

DESIGNER

OWNER

PROJECT

DRAWING

REVISIONS


AVESTA BISHOP STREET, LP
307 CUMBERLAND AVE.,
PORTLAND, MAINE 04101

BISHOP STREET
APARTMENTS
72 BISHOP STREET
PORTLAND, MAINE 04101

FIRST FLOOR
MECHANICAL
DUCTWORK PLAN
CWS PROJECT NUMBER: 14-013

NO.	DATE	DESCRIPTION

DRAWING NUMBER
M1.01
SCALE: AS NOTED
DATE: 01/08/2016
ISSUED FOR BID

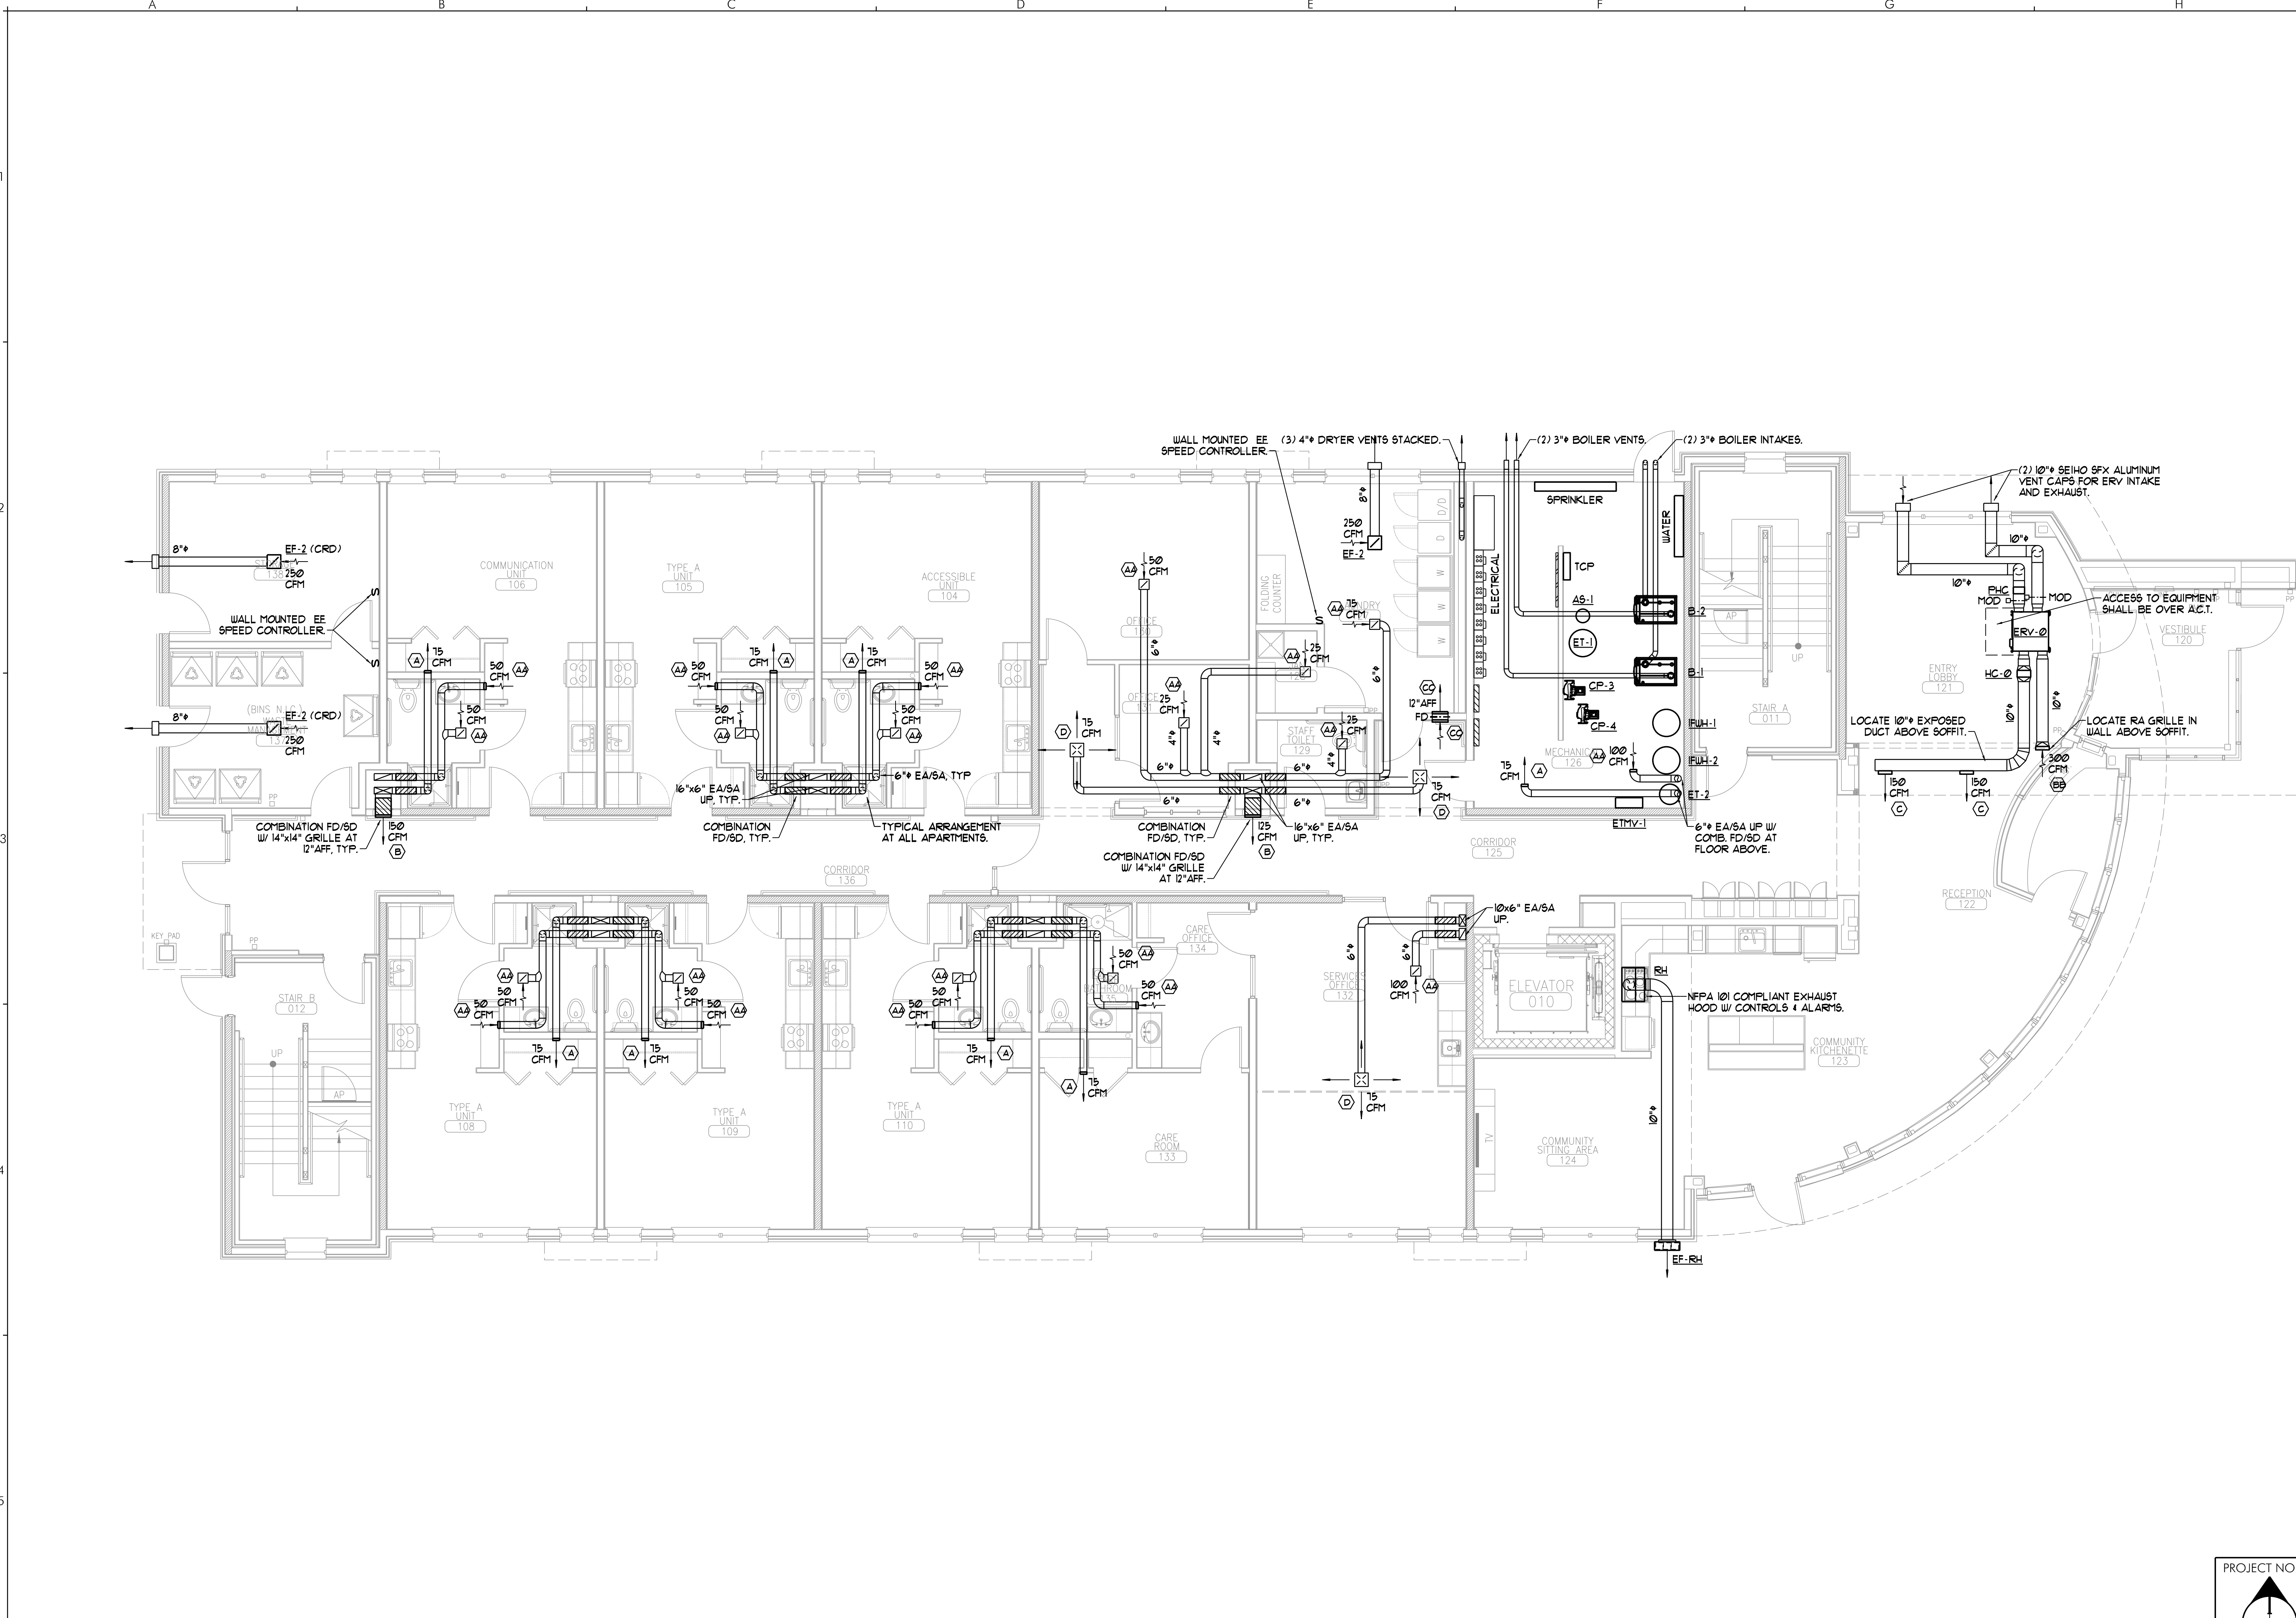

A5 FIRST FLOOR MECHANICAL DUCTWORK PLAN
SCALE: 3/16" = 1'-0"

