


| Calculation Summary | | | | | | | | |
|---------------------|------|------|------|---------|---------|-------|---------|---------|
| Label | Avg | Max | Min | Avg/Min | Max/Min | # Pts | PtSpcLr | PtSpcTb |
| Drive and Parking | 0.97 | 3.7 | 0.1 | 9.70 | 37.00 | 102 | 10 | 10 |
| EAST SIDE | 2.25 | 4.1 | 0.1 | 22.50 | 41.00 | 21 | 10 | 10 |
| Outside Property | N.A. | 0.1 | 0.0 | N.A. | N.A. | 389 | 10 | 10 |
| Property Line | N.A. | 0.2 | 0.0 | N.A. | N.A. | 161 | 7.5 | N.A. |
| SOUTH SIDE | 1.14 | 1.9 | 0.8 | 1.43 | 2.38 | 18 | 10 | 10 |
| WEST side | N.A. | 3.7 | 0.1 | N.A. | N.A. | 22 | 10 | 10 |
| WHOLE SITE | 0.48 | N.A. | N.A. | N.A. | N.A. | 442 | 10 | 10 |

| Luminaire Schedule (note fixture catalogue numbers are not complete) | | | | | | | |
|--|--------|-----|-------------|-------|------------|---|--|
| Type | Symbol | Qty | Lum. Lumens | LLF | Lum. Watts | Description | |
| VS3B | | 2 | 4092 | 0.820 | 70 | VP-S/22NB-70/BLC/4K | |
| A | | 1 | 3558 | 0.820 | 50 | VP-S/22NB-50/BLC/4K | |
| C3 | | 8 | 2744 | 0.520 | 27 | 60% FACTORY DIM 24NB-55-T3-4K | |
| D1 | | 5 | 773 | 0.550 | 14.6 | 50% DIM 1020-B1-10-LRTD4-9014-M2-30KS-80-NCSM | |
| SL1 | | 1 | 66 | 0.900 | 4.4 | MSLHH30K8 WH | |
| B3 | | 3 | 567 | 0.900 | 18.7 | VRB1-15L3K | |

- NOTES:
- 1) EXACT MOUNTING DETAILS TO BE DETERMINED AT JOBSITE BY OTHERS.
 - 2) CALCULATIONS MAY SHOW THE EFFECT OF SHADOWING CAUSED BY BUILDINGS AND OBJECTS WITHIN THE CALCULATED SPACE OR IN THE SITE AREA.
 - 3) READINGS SHOWN ARE INITIAL HORIZONTAL FOOTCANDLES TAKEN AS SHOWN IN CALCULATION SUMMARY UNLESS OTHERWISE INDICATED.
 - 4) THIS CALCULATION IS BASED ON LIMITED INFORMATION SUPPLIED BY OTHERS TO SWANEY LIGHTING ASSOCIATES AND STANDARD ASSUMPTIONS OF THE SPACE AND/OR SITE.
 - 5) CONFORMANCE TO CODES AND OTHER LOCAL REQUIREMENTS AS DETERMINED BY THE AHJ ARE THE RESPONSIBILITY OF THE OWNER AND/OR THE OWNER'S REPRESENTATIVE.
 - 6) THIS LAYOUT DRAWING MUST BE COORDINATED WITH THE SITE LOCATION FOR CORRECT FIXTURE ORIENTATION.
 - 7) CHECK GRAPHIC SCALE. DOCUMENTS PRINTED OR PLOTTED FROM ELECTRONIC FILES MAY OCCUR AT OTHER THAN THE DESIRED OR ASSUMED GRAPHIC SCALES. IT IS THE RESPONSIBILITY OF THE RECIPIENT TO VERIFY THAT THE PRINTED OR PLOTTED-TO-SCALE DRAWING IS PRINTED TO SCALE.

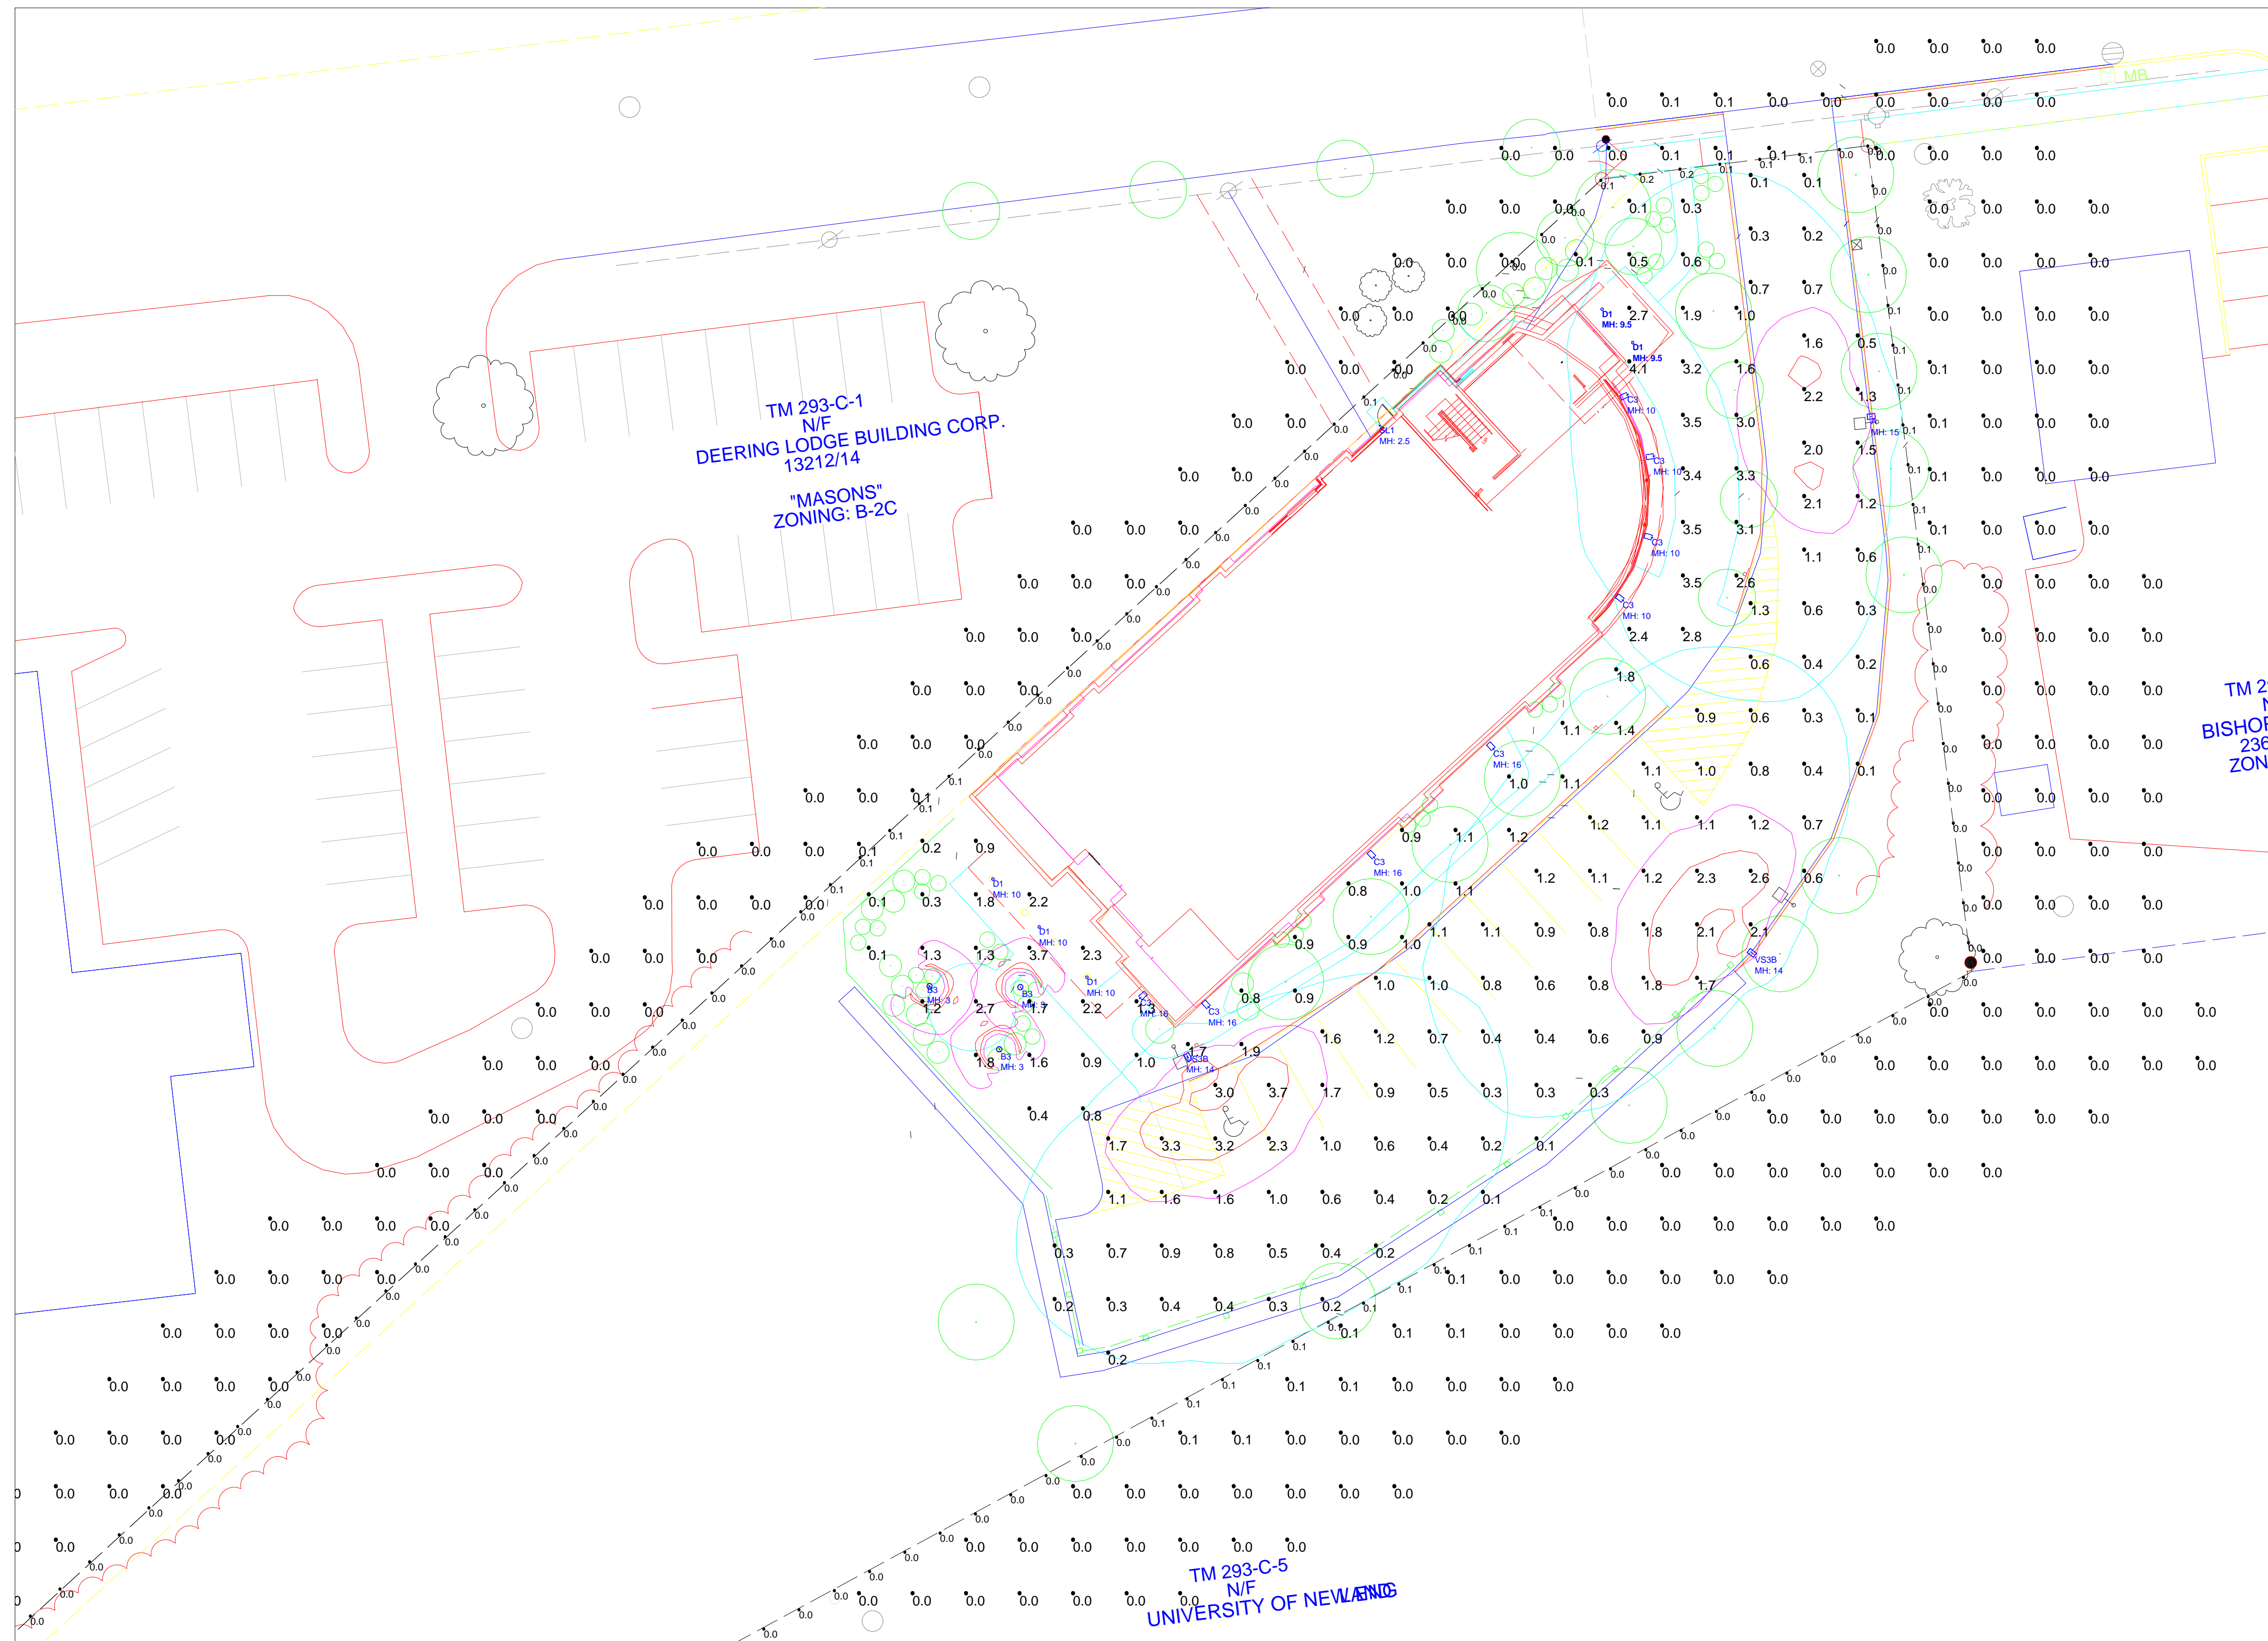

BEACON TRAVERSE



BEACON VIPER



KIM LED BOLLARD

PLAN VIEW

Bishop St site lcy rev 6-5-15.AGI
 GENERATED BY SWANEY LIGHTING, SCARBOROUGH ME - 207-883-7100 - swaneylighting.com
 TITLE: BISHOP STREET PORTLAND, ME LIGHTING LAYOUT
 ARCHITECT/FIRM: MITCHELL & ASSOCIATES
 SCALE: NOT TO SCALE
 Date: 6/29/2015
 Page 1 of 1
 SWANEY LIGHTING ASSOCIATES, INC.

 NOTICE: THIS DRAWING IS THE EXCLUSIVE PROPERTY OF SWANEY LIGHTING ASSOCIATES. INFORMATION CONCERNING THE OPERATION OF UNITS INDICATED, THIS DRAWING IS TO BE USED FOR NO OTHER PURPOSE OTHER THAN AS DETAILED AS EXPRESSLY AUTHORIZED BY SWANEY LIGHTING ASSOCIATES. NO PART OF THIS DRAWING IS TO BE REPRODUCED OR COPIED, EITHER IN WHOLE OR IN PART, WITHOUT THE WRITTEN PERMISSION OF SWANEY LIGHTING ASSOCIATES. ANY VARIATION IN FIXTURE PERFORMANCE FROM PERFORMANCE SHOWN IN FILES IS NOT THE RESPONSIBILITY OF THE MANUFACTURER. ITS USE FOR ANY OTHER PURPOSE IS NOT AUTHORIZED BY SWANEY LIGHTING ASSOCIATES.