



NO.	DESCRIPTION

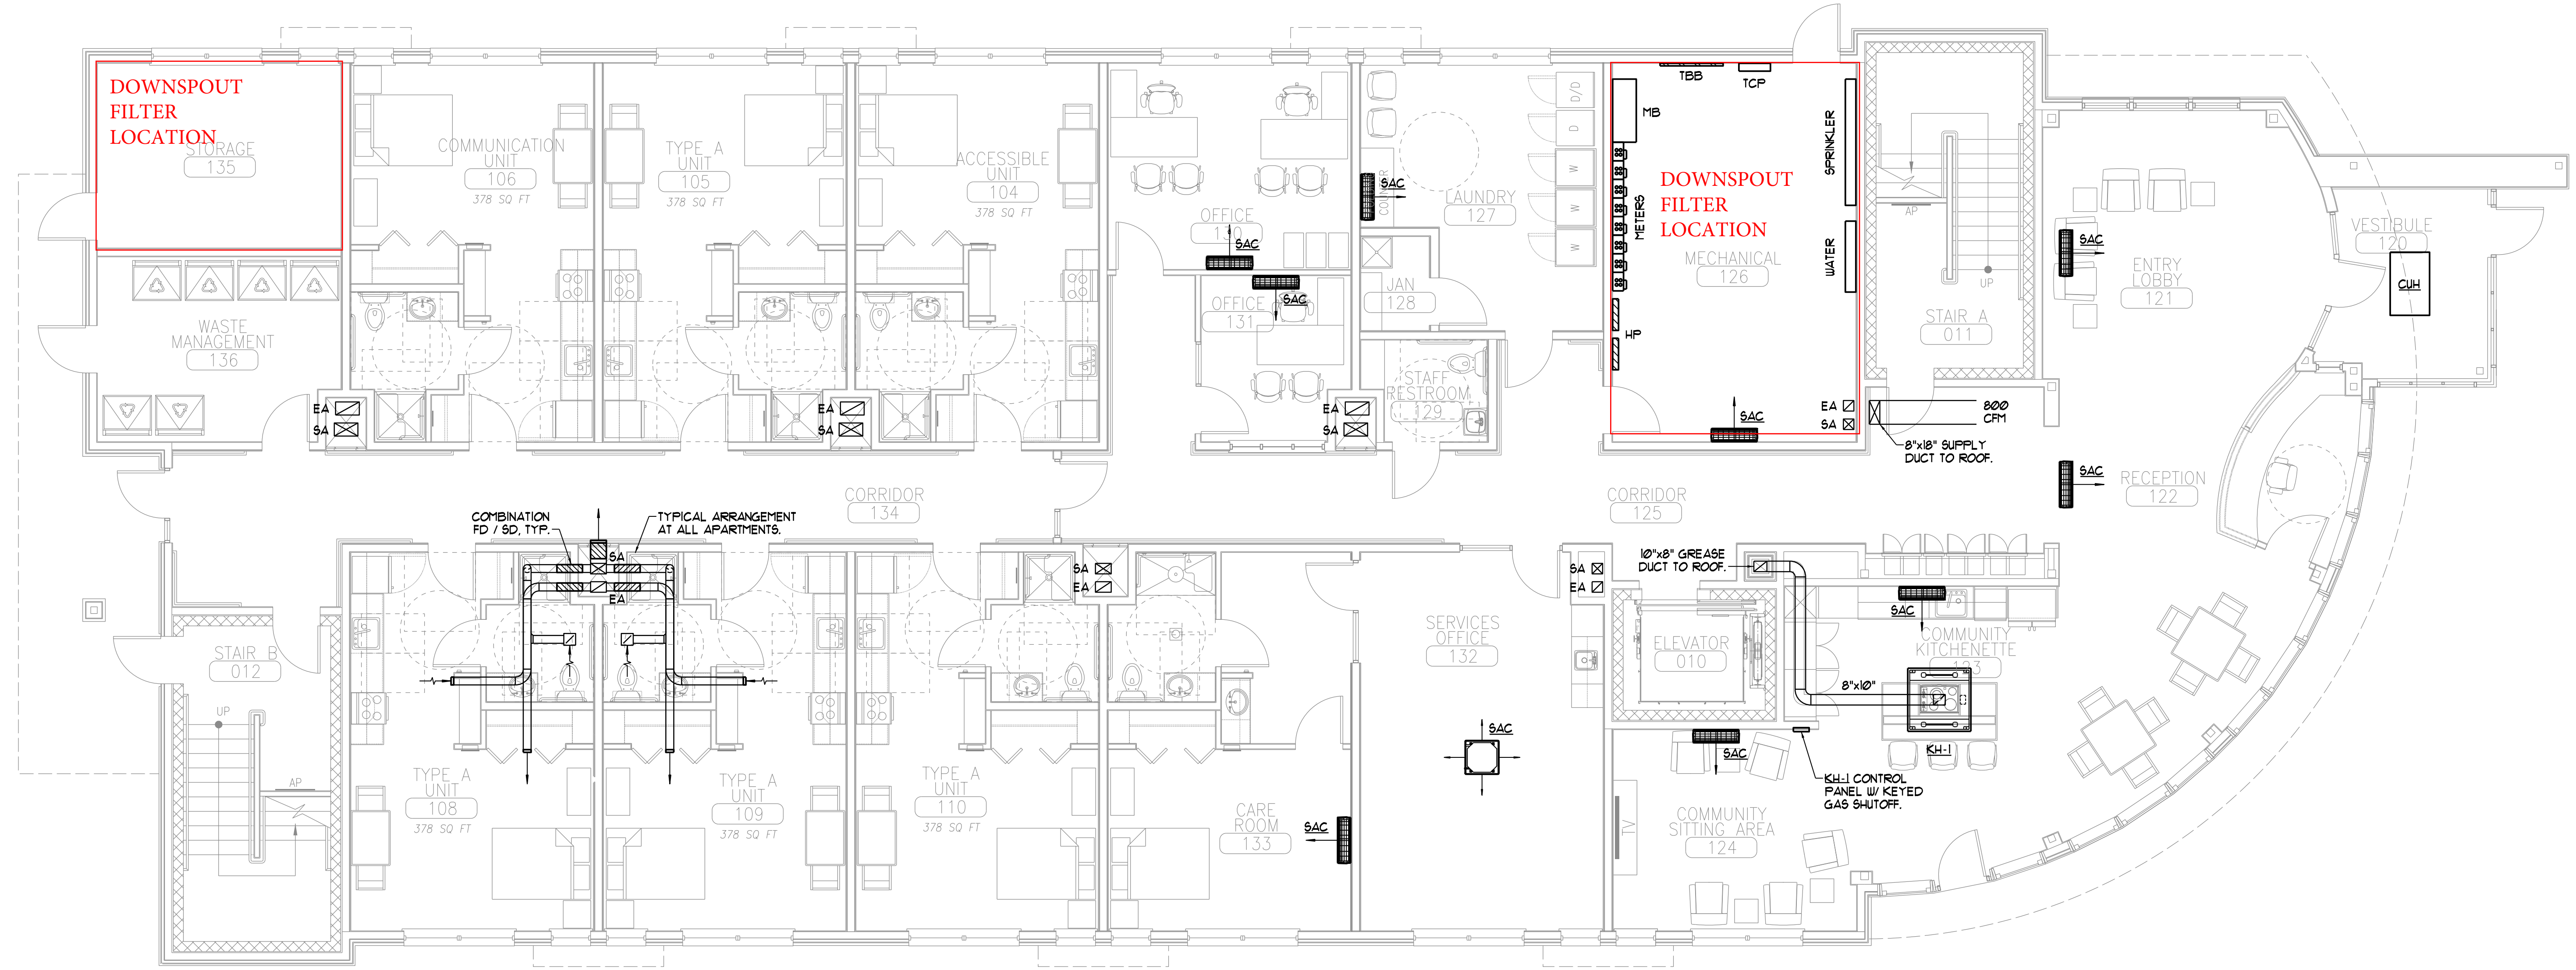

A5 FIRST FLOOR MECHANICAL PLAN
SCALE: 3/16" = 1'-0"

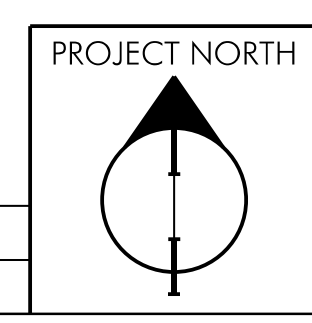

©2015 CWS Architects, Inc. All Rights Reserved. No part of this drawing may be reproduced without the written permission of CWS Architects, Inc.