




2 PIER DETAIL
 SK-001 SCALE: 1" = 1'-0"

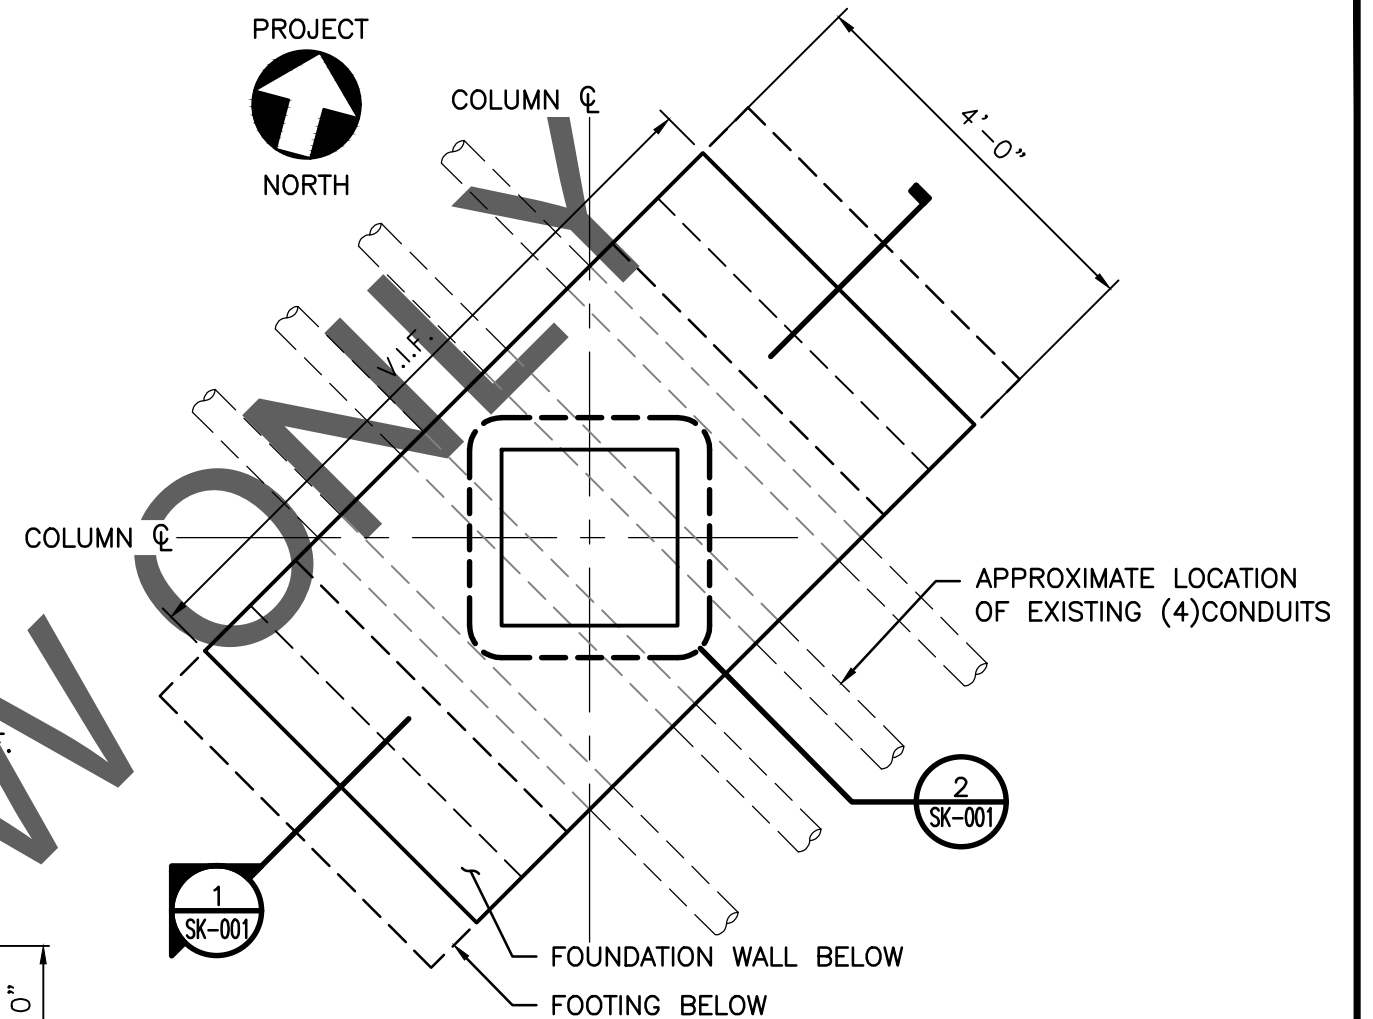

1 SK-001
2 SK-001
 FOUNDATION PLAN
 SCALE: 1/2" = 1'-0"

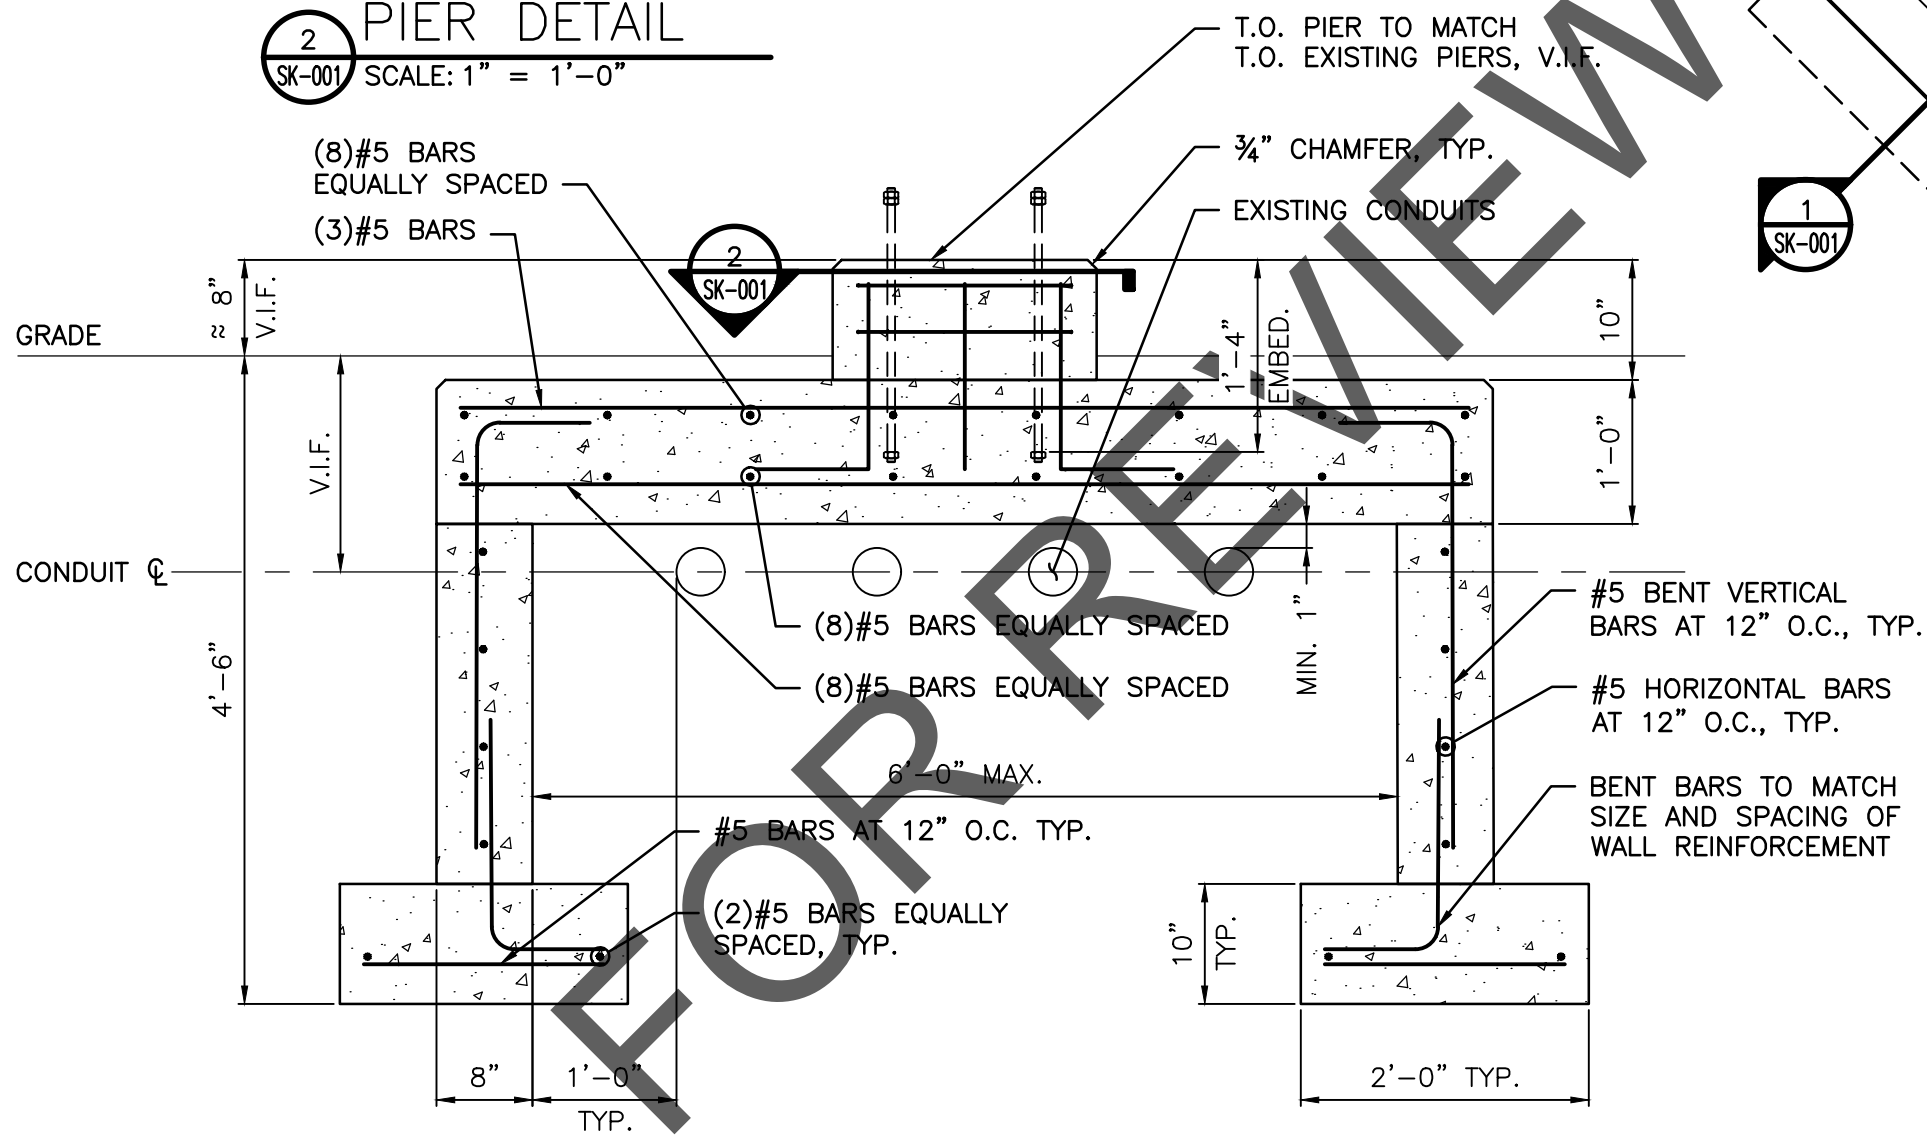

1 SK-001 FOUNDATION SECTION
 SCALE: 3/4" = 1'-0"

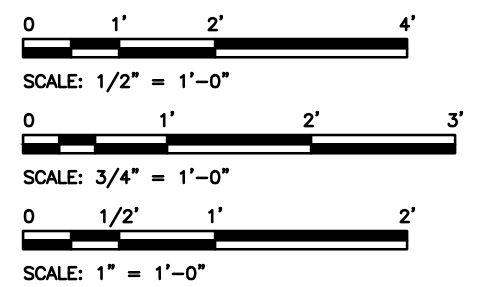

				SGC ENGINEERING, LLC WESTBROOK, ME			
				BISHOP STREET S/S PORTLAND, ME			
A ISSUED FOR CLIENT REVIEW				AKG	BJB	BJB	12.07.16
REV	DESCRIPTION	DWN BY	CKD BY	APP BY	DATE	FOUNDATION DETAILS	
PLEASE NOTE: THIS DOCUMENT MAY NOT ACCURATELY REPRESENT THE FINAL DOCUMENT. ONLY AN ENGINEER, ARCHITECT OR SURVEYOR SIGNED, SEALED AND DATED PAPER COPY PROVIDED BY THIS OFFICE, MAY BE UTILIZED FOR BIDDING OR CONSTRUCTION PURPOSES.				Colby Company engineering		47A York Street Portland, Maine 04101 207.553.7753 colbycoengineering.com	SIZE: AS NOTED DATE: 12.07.2016 DES BY: AKG DWN BY: AKG CKD BY: BJB
				PROJECT NO.	DRAWING NO.		
				106.017.002	SK-001		
				SHEET	1 OF 1		