

AIR DEVICE SCHEDULE

TAG	SIZE	MAX CFM	MAX INCH	THROW	REMARKS
CD-1	6"	96-127	CD-13	1-3-4	SQUARE CONE DIFFUSER T-SIDE LAV-2H
CD-2	6"	175-279	CD-13	R-2-6	SQUARE CONE DIFFUSER T-SIDE LAV-2H
CD-3	12"	273-435	CD-21	3-2-8	SQUARE CONE DIFFUSER T-SIDE LAV-2H
CD-4	12"	370-458	CD-24	3-2-10	SQUARE CONE DIFFUSER T-SIDE LAV-2H
NG	8" X 8"	---	---	---	SEPARATE RETURN GRILLE T-SIDE LAV-2H
NG	8" X 12"	---	---	---	SEPARATE RETURN GRILLE T-SIDE LAV-2H

EXHAUST FAN SCHEDULE

TAG	AREA SERVED	CFM	MANUFACTURER	MODEL NUMBER	ELECTRIC VOLTAGE	AMPS	ROOF	REMARKS
DF-1	HOT ROOM	150	---	EC-148	120 / 1	0.5	25 LBS	CEILING MOUNT
DF-2	WREST ROOM	100	---	EC-204	120 / 1	0.8	30 LBS	CEILING MOUNT

AIR HANDLING UNIT SCHEDULE

TAG	AREA SERVED	COILS	HEATING	MANUFACTURER	MODEL NUMBER	ELECTRIC VOLTAGE	AMPS	ROOF	REMARKS
AHU-1	BAR AREA	---	---	CARRIER	---	---	---	---	1
AHU-2	BARCE FLOOR	---	---	CARRIER	---	---	---	---	1
AHU-3	BAR AREA / BARCE FLOOR	---	400	REXELER	REFL-400	120 / 1	---	---	2


REMARKS: 1. EXISTING UNITS TO BE REUSED



AIRTEMP MECHANICAL CONTRACTORS

11 WALLACE AVENUE

SOUTH PORTLAND, MAINE 04106

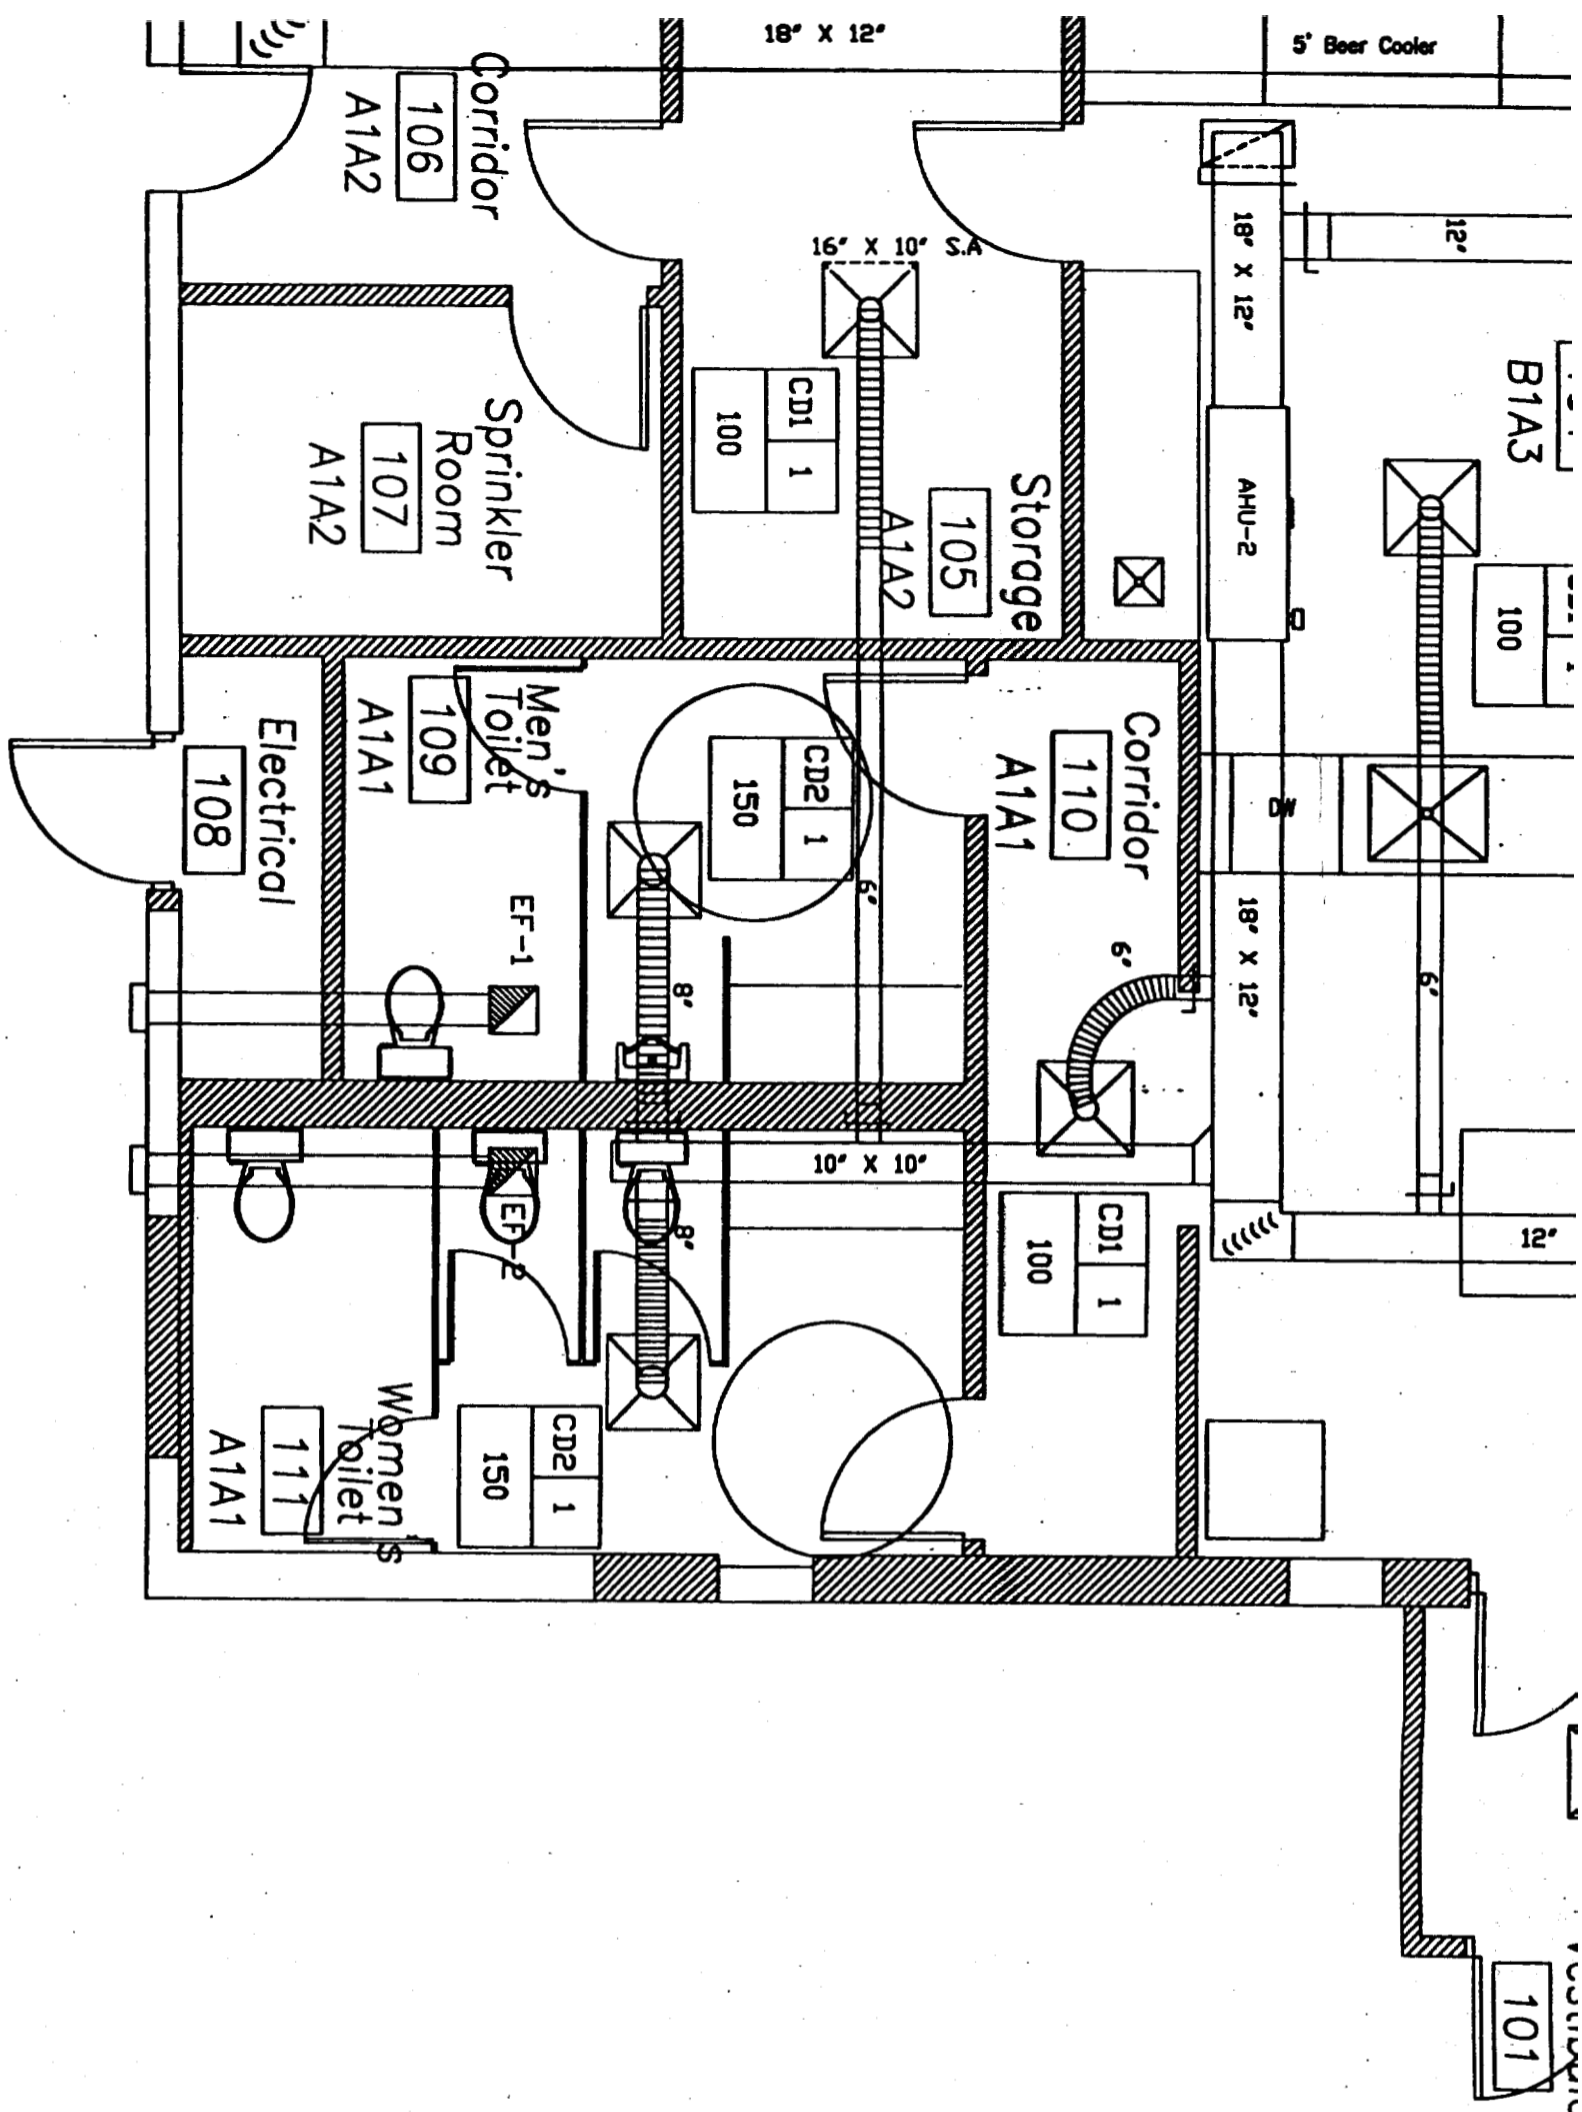


AUSTIN'S BOOT'S & BUCKLE'S
188 WARREN AVE.
PORTLAND, MAINE

CLIENT _____
 DATE _____
 DRAWN BY BPL
 CHECKED BY _____
 DATE JAN 21, 2008
 SHEET TITLE
MECHANICAL FLOOR PLAN

SCALE
1/4" = 1'

M-1

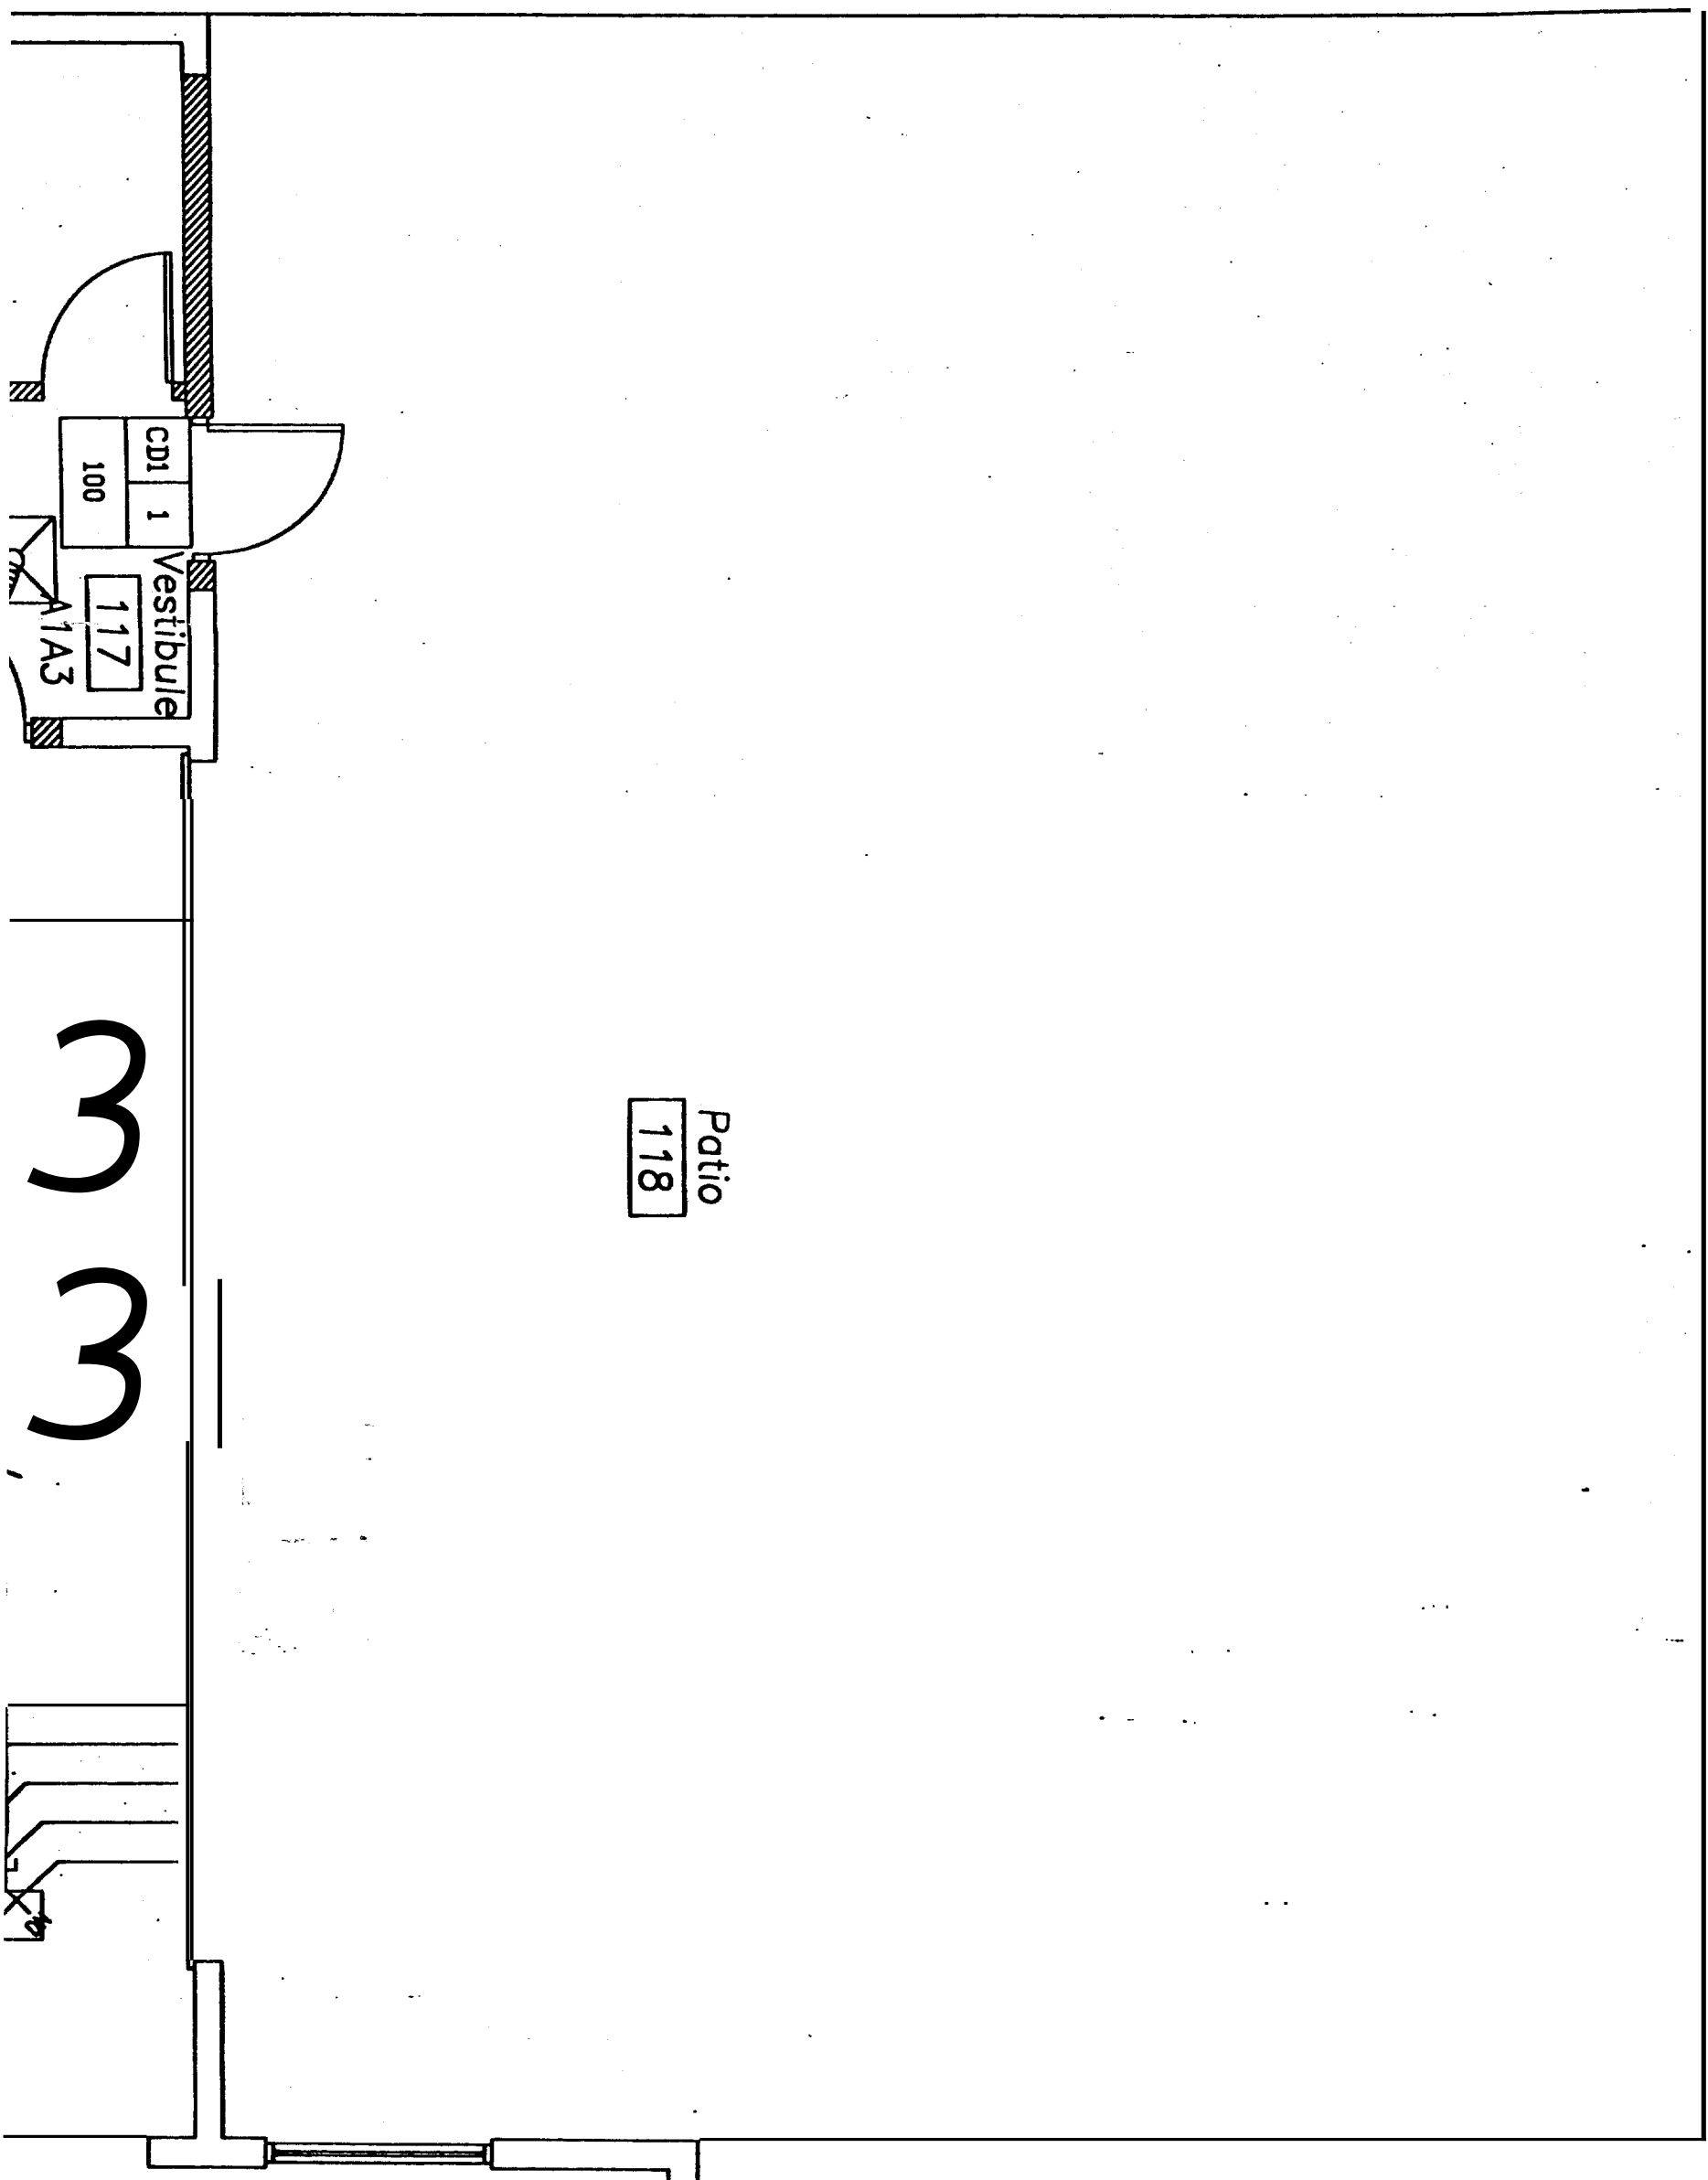

Patio
118

33

