


GENERAL NOTES

UNDERGROUND ROUGH IN ONLY FOR FUTURE BATHROOMS
REFER TO SITE PLAN FOR TRENCH AND SAND/OIL INTERCEPTOR PIPING

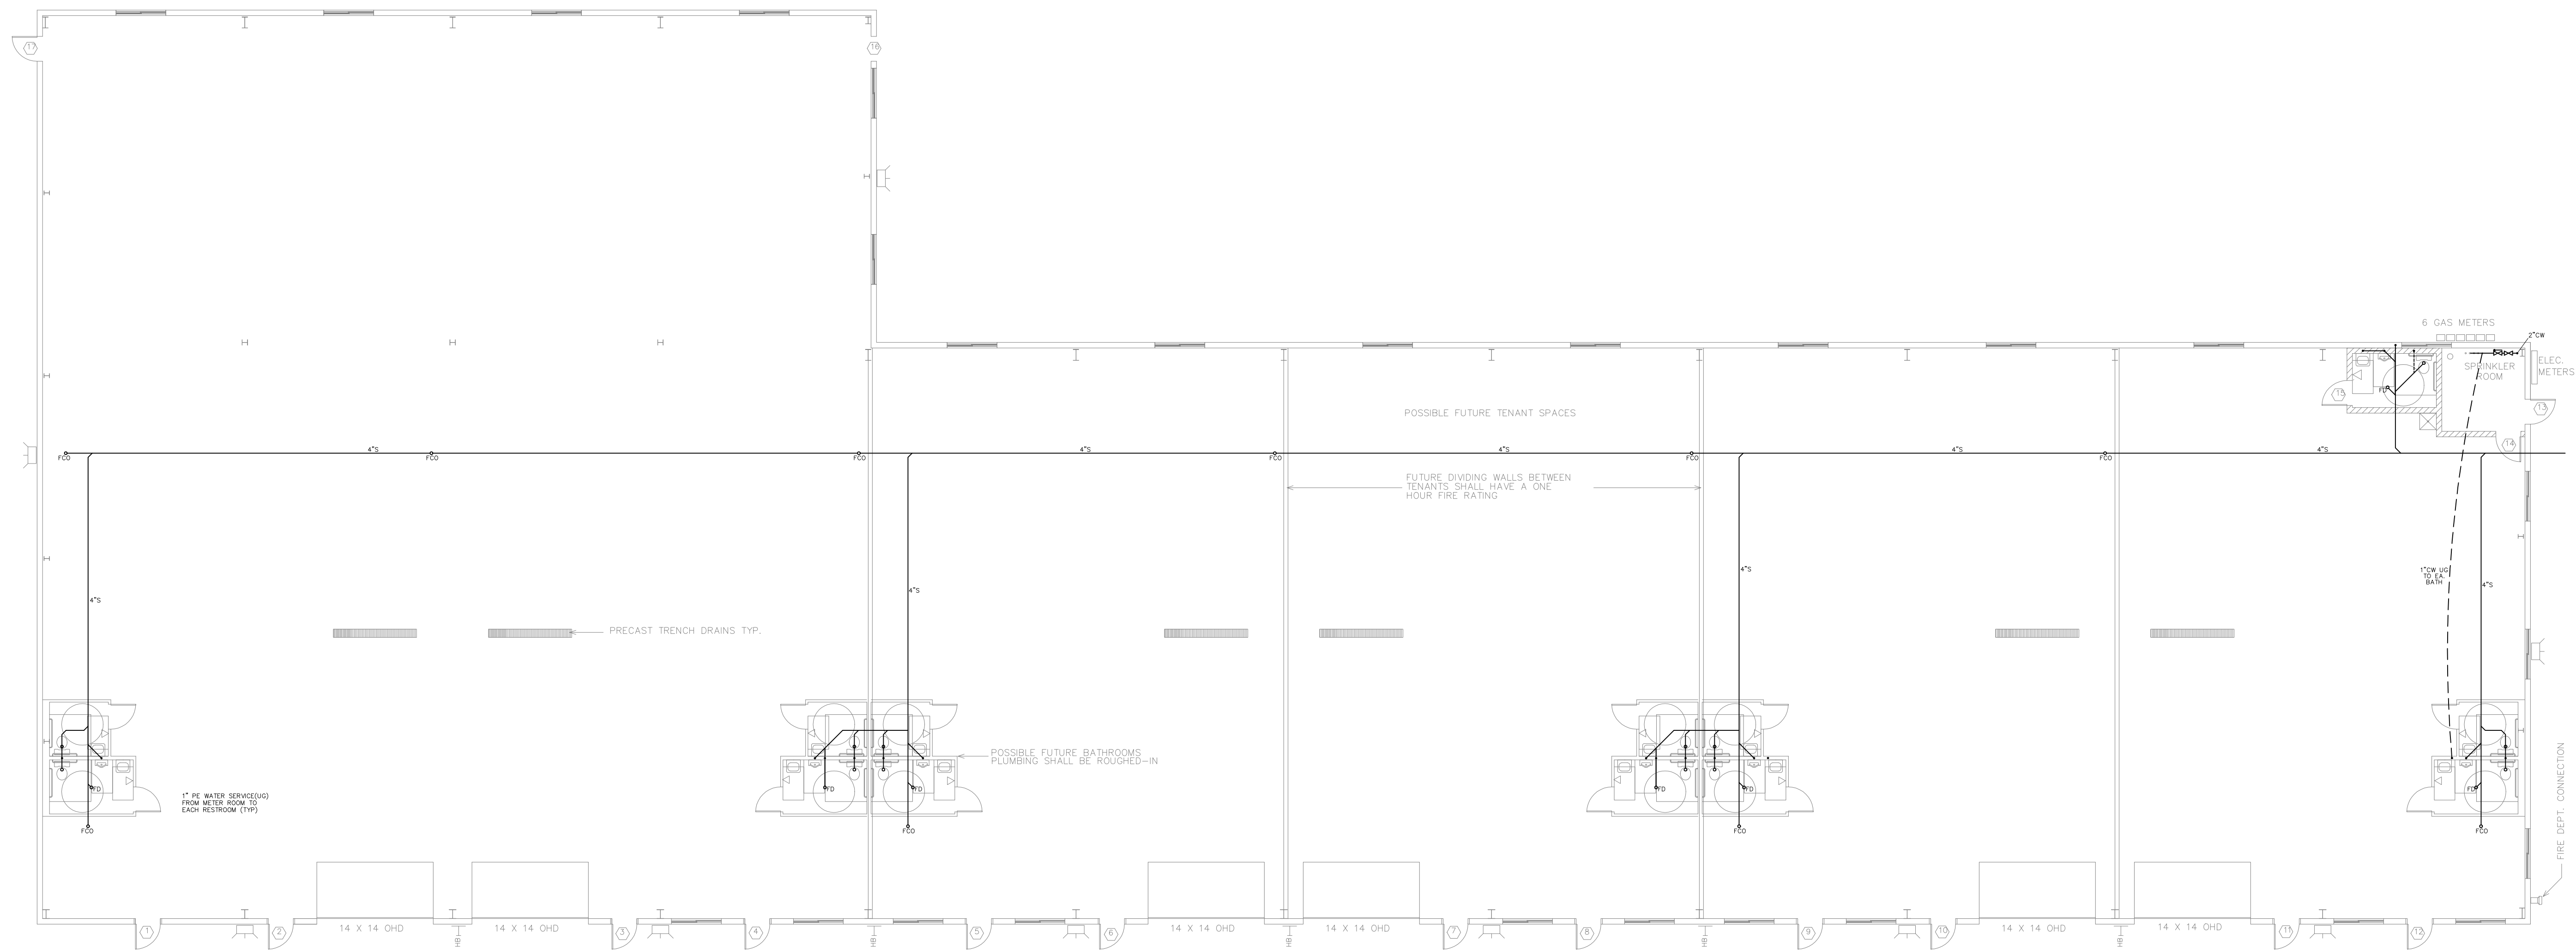


PLUMBING PLAN
SCALE: 3/32" = 1'-0"

01 ISSUED FOR PERMIT 07-30-14

AirTemp, Inc.
11 Wallace Ave
South Portland, Maine



BISKUP CONSTRUCTION, INC.
16 DANIELLE DRIVE
WINDHAM, MAINE 04092
TEL: (207) 892-9890
FAX: (207) 892-9895
WWW.BISKUPCONSTRUCTION.COM

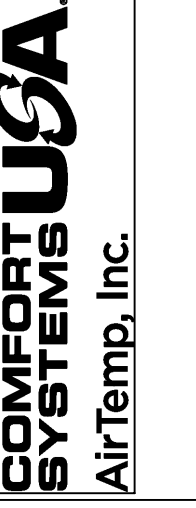

P.H. WARREN AVE LLC
421 WARREN AVE
PORTLAND, MAINE

CLIENT: BRL
DATE:
DRWN BY:
CHKD BY:
DATE: JULY 30, 2014

SHEET TITLE: PLUMBING PLAN

SCALE: 3/32" = 1'

DRAWING: P-1