


1 FLOOR PLAN
SCALE - 3/32"=1'-0"

- KEYED NOTES - GENERAL**
(THESE NOTES ARE SPECIFIC TO THIS SHEET ONLY)
- ① LOCATION OF L-SHAPED MODULAR WORK STATION PROVIDED AND SET IN PLACE BY SAFELITE. SEE DETAIL 2/A-5 FOR PLAN VIEW DIMENSIONS.
 - ② PROVIDE NEW PRE-MANUFACTURED BOLT-DOWN BOLLARDS WHERE SHOWN. SEE DETAIL 2/A-1.1.
 - ③ PROVIDE AND INSTALL A CONCRETE PAD FOR EMERGENCY GENERATOR AS SHOWN. VERIFY WITH SAFELITE AND CONSTRUCTION MANAGEMENT THE SIZE AND LOCATION OF CONCRETE PAD AS REQUIRED. THE PAD IS TO BE 6" THICK 3000# CONC. WITH #4 REBAR @ 12" O.C., E.W.
 - ④ PROVIDE AND INSTALL A CONCRETE PAD FOR RTU-1 UNIT AS SHOWN. VERIFY WITH SAFELITE AND CONSTRUCTION MANAGEMENT THE SIZE AND LOCATION OF CONCRETE PAD AS REQUIRED. THE PAD IS TO BE 6" THICK 3000# CONC. WITH #4 REBAR @ 12" O.C., E.W.

Floor Plan Key	
	EXISTING WALLS TO REMAIN
	NEW FRAMED PARTITION WALLS
	NEW 1-HR RATED FRAME WALL FLOOR TO DECK
	EXISTING DOORS TO REMAIN
	NEW DOORS TO PROVIDE AND INSTALL

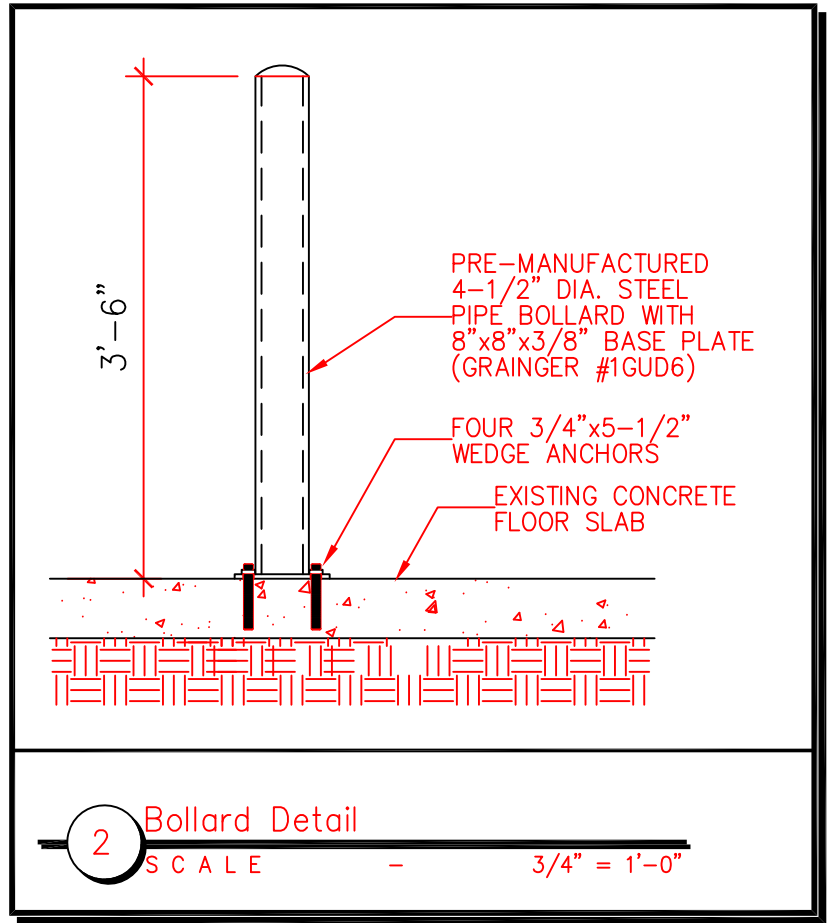

DISCLAIMER:
Drawings A-0.0, A-1-1, A-1.2, A-2.0, A-3.1, A-3.2, A-4.0, A-5.0, A-6.0, A-7.0 were drawn by Safelite AutoGlass. The original date of these drawings (Rev.) is 03/28/16. The Sheridan Corporation replaced Safelite's title with theirs and all revisions since Rev. 1 are by Sheridan's designers. All revisions/changes by Sheridan are noted in the applicable drawing(s) revision block.

DATE	REVISION
3/21/16	City change (Safelite)
4/22/16	Sheridan title block added & egress added
5/5/16	DWG note & HVAC pad & note 4 added

DRAWING STATUS		ENGINEERING DESIGNS FOR		JOB NO.	
EST. NO.		Safelite AutoGlass		16-1003	
SIZE		421 Warren Avenue		ENGINEERING	
TYPE		Portland, Maine		DWG. NO.	
DRAWN BY	RAJP	TITLE		A-1.1	
REVIEWED BY	DS	Floor Plan & Details			
SCALE	AS NOTED	DESIGN BUILDER			
DATE	04/22/2016				

