

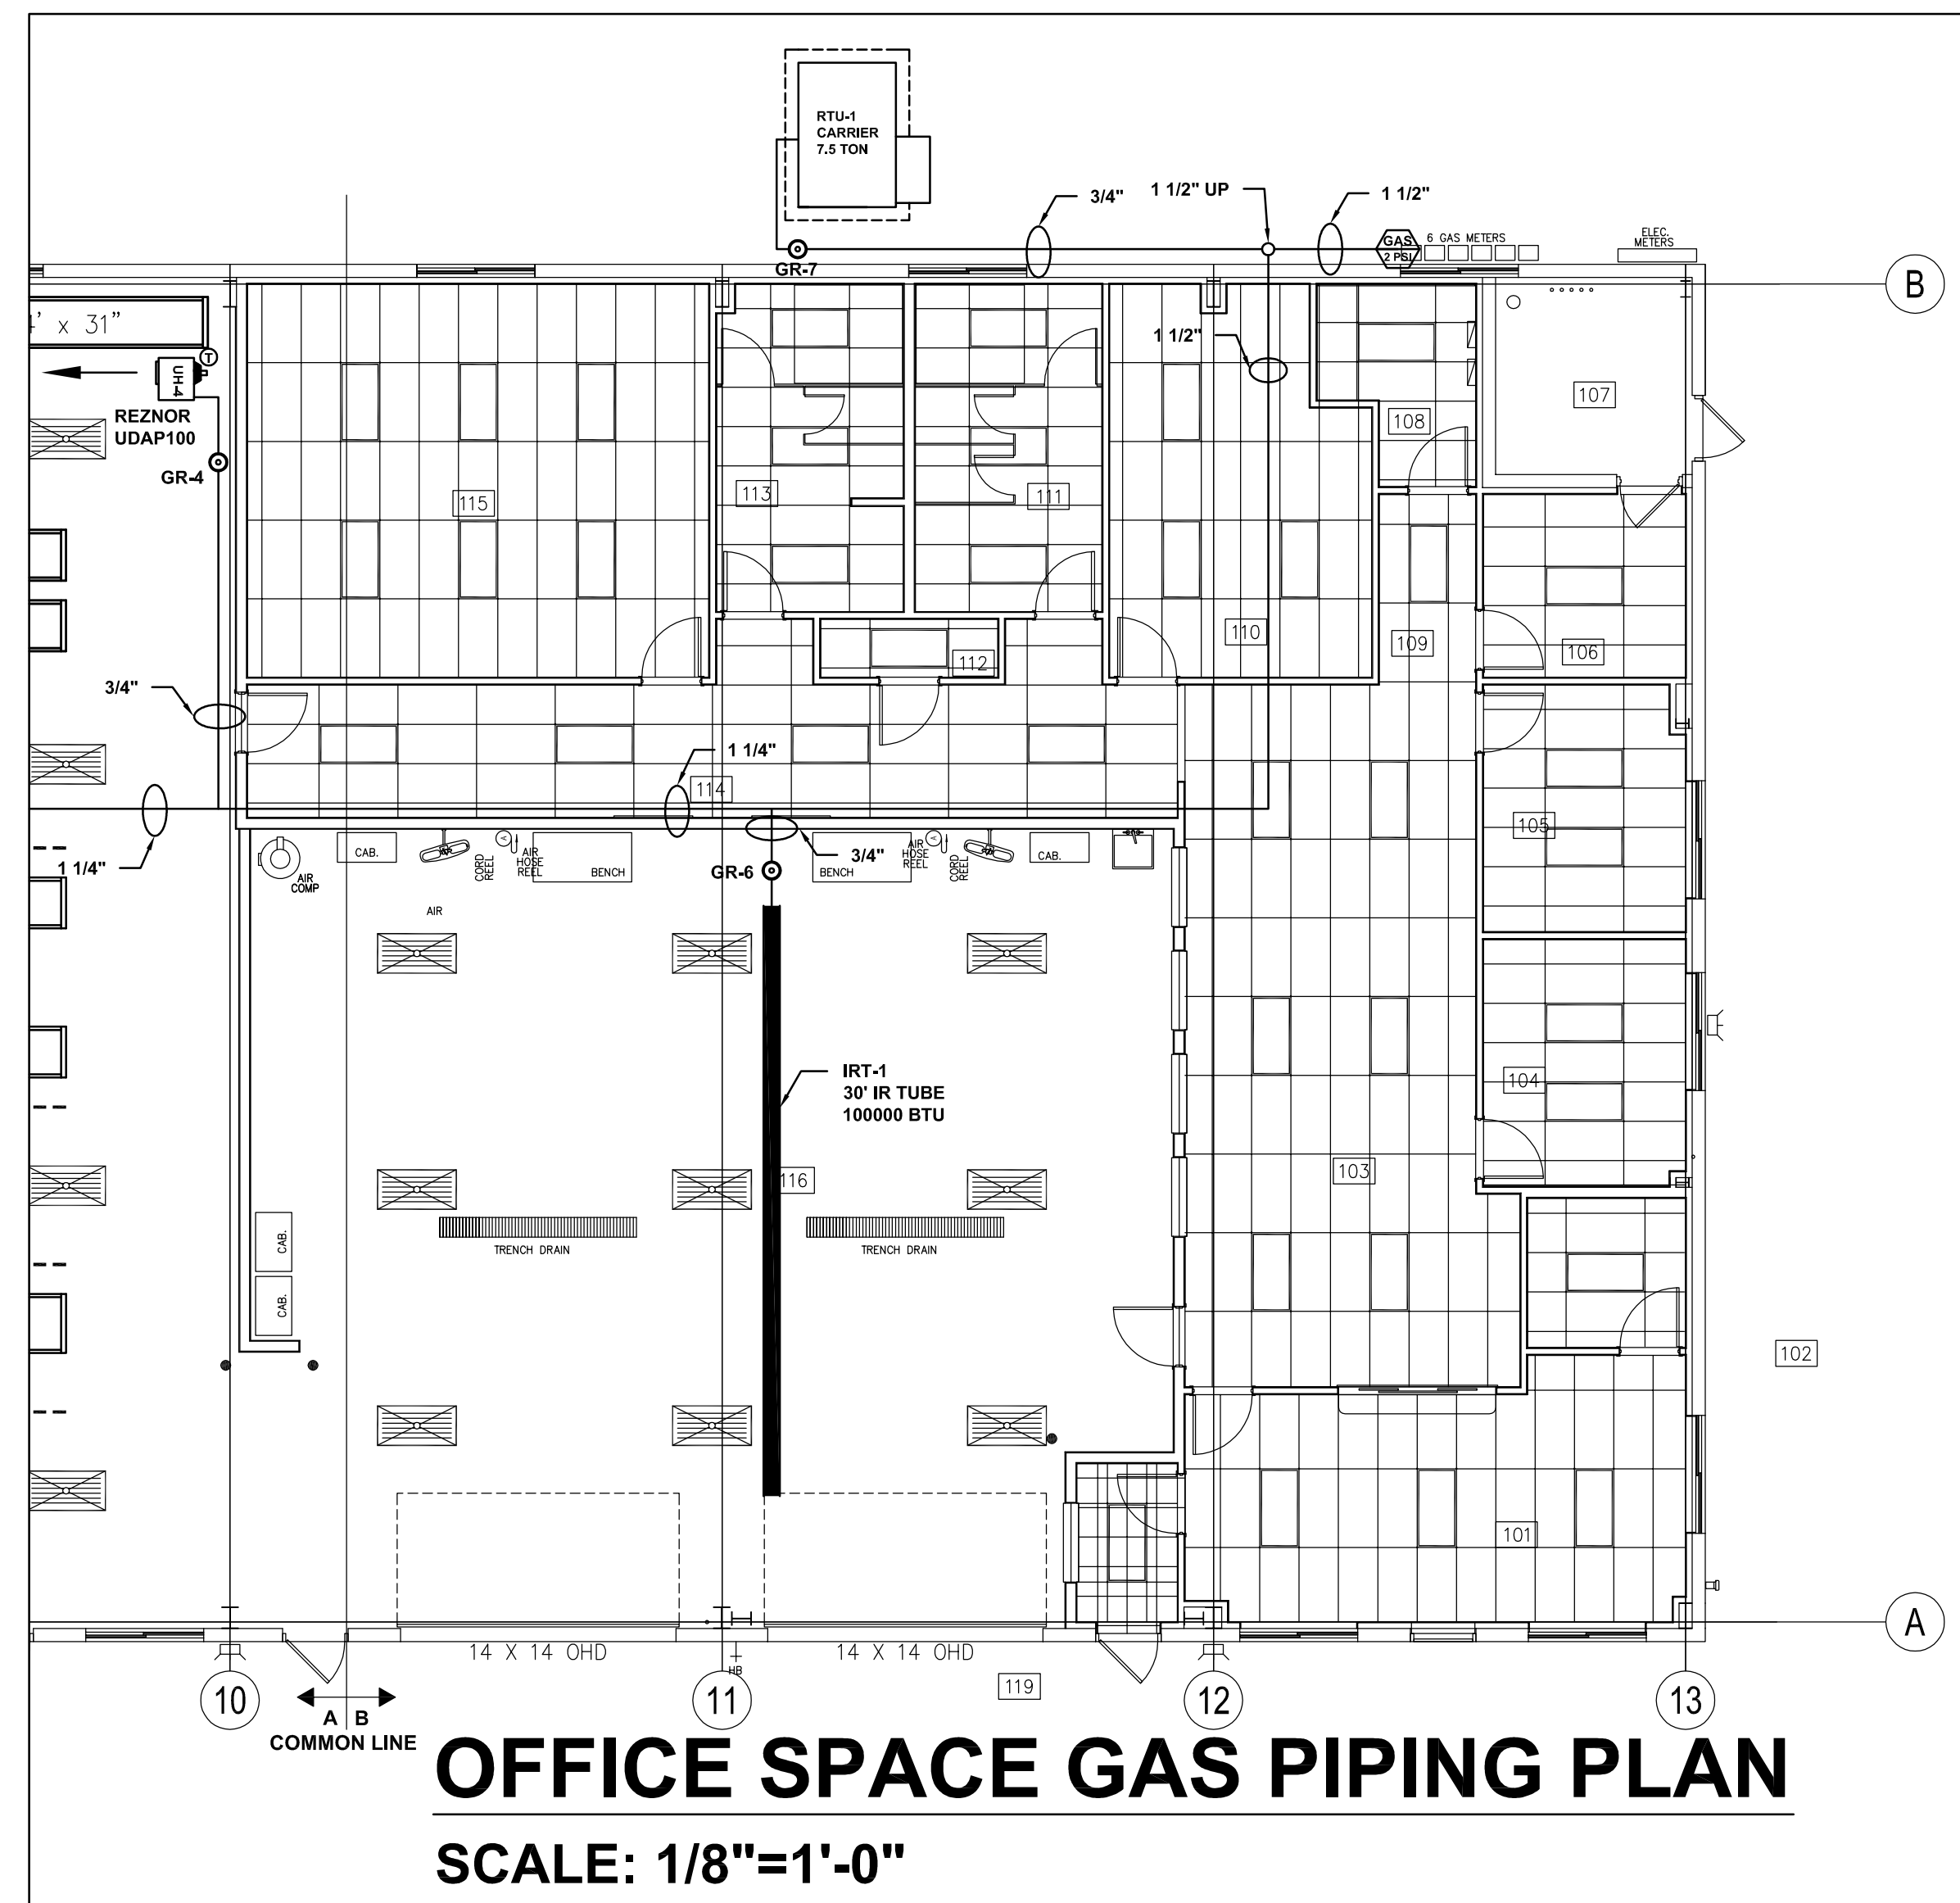


THESE DRAWINGS AND PLANS ARE THE PROPERTY OF WH DEMMONS INC. AND ARE AN INSTRUMENT OF SERVICE FOR THE OWNER'S USE FOR THIS PROJECT ON THIS SITE ONLY

**GAS PIPING PLAN**  
SCALE: 3/32"=1'-0"

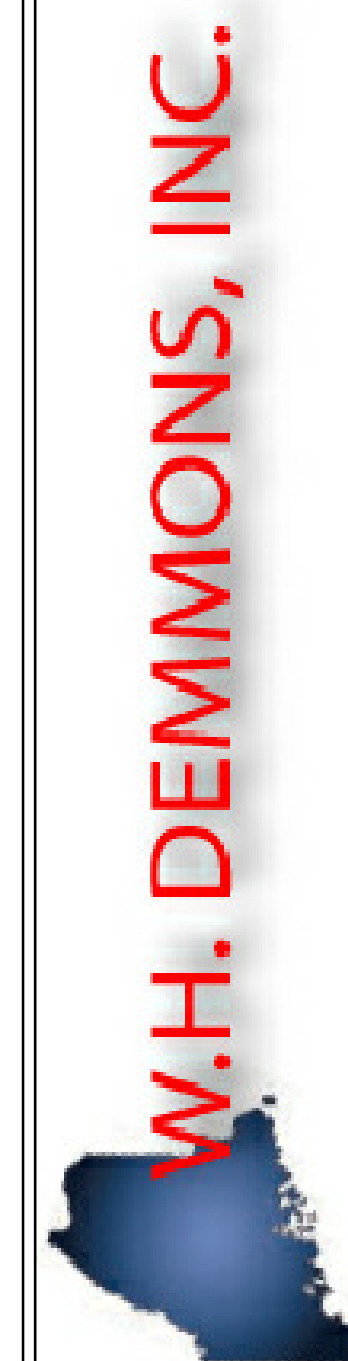


**OFFICE SPACE GAS PIPING PLAN**  
SCALE: 1/8"=1'-0"

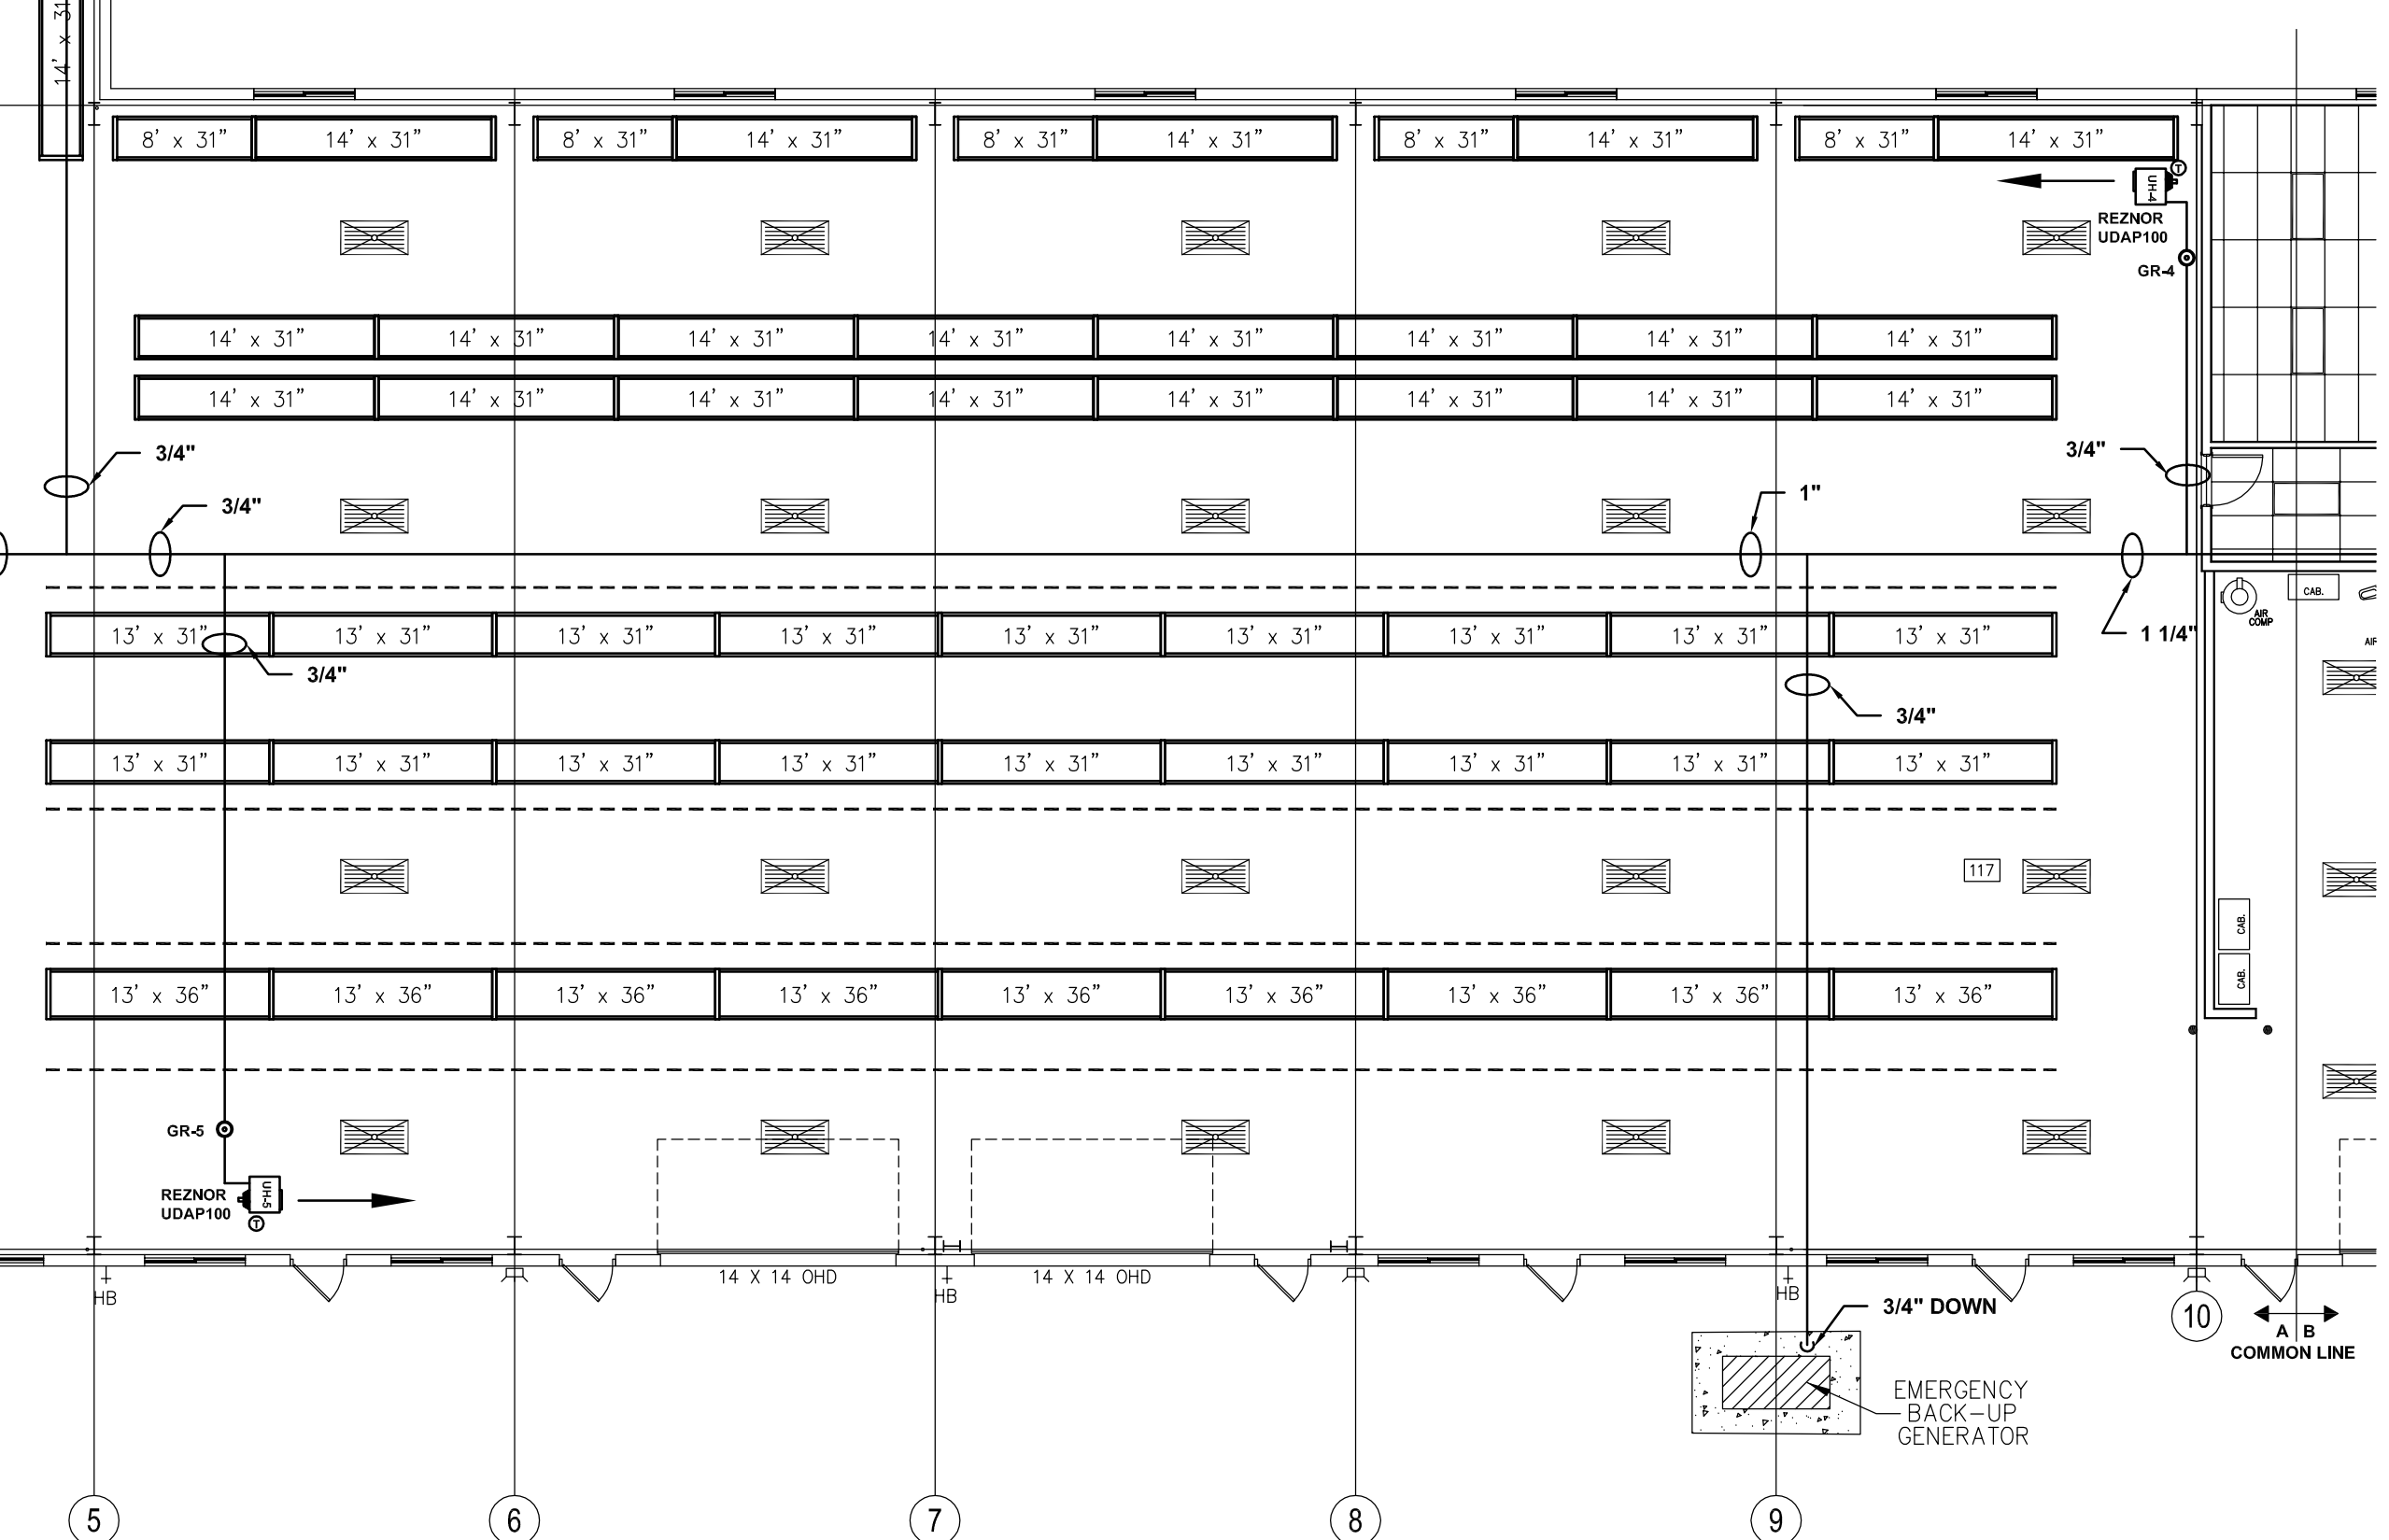

**W.H. DEMMONS, INC.**

www.whdemmons.com 93 Warren Ave., Portland, ME 04103  
T:(207)797-7468 F:(207)878-3015

DESIGN CONSULTANTS

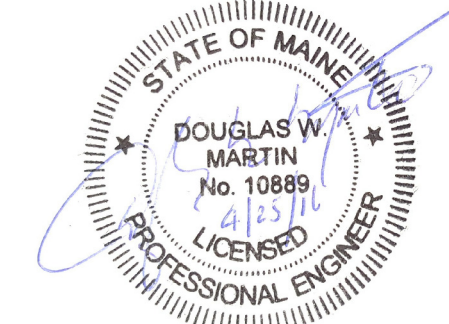

PERMIT SET

This drawing is not intended, nor shall be used for, construction, unless the signed professional seal of a Registered Engineer or Consultant of W.H. Demmons Inc. is affixed.

REVISIONS

SAFELITE AUTOGLASS

421 WARREN AVENUE  
PORTLAND, ME

**GAS PIPING PLAN**

Date: 4.25.16  
Project #: 61257  
Scale: AS NOTED  
Drawn by: MGR/ASG  
Checked by: DWM

**M-2**