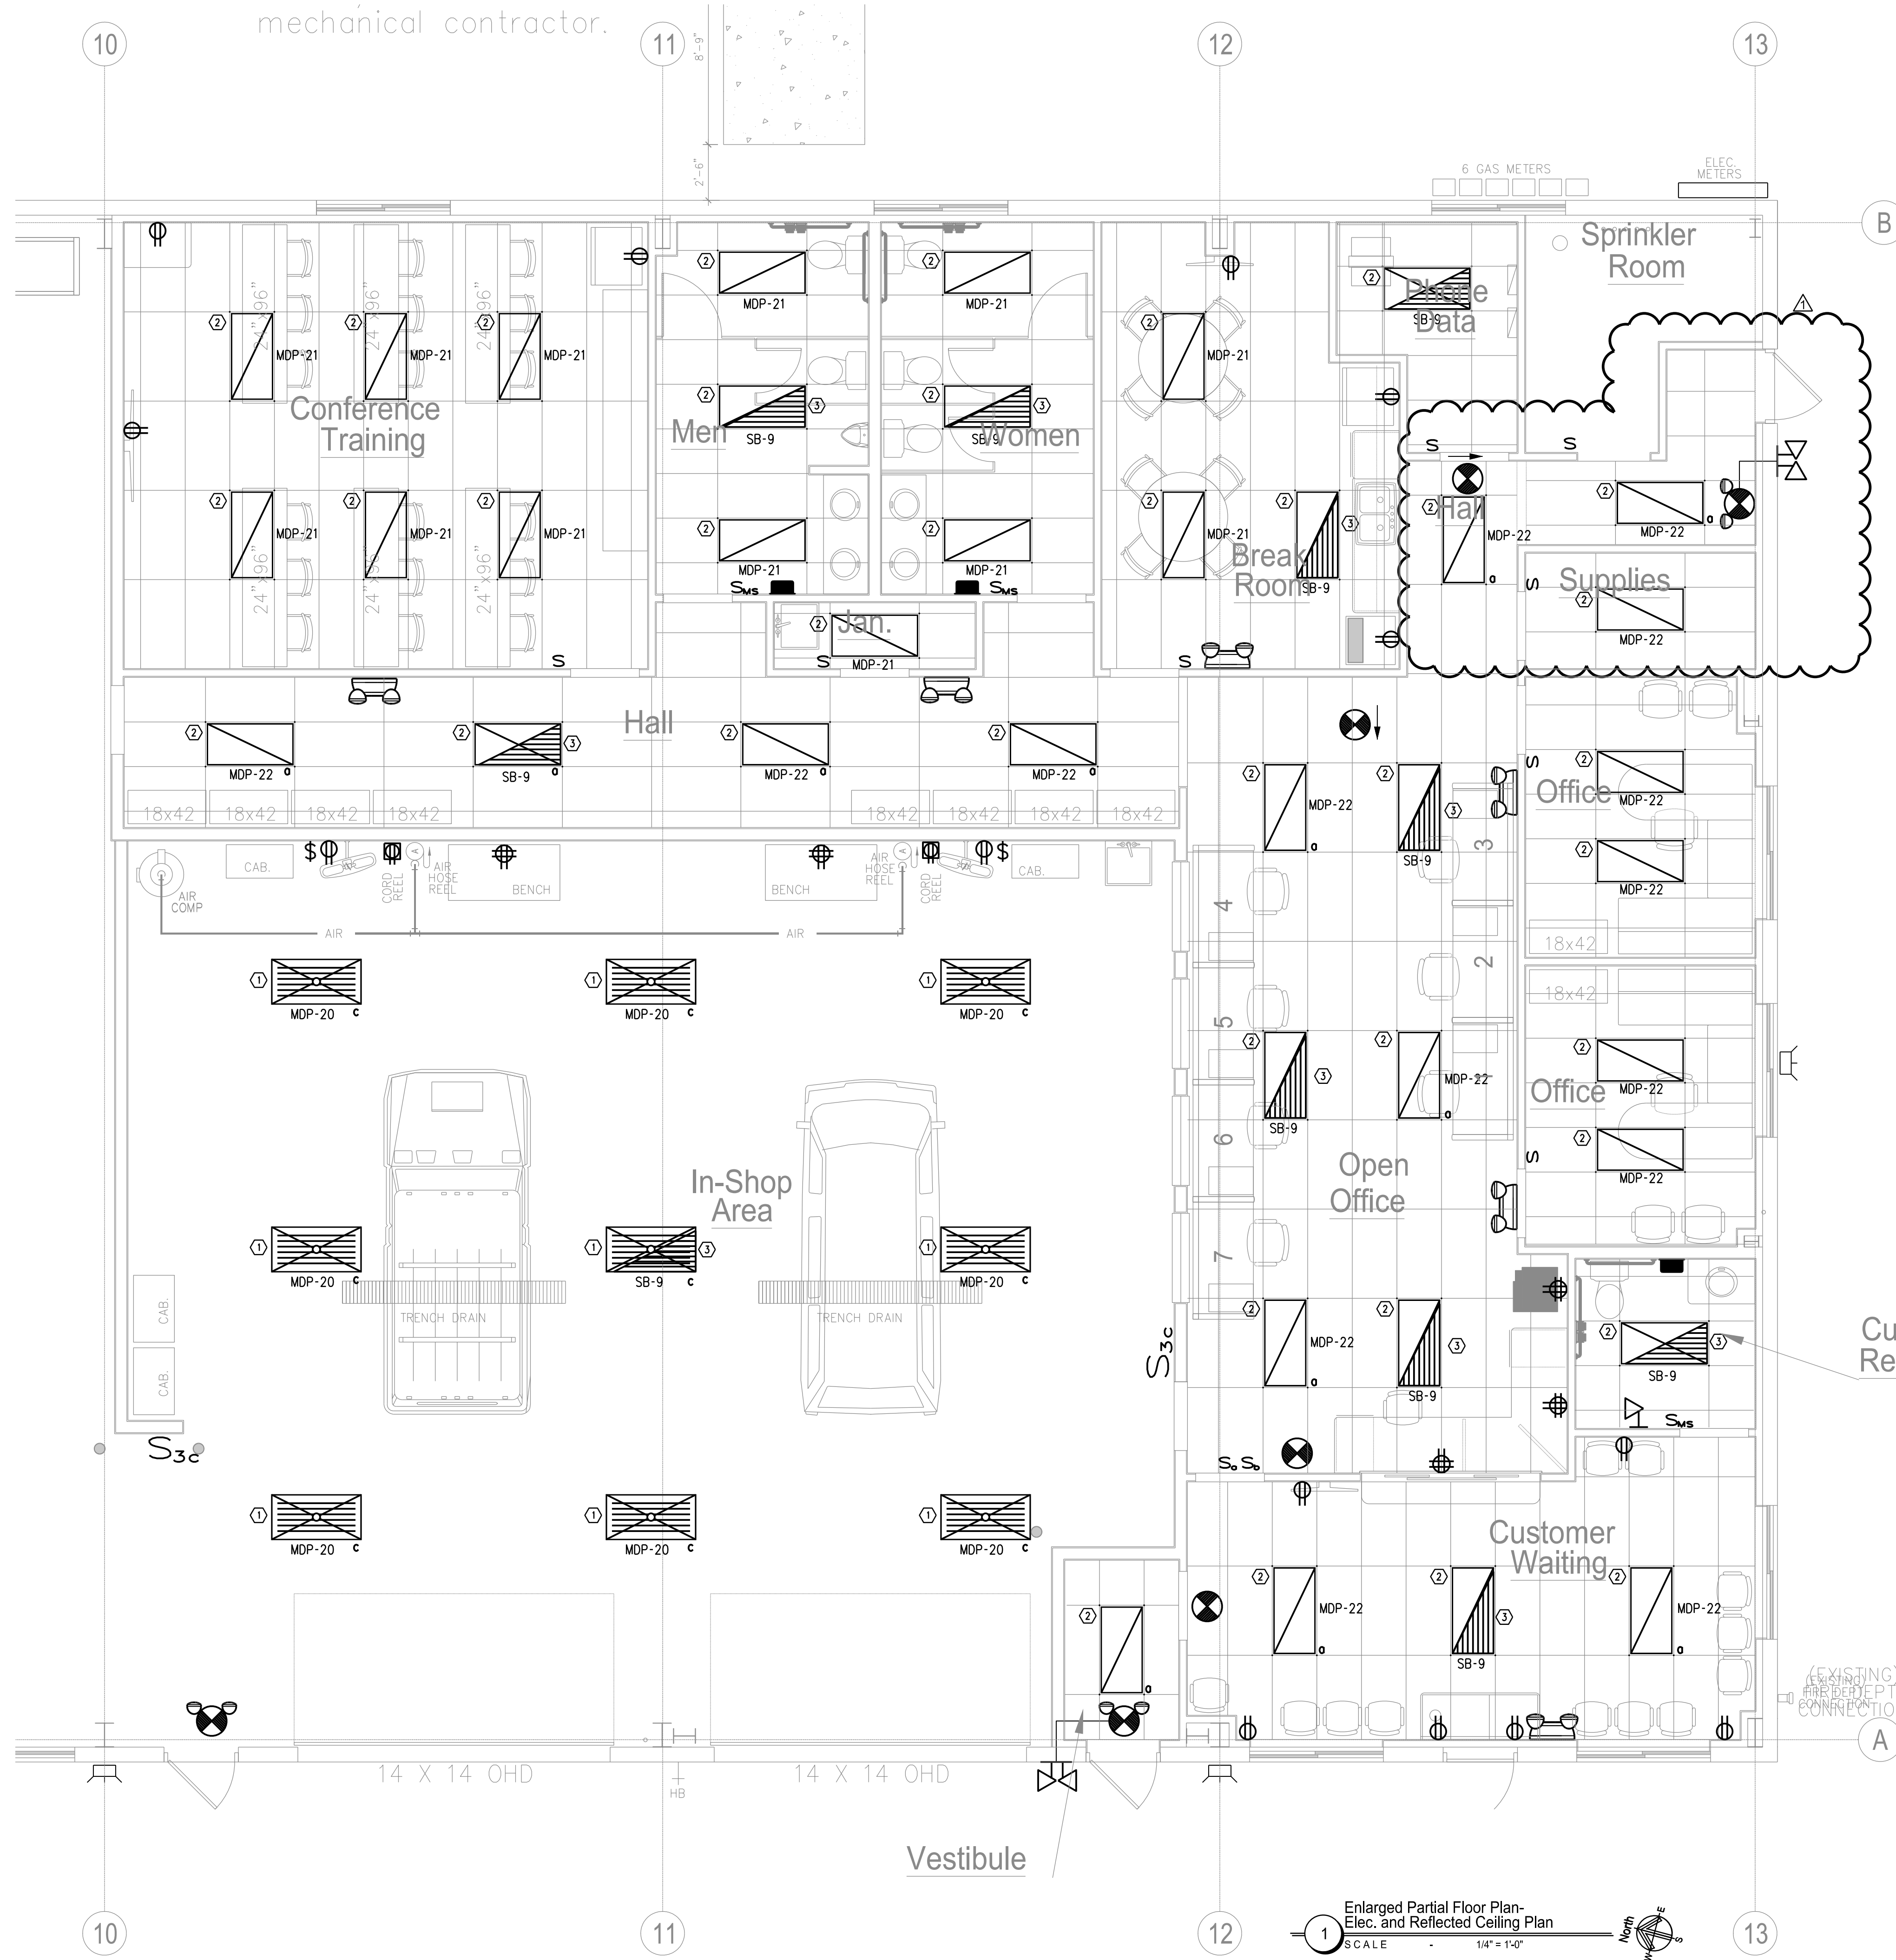


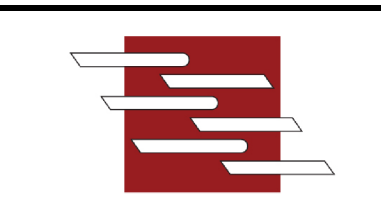

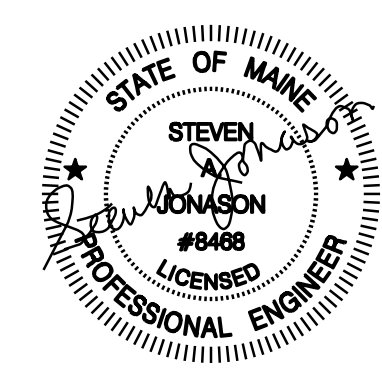
mechanical contractor.



KEYED NOTES - LIGHTING

- (THESE NOTES ARE SPECIFIC TO THIS SHEET ONLY)
- ① PROVIDE NEW HIGH OUTPUT T5, 6-BULB, 2' X 4', LIGHTING AS SHOWN IN THE IN-SHOP AREA. THESE LIGHT FIXTURES TO BE CHAIN MOUNT AT 15'-0" A.F.F.
 - ② PROVIDE LAY-IN, 3-BULB, 2'x4' FLUORESCENT LIGHT FIXTURES IN SUSPENDED CEILING AT LOCATIONS SHOWN.
 - ③ FIXTURES SHALL BE CIRCUITED TO GENERATOR PANEL TO PROVIDE EGRESS LIGHTING DURING POWER OUTAGE.

Enlarged Partial Floor Plan-Elec. and Reflected Ceiling Plan
SCALE 1/4" = 1'-0"

Sheet Name		ENLARGED LIGHTING PLAN			
 BENNETT ENGINEERING MECHANICAL • ELECTRICAL (207) 865-9475		 Safelite AutoGlass 421 Warren Avenue Portland, Maine 04103			
		Issue Date: 05-04-2016 Sheet No. E-1.1			
	Revisions		Drawn By: PMC Checked By: SAJ Checked By: ...		
	No.	Description		Date	
	△	Egress Added		5-19-16	File
	△				Scale AS NOTED
	△				Checked By: SAJ