


FIRE ALARM SYSTEM LAYOUT - WAREHOUSE AREA
SCALE: 1/8" = 1'

SYMBOL LEGEND			
ITEM NO.	SYMBOL	QTY. TOTAL	DESCRIPTION
1	○	1	STANDARD BASE (DB-11) - OCTAGON BOX
2	DM	1	DUAL MONITOR MODULE (HTRI-D) - 4" SQUARE
3	F	16	PULL STATION (MSM-KD/HTRI-M) - SINGLE GANG
4	M	1	MONITOR MODULE (HTRI-S) - 4" SQUARE
5	⊙	1	SMOKE DETECTOR (OH921) - MOUNTS ON DB-11
6	XX	6	HORN/STROBE - WALL (ZH-MC-R) - 4" SQUARE OR SINGLE GANG
7	XX	5	HORN/STROBE - CEILING (ZH-MC-CR) - 4" SQUARE OR SINGLE GANG
8	XX	5	STROBE - WALL (ZR-MC-R) - 4" SQUARE OR SINGLE GANG
9	75CD	5	STROBE - CEILING (ZR-MC-CR) - 4" SQUARE OR SINGLE GANG
10	⊙	1	TAMPER SWITCH - F.B.O.
11	◇	1	WATER FLOW SWITCH - F.B.O.
12	FACP	1	FIRE ALARM CONTROL PANEL (FC 901)
13	PAD	1	PAD PANEL (PAD-4)

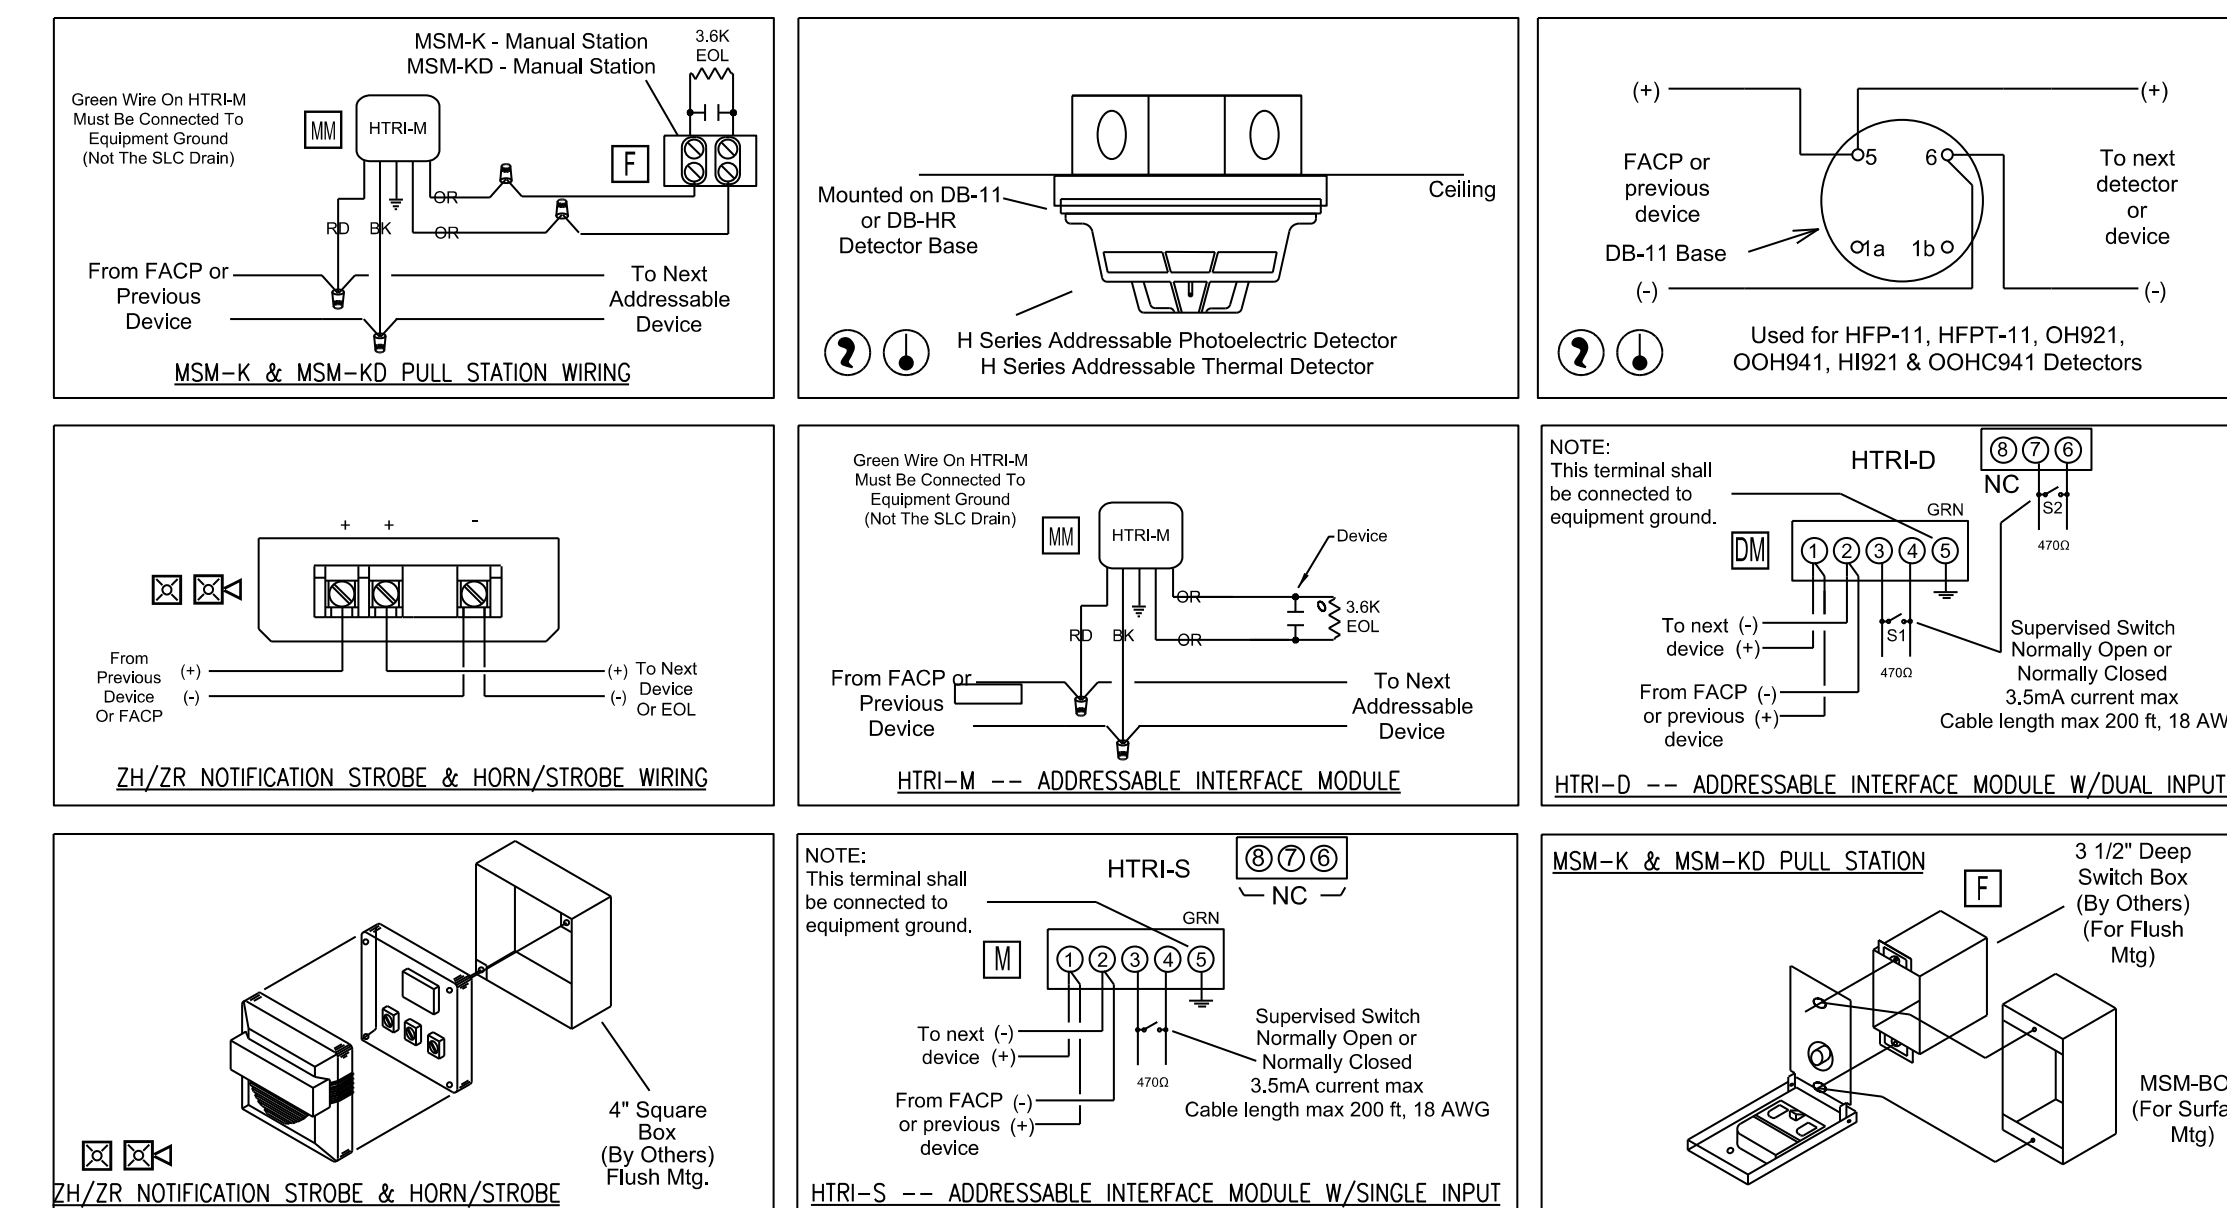

DEVICE WIRING DETAIL
SCALE: N.T.S.

EASTERN FIRE SERVICES, INC.
AUBURN/LEWISTON INDUSTRIAL AIRPARK, AUBURN, MAINE 04210

Sheet Name FIRE ALARM LAYOUT AND DETAILS																			
 BENNETT ENGINEERING MECHANICAL • ELECTRICAL (207) 865-9475																			
 Safelite AutoGlass 421 Warren Avenue Portland, Maine 04103																			
 STEVEN JOHNSON #8488 LICENSED PROFESSIONAL ENGINEER	Issue Date: 05-04-2016																		
Revisions <table border="1"> <thead> <tr> <th>No.</th> <th>Description</th> <th>Date</th> </tr> </thead> <tbody> <tr><td> </td><td> </td><td> </td></tr> <tr><td> </td><td> </td><td> </td></tr> <tr><td> </td><td> </td><td> </td></tr> <tr><td> </td><td> </td><td> </td></tr> <tr><td> </td><td> </td><td> </td></tr> </tbody> </table>	No.	Description	Date																File Scale AS NOTED Drawn By: PMC Checked By: SAJ Checked By: ...
No.	Description	Date																	
E-3.0																			

