



FIRE ALARM SYSTEM LAYOUT - WAREHOUSE & OFFICE AREA  
SCALE: 1/8" = 1'

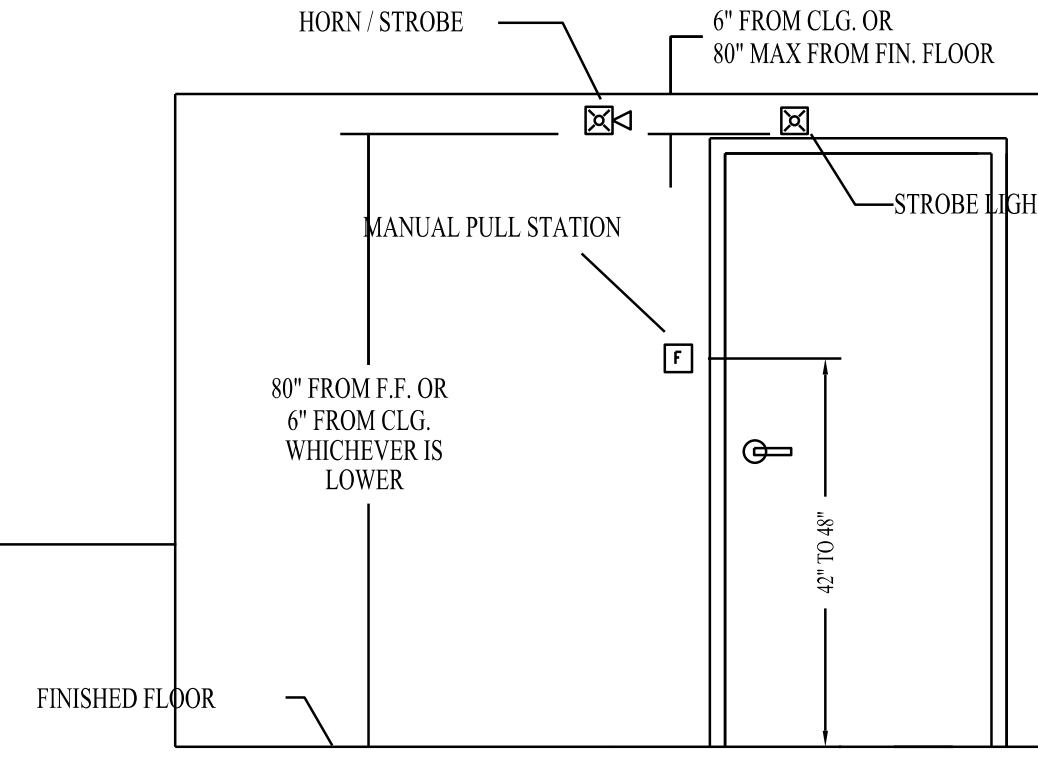


DEVICE ELEVATION DETAIL  
NOT TO SCALE

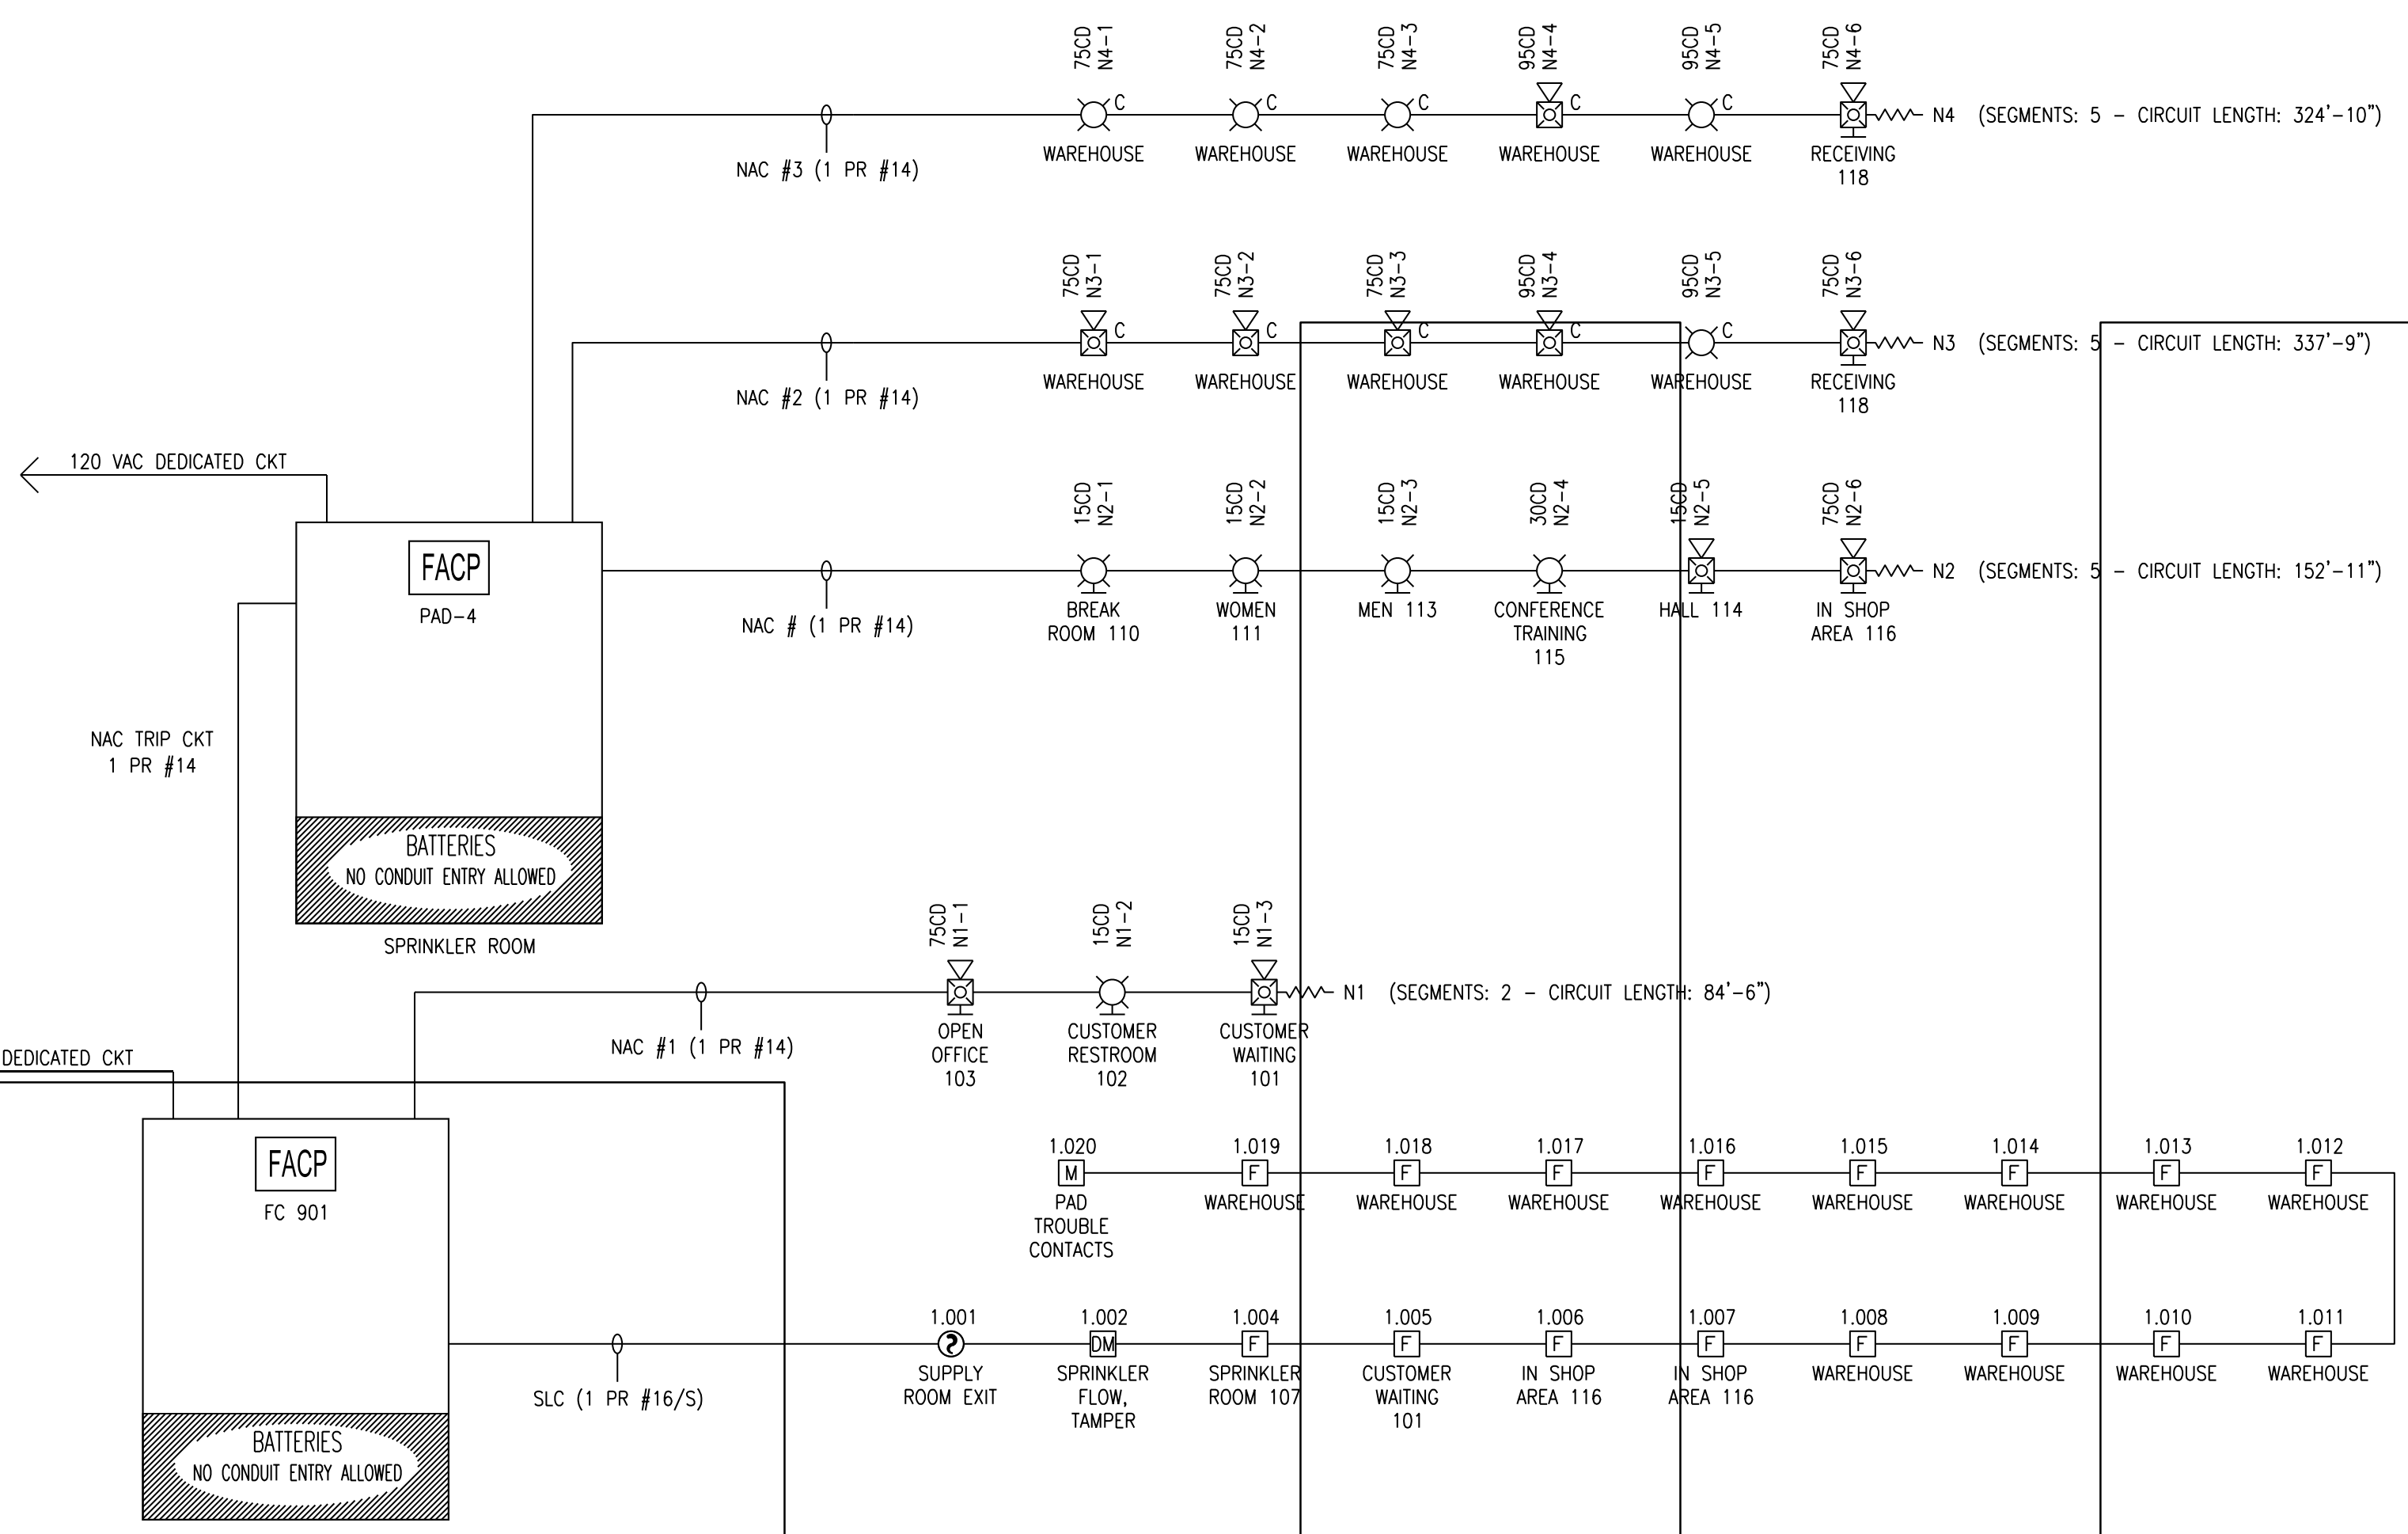

FIRE ALARM RISER DIAGRAM  
SCALE: N.T.S.

**EASTERN FIRE SERVICES, INC.**  
AUBURN/LEWISTON INDUSTRIAL AIRPARK, AUBURN, MAINE 04210

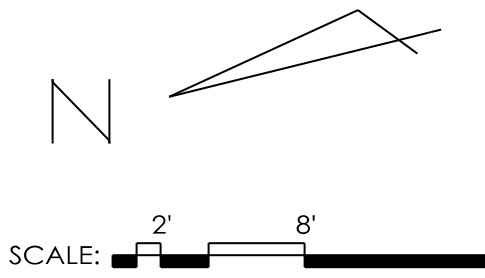

Sheet Name <b>FIRE ALARM LAYOUT AND RISER DIAGRAM</b>		Issue Date: 05-04-2016		Sheet No. <b>E-3.1</b>						
 <b>EASTERN FIRE SERVICES, INC.</b> AUBURN/LEWISTON INDUSTRIAL AIRPARK, AUBURN, MAINE 04210		 <b>BENNETT ENGINEERING</b> MECHANICAL • ELECTRICAL (207) 865-9475		421 Warren Avenue Portland, Maine 04103						
		Revisions <table border="1"> <thead> <tr> <th>No.</th> <th>Description</th> <th>Date</th> </tr> </thead> <tbody> <tr> <td>1</td> <td>Egress Added</td> <td>5-19-16</td> </tr> </tbody> </table>			No.	Description	Date	1	Egress Added	5-19-16
No.	Description	Date								
1	Egress Added	5-19-16								