


KEYED NOTES - ELECTRICAL

SEE ELECTRICAL DRAWING FOR SPECIFICATIONS AND ADDITIONAL INFORMATION. (THESE NOTES ARE SPECIFIC TO THIS SHEET ONLY)

- 1. PROVIDE ONE FOUR-PLEX ELECTRICAL OUTLETS AT 44" A.F.F. FOR IN-SHOP BENCHES.
- 2. INSTALL NEW WALL MOUNTED FAN, SWITCH, AND ELECTRICAL RECEPTACLE AT LOCATIONS SHOWN PROVIDED BY SAFELITE, INSTALLED BY CONTRACTOR. SWITCH IS TO BE INSTALLED AT 54" A.F.F. TO CENTERLINE. FAN AND RECEPTACLE IS TO BE INSTALLED AT 120" A.F.F. FAN IS "CLD HANDLING SYSTEM" ITEM NUMBER H4CU-30-WO.
- 3. INSTALL NEW ELECTRICAL CORD REELS WHERE SHOWN, PROVIDED BY SAFELITE, INSTALLED BY CONTRACTOR. REELS TO BE "LUMAPRO" BY GRANGER #4967.
- 4. PROVIDE NEW DUPLEX ELECTRICAL RECEPTACLE AT 84" A.F.F. FOR TV WHERE SHOWN.
- 5. PROVIDE NEW DUPLEX ELECTRICAL RECEPTACLE AT 44" A.F.F. OVER COFFEE CABINET WHERE SHOWN.
- 6. PROVIDE NEW DUPLEX ELECTRICAL RECEPTACLE AT 24" A.F.F. FOR CANNED BEVERAGE CENTER WHERE SHOWN.
- 7. PROVIDE REQUIRED ELECTRICAL TO A HAND DRYER MOUNTED ON WALL IN BOTH RESTROOMS WHERE SHOWN. HAND DRYER IS A CHROME XLERATOR MODEL XL-C-1-IN. AND MOUNT PER MANUFACTURERS RECOMMENDATIONS. BOTTOM OF UNIT TO BE AT 37" A.F.F.
- 8. PROVIDE NEW DUPLEX ELECTRICAL RECEPTACLE AT 44" A.F.F. FOR REFRIGERATOR WHERE SHOWN.
- 9. PROVIDE NEW DUPLEX ELECTRICAL RECEPTACLE AT 44" A.F.F. FOR ICE MAKER WHERE SHOWN.
- 10. PROVIDE NEW DUPLEX ELECTRICAL RECEPTACLE AT 18" A.F.F. WHERE SHOWN.
- 11. PROVIDE NEW DUPLEX ELECTRICAL RECEPTACLE AT 44" A.F.F. FOR AIR COMPRESSOR WHERE SHOWN.
- 12. PROVIDE NEW FOUR-PLEX ELECTRICAL RECEPTACLE AT 18" A.F.F. FOR PRINTER AND BELOW CSR COUNTER WHERE SHOWN.
- 13. PROVIDE NEW WATER HEATER ON SHELF ABOVE TUB SINK IN JANITOR'S CLOSET WHERE SHOWN.
- 14. PROVIDE REQUIRED ELECTRICAL AND SWITCH FOR DISHWASHER AS SHOWN.
- 15. PROVIDE REQUIRED ELECTRICAL AND SWITCH FOR DISPOSAL AS SHOWN.
- 16. PROVIDE NEW ELECTRIC OVERHEAD DOOR OPERATORS AT LOCATIONS SHOWN.

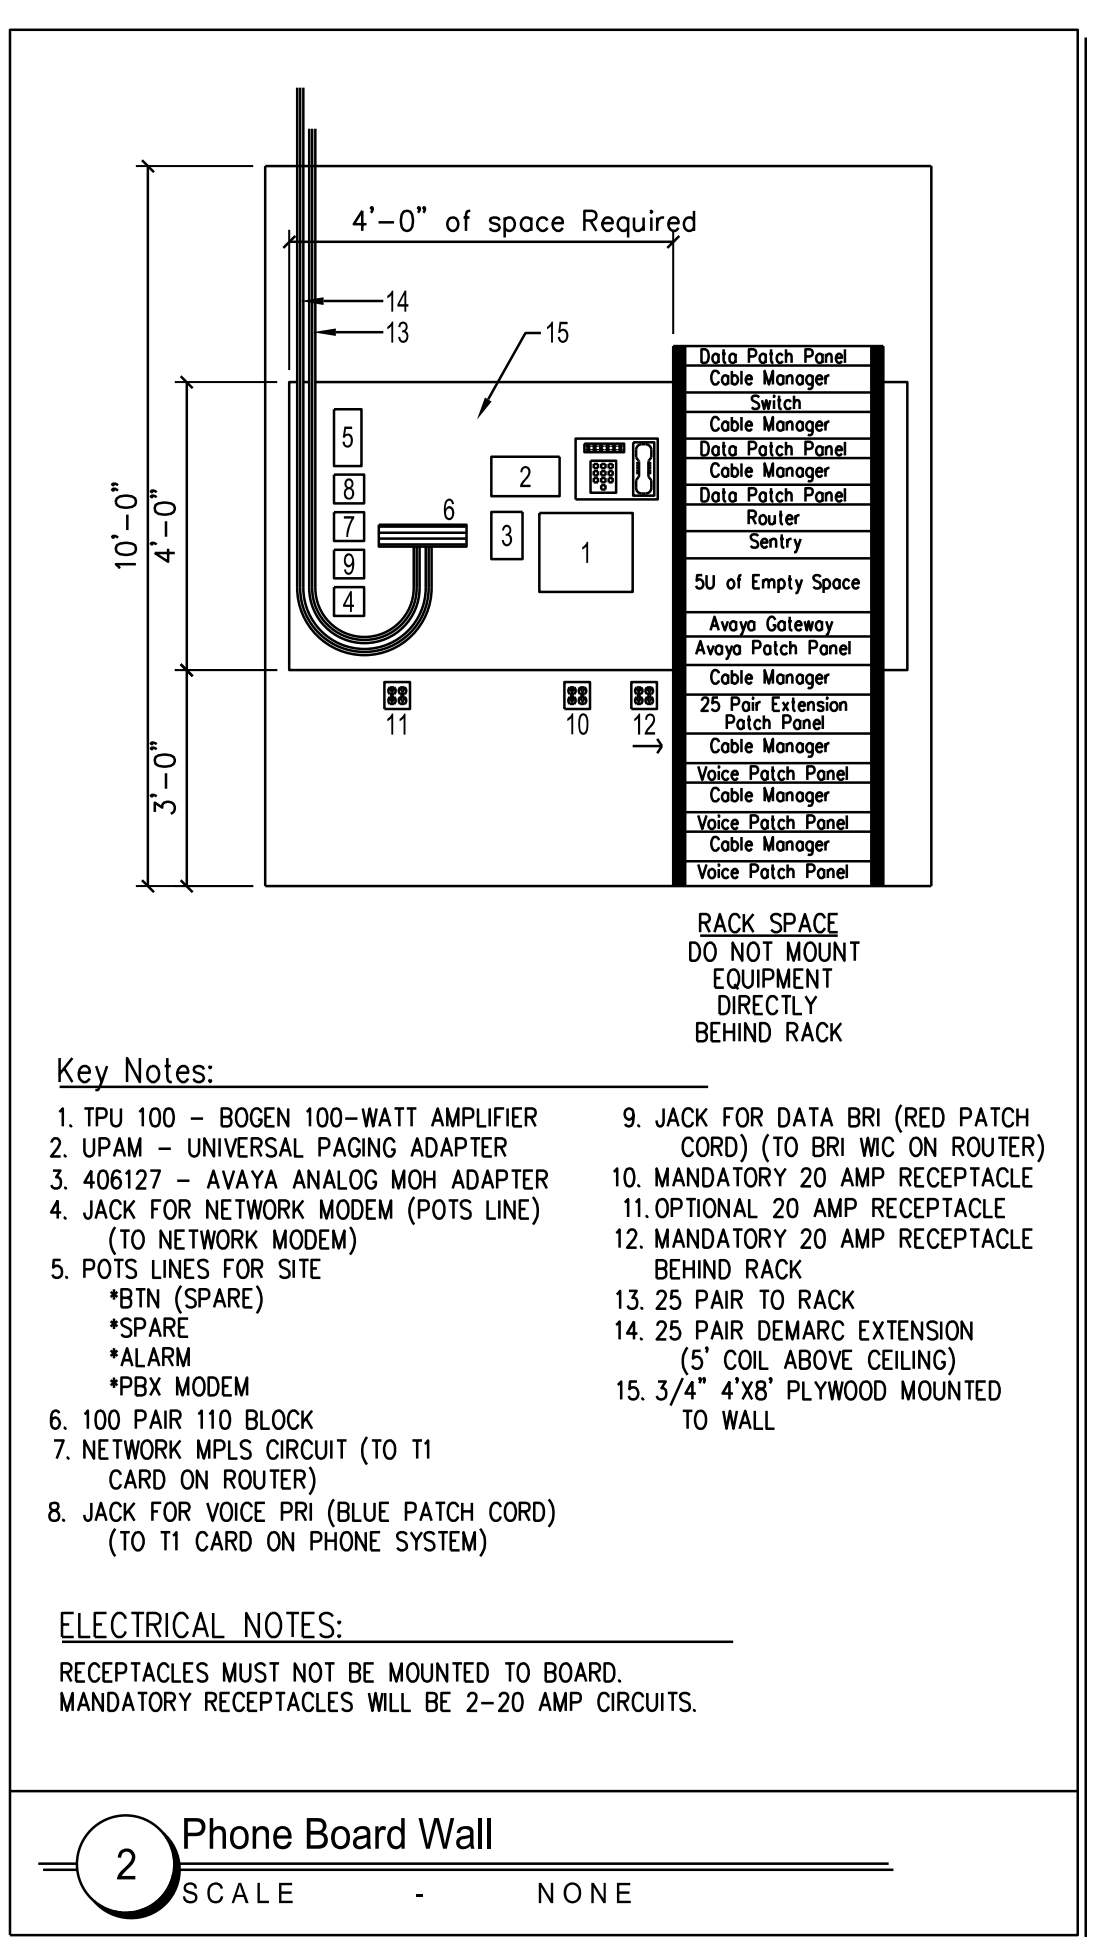

Enlarged Partial Floor Plan - Electrical
SCALE 1/4" = 1'-0"

Sheet Name		ENLARGED POWER PLAN																		
<p>BENNETT ENGINEERING MECHANICAL • ELECTRICAL (207) 865-9475</p>		<p>Safelite AutoGlass 421 Warren Avenue Portland, Maine 04103</p>																		
			<table border="1"> <thead> <tr> <th colspan="3">Revisions</th> </tr> <tr> <th>No.</th> <th>Description</th> <th>Date</th> </tr> </thead> <tbody> <tr> <td> </td> <td> </td> <td> </td> </tr> <tr> <td> </td> <td> </td> <td> </td> </tr> <tr> <td> </td> <td> </td> <td> </td> </tr> <tr> <td> </td> <td> </td> <td> </td> </tr> </tbody> </table>	Revisions			No.	Description	Date											
Revisions																				
No.	Description	Date																		
<p>Scale AS NOTED</p> <p>Drawn By: PMC</p> <p>Checked By: SAJ</p> <p>Checked By: ...</p>		<p>File</p>																		