



FIRE ALARM SYSTEM LAYOUT - WAREHOUSE AREA
SCALE: 1/8" = 1'

SYMBOL LEGEND			
ITEM NO.	SYMBOL	QTY. TOTAL	DESCRIPTION
1	○	1	STANDARD BASE (DB-11) - OCTAGON BOX
2	DM	1	DUAL MONITOR MODULE (HTRI-D) - 4" SQUARE
3	F	16	PULL STATION (MSM-KD/HTRI-M) - SINGLE GANG
4	M	1	MONITOR MODULE (HTRI-S) - 4" SQUARE
5	⊙	1	SMOKE DETECTOR (OH921) - MOUNTS ON DB-11
6	XX	6	HORN/STROBE - WALL (ZH-MC-R) - 4" SQUARE OR SINGLE GANG
7	XX	5	HORN/STROBE - CEILING (ZH-MC-CR) - 4" SQUARE OR SINGLE GANG
8	XX	5	STROBE - WALL (ZR-MC-R) - 4" SQUARE OR SINGLE GANG
9	75CD	5	STROBE - CEILING (ZR-MC-CR) - 4" SQUARE OR SINGLE GANG
10	⊙	1	TAMPER SWITCH - F.B.O.
11	◇	1	WATER FLOW SWITCH - F.B.O.
12	FACP	1	FIRE ALARM CONTROL PANEL (FC 901)
13	PAD	1	PAD PANEL (PAD-4)

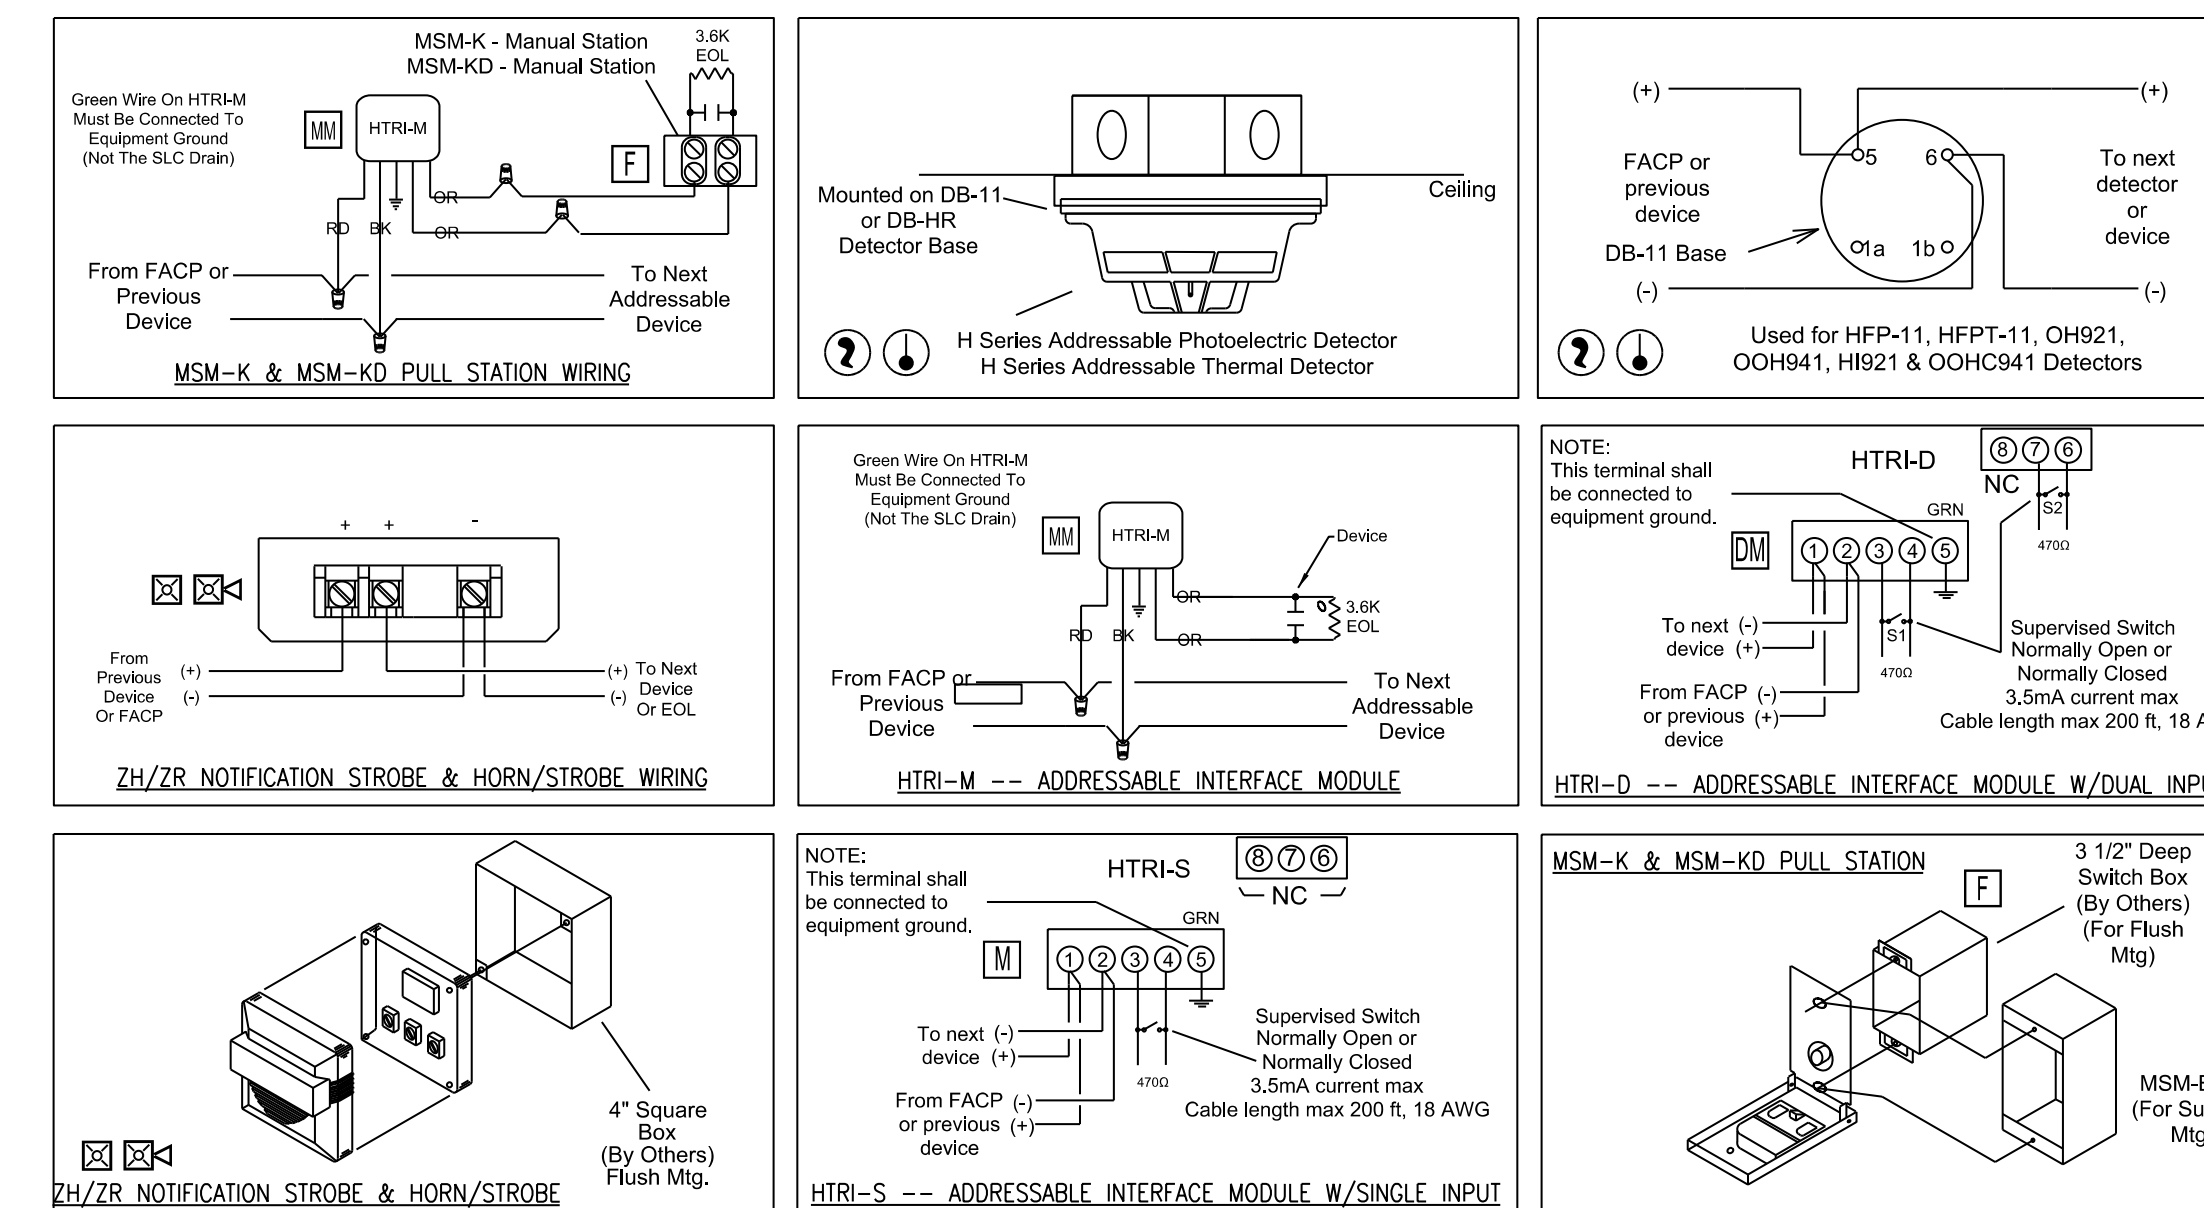

DEVICE WIRING DETAIL
SCALE: N.T.S.

EASTERN FIRE SERVICES, INC.
AUBURN/LEWISTON INDUSTRIAL AIRPARK, AUBURN, MAINE 04210

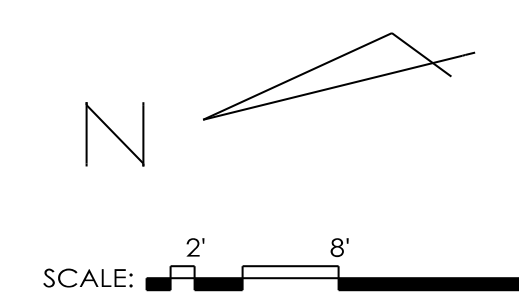

Sheet Name		FIRE ALARM LAYOUT AND DETAILS		
 BENNETT ENGINEERING MECHANICAL • ELECTRICAL (207) 865-9475		 Safelite AutoGlass 421 Warren Avenue Portland, Maine 04103		
				Issue Date: 05-04-2016
		Revisions		
		No.	Description	Date
Drawn By: PMC Checked By: SAJ Checked By: ...		File Scale AS NOTED		
		Sheet No. <h1>E-3.0</h1>		