



FIRE ALARM SYSTEM LAYOUT - WAREHOUSE & OFFICE AREA  
SCALE: 1/8" = 1'

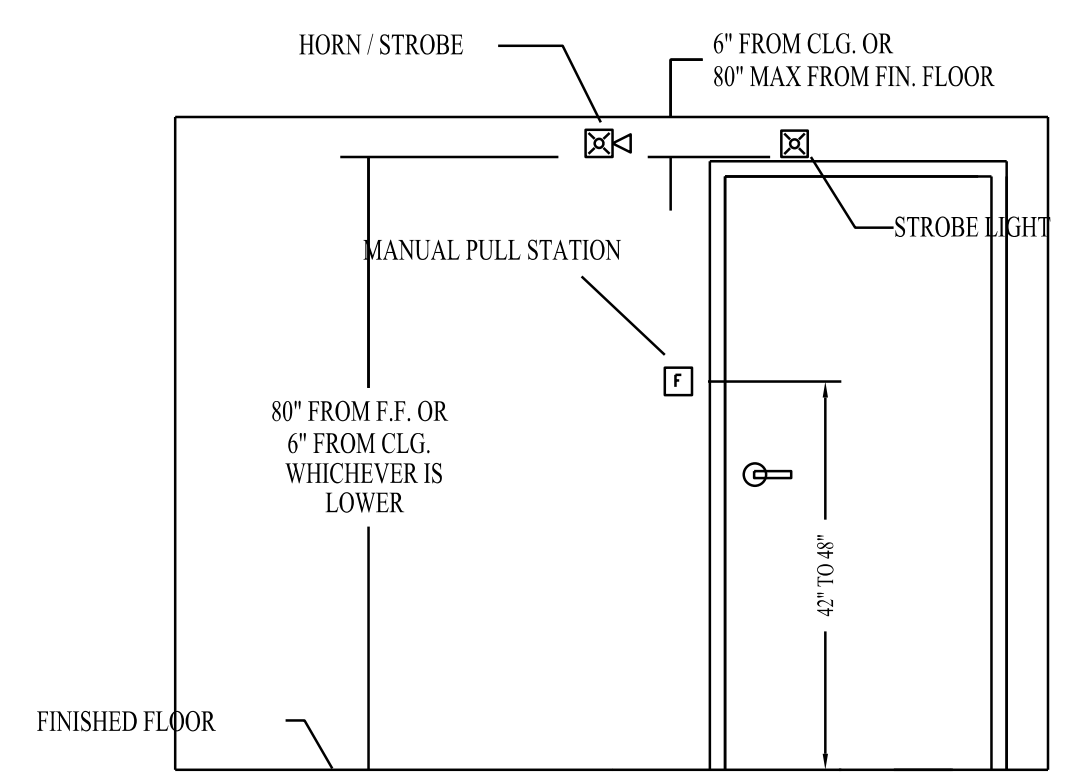


DEVICE ELEVATION DETAIL  
NOT TO SCALE

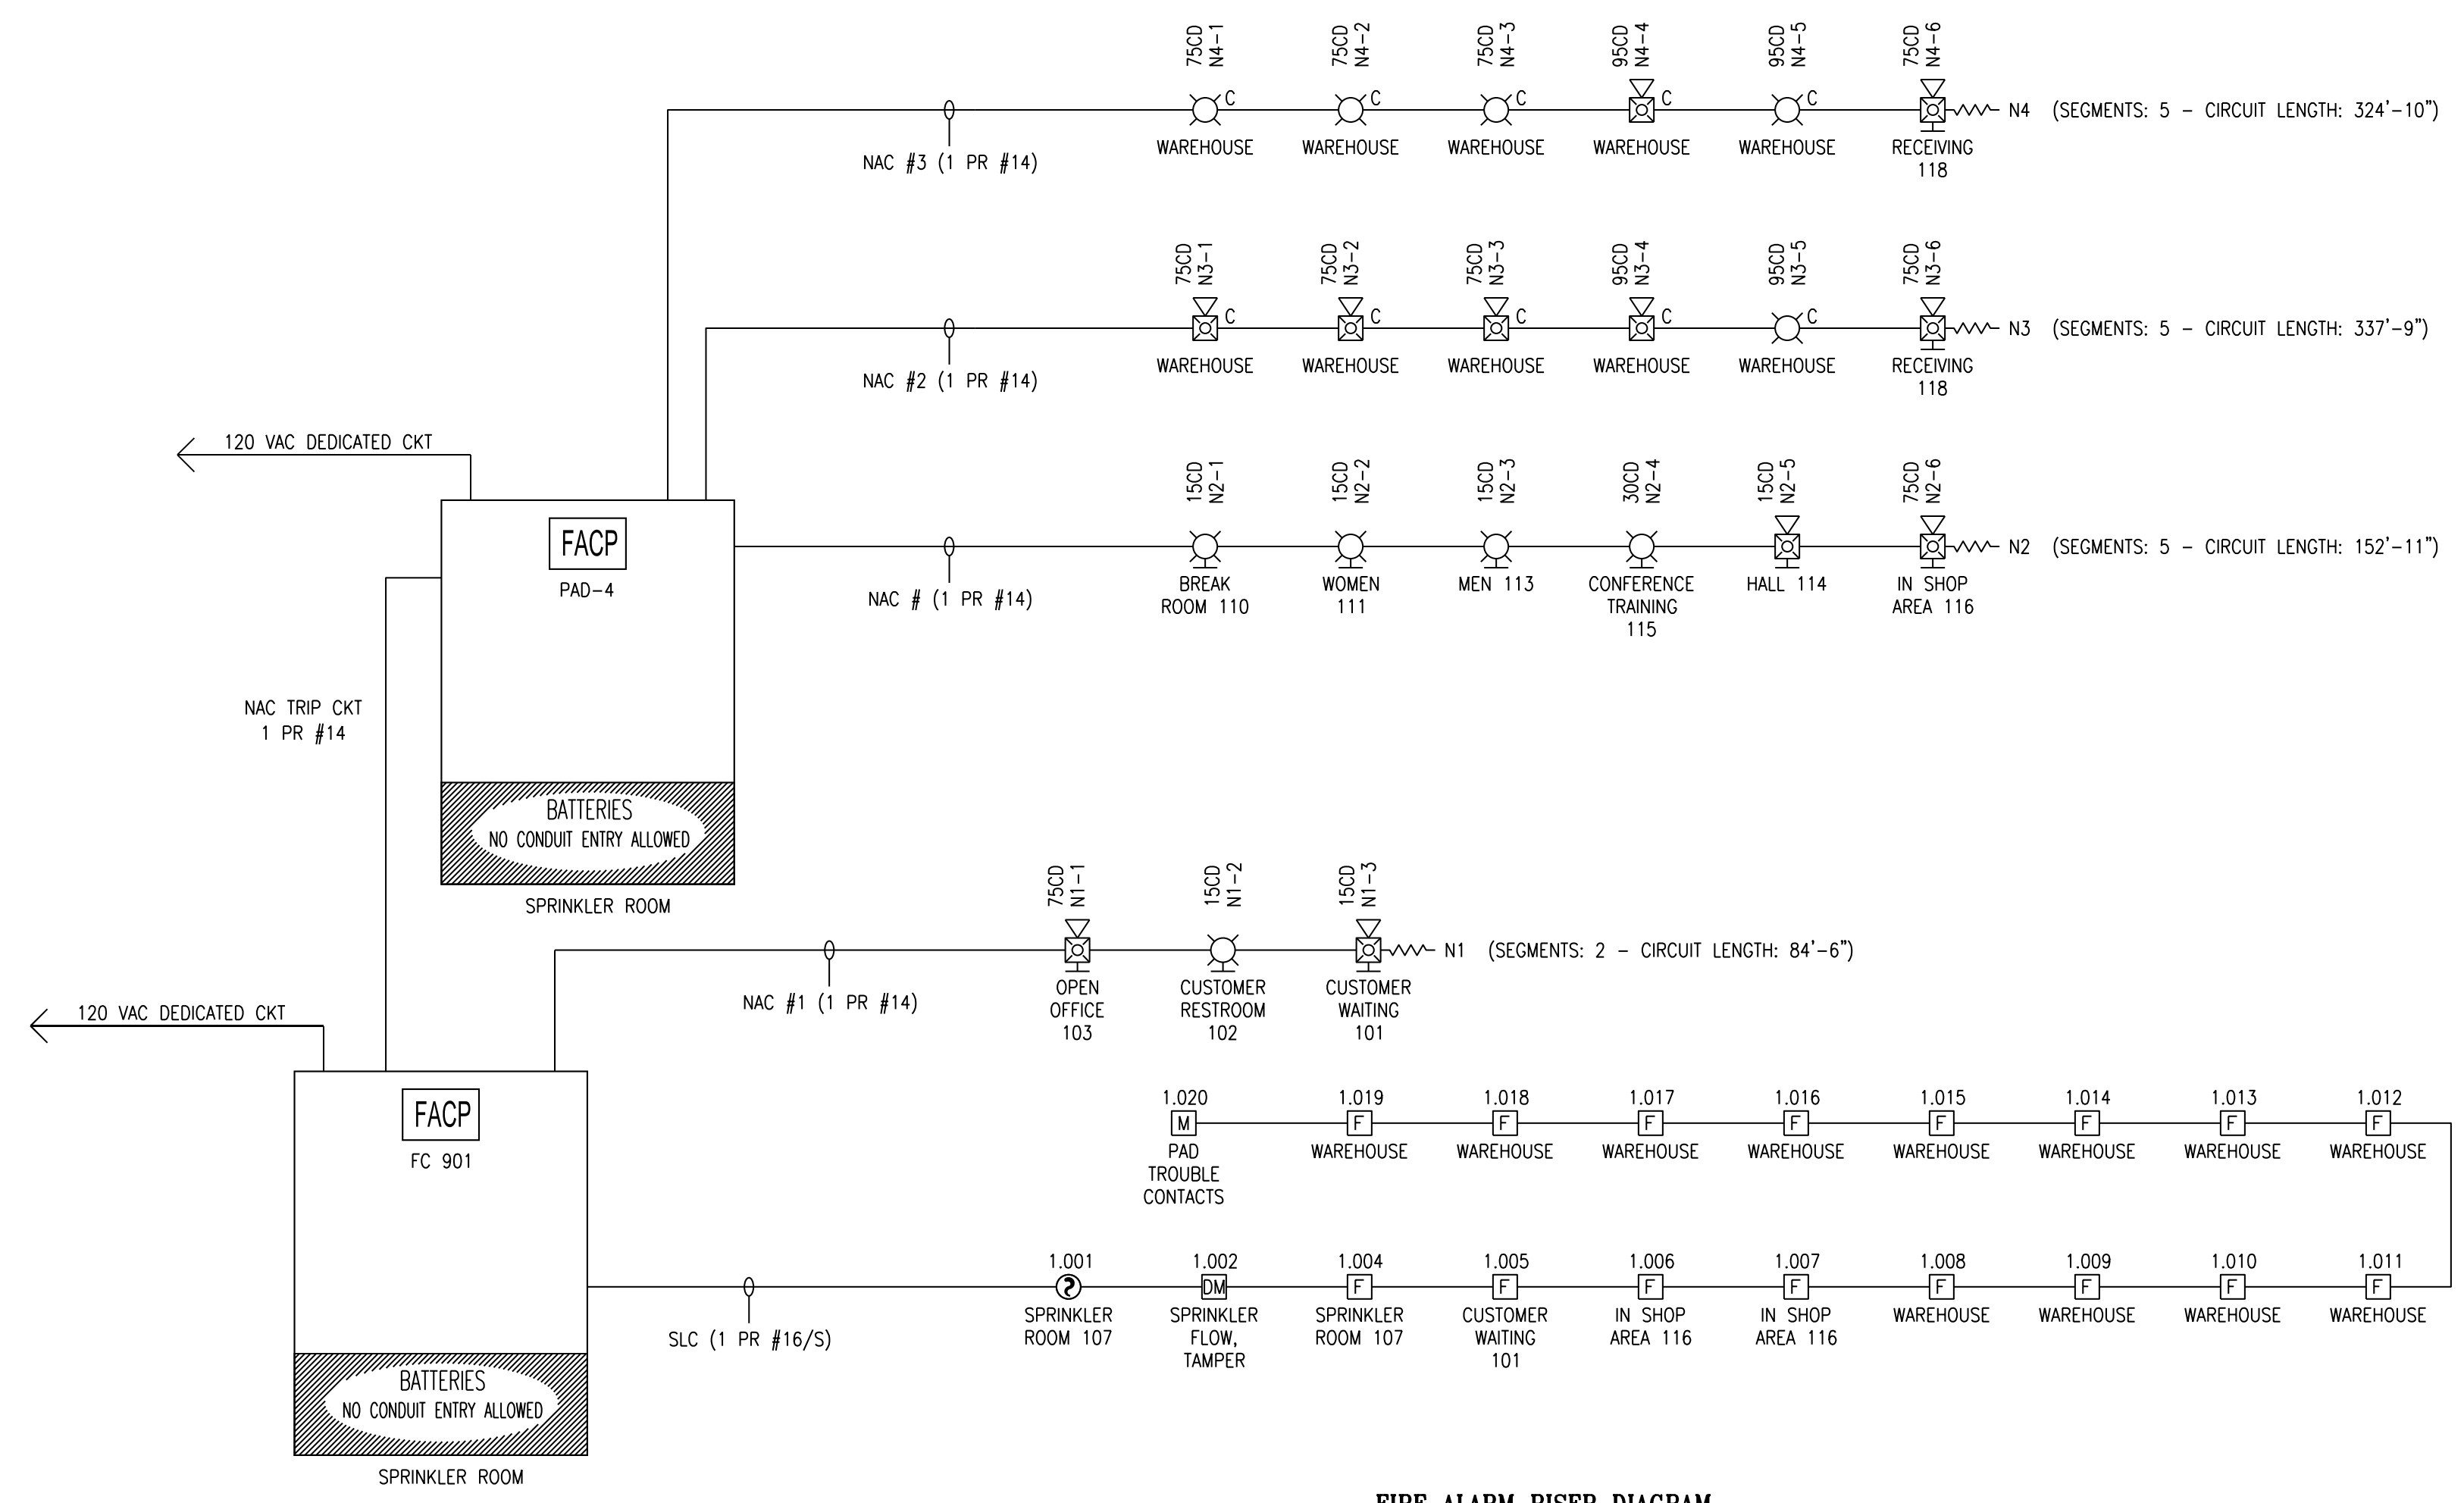

FIRE ALARM RISER DIAGRAM  
SCALE: N.T.S.

**EASTERN FIRE SERVICES, INC.**  
AUBURN/LEWISTON INDUSTRIAL AIRPARK, AUBURN, MAINE 04210

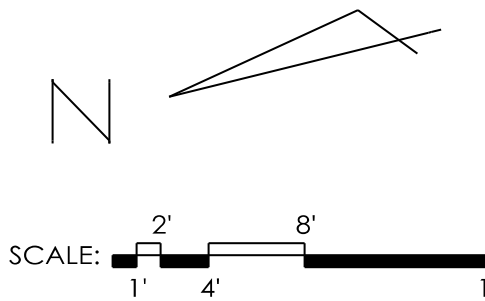

| Sheet Name<br><b>FIRE ALARM LAYOUT AND RISER DIAGRAM</b>   |             | Issue Date:<br>05-04-2016                                    |  | Sheet No.<br><b>E-3.1</b> |     |             |      |  |  |  |  |  |  |  |  |  |  |  |  |   |  |  |
|--|-------------|--|--|---------------------------|-----|-------------|------|--|--|--|--|--|--|--|--|--|--|--|--|---|--|--|
| <br><b>BENNETT ENGINEERING</b><br>MECHANICAL • ELECTRICAL<br>(207) 865-9475  |             | <br><b>421 Warren Avenue</b><br><b>Portland, Maine 04103</b> |  |                           | <table border="1"> <thead> <tr> <th colspan="3">Revisions</th> </tr> <tr> <th>No.</th> <th>Description</th> <th>Date</th> </tr> </thead> <tbody> <tr> <td> </td> <td> </td> <td> </td> </tr> <tr> <td> </td> <td> </td> <td> </td> </tr> <tr> <td> </td> <td> </td> <td> </td> </tr> <tr> <td> </td> <td> </td> <td> </td> </tr> </tbody> </table> |             | Revisions  |  |                           | No. | Description | Date |  |  |  |  |  |  |  |  |  |  |  |  | File<br>Scale AS NOTED<br>Drawn By: PMC<br>Checked By: SAJ<br>Checked By: ... |  |  |
| Revisions  |             |  |  |                           |     |             |      |  |  |  |  |  |  |  |  |  |  |  |  |   |  |  |
| No.  | Description | Date   |  |                           |     |             |      |  |  |  |  |  |  |  |  |  |  |  |  |   |  |  |
|  |             |  |  |                           |     |             |      |  |  |  |  |  |  |  |  |  |  |  |  |   |  |  |
|  |             |  |  |                           |     |             |      |  |  |  |  |  |  |  |  |  |  |  |  |   |  |  |
|  |             |  |  |                           |     |             |      |  |  |  |  |  |  |  |  |  |  |  |  |   |  |  |
|  |             |  |  |                           |     |             |      |  |  |  |  |  |  |  |  |  |  |  |  |   |  |  |