



FIRE ALARM SYSTEM LAYOUT - WAREHOUSE & OFFICE AREA
SCALE: 1/8" = 1'


SYMBOL LEGEND			
ITEM NO.	SYMBOL	QTY.	DESCRIPTION
1	○	1	STANDARD BASE (DB-11) - OCTAGON BOX
2	□M	1	DUAL MONITOR MODULE (HTRI-D) - 4" SQUARE
3	□F	16	PULL STATION (MSM-KD/HTRI-M) - SINGLE GANG
4	□M	1	MONITOR MODULE (HTRI-S) - 4" SQUARE
5	⊙	1	SMOKE DETECTOR (OH221) - MOUNTS ON DB-11
6	⊘XX	6	HORN/STROBE - WALL (ZH-MC-R) - 4" SQUARE OR SINGLE GANG
7	⊘XX	5	HORN/STROBE - CEILING (ZH-MC-CR) - 4" SQUARE OR SINGLE GANG
8	⊘XX	5	STROBE - WALL (ZR-MC-R) - 4" SQUARE OR SINGLE GANG
9	⊘75CD	5	STROBE - CEILING (ZR-MC-CR) - 4" SQUARE OR SINGLE GANG
10	⊙	1	TAMPER SWITCH - F.B.O.
11	⊙	1	WATER FLOW SWITCH - F.B.O.
12	□FACP	1	FIRE ALARM CONTROL PANEL (FC 901)
13	□PAD	1	PAD PANEL (PAD-4)

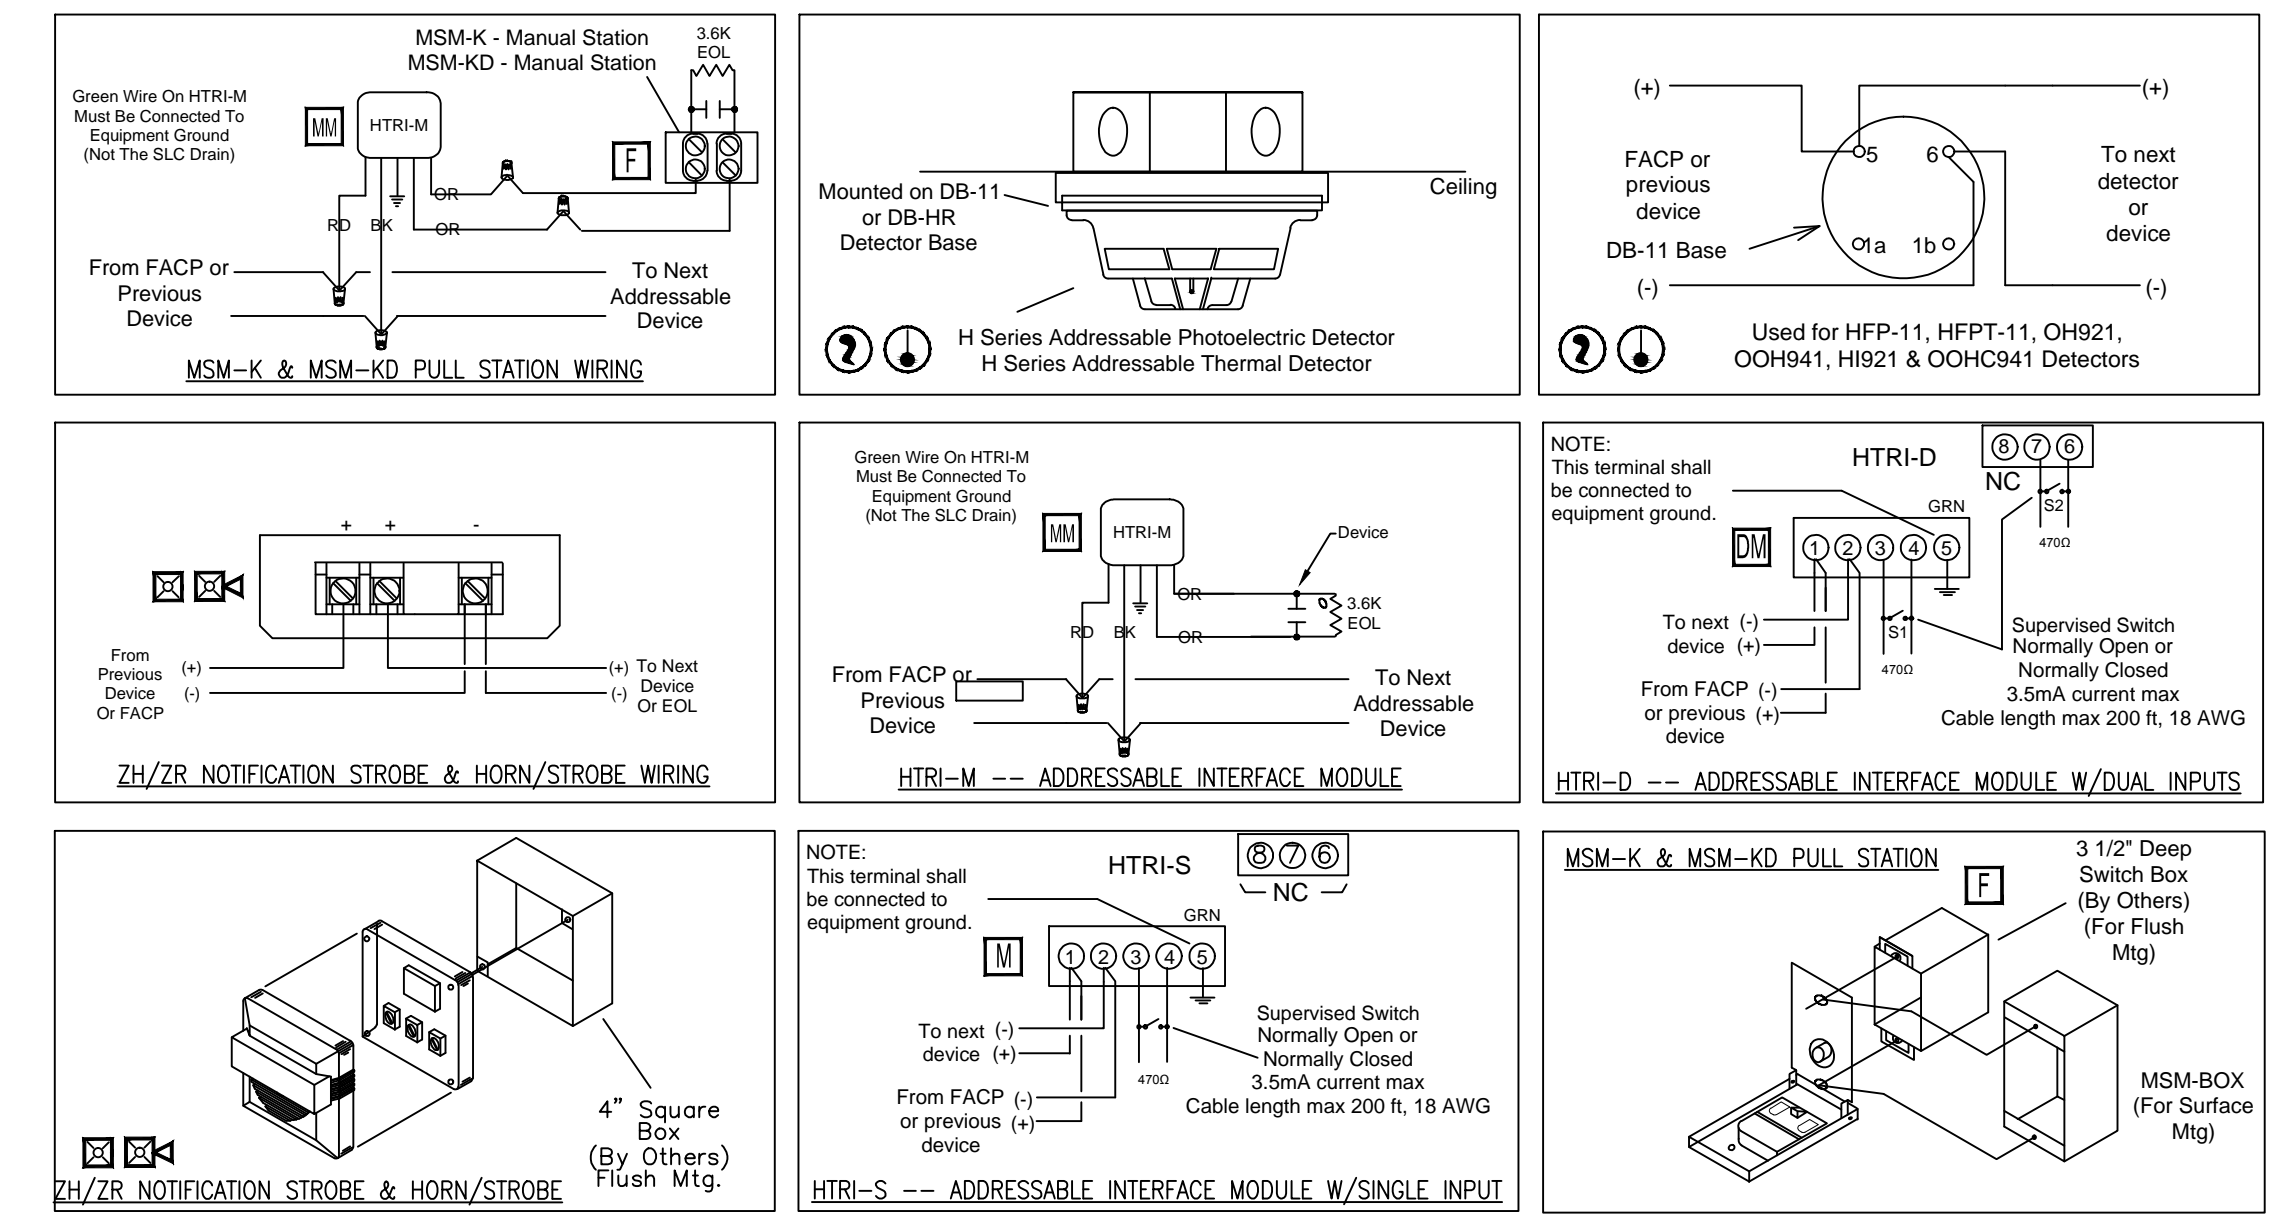


DEVICE WIRING DETAIL
SCALE: N.T.S.

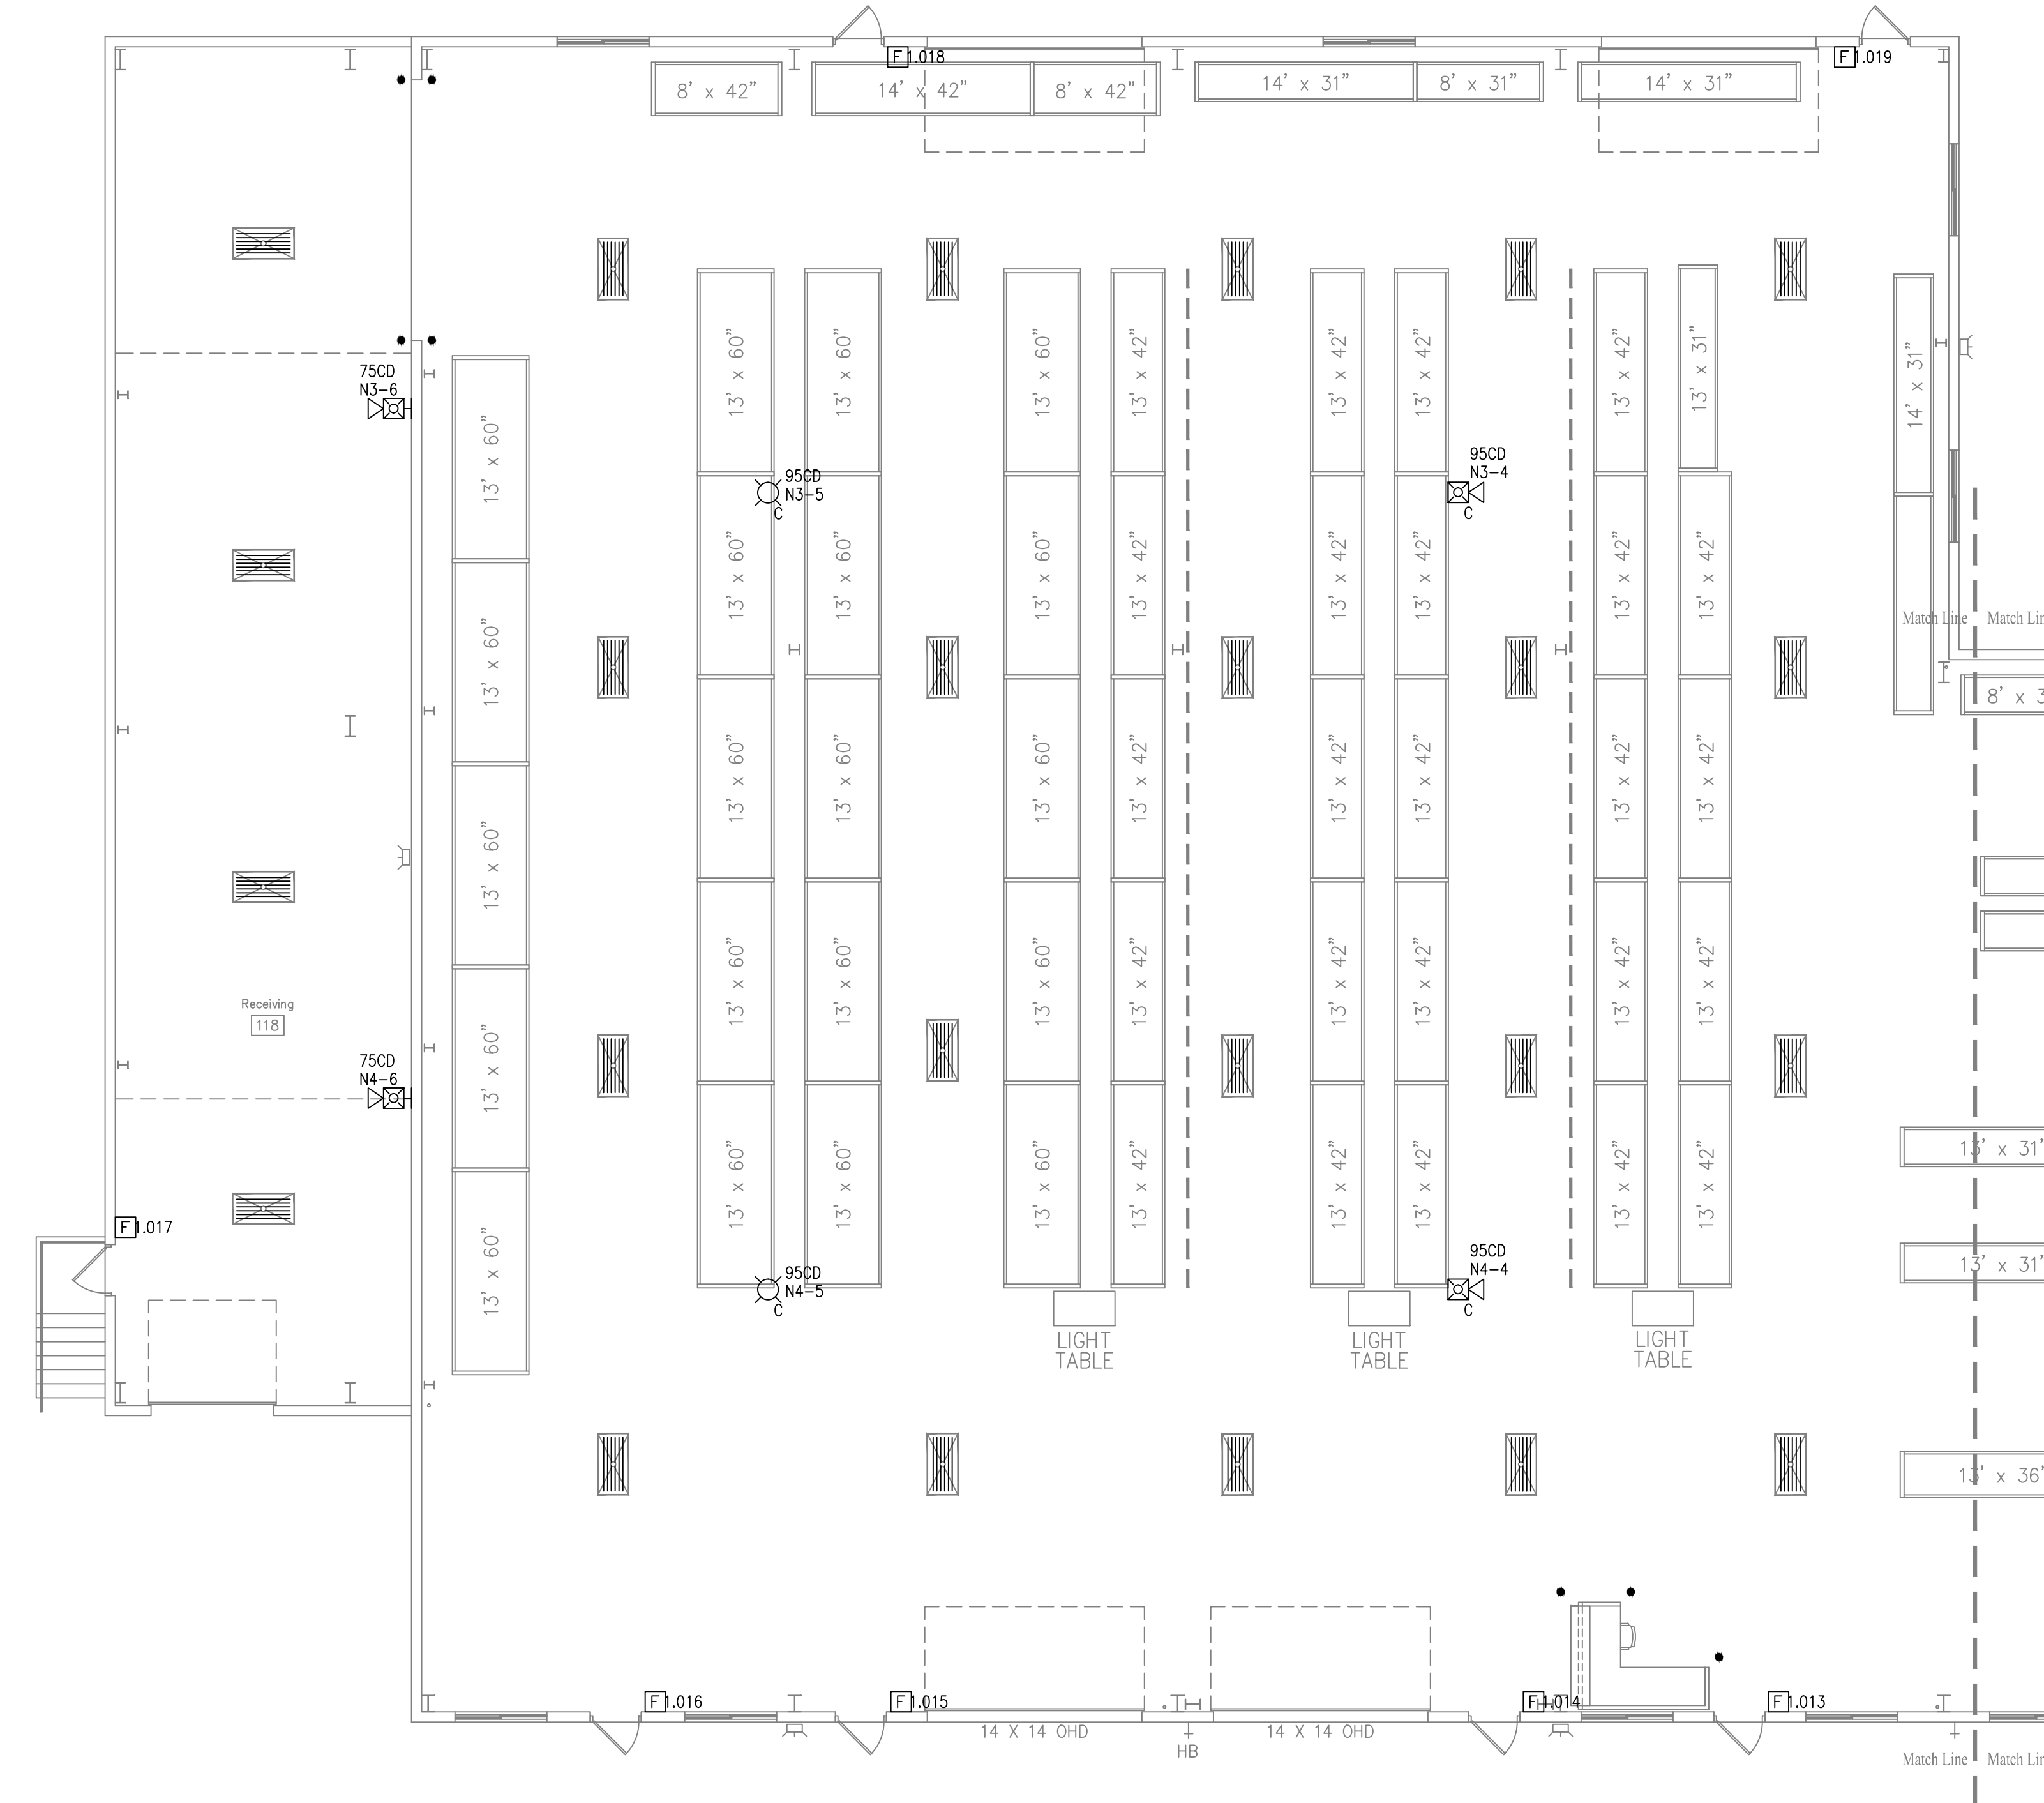


FIRE ALARM SYSTEM LAYOUT - WAREHOUSE AREA
SCALE: 1/8" = 1'

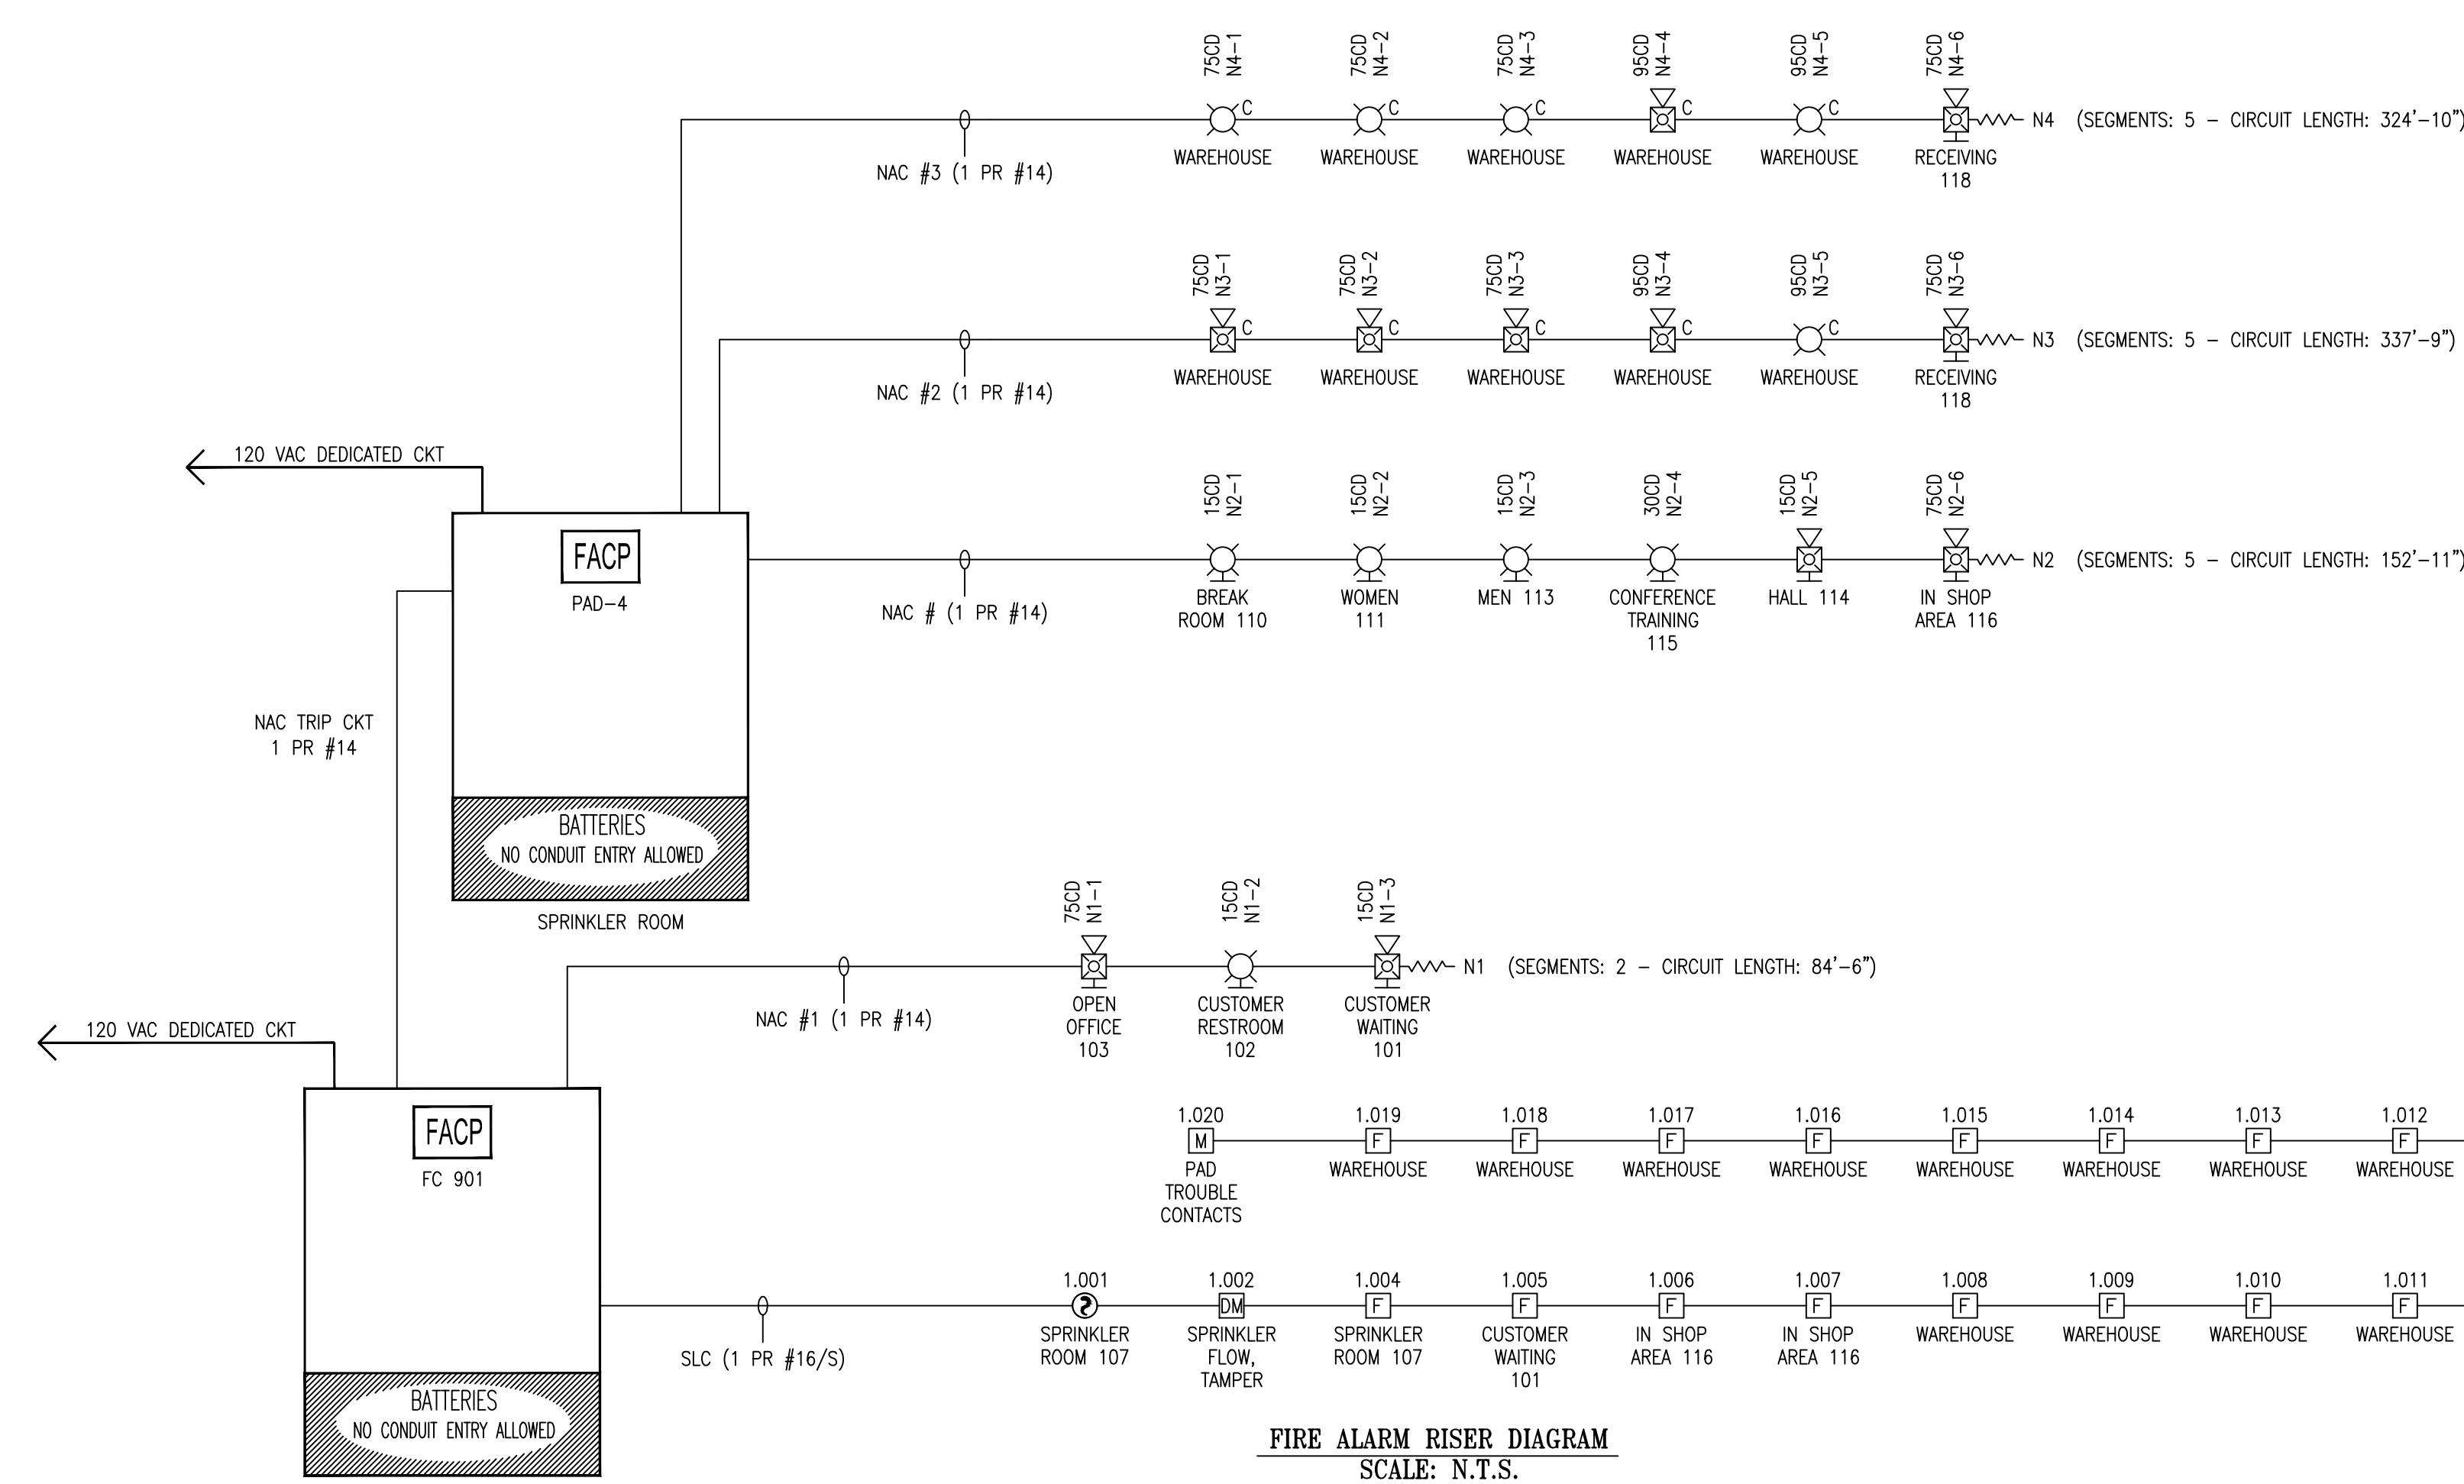

FIRE ALARM RISER DIAGRAM
SCALE: N.T.S.

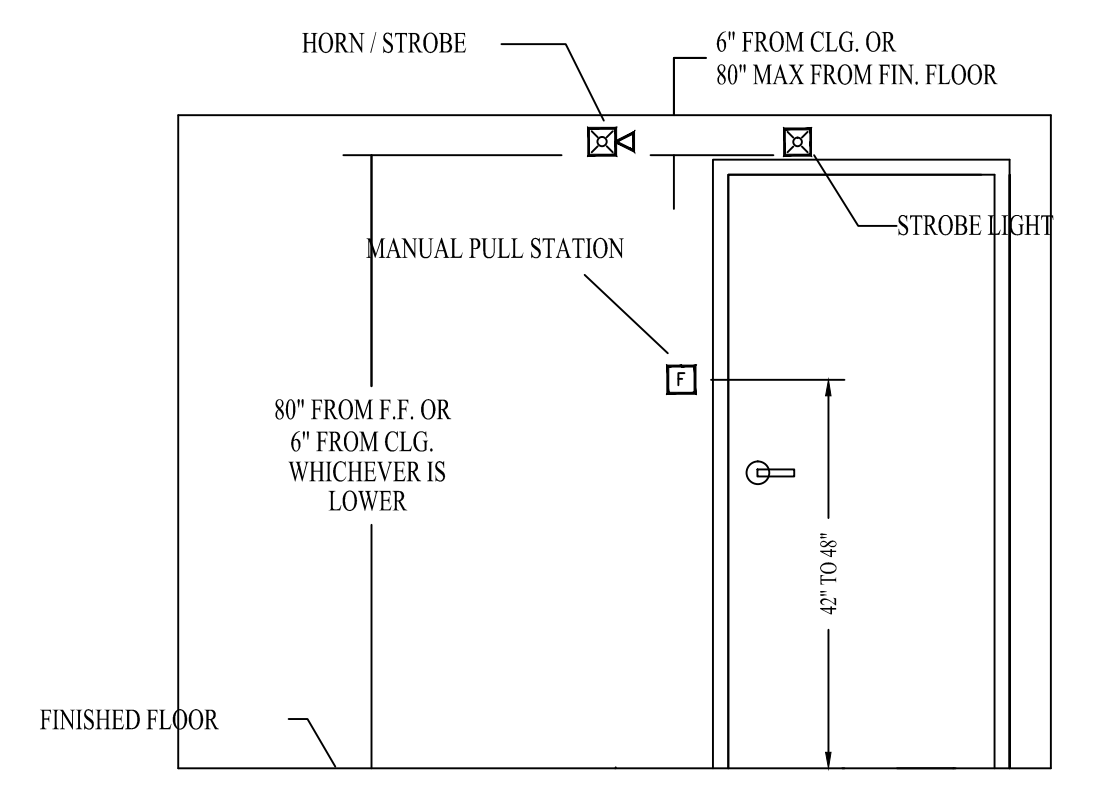

DEVICE ELEVATION DETAIL
NOT TO SCALE

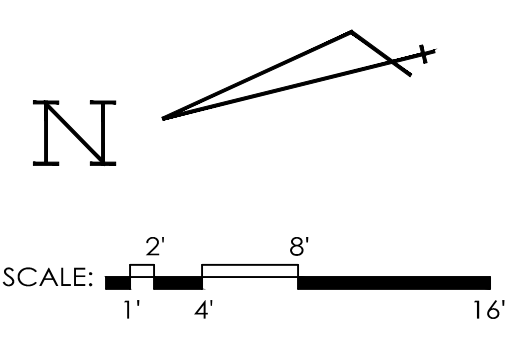

GENERAL NOTES	DATE	REVISIONS	REQUIRED APPROVALS	SAFELITE 421 WARREN AVE PORTLAND, ME 04103 CONTRACT WITH: ELECTRICAL SYSTEMS OF MAINE EASTERN FIRE SERVICES, INC. AUBURN/LEWISTON INDUSTRIAL AIRPARK, AUBURN, MAINE 04210	FIRE ALARM SYSTEM
			OWNER STATE FIRE MARSHAL LOCAL FIRE DEPARTMENT		PLANS & DETAILS
			DRAWN BY CRM		DWG. NO. FA-1
			CHECKED BY BWB CONTRACTOR LICENSE #		JOB NUMBER
				SCALE AS SHOWN	
				DATE 4-26-16	