



DRAWING KEYNOTES


- 1 REMOVE (E) PLUMBING FIXTURES AS INDICATED ON THIS SHEET. SIZING AND ROUTING OF EXISTING PIPING, INCLUDING SANITARY AND DOMESTIC WATER, IS ASSUMED DUE TO LACK OF AS-BUILT DOCUMENTATION. CONTRACTOR SHALL FIELD VERIFY ACTUAL PIPING ROUTES & LINE SIZES IN FIELD. VERIFY THAT (E) SIZES ARE CODE-COMPLIANT.
- 2 CONNECT NEW PLUMBING FIXTURES TO EXISTING PIPING BRANCHES, INCLUDING DOMESTIC WATER, SANITARY DRAINAGE, AND VENT PIPING.

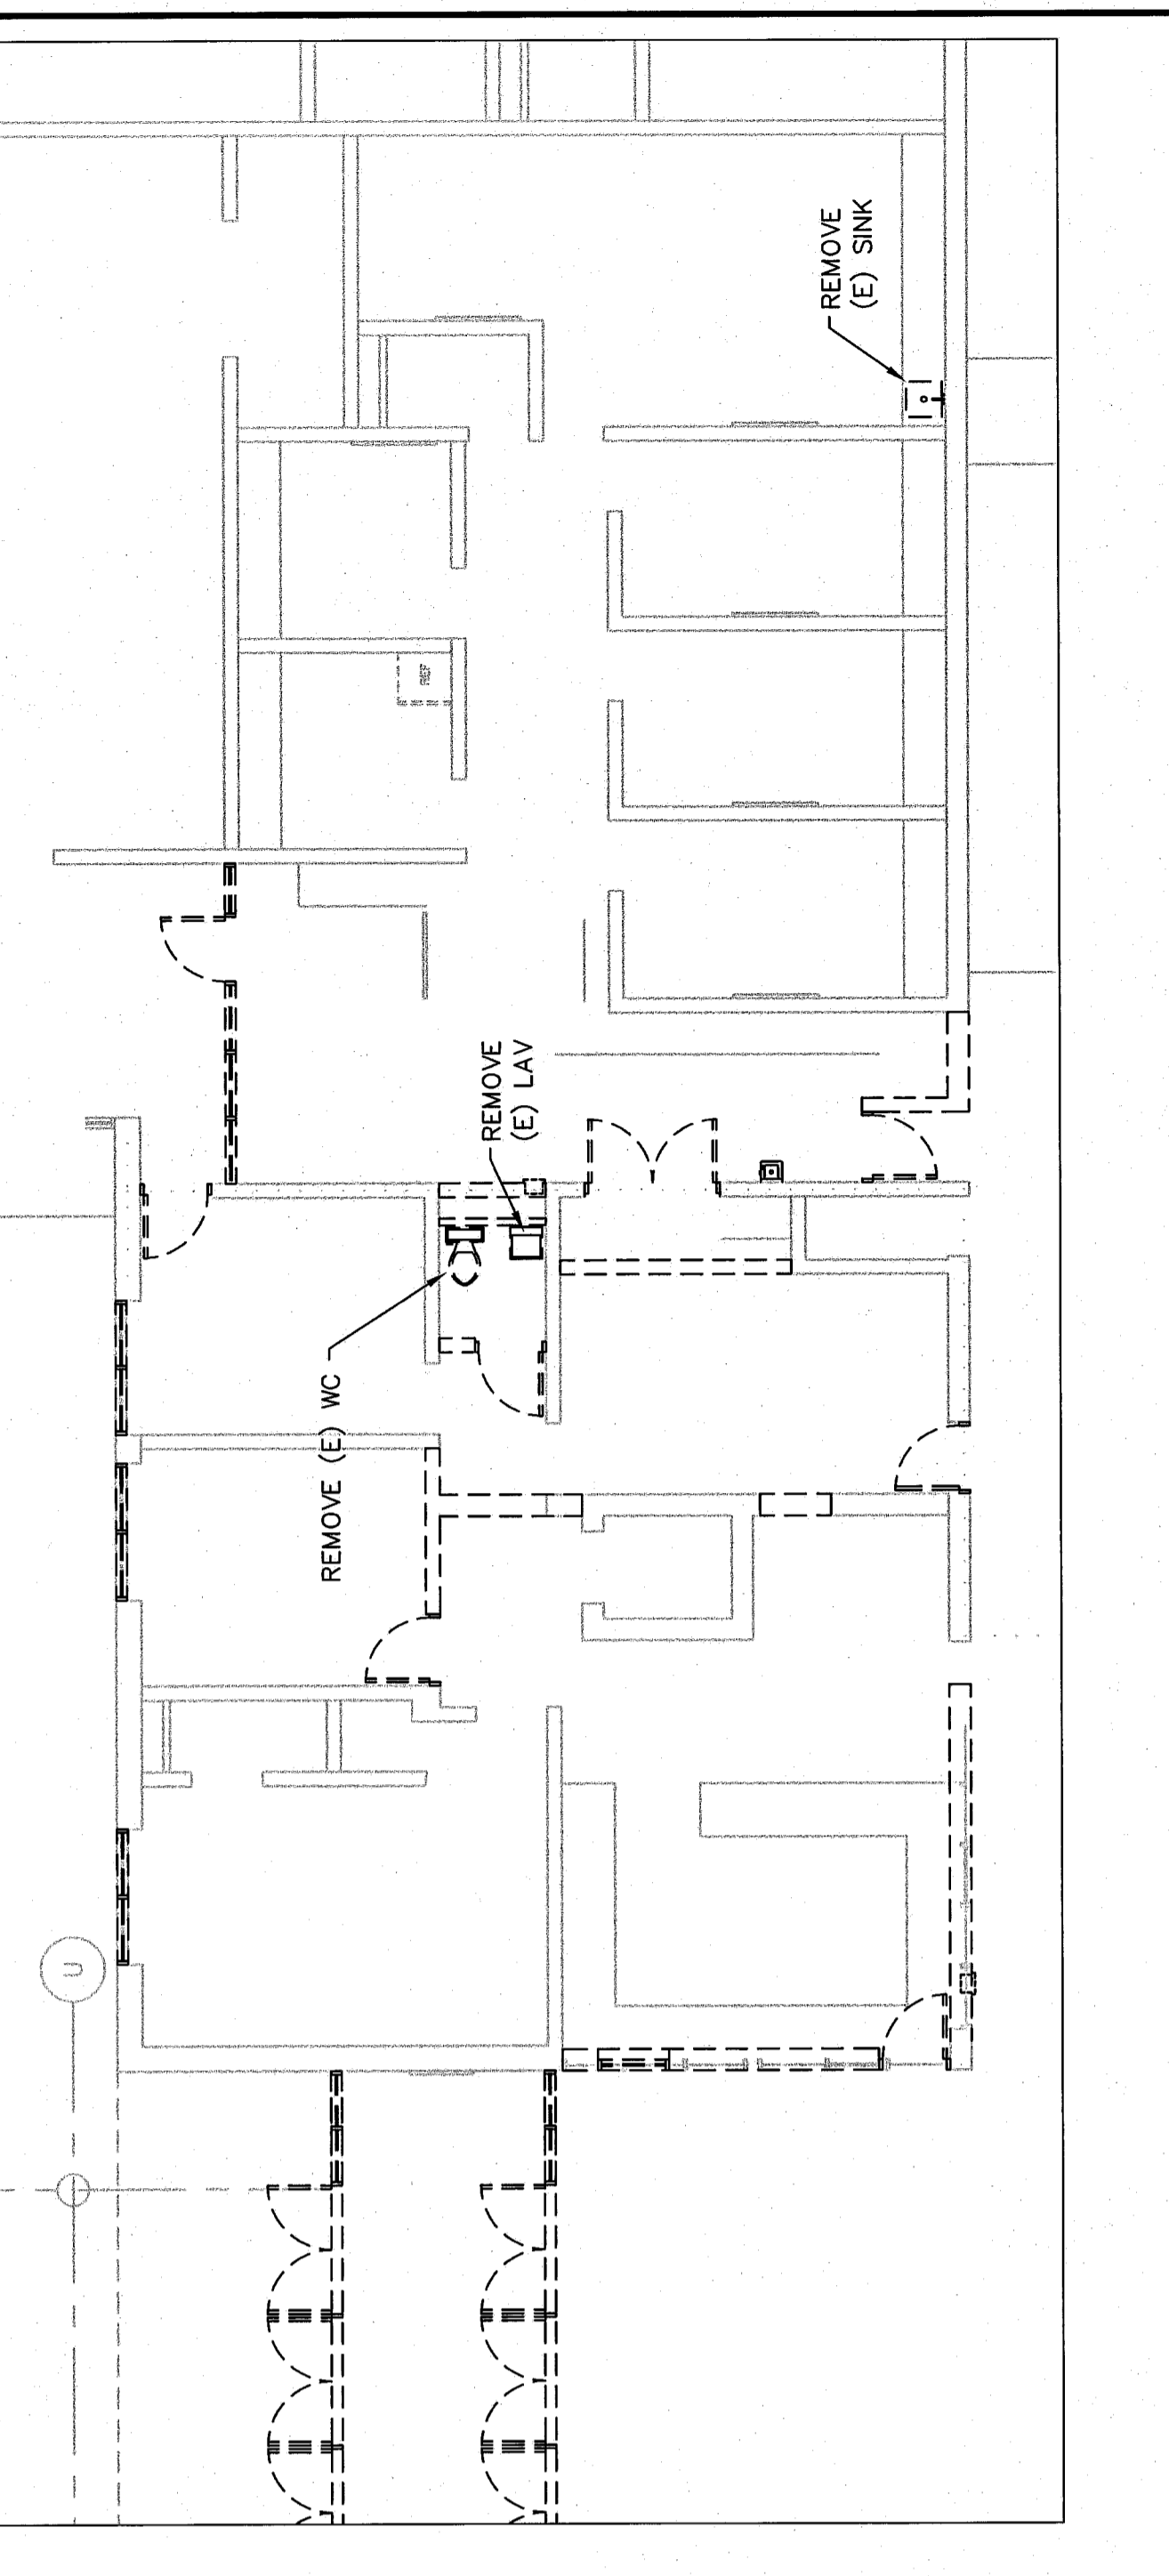


DEMOLITION PART PLAN - ADMIN. RENOVATIONS
 C6
 1/8" = 1'-0"

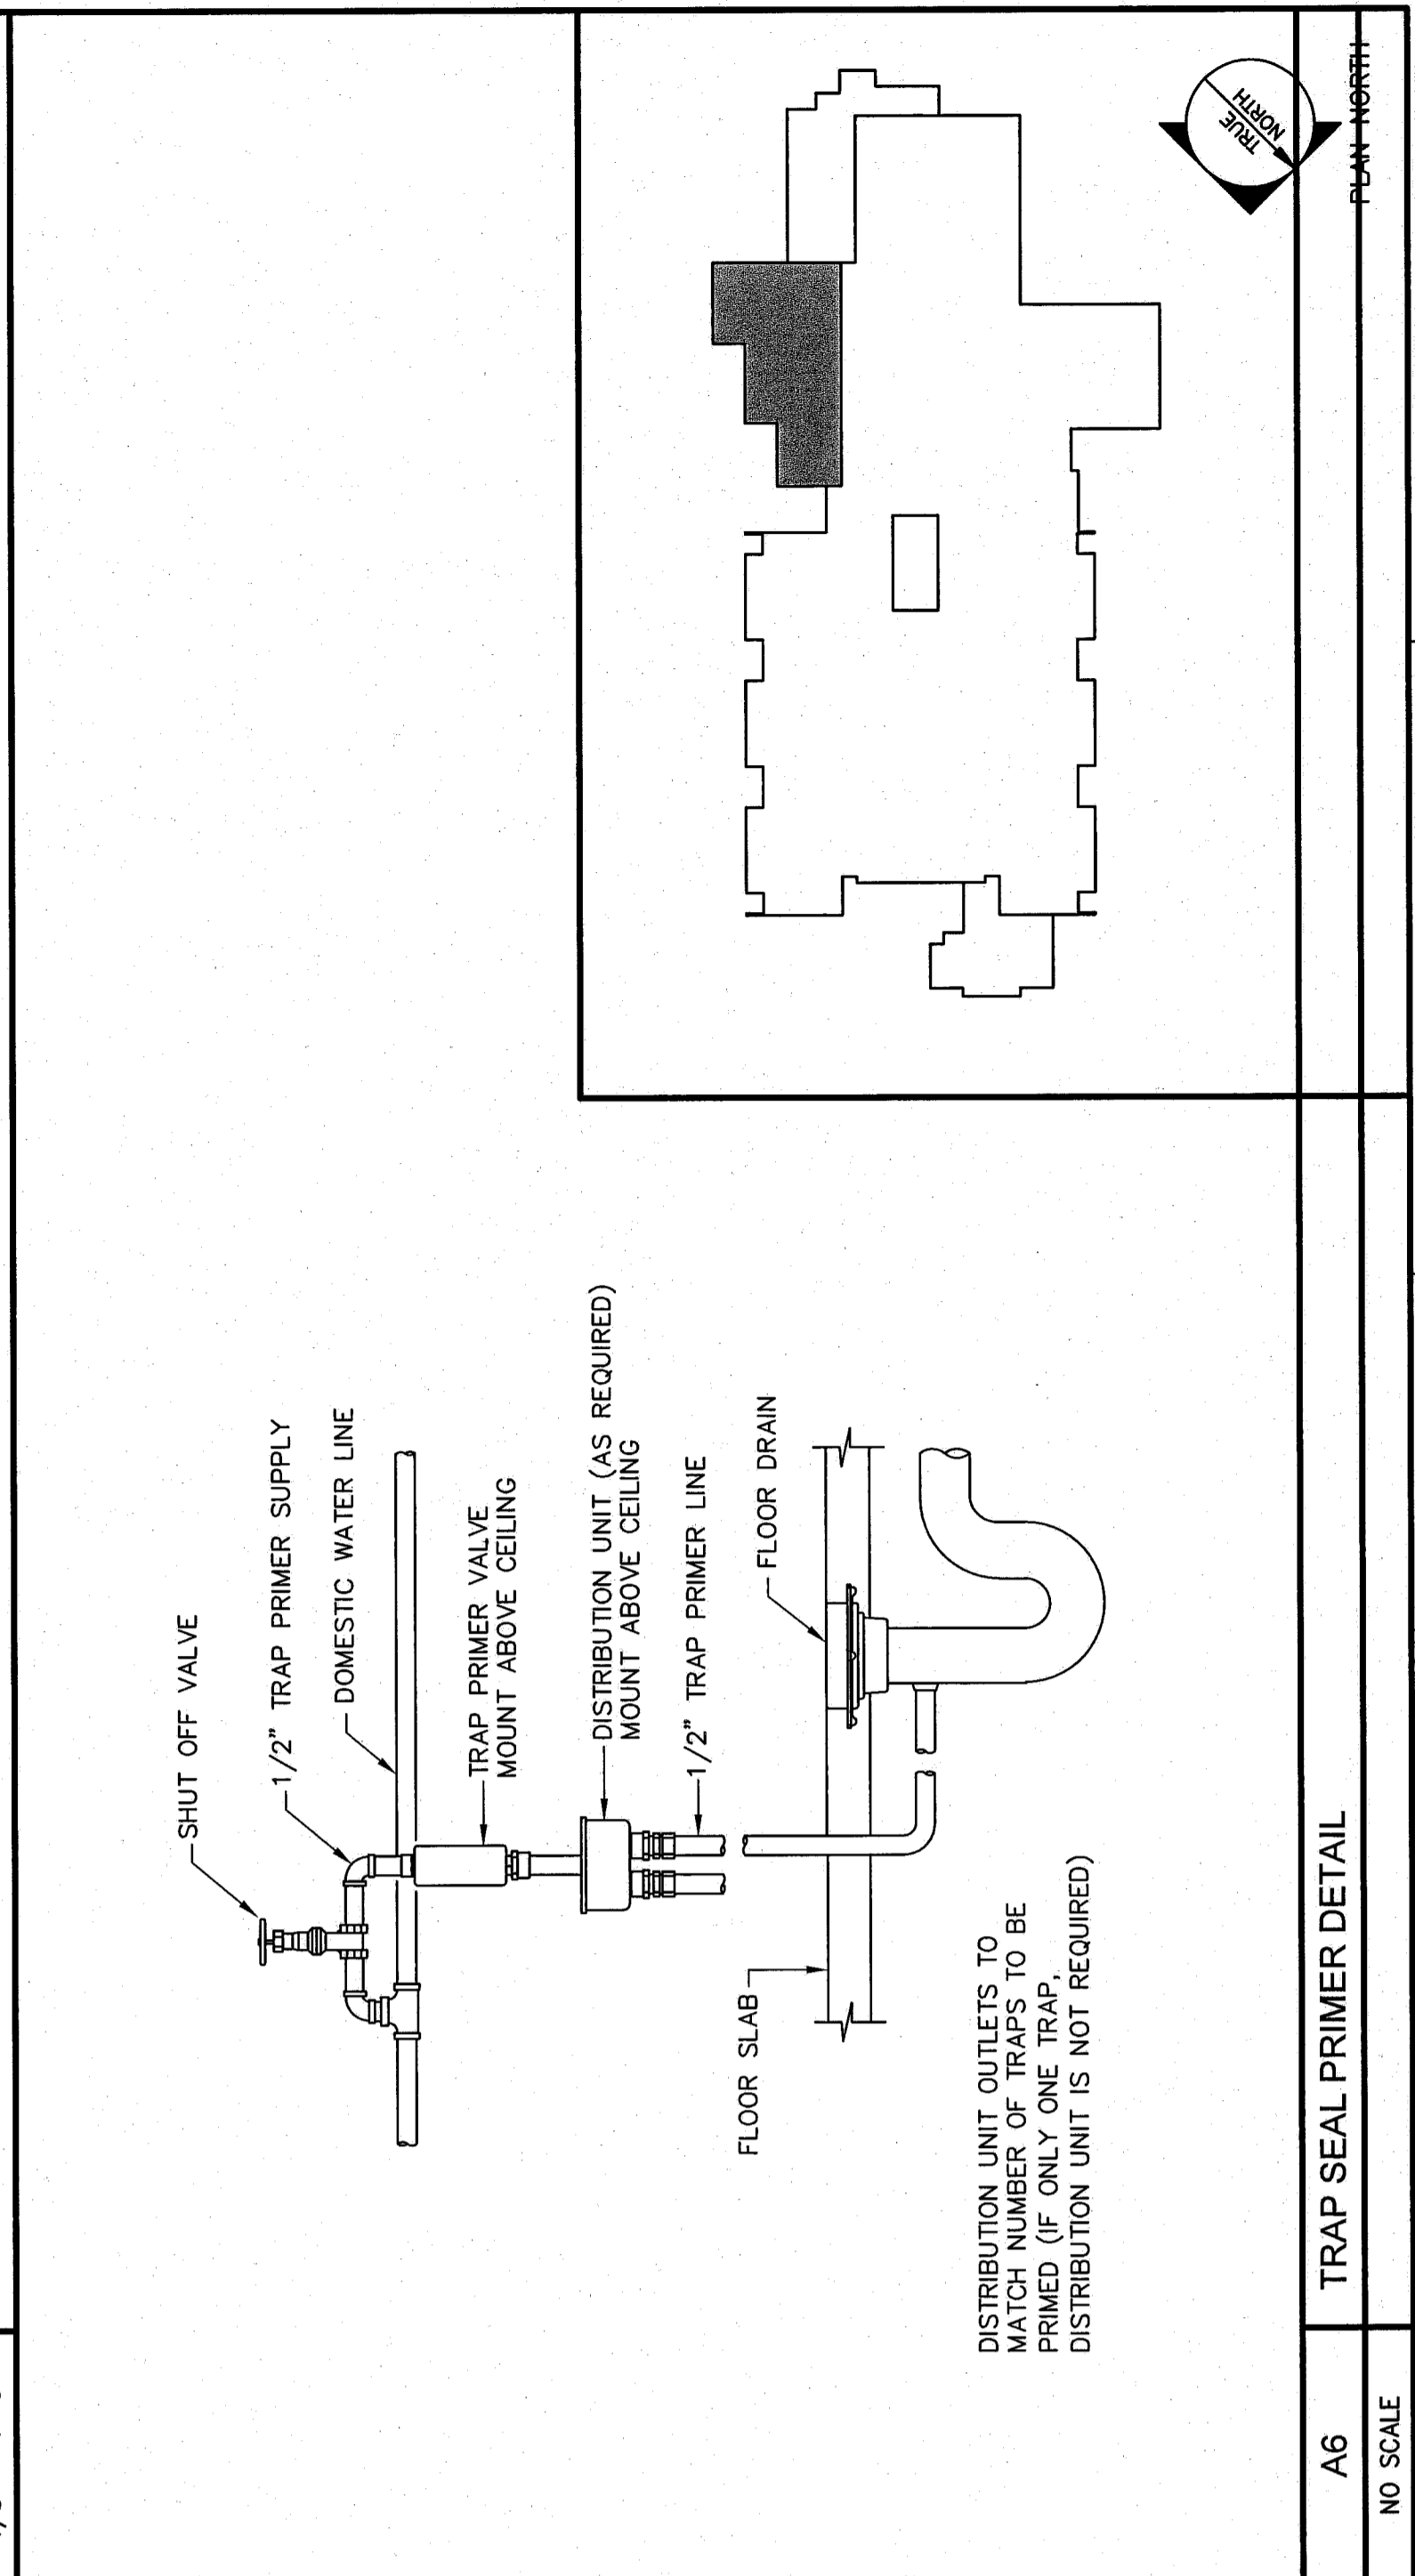

TRAP SEAL PRIMER DETAIL
 A6
 NO SCALE

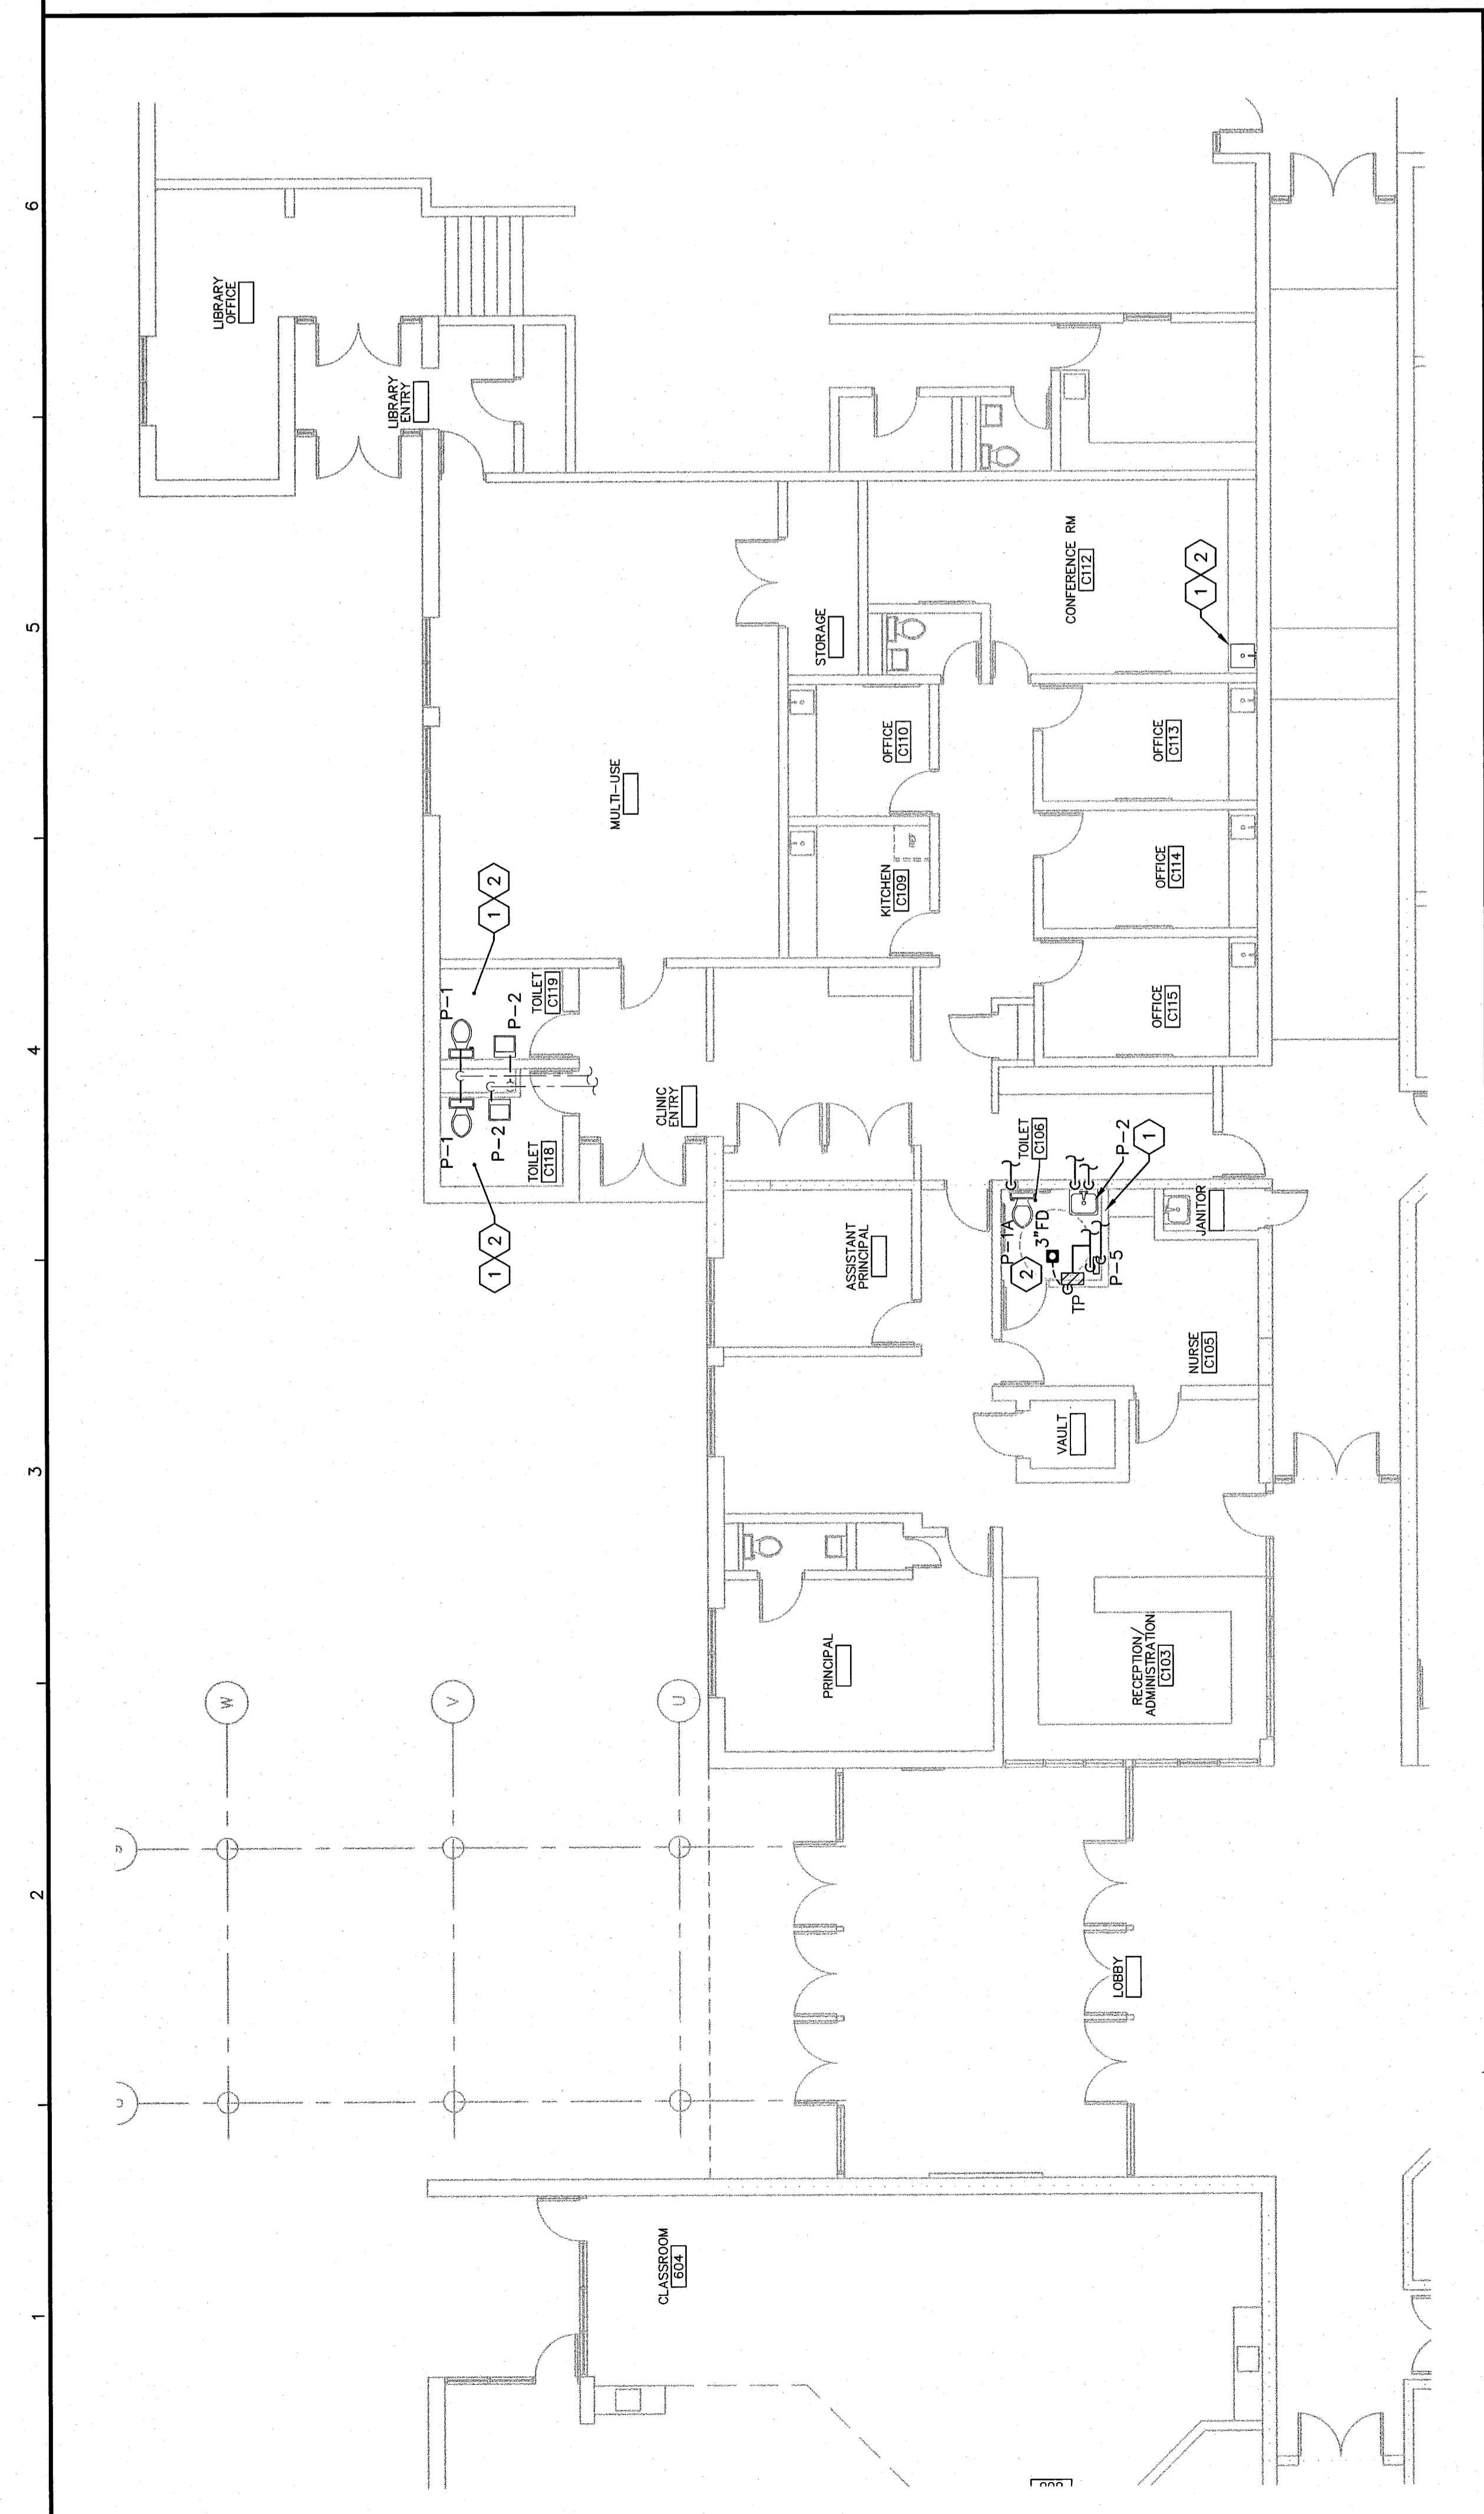

DOMESTIC WATER PIPING PART PLAN - ADMIN. RENOVATIONS
 E1
 1/8" = 1'-0"

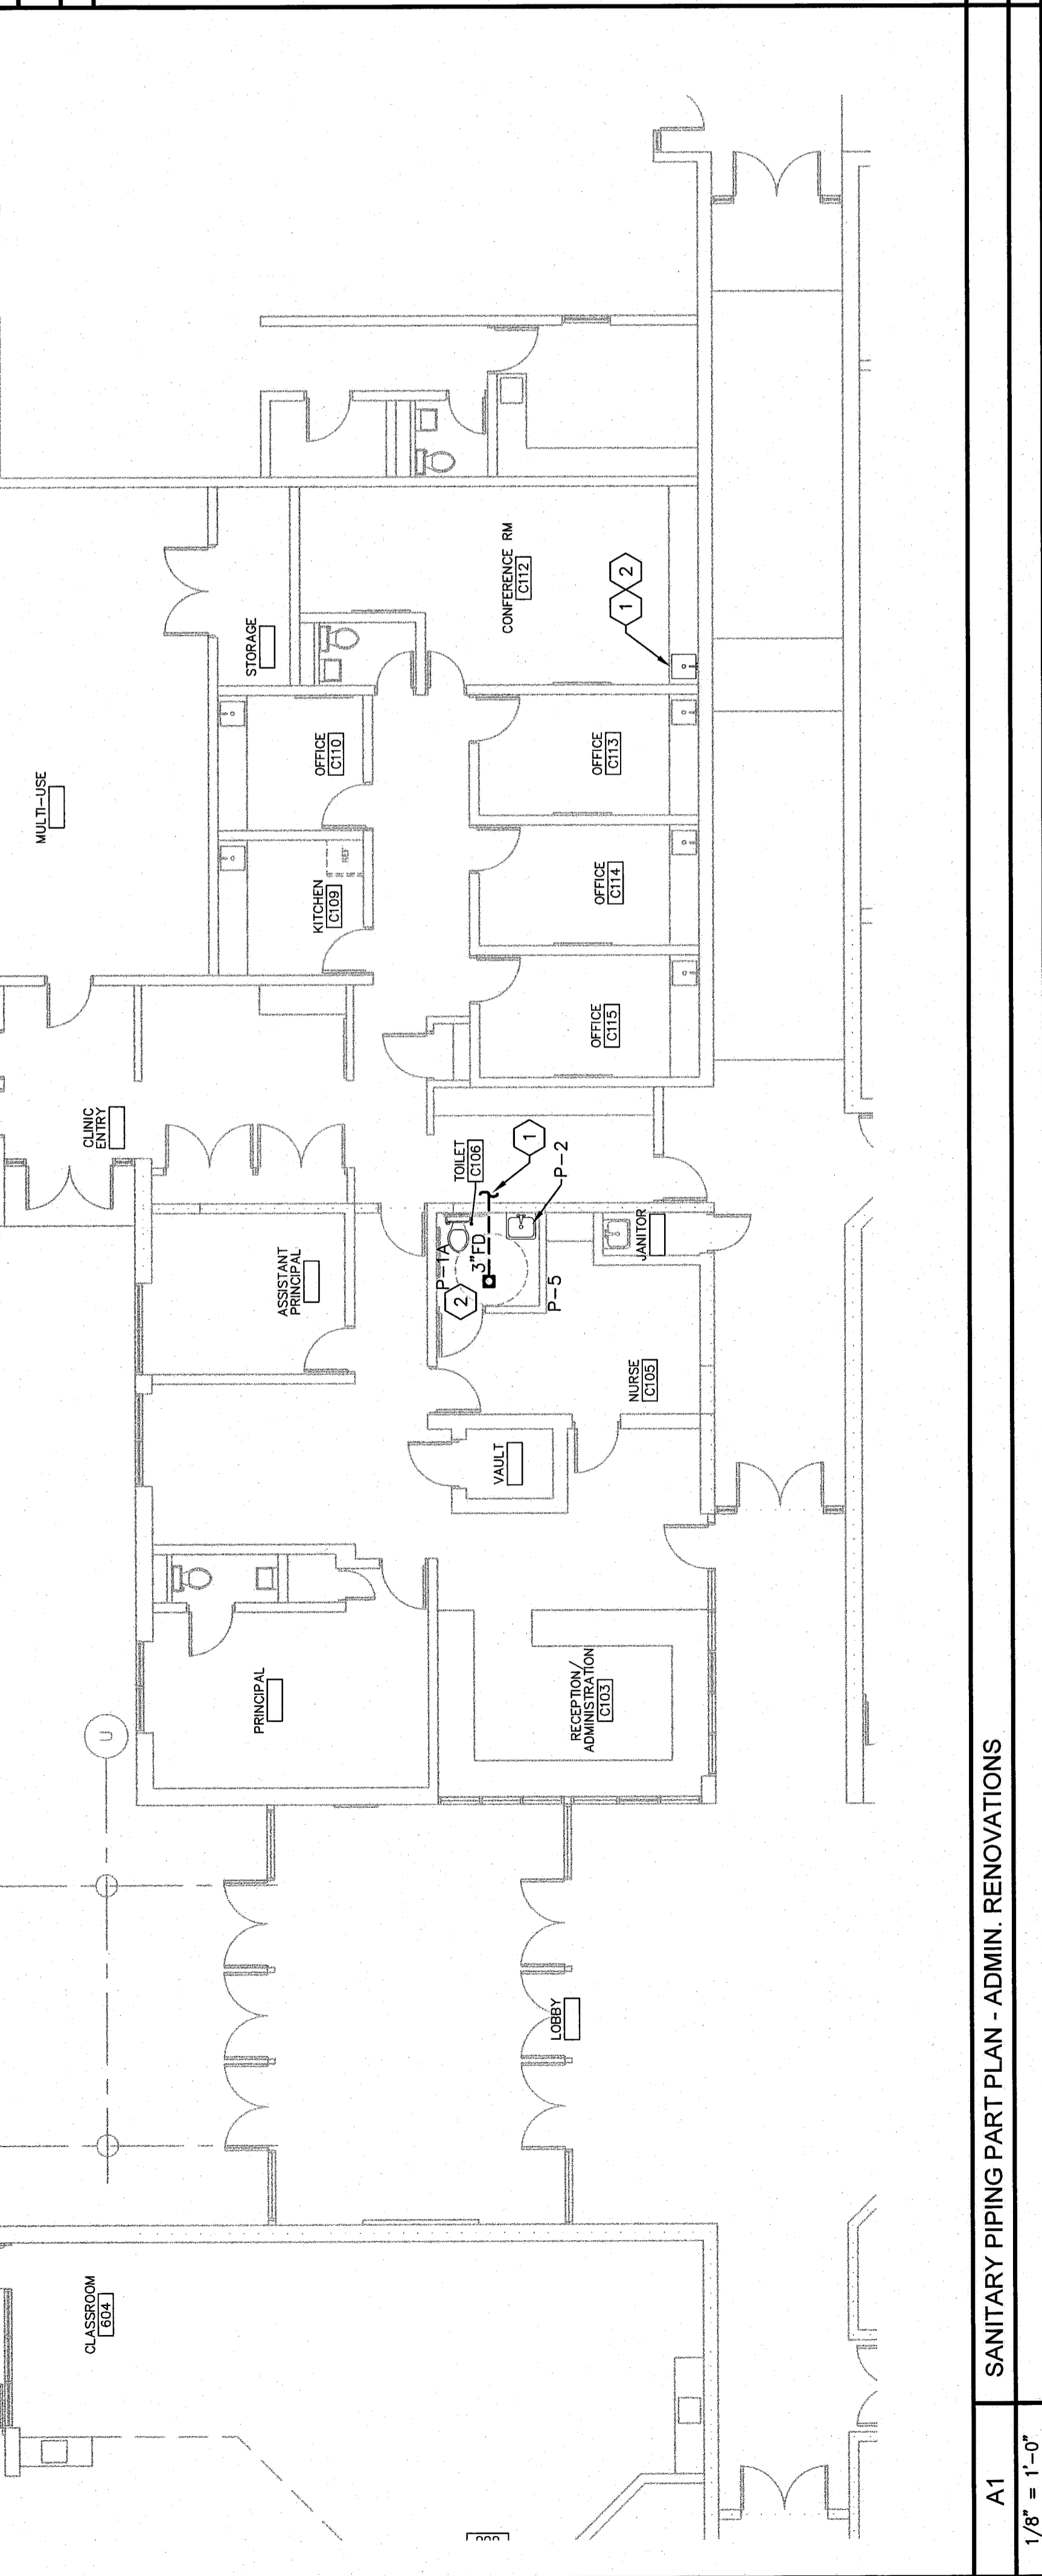

SANITARY PIPING PART PLAN - ADMIN. RENOVATIONS
 A1
 1/8" = 1'-0"