


# FEMA EMERGENCY RADIO NETWORK WGAN PORTLAND, MAINE

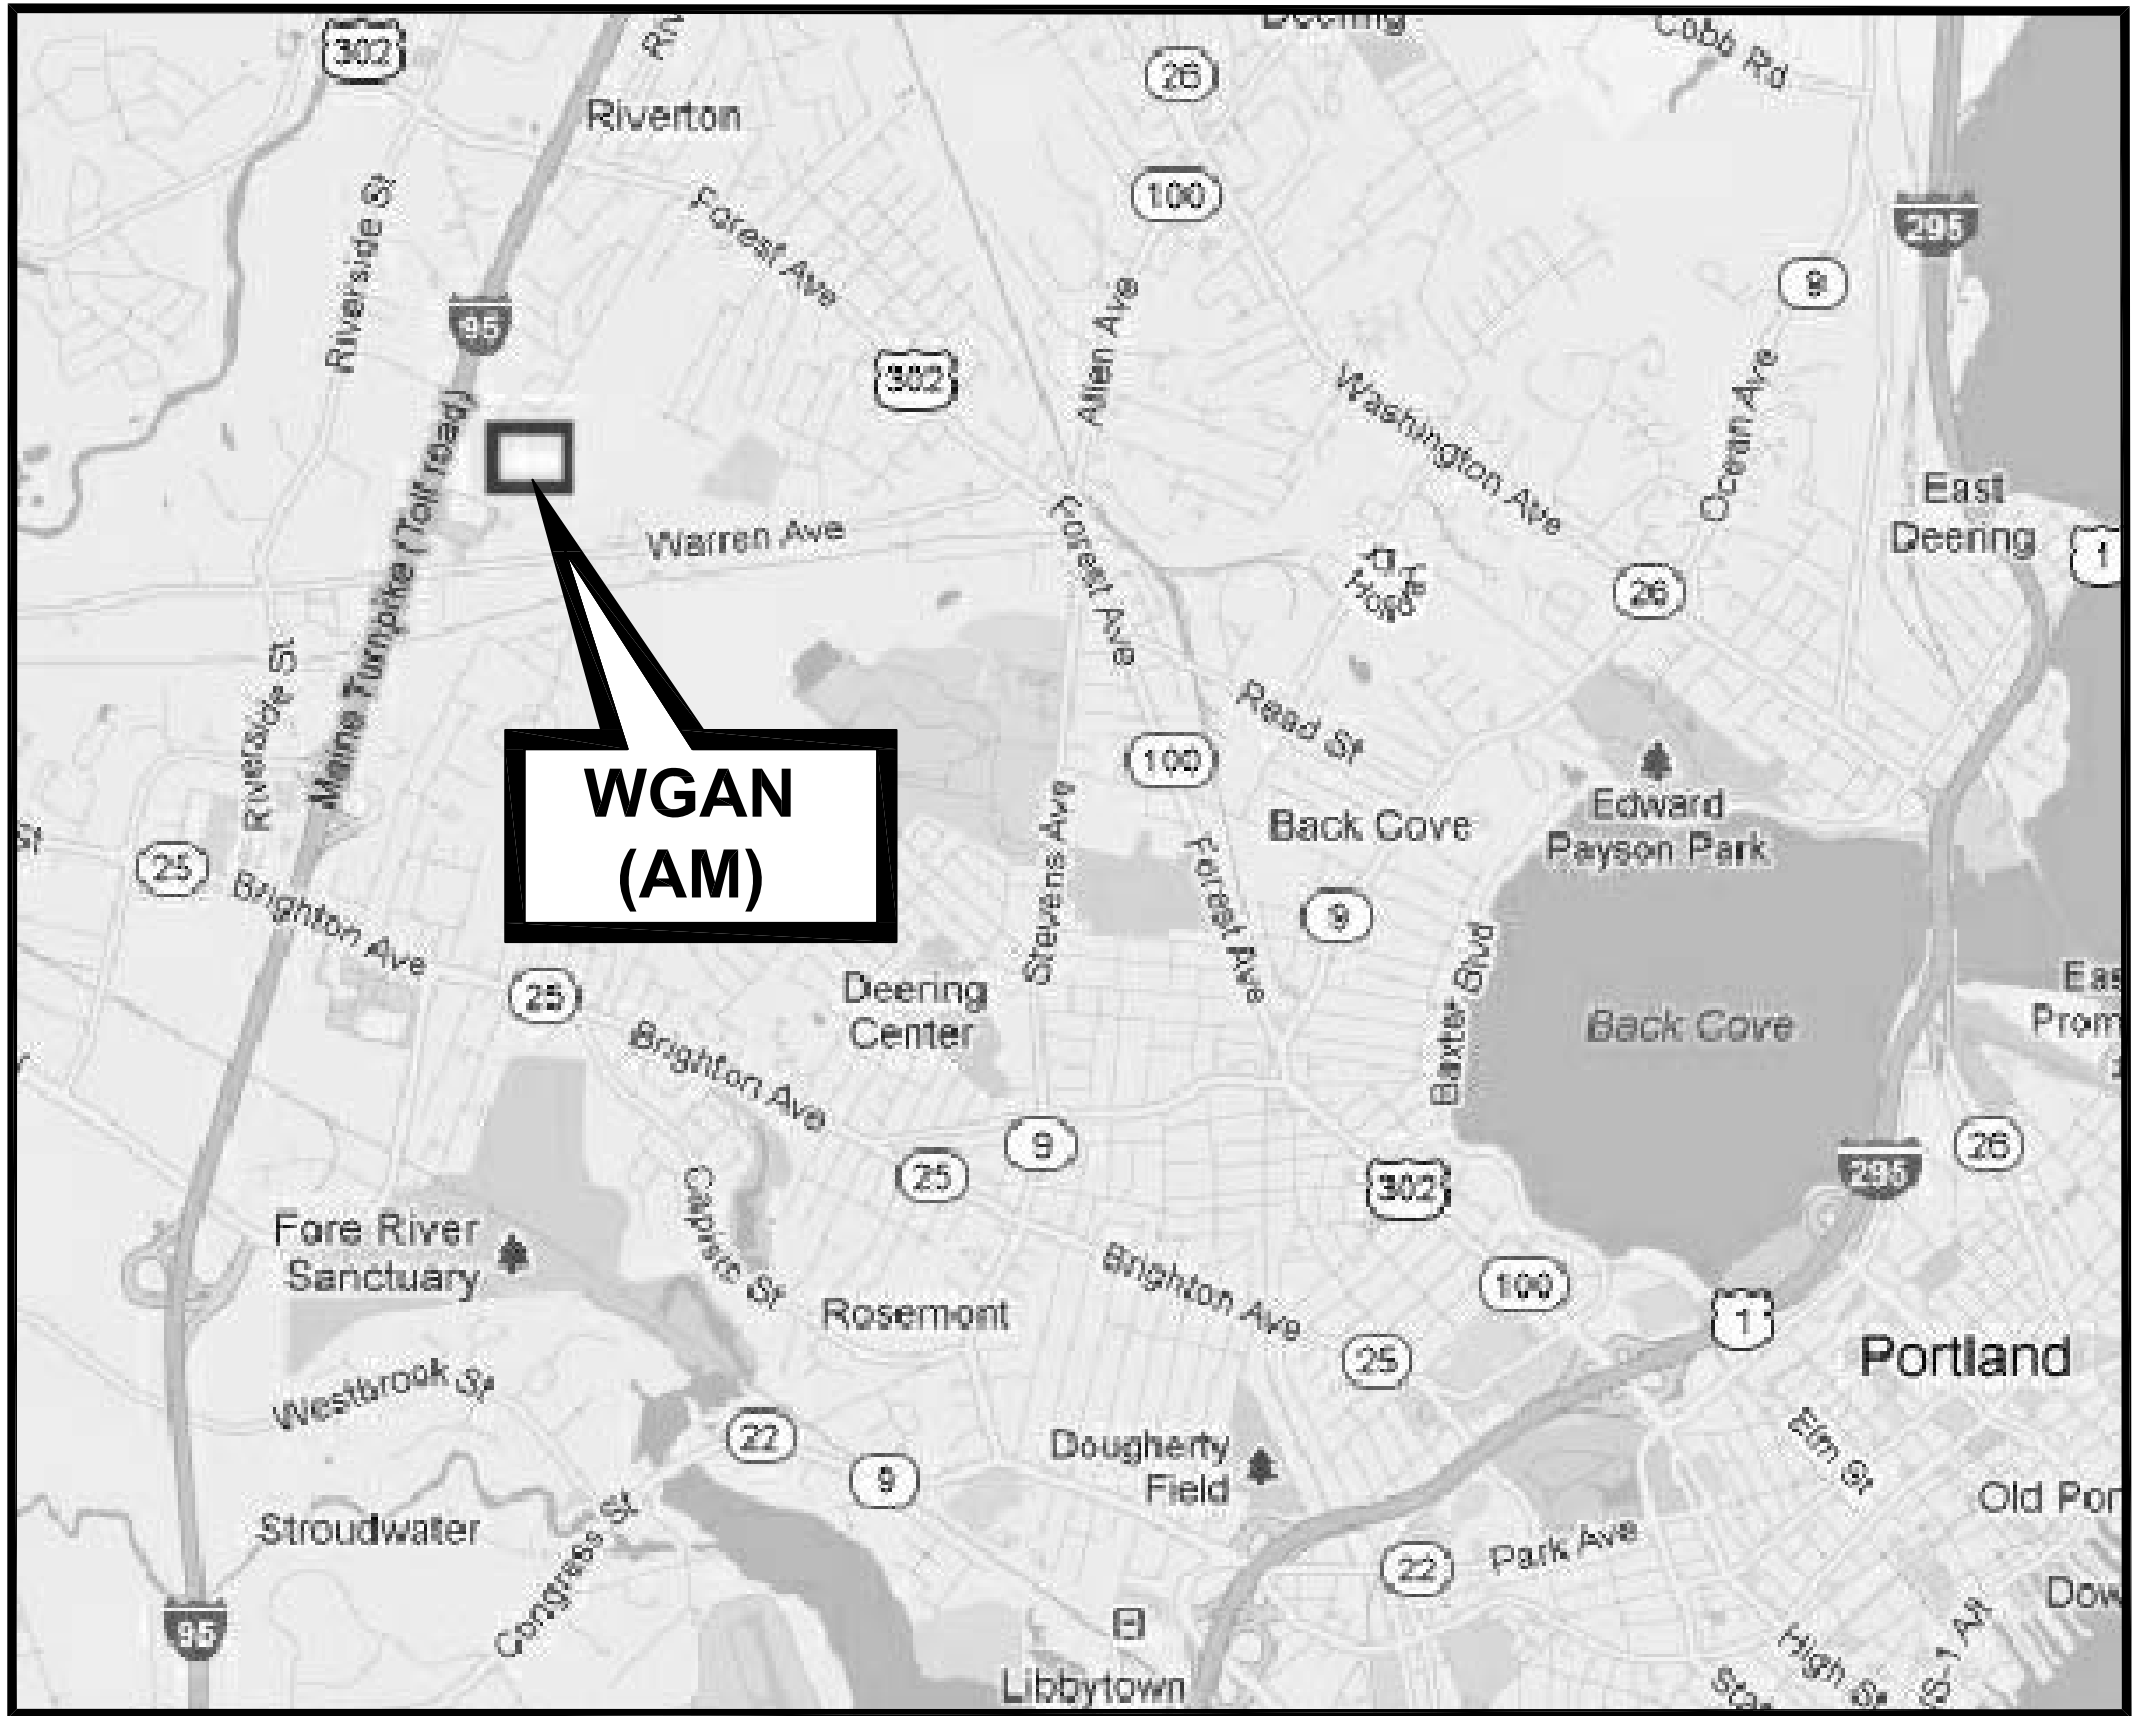

VICINITY MAP

WGAN TRANSMITTER SITE  
236 LANE AVENUE  
PORTLAND, ME 04103  
CUMBERLAND COUNTY



PROJECT AERIAL VIEW  
SEE SITE PLAN, DWG G-101

### INDEX

- G-001 VICINITY MAP AND INDEX
- G-101 SITE PLAN
  
- C-101 STORMWATER MANAGEMENT PLAN
- C-102 CIVIL PLAN
- C-301 CIVIL SECTIONS
  
- S-001 STRUCTURAL GENERAL NOTES
- S-101 FOUNDATION AND FENCE PLAN
- S-102 SITE GENERATOR FOUNDATION PLAN
  
- S-301 MISCELLANEOUS SECTIONS
  
- S-501 MISCELLANEOUS DETAILS
- S-502 SIGN AND FENCE DETAILS
  
- M-101 MECHANICAL PLAN
- M-201 MECHANICAL FUEL SYSTEM ELEVATIONS
- M-501 MECHANICAL FUEL PIPING DETAILS
- M-601 FUEL SYSTEM P&ID
  
- E-101 ELECTRICAL SITE PLAN
- E-102 ELECTRICAL GROUNDING PLAN
- E-103 ELECTRICAL POWER PLAN
- E-104 GROUNDING AND POWER PLAN
- E-105 GROUNDING AND POWER PLAN
  
- E-401 TRANSMITTER / GENERATOR ELECTRICAL PANEL SCHEDULES
- E-402 TRANSMITTER / GENERATOR ELECTRICAL RISER DIAGRAM
- E-403 ELECTRICAL SCHEDULES
- E-404 TRANSMITTER / GENERATOR UPS / TIME DELAY DIAGRAM
  
- E-501 INSTALLATION DETAILS
- E-502 INSTALLATION DETAILS
- E-503 INSTALLATION DETAILS
- E-504 INSTALLATION DETAILS

### REFERENCED BUILDING CODES

- CITY OF PORTLAND TECHNICAL MANUAL 2010
- MAINE UNIFORM BUILDING CODE 2010
- INTERNATIONAL BUILDING CODE 2009
- INTERNATIONAL MECHANICAL CODE 2009
- ASCE 7-05
- NFPA 30, 2008 EDITION
- NATIONAL ELECTRIC CODE, 2008 EDITION
- NFPA 101 LIFE SAFETY CODE, 2009 EDITION



Project Manager	
DC Reviewer	
Architectural	
Structural	
Mechanical	
Plumbing	
Electrical	
Civil	

Mark	0	ISSUED FOR CONSTRUCTION	11/7/12	Date
Agreed				

Designed by	DCB
Drawn by	RAM
Checked by	MLM
Reviewed by	DCB
Date	2012

**FEMA**  
  
**KBR**  
 63 SOUTH ROYAL STREET SUITE 200  
 MOBILE, AL 36602  
 PHONE: (251) 420-7900  
 FAX: (251) 420-7999  
 Engineering Services by  
 KBR Engineering Co., LLC

FEMA EMERGENCY RADIO NETWORK  
ON WGAN PORTLAND, MAINE  
**COVER SHEET**  
**VICINITY MAP AND INDEX**

Drawing Number:  
**G-001**