


1 STATION WGAN - SITE PLAN
 G-001 SCALE: 1"=10'-0"


1"=10' 0' 10' 20' 30' 40' 50'

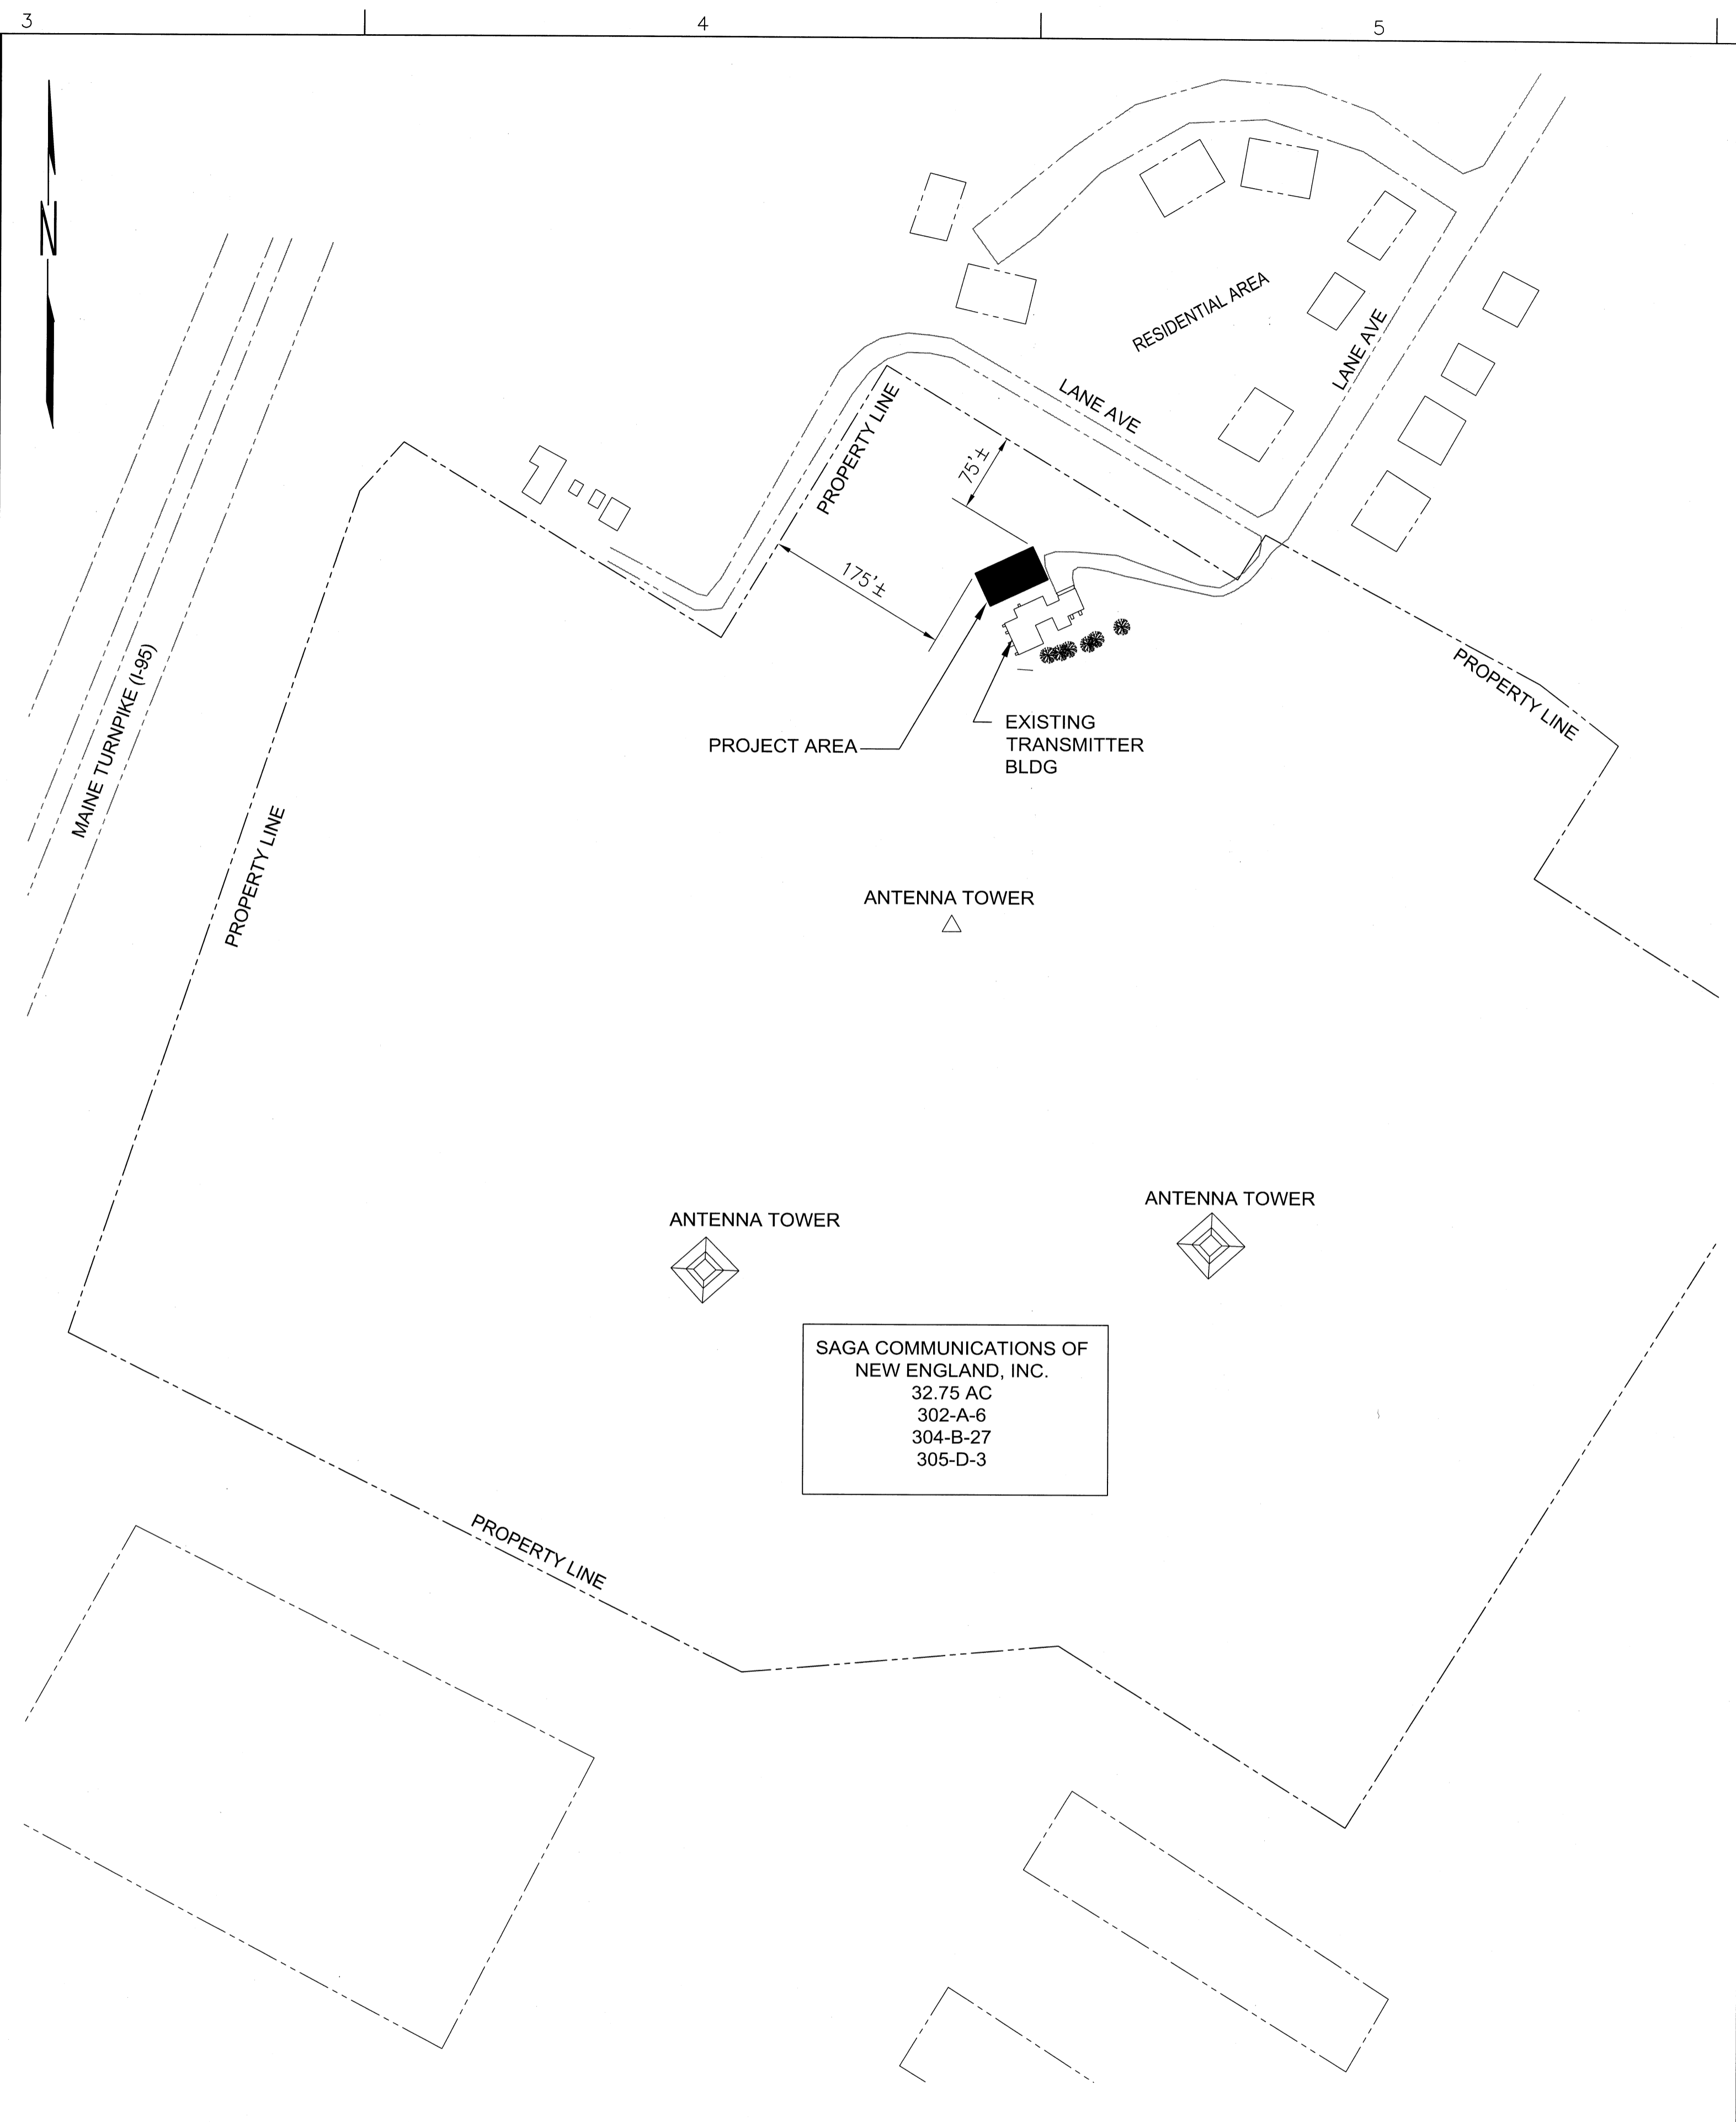

WGAN PROPERTY PLAN
 SCALE: 1"=100'

1"=100' 0' 100' 200' 300' 400' 500'

STATE OF MAINE
 DENSE COUËY
 BROWN
 No. 12959
 REGISTERED
 PROFESSIONAL ENGINEER
 REV 0 11-01-12

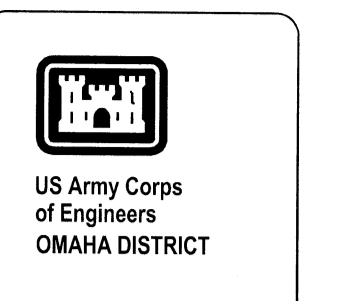

Project Manager	
DC Reviewer	
Architectural	
Structural	
Mechanical	
Electrical	
Civil	

ISSUED FOR CONSTRUCTION	11/7/12	Approved
Work	Date	
Description		

Designed by	DCB
Drawn by	RAM
Checked by	MLM
Reviewed by	DCB
Date	2012

KBR
 63 South Main Street Suite 200
 Woburn, MA 01897
 Phone: (617) 450-7800
 Fax: (617) 450-7898

FEMA
 FEDERAL EMERGENCY MANAGEMENT AGENCY

KBR
 Engineering Services by
 KBR Engineering Co. LLC

FEMA EMERGENCY RADIO NETWORK
 ON WGAN PORTLAND, MAINE

SITE PLAN

Drawing Number:
G-101