



1 SITE GENERATOR FOUNDATION PLAN
 SCALE: 1/4"=1'-0"

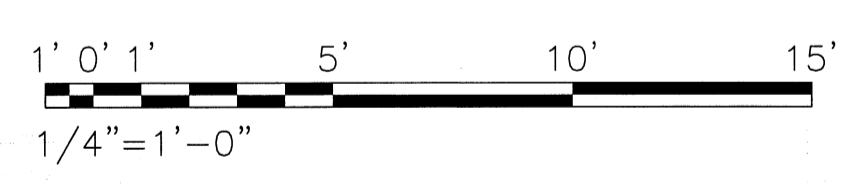

NOTES:

- FOR STRUCTURAL GENERAL NOTES, SEE DWG S-001. FOR CIVIL NOTES, SEE DWG C-102.
- (PS-1) PIPE SUPPORT DESIGNATOR. SEE DWG S-501.
- SEE ELECTRICAL DRAWINGS FOR GROUNDING.

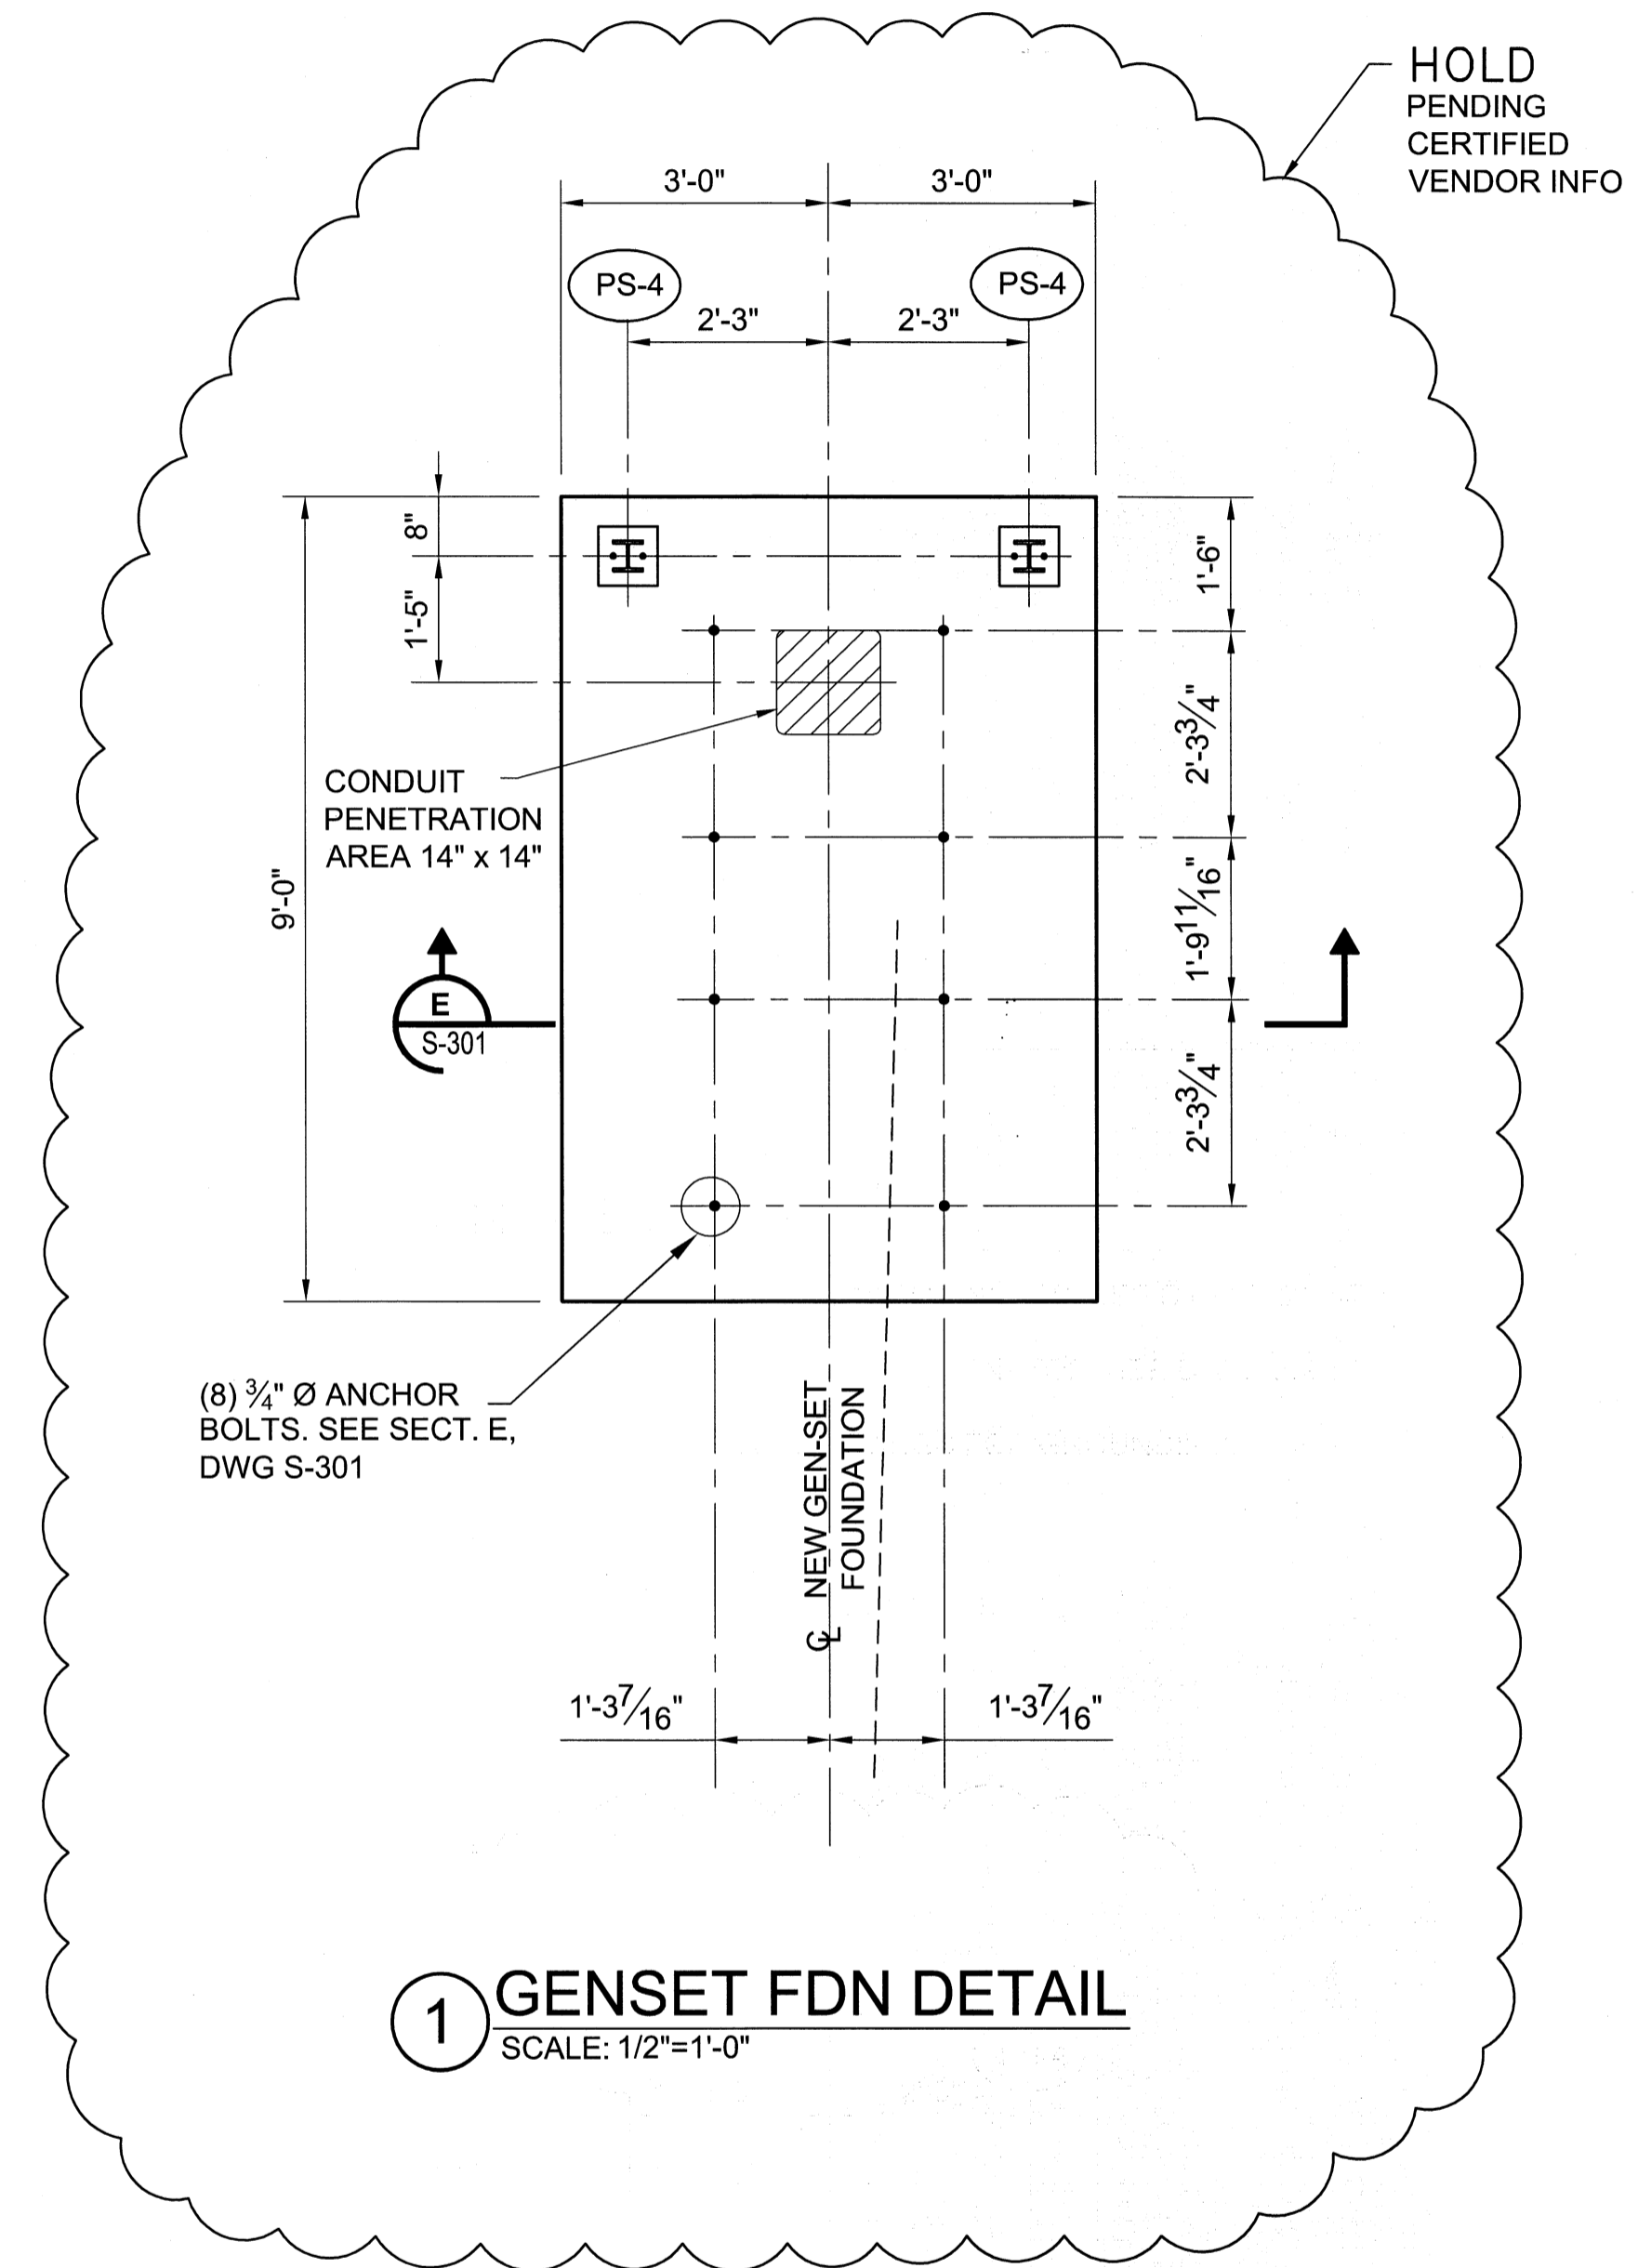

1 GENSET FDN DETAIL
 SCALE: 1/2"=1'-0"

HOLD PENDING CERTIFIED VENDOR INFO




PHASE REVIEW	Project Manager	DC Reviewer	Architectural	Structural	Mechanical	Plumbing	Electrical	Cost

Mark	Description	Date	By
0	ISSUED FOR CONSTRUCTION	11/7/12	Agard

Designed by:	DCB
Checked by:	MLM
Drawn by:	RAM
Reviewed by:	CHB
Date:	2012

KBR
 63 SOUTH ROYAL STREET SUITE 200
 PORTLAND, ME 04106
 PHONE: (207) 400-7600
 FAX: (207) 400-7888

FEMA
 ENGINEERING SERVICES BY
 KBR ENGINEERING CO., LLC

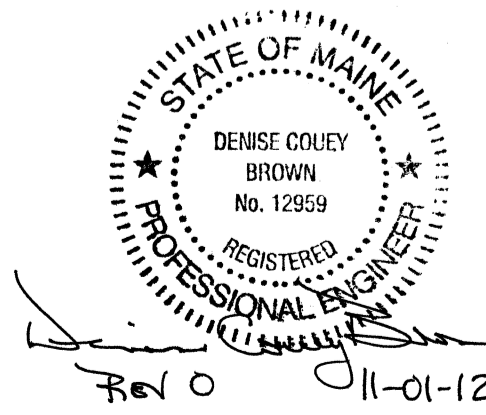

FEMA EMERGENCY RADIO NETWORK
 ON WGAN PORTLAND, MAINE

SITE GENERATOR FOUNDATION PLAN

Drawing Number:
S-102

REV 0 11-01-12