

FIRE ALARM LEGEND

Symbol	Description
	Smoke Detector
	Smoke Detector - local
	Combination Smoke/CO Detector
	Combination Smoke/CO Detector - local
	Heat Detector - rate of rise
	Heat Detector - fixed
	CO Detector
	Pull Station - dual action
	Pull Station - weather proof
	Horn/Strobe Unit
	Horn/Strobe Unit - weather proof
	Low Frequency Sounder
	Strobe Only Unit
	Exterior Beacon
	Monitor Module
	Flow Switch
	Tamper Switch
	Pressure Switch
	Power Supply
	Fire Alarm Control Panel
	Annunciator
	Fire Alarm Sprinkler Bell
	Remote Test Station
	Remote Alarm Indicator
	Key Box
	Control Module
	Master Box

FIRE ALARM GENERAL NOTES

1. FIRE ALARM INSTALLATION SHALL COMPLY WITH ALL LOCAL CODES AND REGULATIONS AND BE INSTALLED ACCORDING TO MANUFACTURERS INSTRUCTIONS.
2. ALL FIRE ALARM RACEWAY SIZES AND CIRCUITRY REQUIREMENTS SHALL BE IN ACCORDANCE WITH APPLICABLE CODES AND MANUFACTURERS RECOMMENDATIONS
3. PROVIDE 120V 20A DEDICATED CIRCUIT TO CONTROL PANELS, POWER SUPPLIES, ETC AS NEEDED. CIRCUIT BREAKERS SHALL BE EQUIPPED WITH LOCKS TO PREVENT ACCIDENTAL SHUT OFF AND BE CLEARLY MARKED "FIRE ALARM CIRCUIT"
4. WIRING SHALL BE COLOR CODED ACCORDING TO ALL APPLICABLE CODES AND SHALL BE MAINTAINED THROUGHOUT THE ENTIRE SYSTEM
5. ALL WIRING SHALL BE CHECKED AND TESTED TO ENSURE THERE ARE NO OPEN OR GROUND CONDITION PRIOR TO ENERGIZING SYSTEM
6. ALL STROBES SHALL BE SYNCHRONIZED AT THE END OF CONSTRUCTION
7. SMOKE DETECTORS HEADS SHALL NOT BE INSTALLED UNTIL AFTER THE CONSTRUCTION CLEANUP OF ALL TRADES IS COMPLETE AND FINAL IN ACCORDANCE WITH NFPA 72

PREPARED AND APPROVED BY
GARY J. EMOND
NICET LEVEL IV
SET #74053

DEAN & ALLYN, INC.
116 Lewiston Road
Gray, ME

NO.	REVISION/ISSUE	DATE
-	-	-
-	-	-

PROJECT NAME
BJ'S WHOLESALE
PORTLAND, ME

FILE
BJ WHOLESALE.DWG

DRAWN BY
B. G.

DATE
NOVEMBER 19, 2014

CHECKED BY
G. E.


DATE
NOVEMBER 19, 2014

SCALE
N/A

SHEET

FA-0

PAGE 1 OF 3

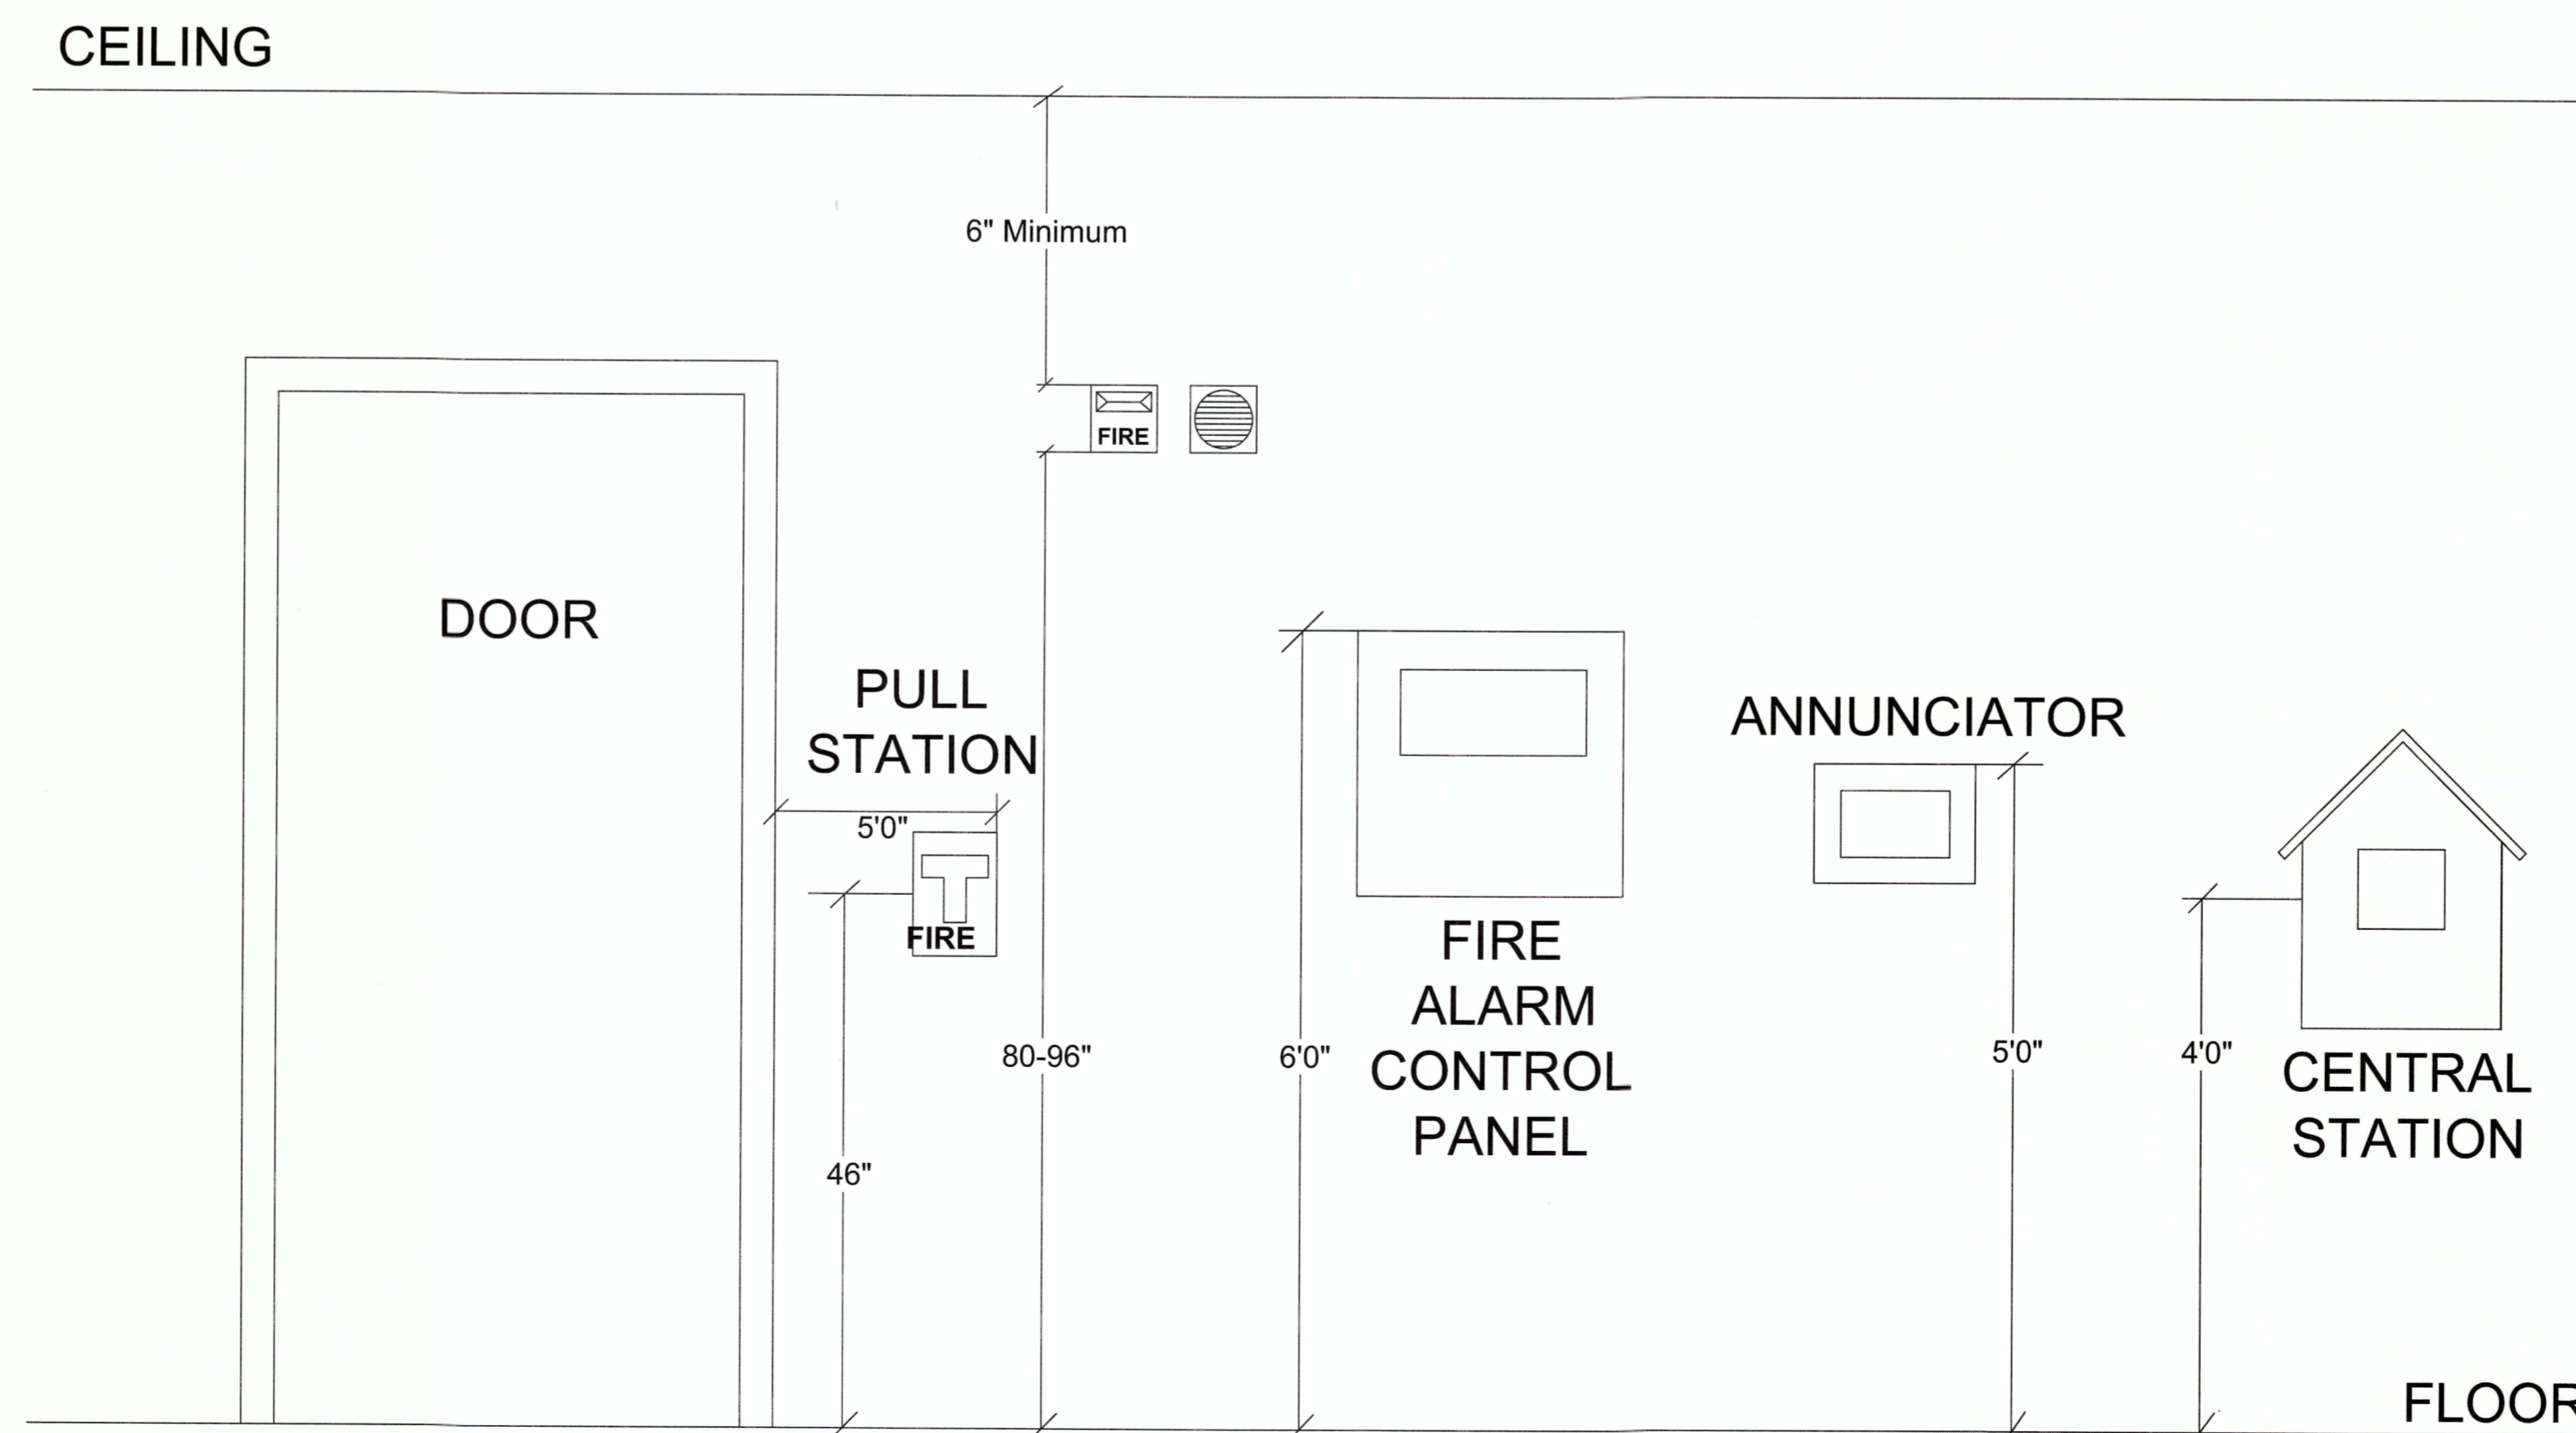

EXAMPLE OF FIRE ALARM DEVICE MOUNTING HEIGHTS