


City Of Portland Portland Public Schools - Central Kitchen

PORTLAND, MAINE

ALLIED PROJECT No. 13001

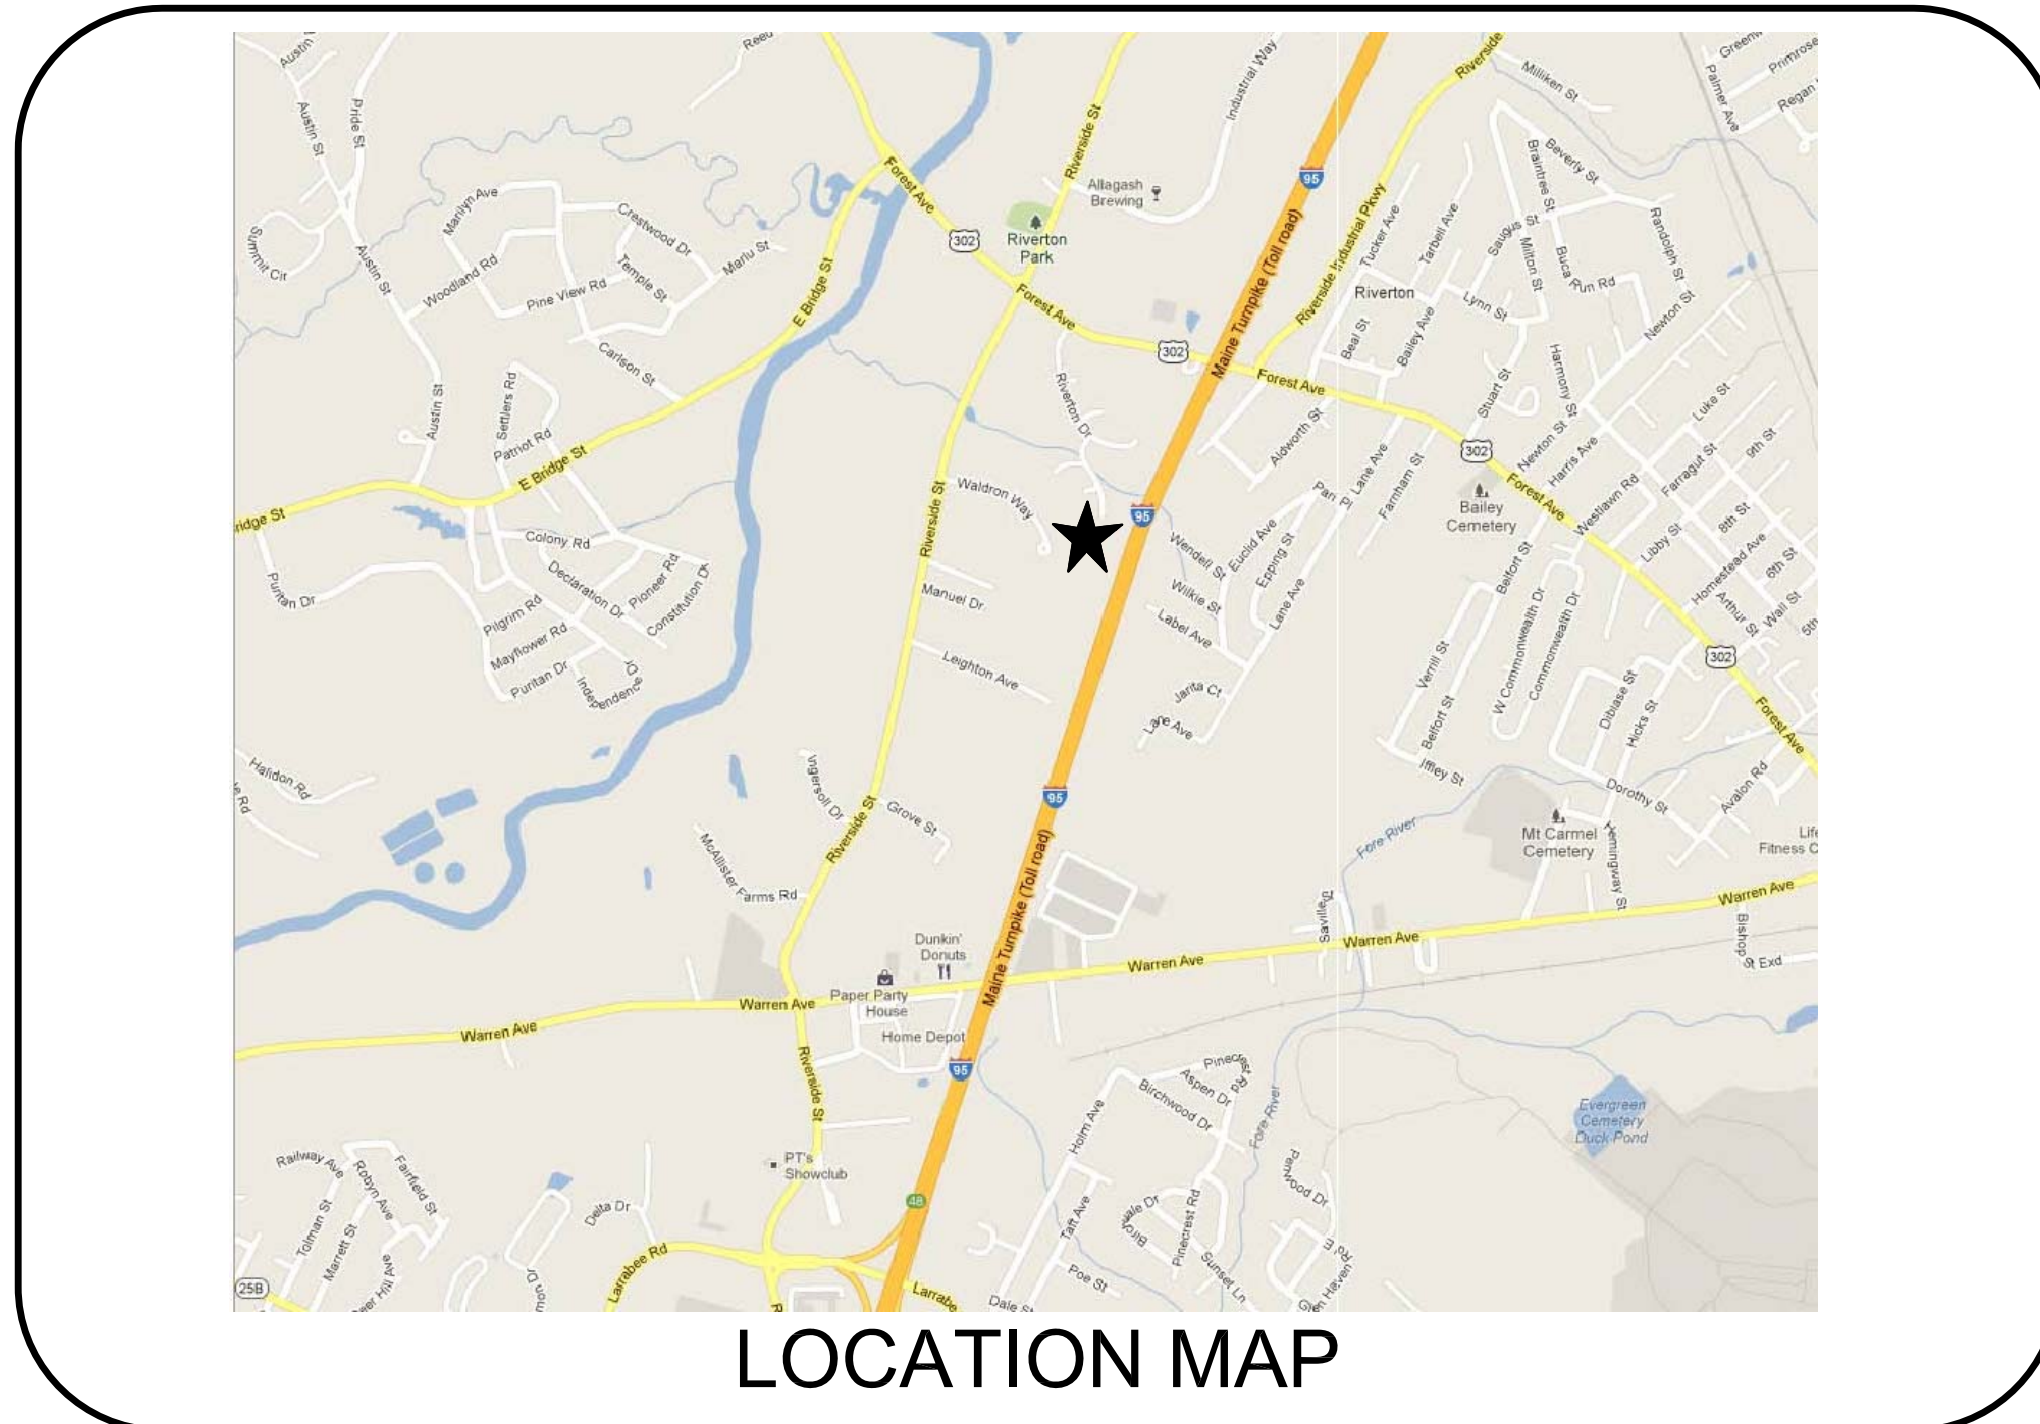


**ISSUED FOR CONSTRUCTION
03-20-2013**

DRAWING		ISSUE	DATE		
STATUS LIST			ISSUED FOR BID	80% REVIEW SET	100% REVIEW SET
DRAWINGS		ISSUED FOR CONSTRUCTION			
Sht No.	SHEET TITLE				
*	COVER SHEET				
AD-100	ARCHITECTURAL - DEMOLITION PLAN				
A-000	ARCHITECTURAL - CODE COMPLIANCE PLAN				
A-100	ARCHITECTURAL - FLOOR PLAN				
A-101	ARCHITECTURAL - ENLARGED PARTIAL FLOOR PLAN				
A-300	ARCHITECTURAL - WALL SECTIONS AND TYPES				
A-400	ARCHITECTURAL - DOOR TYPES AND SCHEDULES				
A-500	ARCHITECTURAL - DETAILS				
SD-100	STRUCTURAL - DEMOLITION PLAN				
SB-100	STRUCTURAL - SLAB PLAN AND DETAILS				
SF-100	STRUCTURAL - FRAMING PLAN AND DETAILS				
FS-1	FOODSERVICE EQUIPMENT FLOOR PLAN				
FS-2	FOODSERVICE EQUIPMENT MECHANICAL SCHEDULE				
FS-3	FOODSERVICE EQUIPMENT ELECTRICAL CONNECTION PLAN				
FS-4	FOODSERVICE EQUIPMENT PLUMBING CONNECTION PLAN				
FS-5	FOODSERVICE EQUIPMENT WALL PLAN, EXISTING AND NEW				
FS-6	FOODSERVICE EQUIPMENT DETAILS AND ELEVATIONS				
FS-7	FOODSERVICE EQUIPMENT DETAILS AND ELEVATIONS				
FS-8	FOODSERVICE EQUIPMENT DETAILS AND ELEVATIONS				
FS-9	FOODSERVICE EQUIPMENT EXHAUST HOOD DETAILS				
FS-10	FOODSERVICE EQUIPMENT EXHAUST HOOD DETAILS				
FS-11	FOODSERVICE EQUIPMENT EXHAUST HOOD DESIGN NOTES				
FS-12	FOODSERVICE EQUIPMENT FLIGHT-TYPE DISHWASHER DETAIL				
FS-13	FOODSERVICE EQUIPMENT WALK-IN COOLER DETAILS				
FS-14	FOODSERVICE EQUIPMENT WALK-IN COOLER DETAILS				
FS-15	FOODSERVICE EQUIPMENT WALK-IN COOLER DETAILS				
FS-16	FOODSERVICE EQUIPMENT REFRIGERATION RACK DETAILS				
PL-000	PLUMBING AND HVAC ABBREVIATIONS AND LEGEND				
PD-100	PLUMBING - DEMOLITION PART PLAN				
PL-100	PLUMBING - OVER ALL PLAN				
PL-101	PLUMBING KITCHEN PART PLAN - UNDER SLAB PIPING				
PL-102	PLUMBING KITCHEN PART PLAN - SANITARY PIPING				
PL-103	PLUMBING KITCHEN PART PLAN - DOMESTIC PIPING				
PL-500	PLUMBING - SCHEDULES, DETAILS AND NOTES				
MD-100	MECHANICAL - DEMOLITION PART PLAN				
MH-100	MECHANICAL - OVER ALL PLAN				
MH-101	MECHANICAL - PART PLAN				
MH-500	MECHANICAL - SCHEDULES, DETAILS AND NOTES				
E-100	ELECTRICAL - OVERALL BUILDING AND FIRE ALARM PLAN				
E-101	ELECTRICAL - LIGHTING PLAN				
E-102	ELECTRICAL - POWER AND SYSTEMS PLAN				
E-103	ELECTRICAL - RISER DIAGRAMS AND DETAILS				
E-104	ELECTRICAL - SCHEDULES				



TJM Consulting, Inc.
Foodservice Consultant
273 Main Street, Suite 5
Yarmouth, Maine 04096

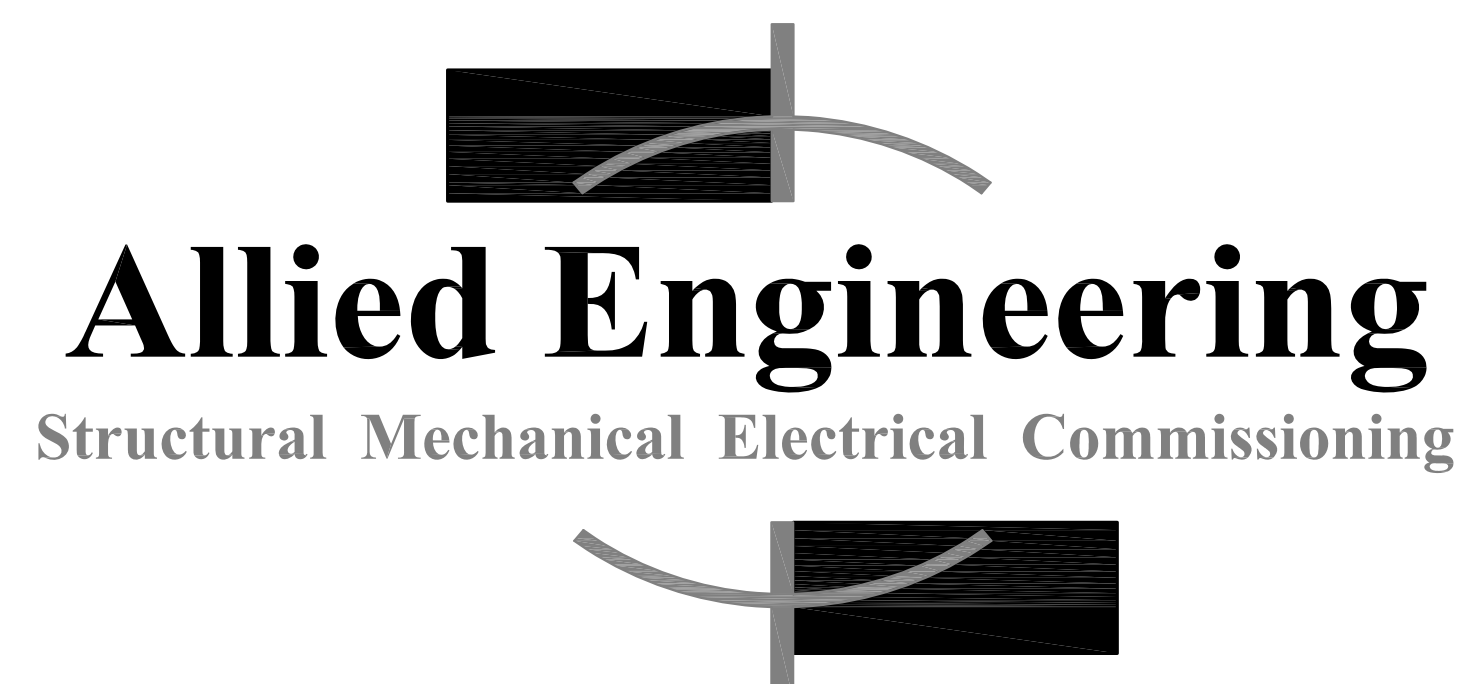

160 Veranda Street
Portland, Maine 04103
T: 207.221.2260
F: 207.221.2266
Web: www.allied-eng.com

