


# City Of Portland Portland Public Schools - Central Kitchen

## PORTLAND, MAINE

ALLIED PROJECT No. 13001

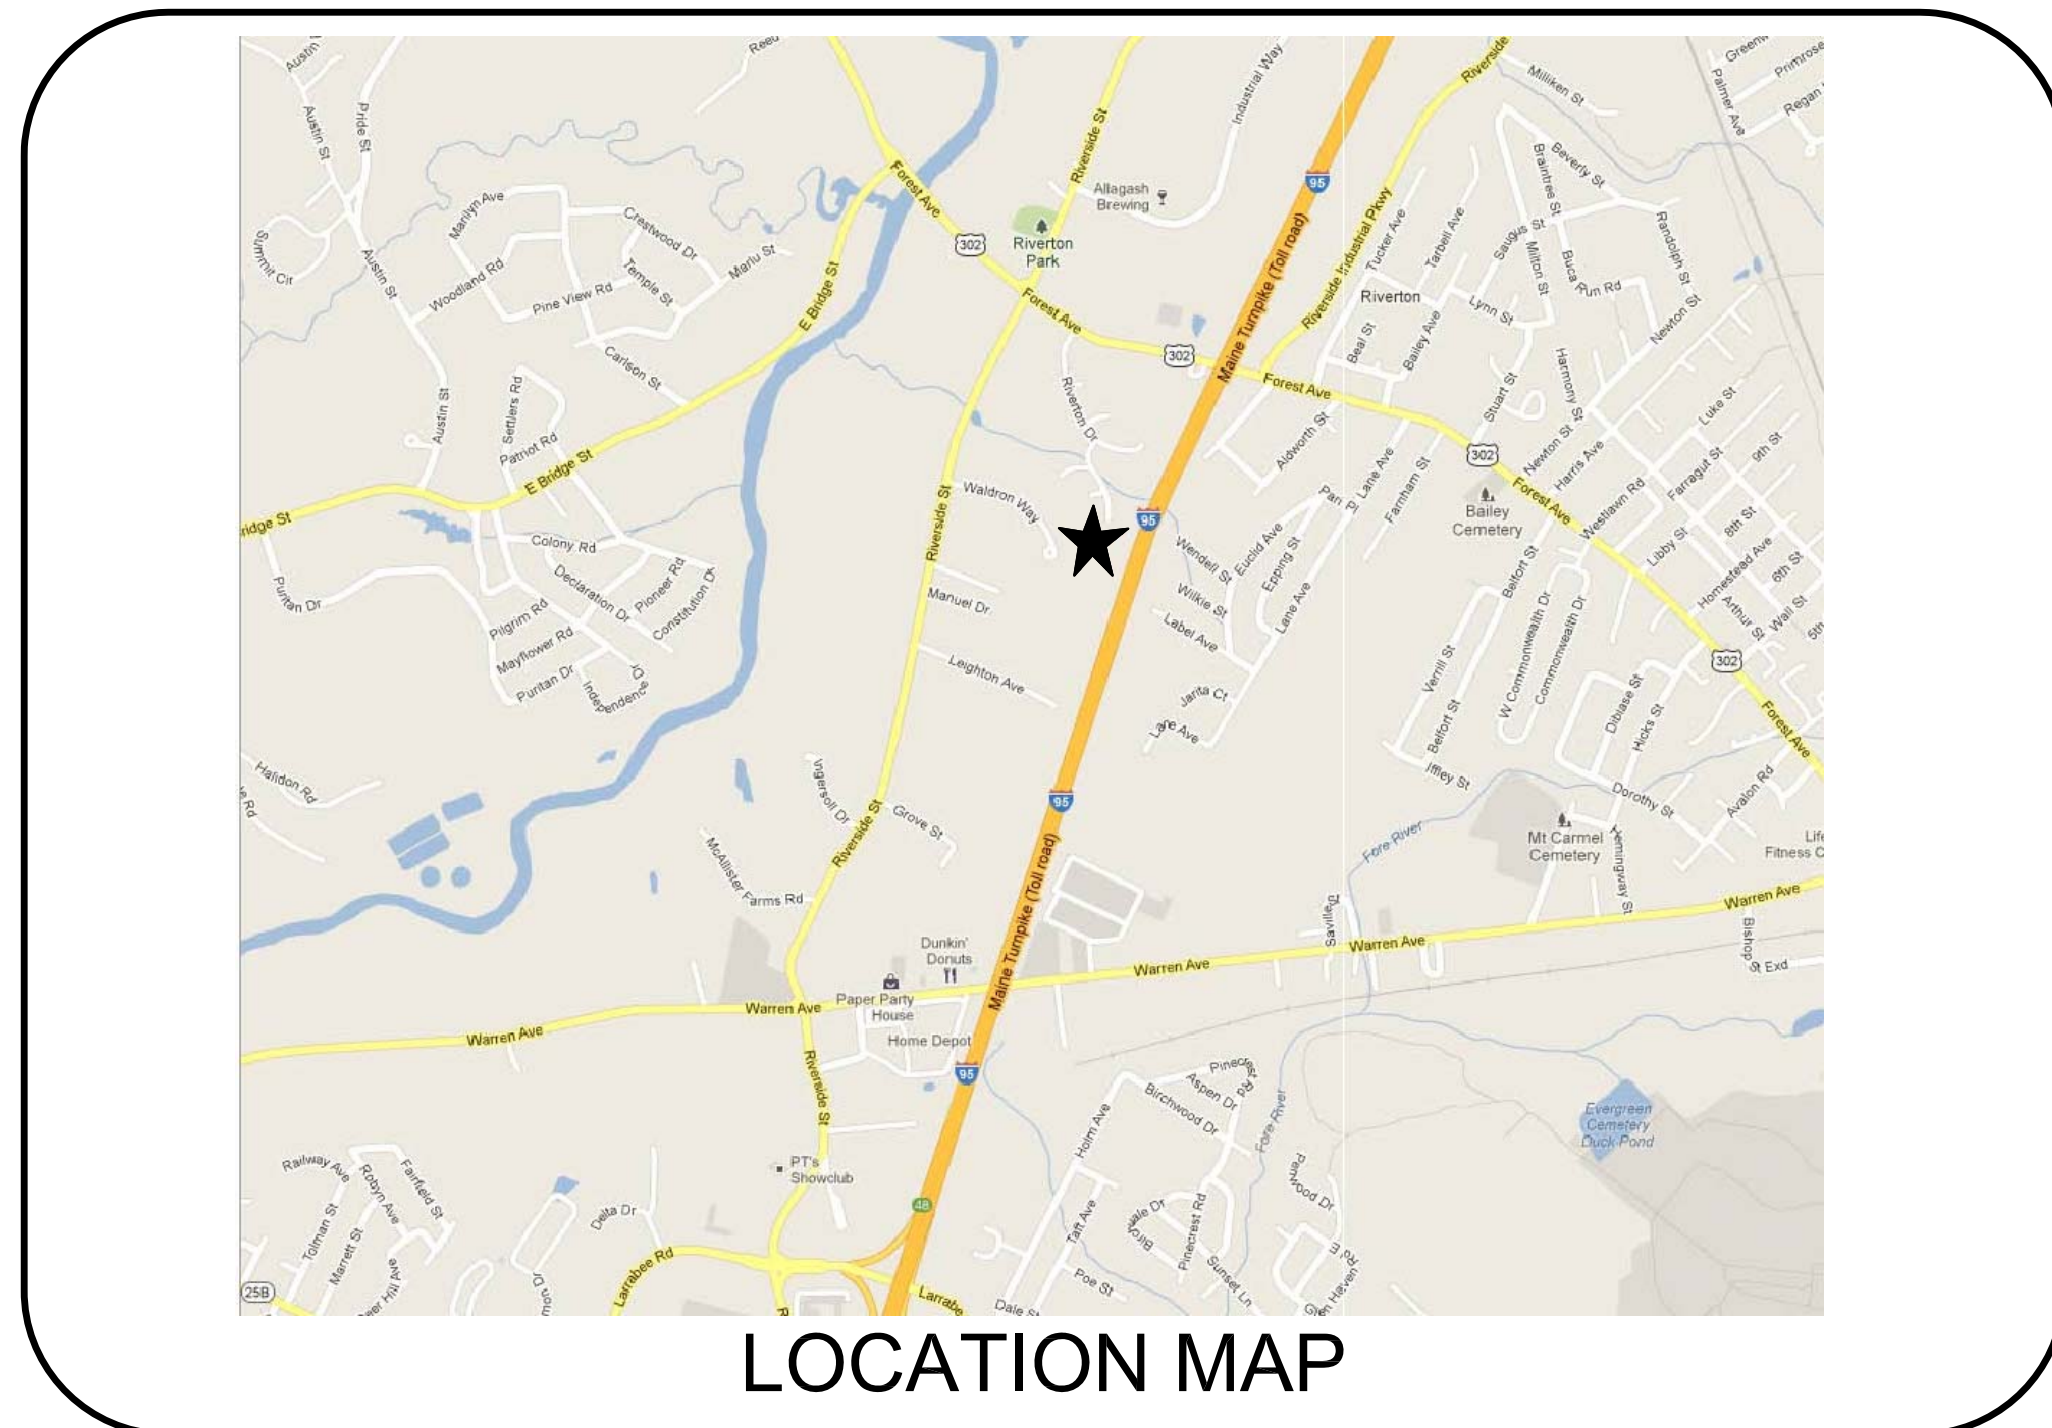


LOCATION MAP

**ISSUED FOR BID  
02-01-2013**

DRAWING STATUS LIST		ISSUE	DATE											
			ISSUED FOR BID											
DRAWINGS														
Sht No.	SHEET TITLE													
-	COVER SHEET													
FS-1	FOODSERVICE EQUIPMENT FLOOR PLAN													
FS-2	FOODSERVICE EQUIPMENT MECHANICAL SCHEDULE													
FS-3	FOODSERVICE EQUIPMENT ELECTRICAL CONNECTION PLAN													
FS-4	FOODSERVICE EQUIPMENT PLUMBING CONNECTION PLAN													
FS-5	FOODSERVICE EQUIPMENT WALL PLAN, EXISTING AND NEW													
FS-6	FOODSERVICE EQUIPMENT DETAILS AND ELEVATIONS													
FS-7	FOODSERVICE EQUIPMENT DETAILS AND ELEVATIONS													
FS-8	FOODSERVICE EQUIPMENT DETAILS AND ELEVATIONS													
FS-9	FOODSERVICE EQUIPMENT EXHAUST HOOD DETAILS													
FS-10	FOODSERVICE EQUIPMENT EXHAUST HOOD DETAILS													
FS-11	FOODSERVICE EQUIPMENT EXHAUST HOOD DESIGN NOTES													
FS-12	FOODSERVICE EQUIPMENT FLIGHT-TYPE DISHWASHER DETAIL													
FS-13	FOODSERVICE EQUIPMENT WALK-IN COOLER DETAILS													
FS-14	FOODSERVICE EQUIPMENT WALK-IN COOLER DETAILS													
FS-15	FOODSERVICE EQUIPMENT WALK-IN COOLER DETAILS													
FS-16	FOODSERVICE EQUIPMENT REFRIGERATION RACK DETAILS													



TJM Consulting, Inc.  
Foodservice Consultant  
273 Main Street, Suite 5  
Yarmouth, Maine 04096

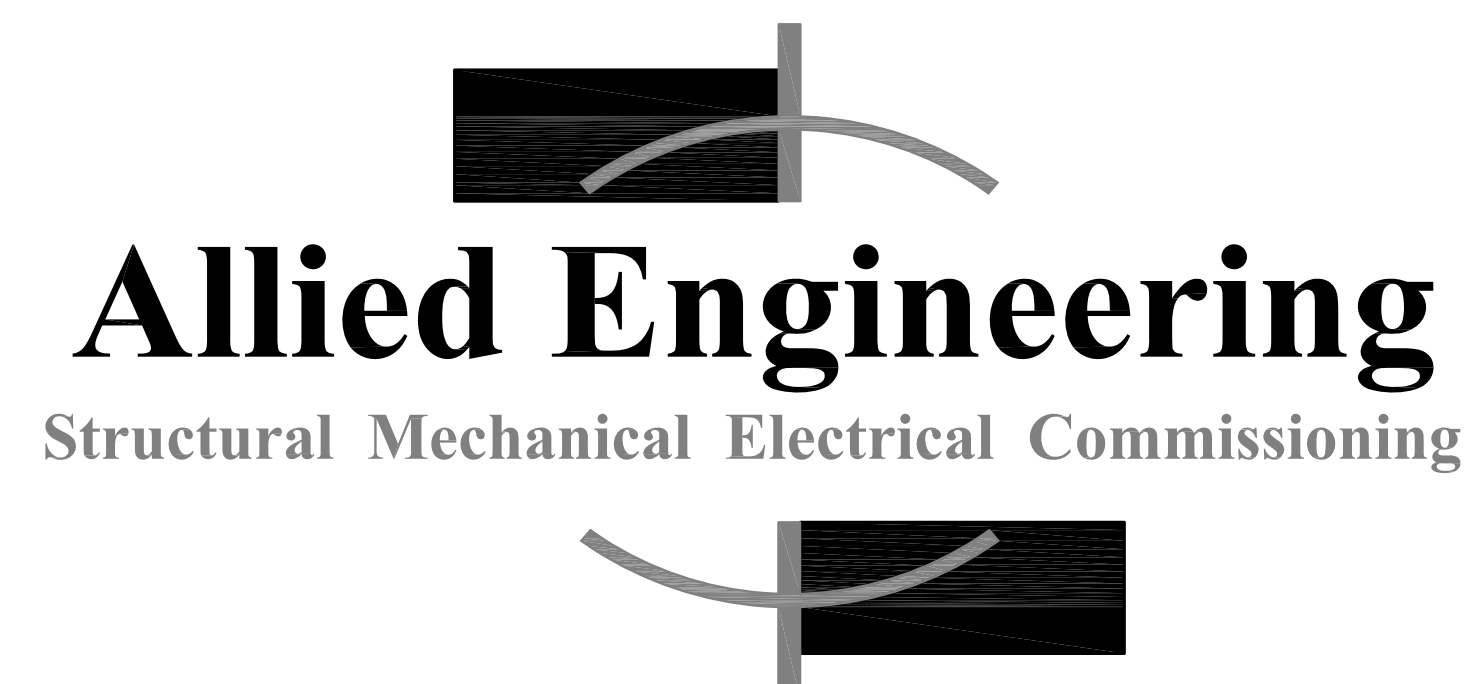

160 Veranda Street  
Portland, Maine 04103  
T: 207.221.2260  
F: 207.221.2266  
Web: www.allied-eng.com

--	--	--	--	--