


WK. QTY	DESCRIPTION	ELECTRICAL				WATER		WASTE		GAS		STEAM		VENTILATION		REMARKS						
		FLAMPS	KW	HP	VOLTS	COLD	HOT	DIRECT	INDIRECT	SIZE	MBTUH	LBS/HR	PSIG	INLET	RETURN		EXHAUST	SIZE	CFM	WAKE-UP AIR	SIZE	CFM
1	7 HAND SINK					1/2"	1/2"															BASE BID
2	2 WORK TABLE (EXISTING)																					EXISTING EQUIPMENT
3	4 WALL SHELF																					BASE BID
4	6 SHELVING UNIT																					BASE BID
5	1 WALK-IN COOLER (EXISTING)	58		1 1/2	208	3 X																EXISTING EQUIPMENT
6	1 WALK-IN FREEZER (EXISTING)	80		1 1/2	115	1 X																EXISTING EQUIPMENT
7	1 SINK, SPARE NUMBER																					EXISTING EQUIPMENT
8	1 PRODUCE SOAK SINK (N.I.C.)	52		3/4	208	1 X	1/2"	1/2"														N.I.C. PART OF BID PACKAGE # 2
9	2 WORK TABLE W/SINK (EXISTING)						1/2"	1/2"														EXISTING EQUIPMENT
10	1 PASS-THRU SHELF																					BASE BID
11	6 WORK TABLE (EXISTING)	60		1/2	115	1 X																EXISTING EQUIPMENT
12	2 SLUGGER (EXISTING)	100		1	120	1 X																EXISTING EQUIPMENT
13	2 FOOD PROCESSOR (EXISTING)	100		1	120	1 X																EXISTING EQUIPMENT
14	1 PEELER, VEGETABLE (N.I.C.)	38		1	208	3 X	1/2"	1/2"														N.I.C. PART OF BID PACKAGE # 2
15	6 HOSE REEL						1/2"	1/2"														BASE BID
16	— SPARE NUMBER —																					
17	— SPARE NUMBER —																					
18	1 EXHAUST HOOD	150		120	1 X																	BASE BID
19	2 KETTLE, 80-GALLON, MIXER	150		120	1 X	1/2"	1/2"															1-UNIT BASE BID, 1-UNIT BID ALT # 1
20	2 FLOOR TROUGH	450	360	2	480	3 X	1/2"	1/2"														BASE BID
21	1 PUMP/FOOD FILLING STATION/COOK-CHILL	150			115	1 X																BASE BID
22	1 REFRIGERATOR, 2-SECTION (EXISTING)	107		1/2	115	1 X																EXISTING EQUIPMENT
23	1 GALLON MASTER, WATER METER	30			115	1 X	3/4"															BASE BID
24	— SPARE NUMBER —																					
25	1 EXHAUST HOOD	150		120	1 X																	BASE BID
26	1 TILTING SKILLET, 40-GALLON	150		120	1 X																	N.I.C. PART OF BID ALTERNATE # 1
27	1 FLOOR TROUGH	40		120	1 X	3/8"	3/8"															BASE BID
28	1 RANGE, FOUR OPEN BURNERS	175	61.8	208	3 X	3/4"																N.I.C. PART OF BID ALTERNATE # 1
29	2 COMBI-OVEN, ROLL-IN																					1-UNIT BASE BID, 1-UNIT BID ALT # 1
30	1 WALK-IN COOLER	150		120	1 X	3/4"																BASE BID
31	2 BLAST CHILLER (1 UNIT N.I.C.)	120			120	1 X																1-UNIT BASE BID, 1-UNIT BID ALT # 1
32	1 BLAST CHILLER/SHOOK FREEZER	80			120	208	3 X															BASE BID
33	2 EVAPORATOR COIL, COOLER	27			115	1 X	3/4"															EXISTING EQUIPMENT
34	— SPARE NUMBER —																					BASE BID
35	4 WORK TABLE, MOBILE (EXISTING)																					EXISTING EQUIPMENT
36	1 ROLLER WHEEL CONVEYOR																					BASE BID
37	1 AUTOMATED PACKAGING SYSTEM	100		208	1 X																	N.I.C. (BY OTHERS)
38	1 ROTARY ACCUMULATOR (N.I.C.)	20		115	1 X																	N.I.C. PART OF BID ALTERNATE # 1
39	1 DUNNAGE RACK	433		480	3 X	3/4"																BASE BID
40	1 DISHWASHER, FLIGHT-TYPE	330		480	3 X																	BASE BID
		345		480	3 X																	
		32		480	3 X																	
41	1 COMPENSATE HOOD																					BASE BID
42	2 TRAY DRYING RACK																					BASE BID
43	1 SINK, 3-COMPARTMENT																					BASE BID
44	1 POT AND PAN WASHER (EXISTING)	86.8		208	3 X																	EXISTING EQUIPMENT
45	1 CONDENSATE HOOD (EXISTING)																					EXISTING EQUIPMENT
46	1 MOP SINK																					BASE BID
47	— SPARE NUMBER —																					BASE BID
48	— SPARE NUMBER —																					BASE BID
49	1 WALK-IN COOLER	40		120	1 X																	BASE BID
50	1 EVAPORATOR COIL, COOLER	27		115	1 X																	BASE BID
51	1 REFRIGERATION RACK SYSTEM	1260		208	3 X																	BASE BID
52	1 REFRIGERATION RACK SYSTEM	1260		208	3 X																	BASE BID
53	1 REFRIGERATION RACK SYSTEM	1260		208	3 X																	BASE BID
54	50 SHEET PAN RACK (N.I.C.)																					N.I.C. PART OF BID PACKAGE # 2
55	56 DISH/TRAY CART (N.I.C.)																					N.I.C. PART OF BID PACKAGE # 2

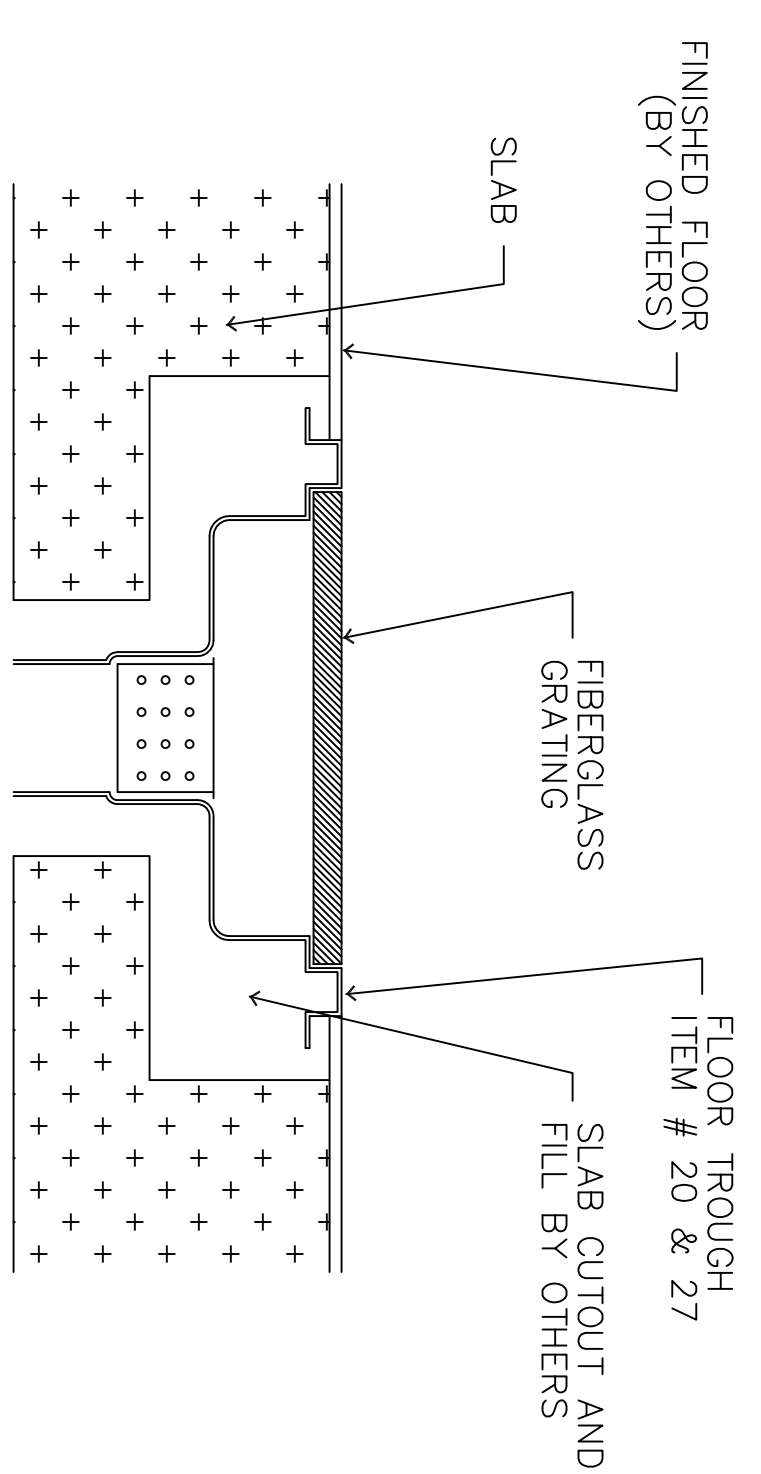

**FLOOR TROUGH SECTION**  
SCALE - NONE

**TJM Consulting, Inc.**  
 273 Main Street, Suite 5  
 Yarmouth, Maine 04098

NOTICE:  
 THIS DRAWING AND ALL INFORMATION HEREIN  
 ARE THE PROPERTY OF TJM CONSULTING, INC.  
 AND SHALL REMAIN THE PROPERTY OF THE DESIGNER  
 WHOSE WRITTEN CONSENT OF THE DESIGNER  
 IS REQUIRED FOR ANY PARTIAL OR WHOLE REPRODUCTION.

REV. NO.	REVISIONS	REV. NO.	REVISIONS

Portland Public Schools  
 Central Kitchen  
 92 Waldron Way  
 Portland, Maine

DATE: 2-1-2018  
 CHECKED BY: T. Maxwell  
 DRAWN BY: T. Maxwell  
 SCALE: None

SHEET TITLE:  
**Foodservice Equipment  
 Mechanical Schedule**

SHEET NO.:  
**FS-2**