




1 DECK / JOIST DETAIL SCALE: 1"=1'-0"

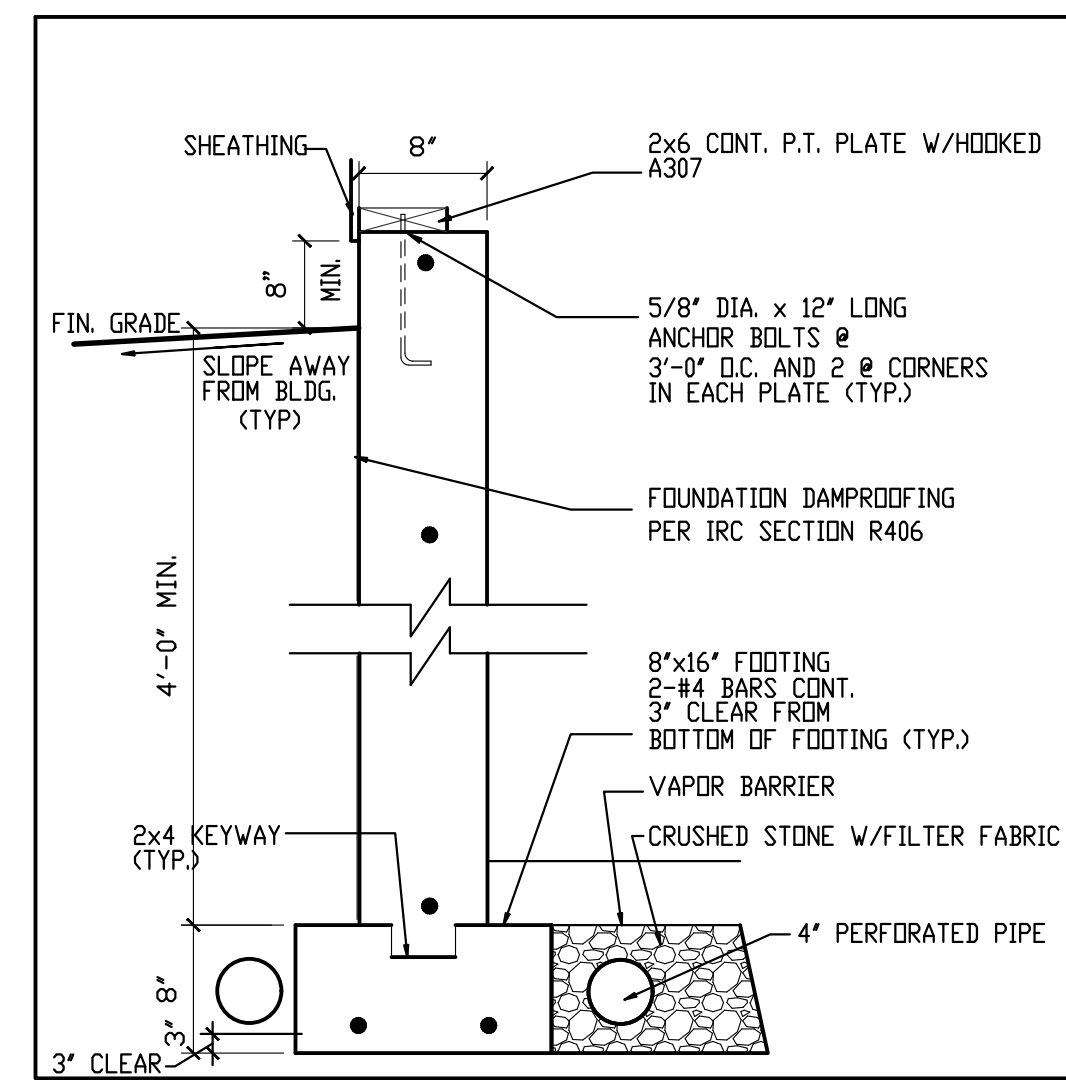

2 TYPICAL FOUNDATION WALL SCALE: 1"=1'-0"

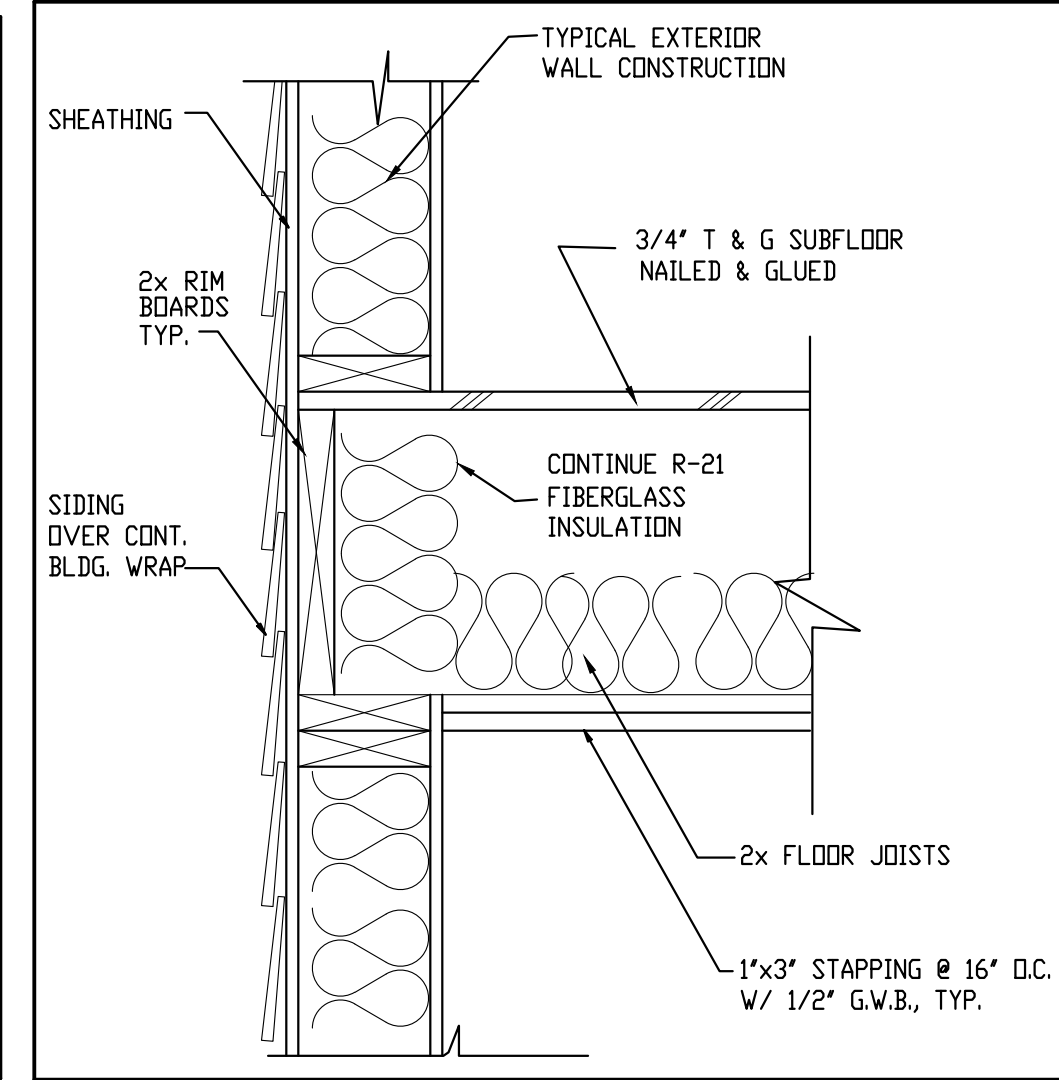

3 FLOOR FRAMING DETAIL 1 1/2" = 1'-0"

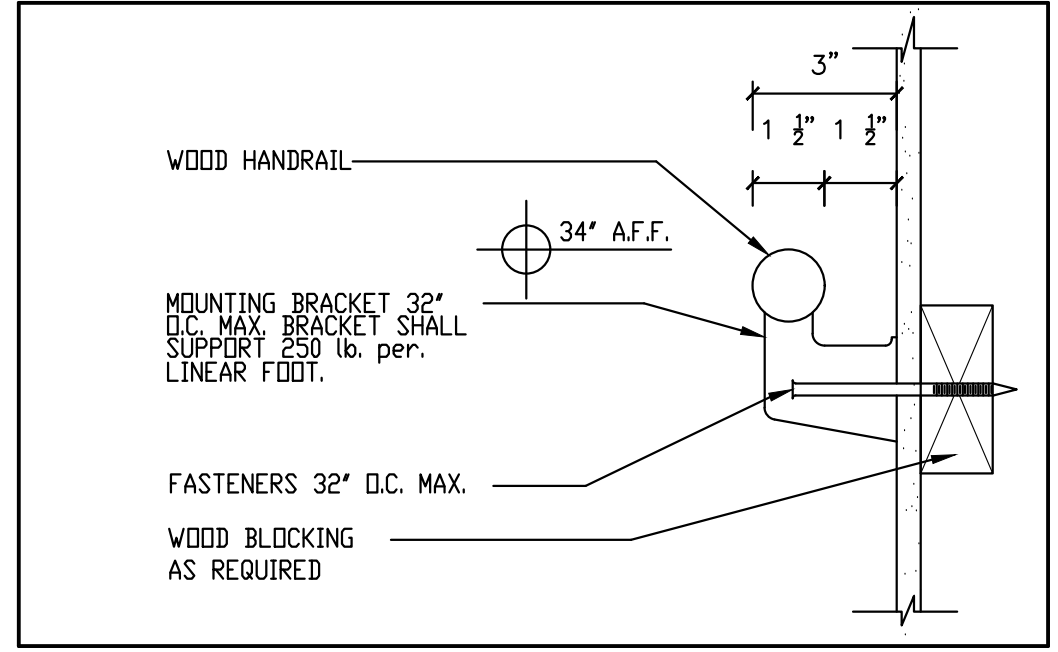

HANDRAIL DETAIL NTS


GENERAL NOTES:

1. All work shall be in accordance with IRC 2009, IBC Basic Building Code, NFPA-70 National Electric Code, Maine State Plumbing Code, ASHRAE, U.L., NFPA Codes and all local, State and Federal requirements.
2. All required City and State permits must be obtained before any construction begins.
3. Structural, Mechanical, Electrical and Plumbing design and installation by others shall be performed in accordance with local, State and Federal standards.
4. Seal all openings & mechanical penetrations with approved fire safing material.
5. Building shall have approved smoke detectors in accordance with NFPA-101 Life Safety Code.


HEADER SCHEDULE	
ROUGH OPENING	HEADER SIZE
0 - 3'-0"	(3) - 2x6
3'-1" - 4'-6"	(3) - 2x8
4'-7" - 5'-8"	(3) - 2x10
5'-9" - 7'-0"	(3) - 2x12

NOTE: PROVIDE JAMBS BOTH ENDS AS FOLLOWS:
 2x6 JACK PLUS 2x6 KING UP TO 4'-6" ROUGH OPENING
 (2) 2x6 JACKS PLUS (2) 2x6 KINGS UP TO 7'-0" ROUGH OPENING


NOTE: NFPA #13D WET PIPE SPRINKLER SYSTEM
 SMOKE AND CO'S TO BE HARD WIRED

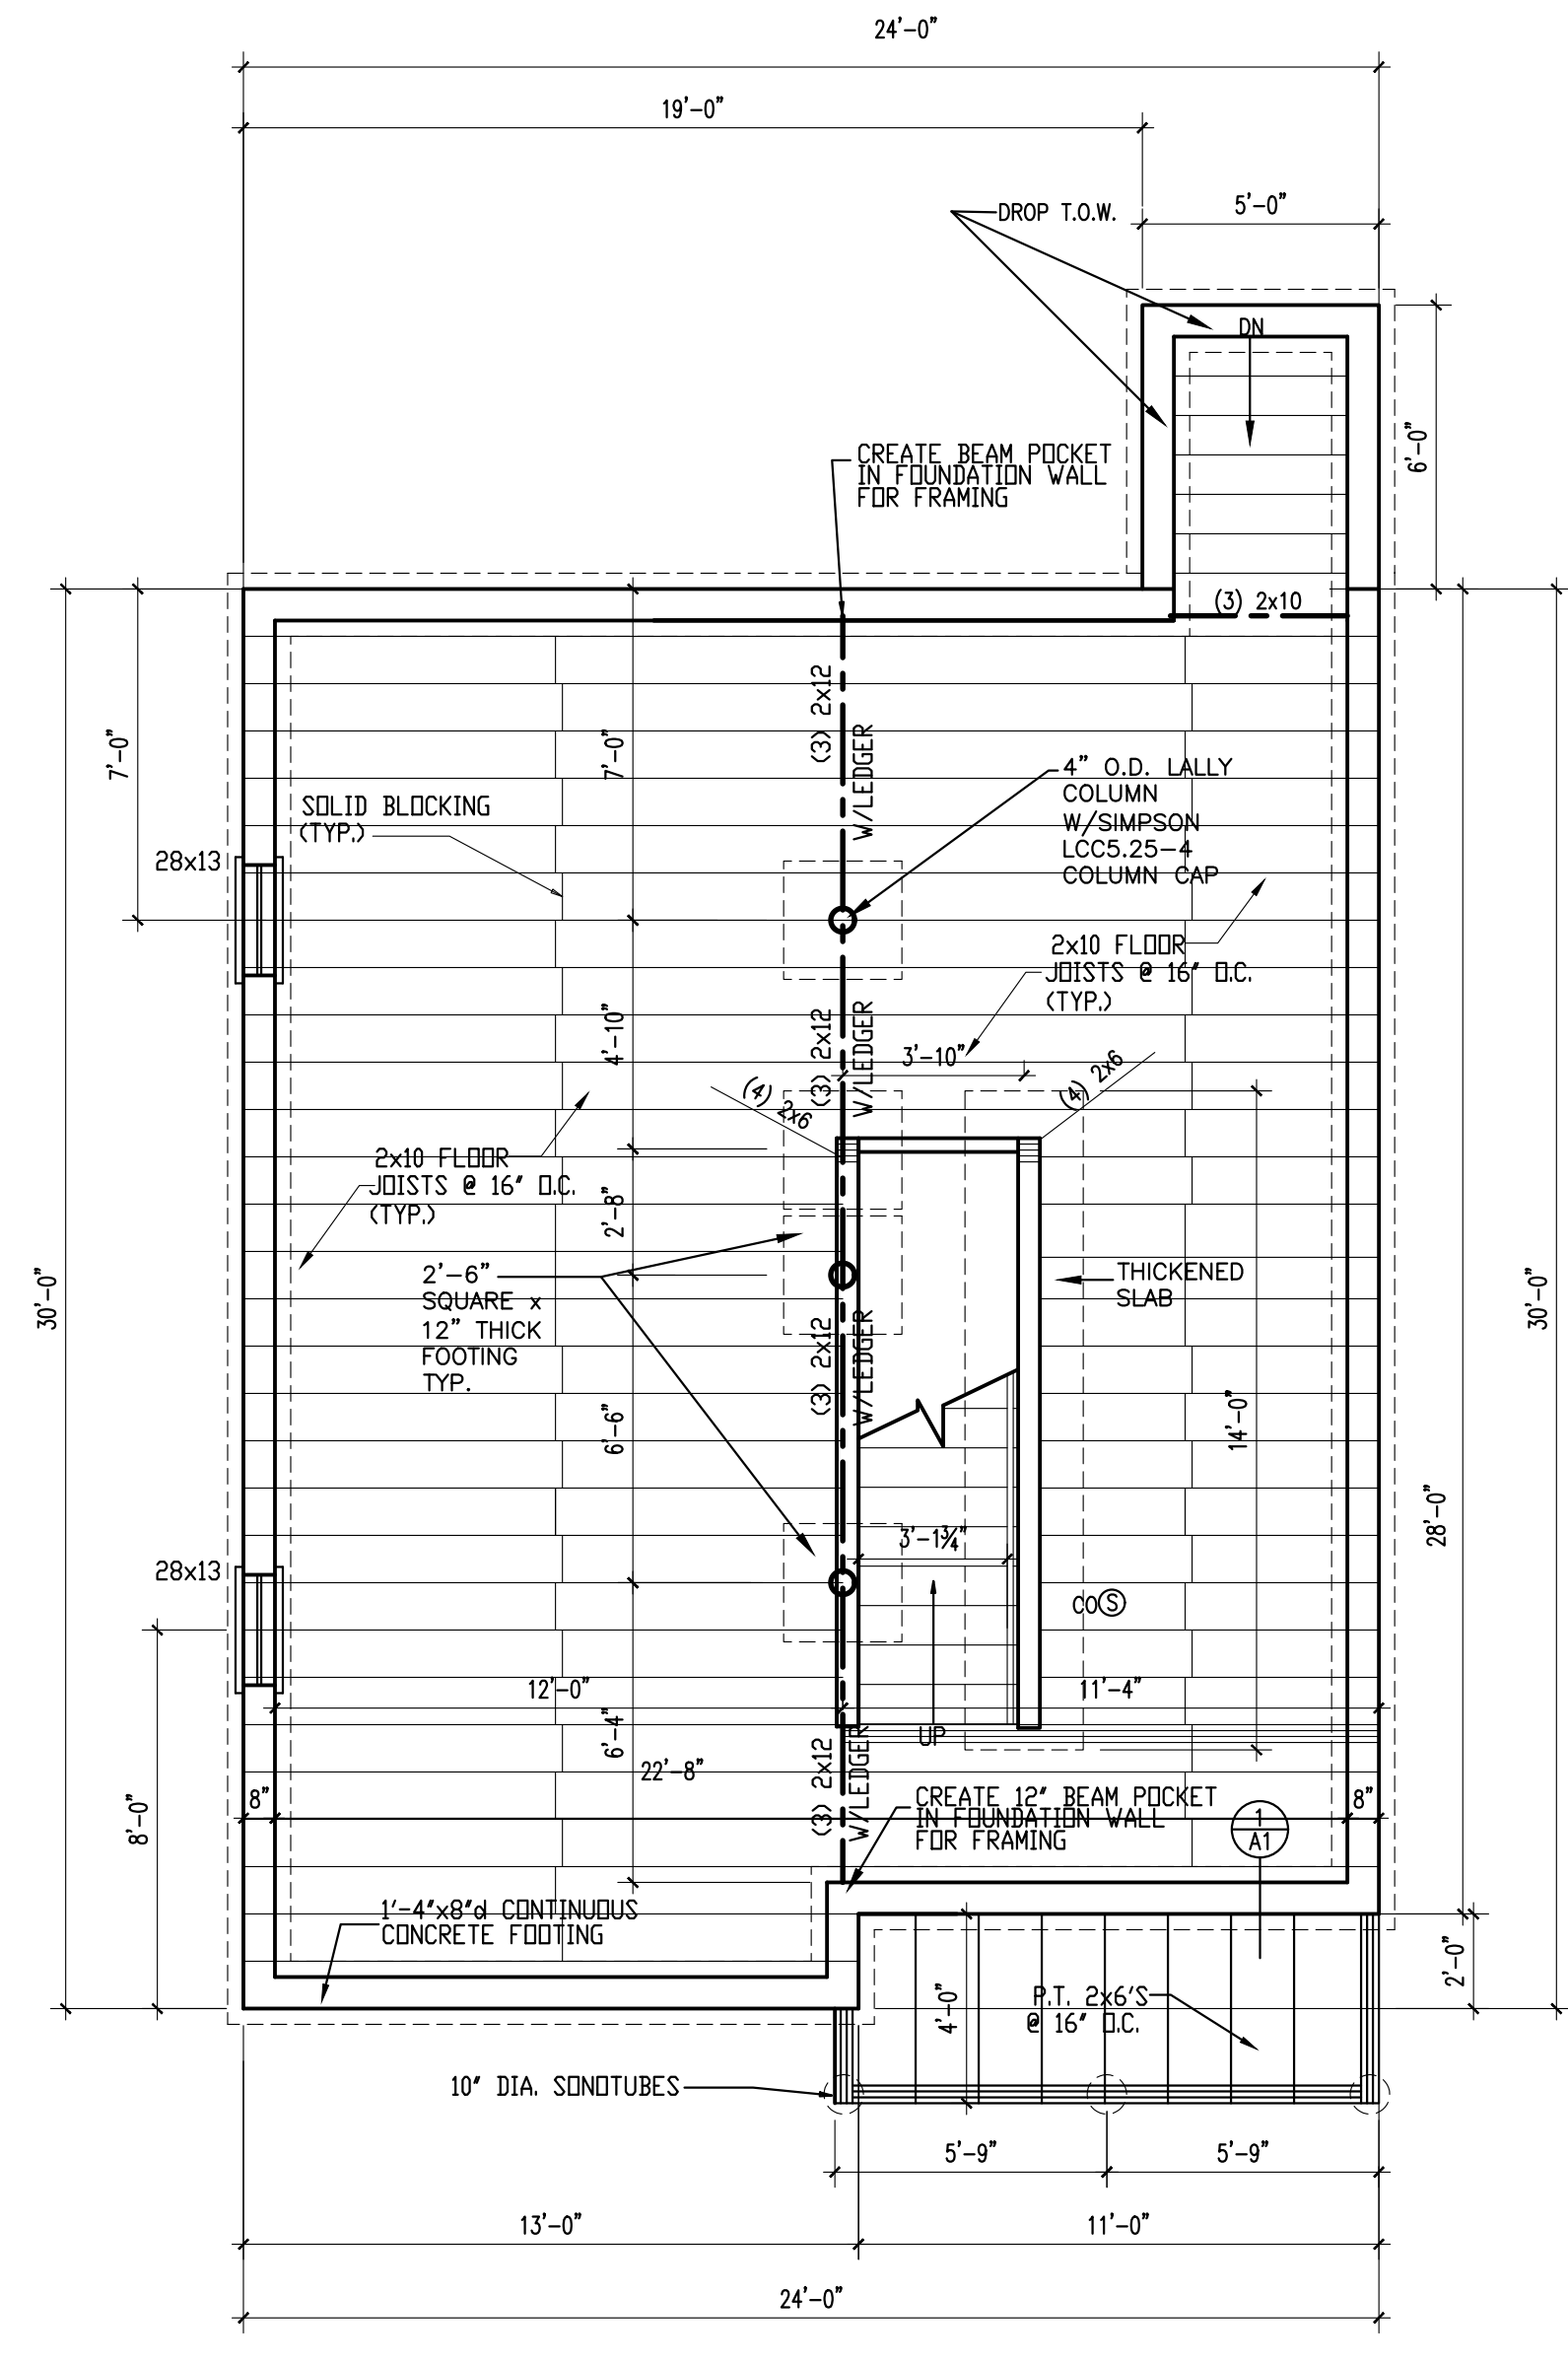

FOUNDATION/FRAMING PLAN SCALE: 1/4"=1'-0"

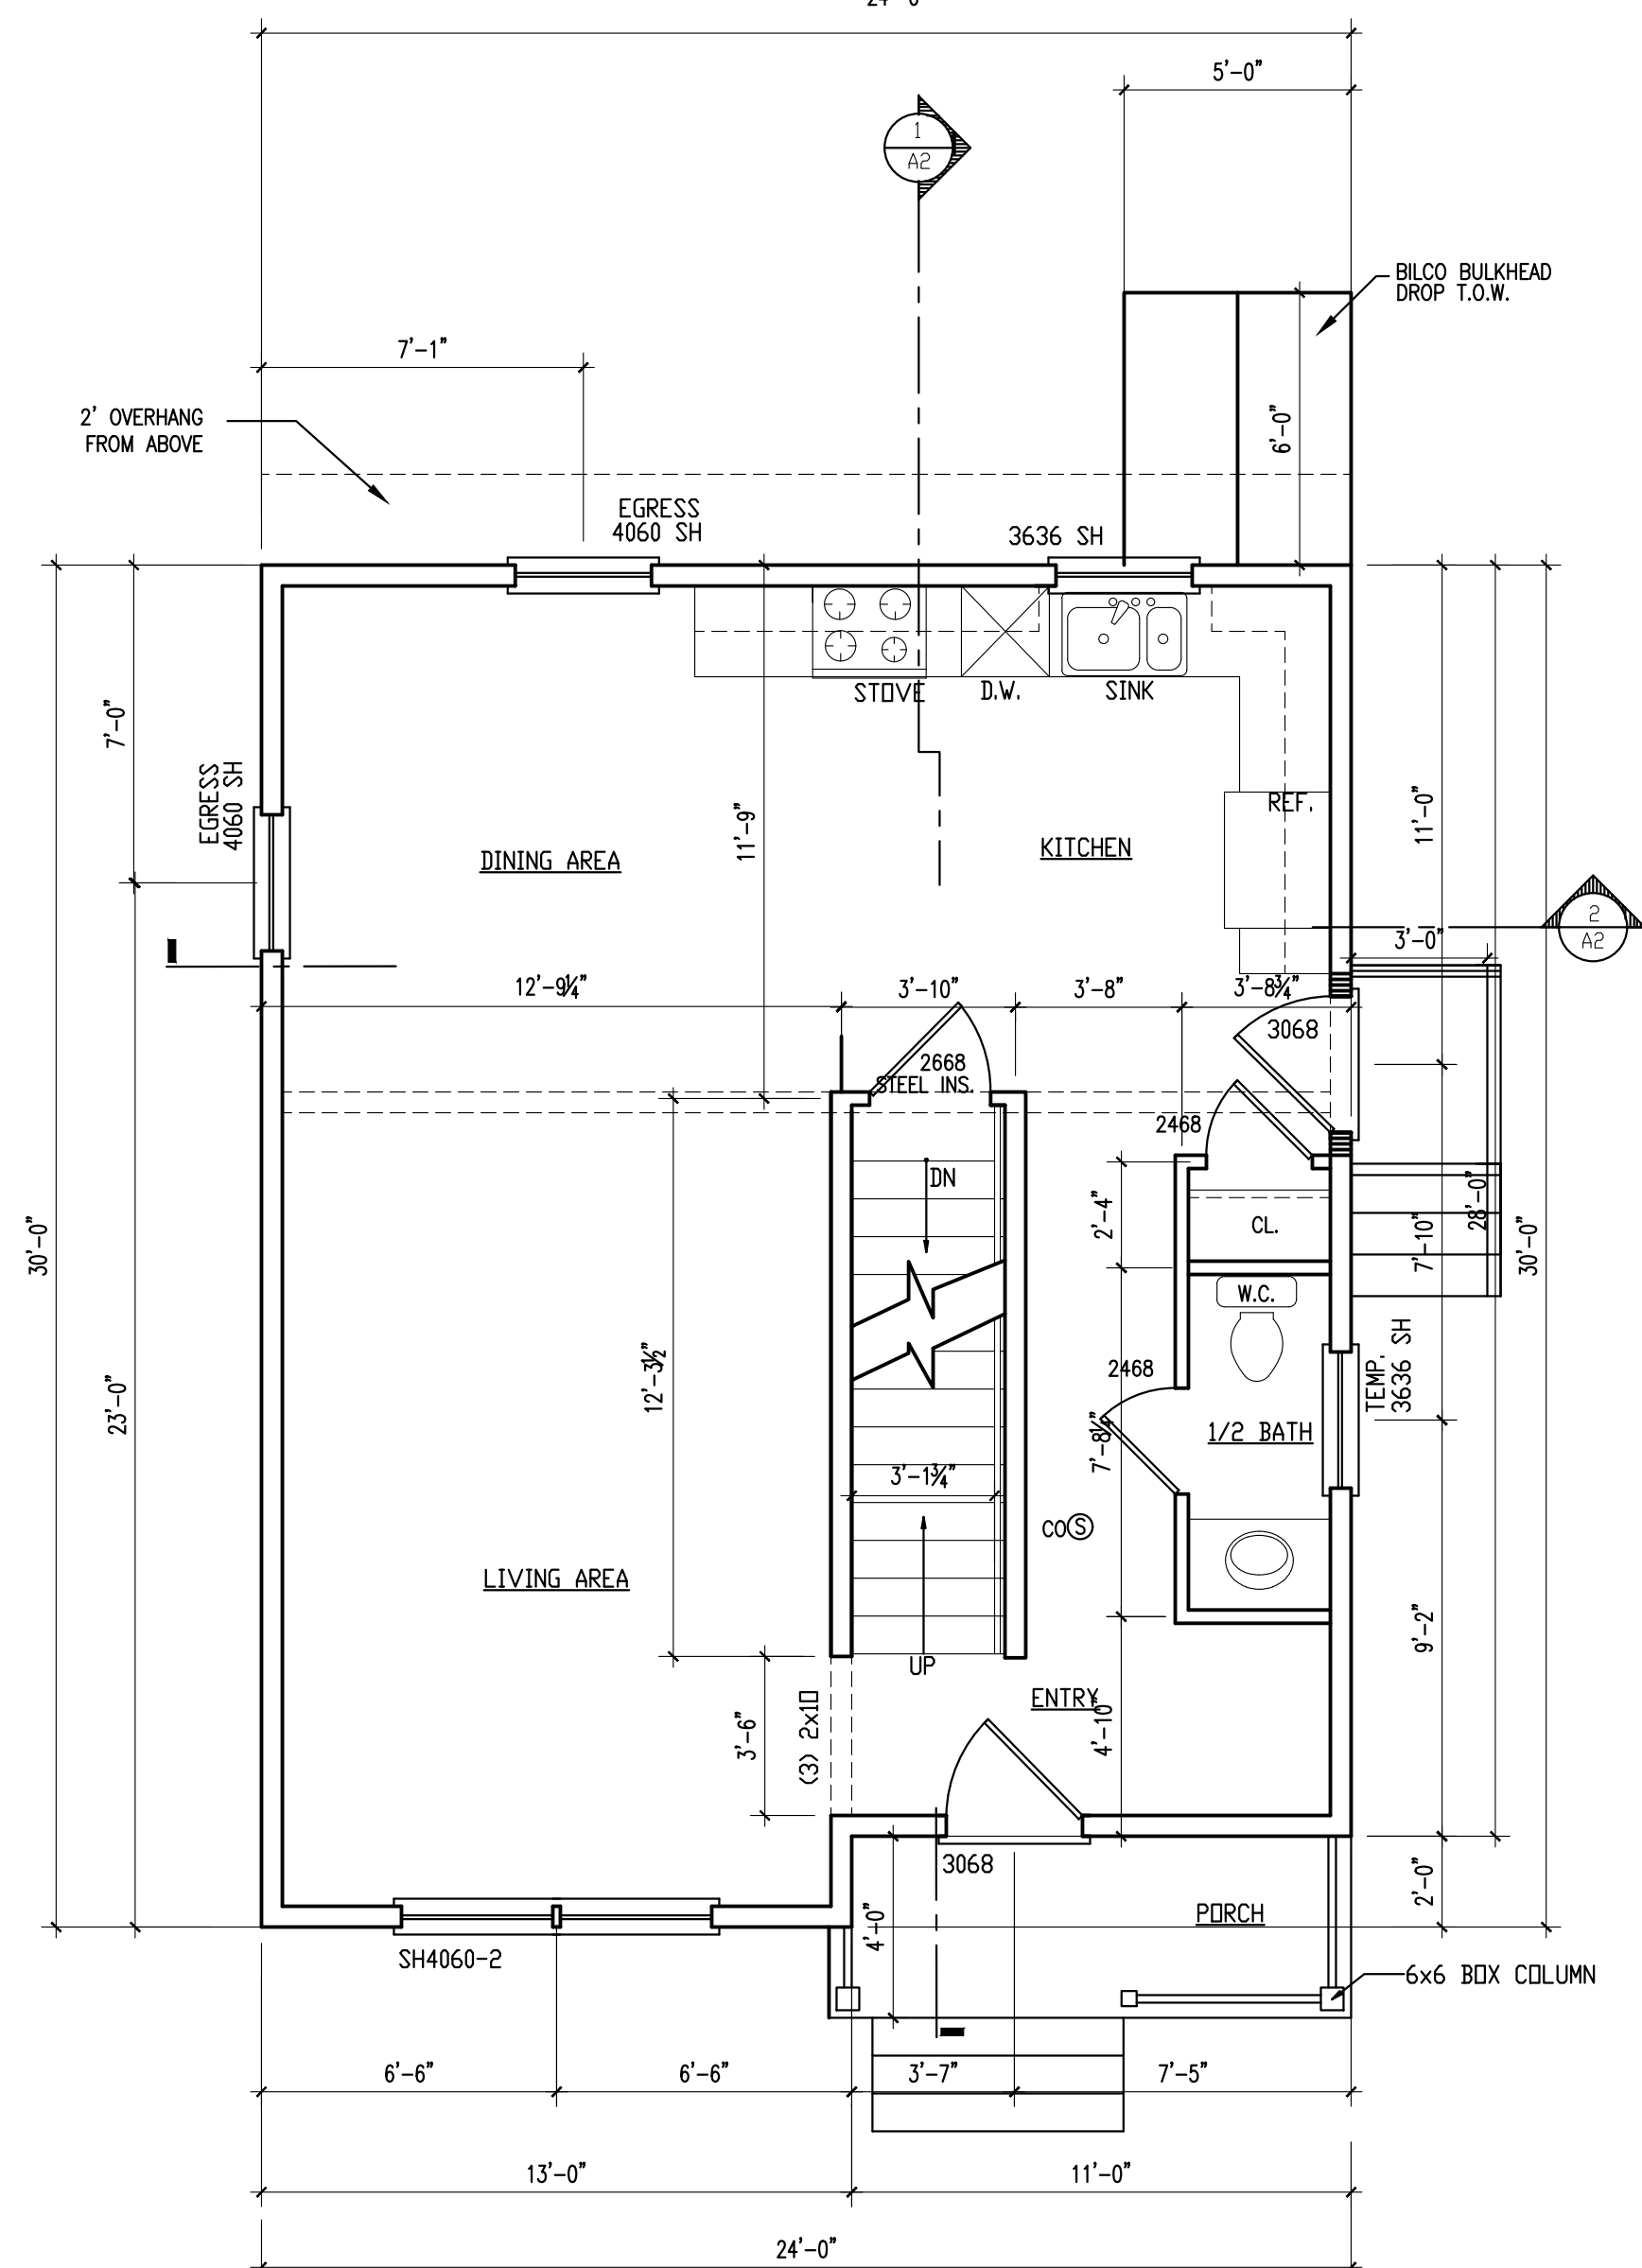

FIRST FLOOR PLAN SCALE: 1/4"=1'-0"
 698 S.F.

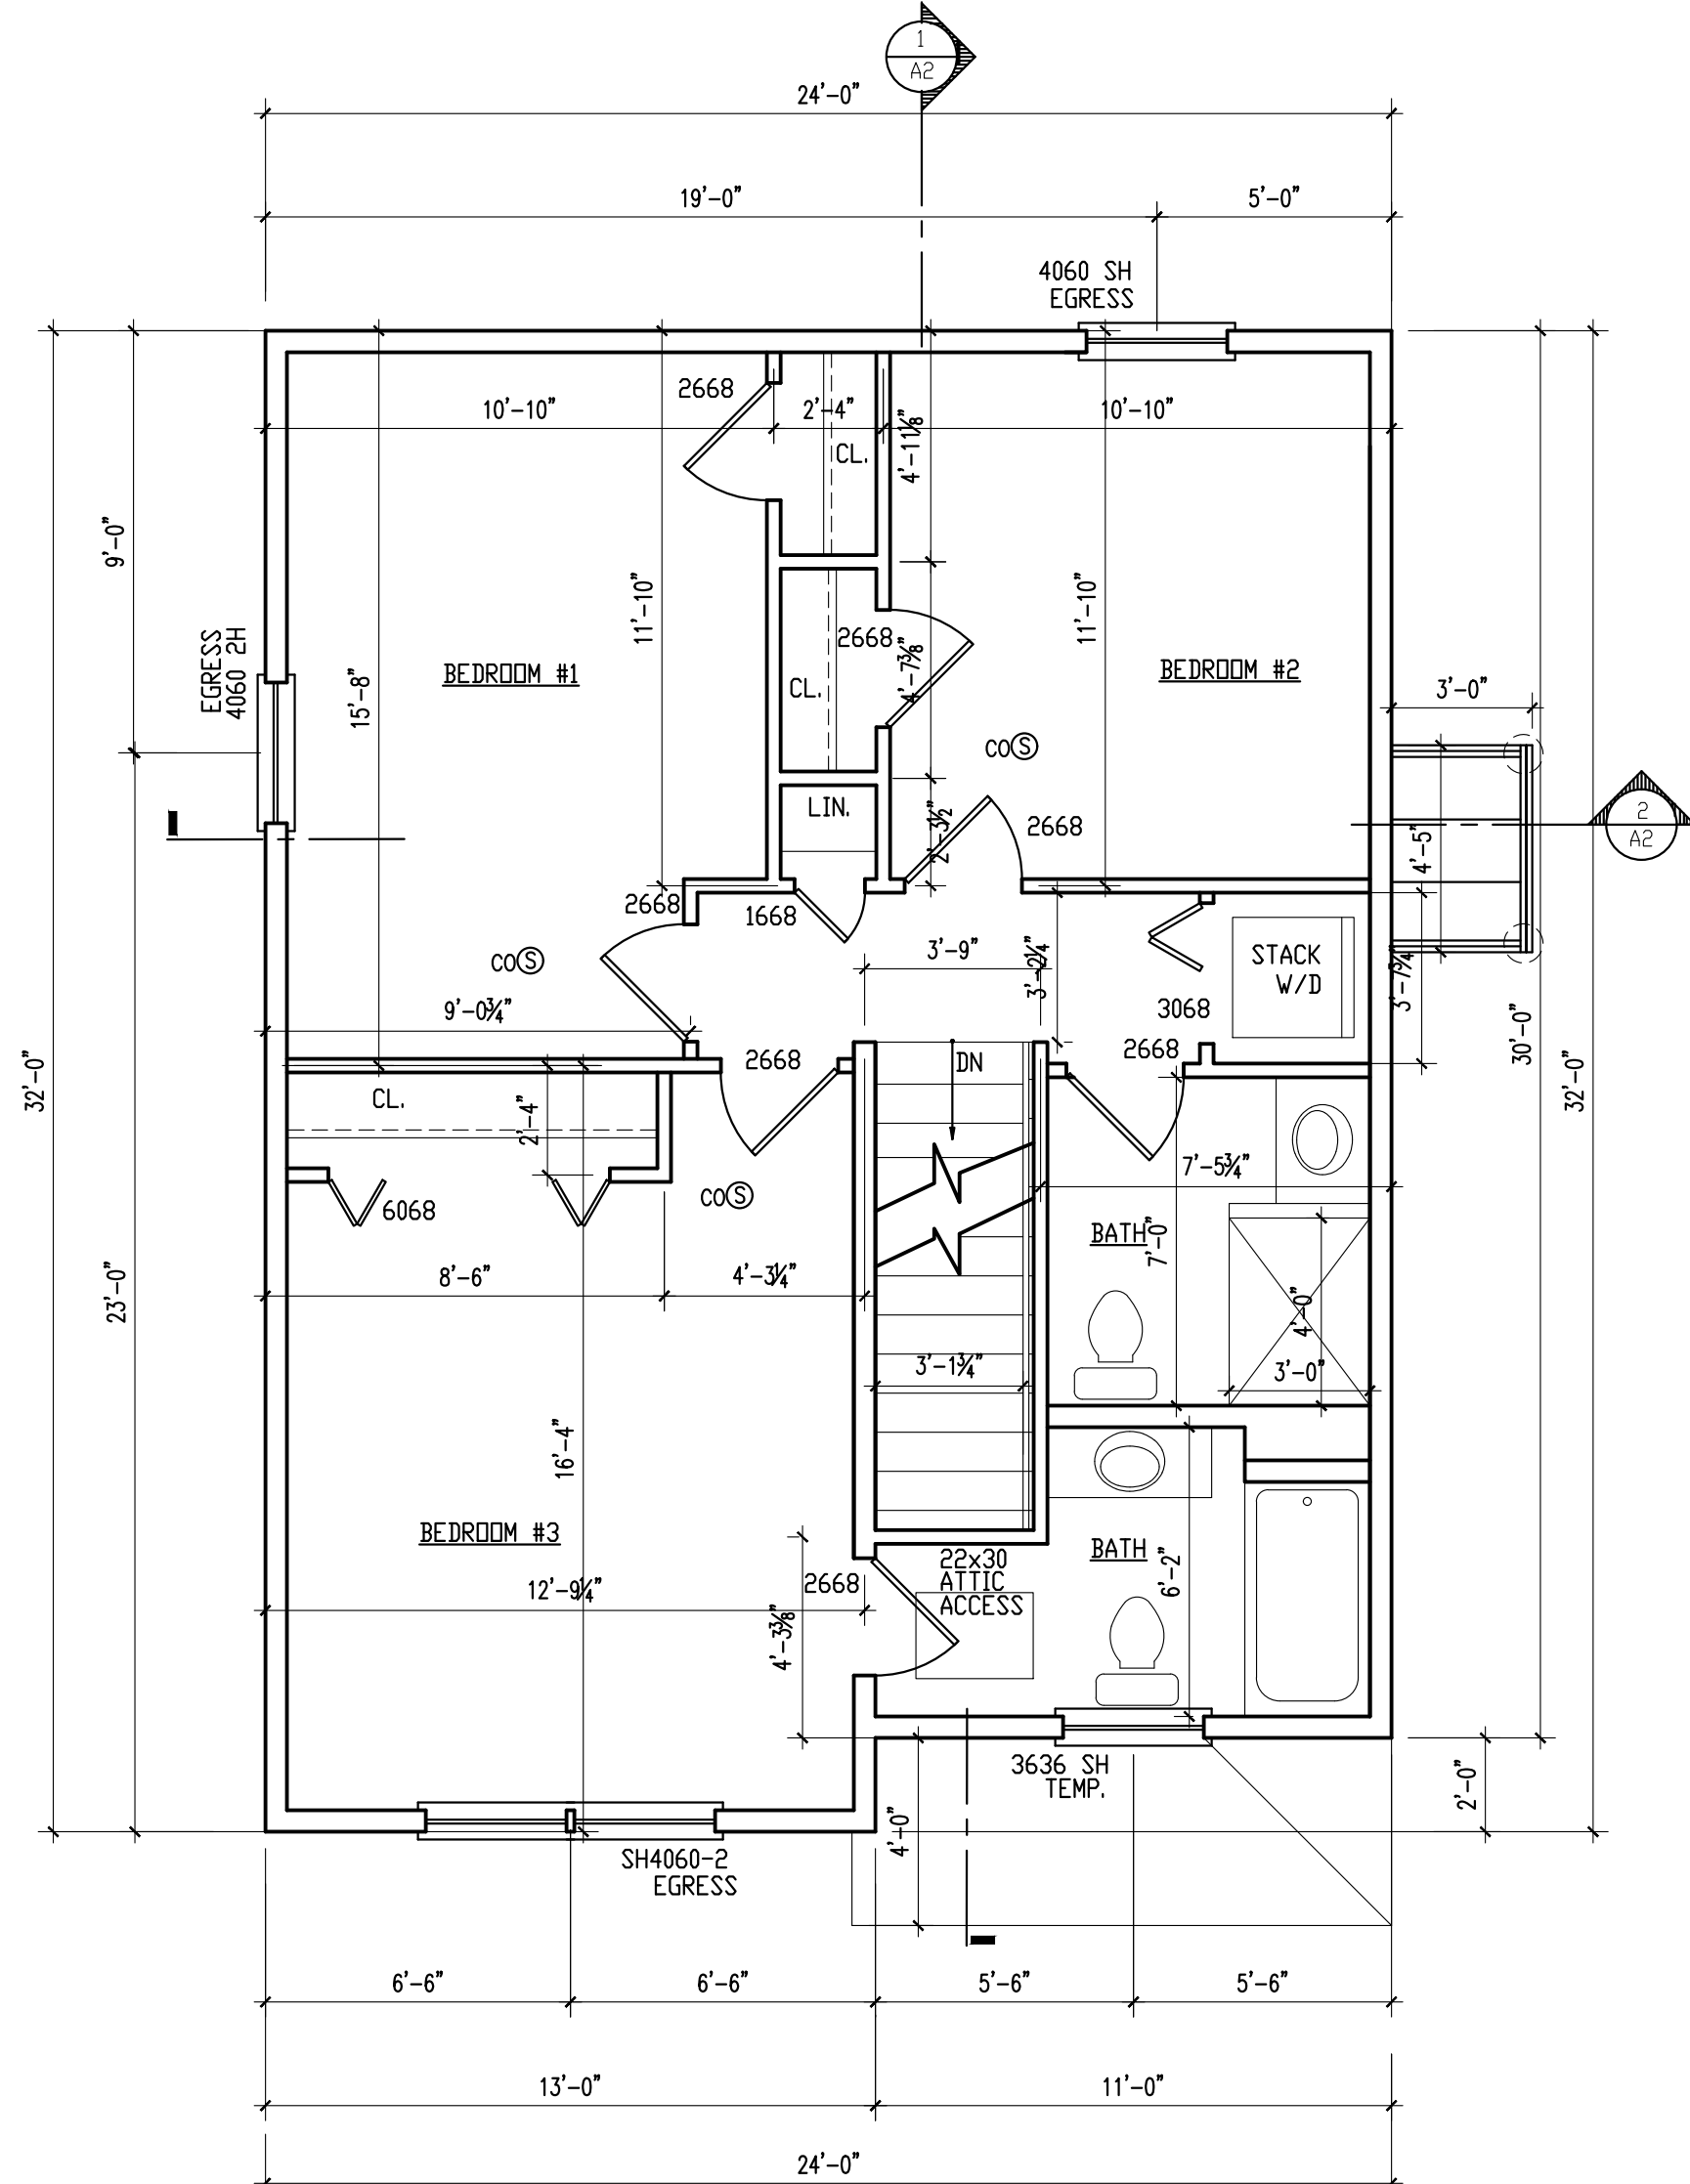

SECOND FLOOR PLAN SCALE: 1/4"=1'-0"
 746 S.F.

COLONIAL
 10 CASTINE AVE
 PORTLAND, MAINE

REVISIONS

DRAWN BY:	DLP
CHECKED BY:	DLP
DATE:	02-11-18
ISSUED:	

FLOOR PLANS
 DETAILS/NOTES

A1

SCALE: AS NOTED