

© 2017 RYAN SENATORE ARCHITECTURE

OFFICE BUILDING  
547 RIVERSIDE STREET  
PORTLAND, MAINE



RYAN SENATORE ARCHITECTURE  
565 CONGRESS STREET  
PORTLAND, MAINE 04101  
207-650-6414  
senatorearchitecture.com

CONSULTANTS:

REVISIONS:

DATE: DECEMBER 29, 2017

PROJECT No. 1788

DRAWN BY: RJS, JPF

CHECKED BY: RJS

SCALE: AS NOTED

SHEET TITLE:

REFLECTED CEILING PLAN

A1-2


**RCP LEGEND**

	RECESSED LIGHTING		EMERGENCY LIGHTING
	SPEAKER		12" GRILL
	FIRE ALARM (IN CEILING)		24" GRILL
	DIFUSER		
	SMOKE DETECTOR		

- RCP NOTES**
- LIGHTS TO BE CENTERED IN SPACE UNLESS NOTED OTHERWISE
  - G.C. TO COORDINATE LOCATIONS OF PLUMBING CLEAN OUTS AND PROVIDE FIRE RATED ACCESS PANELS AT CEILING
  - G.C. TO PROVIDE ACCESS PANELS AS REQUIRED FOR ALL ELEMENTS (SPRINKLER, VALVES, ETC) NOT SHOWN ON THIS REFLECTED CEILING PLAN
  - G.C. TO PROVIDE METAL FRAMING AND BLOCKING REQUIRED FOR ALL ACCESS PANELS AND CONTROL JOINTS

**LIGHT FIXTURE SCHEDULE**

A		SURFACE LED LIGHT
B		2x2 LED RECESSED FIXTURE
C		SURFACE LED LIGHT
D		EXTERIOR SURFACE LED LIGHT
E		RECESSED LED WET LIGHT FIXTURE
F		EXTERIOR WALL SCONCE

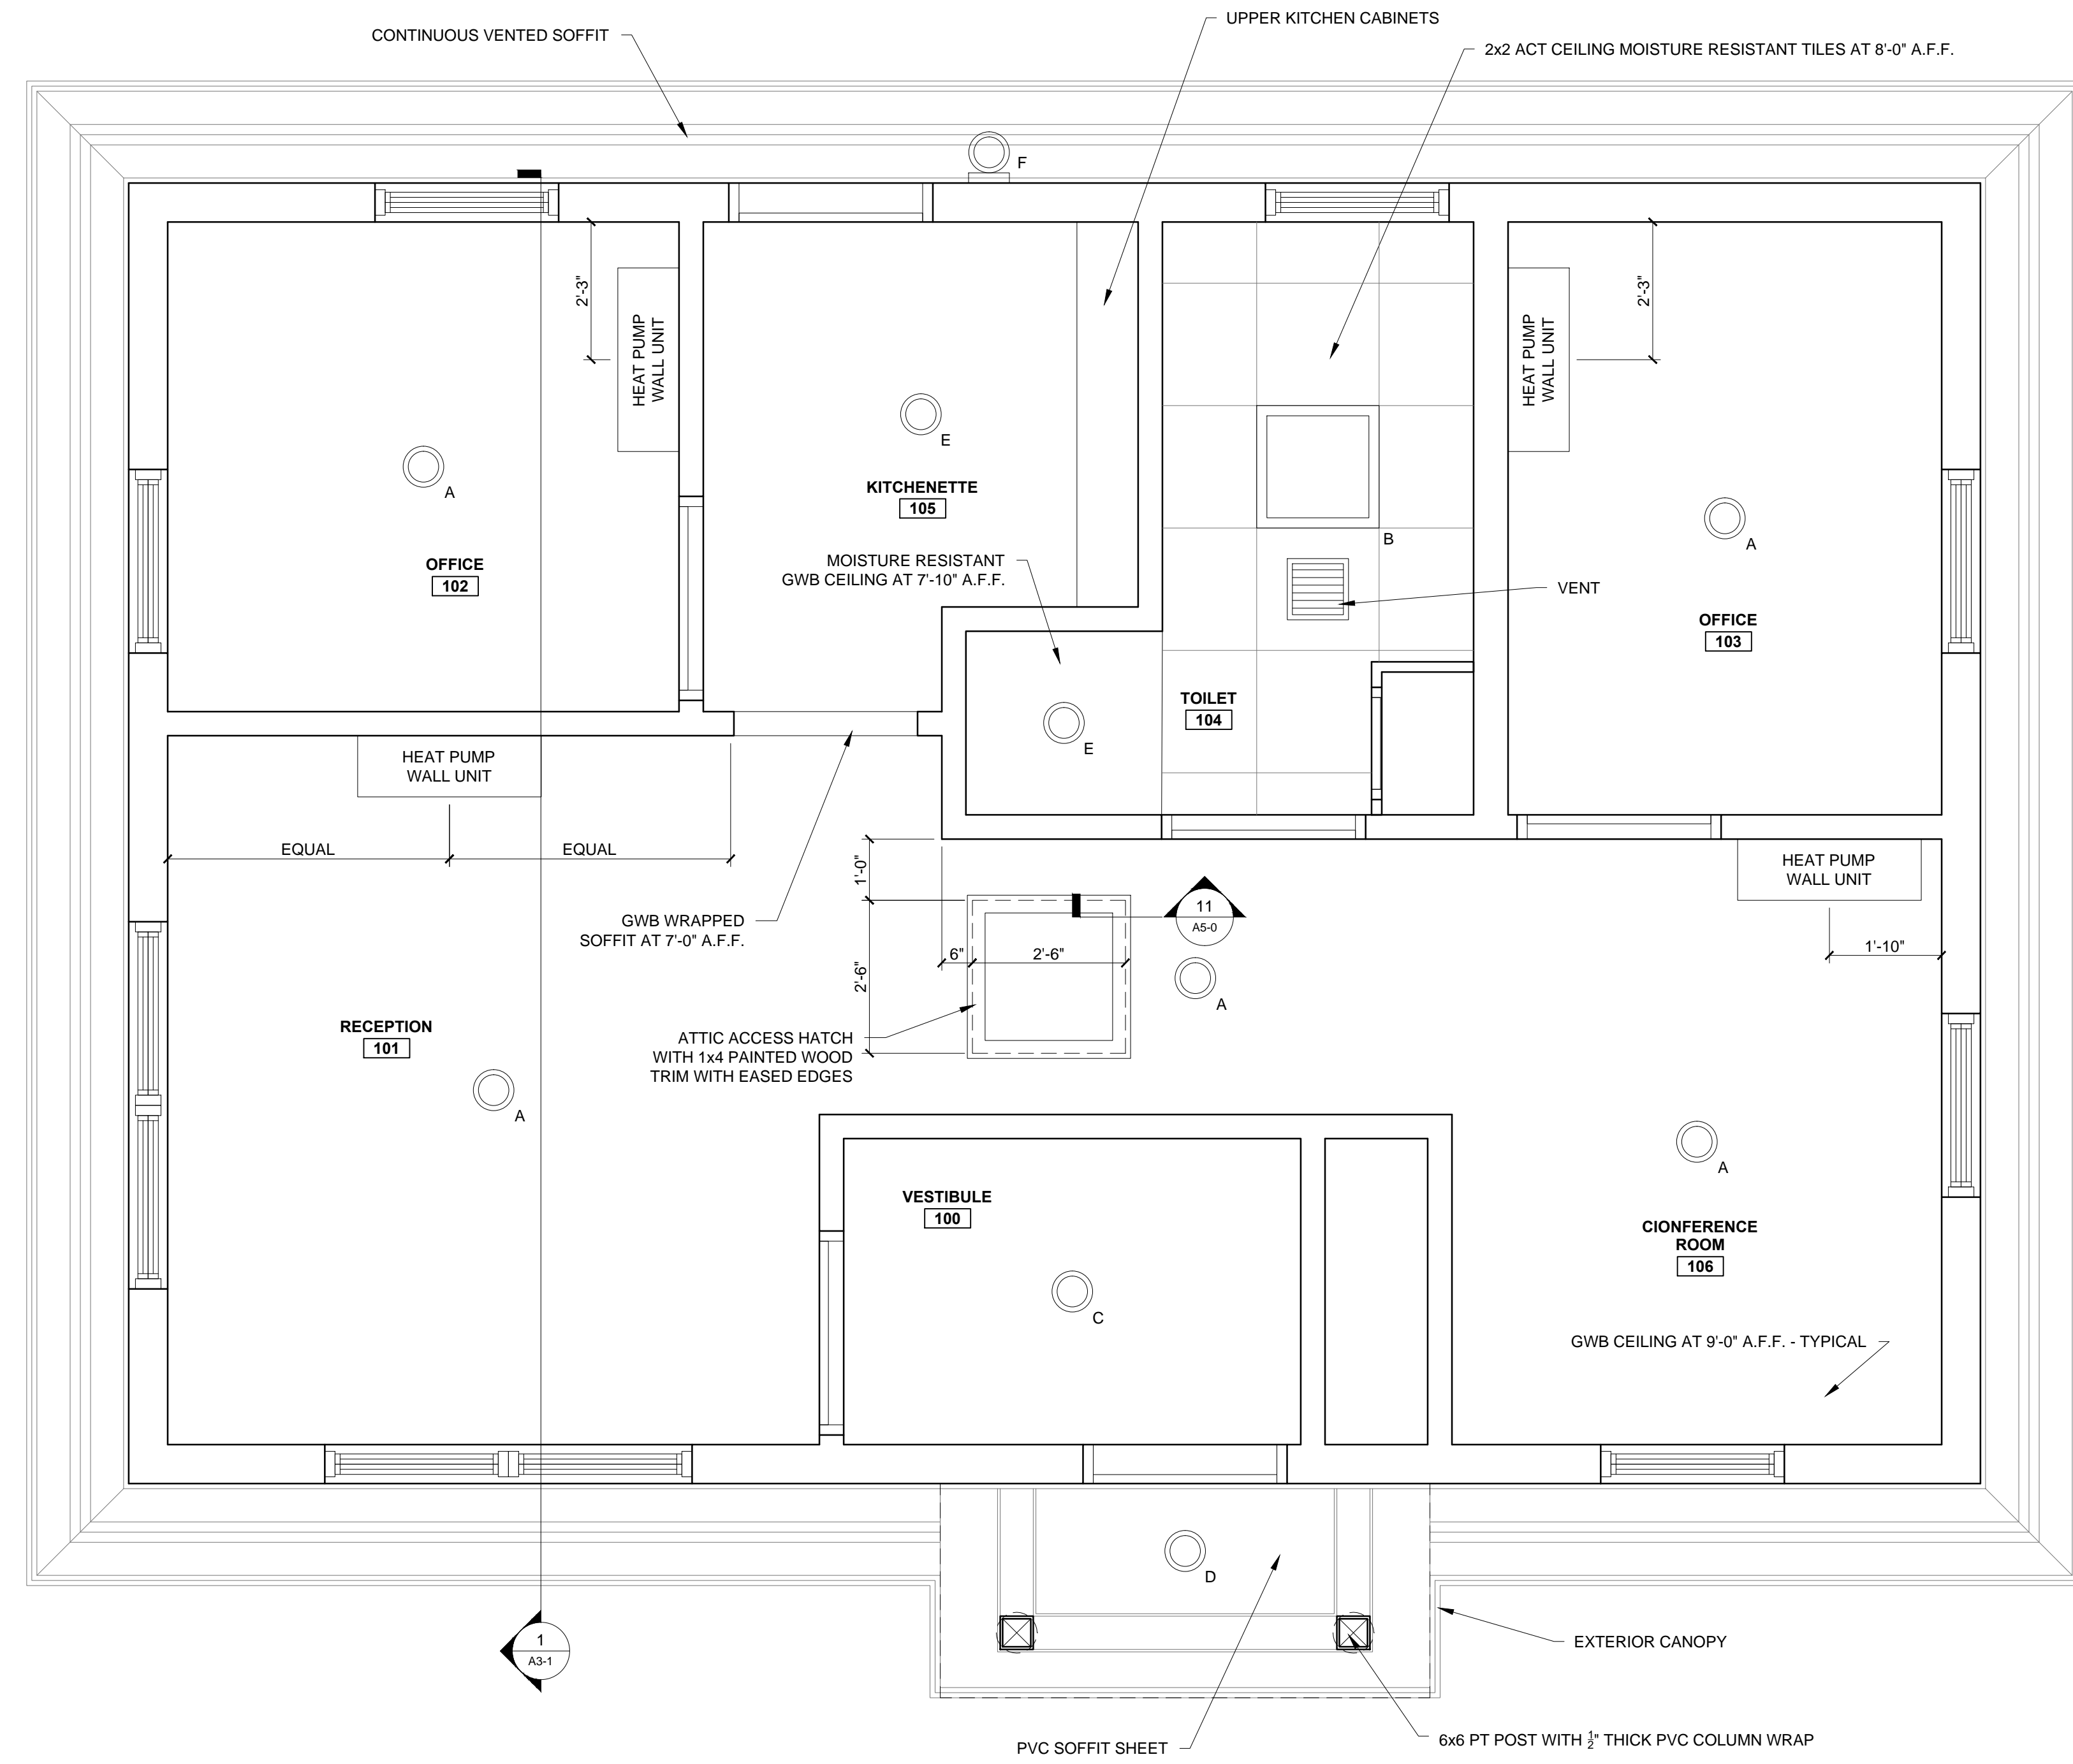

1 REFLECTED CEILING PLAN  
1/2" = 1'-0"

