



PROJECT:		THREE PHASE		PANEL DESIGNATION:	
WARREN AVE. CAR WASH PORTLAND, MAINE		PANEL BOARD SCHEDULE		PP	
MAN. BRKR: 600A 3P		SURFACE MOUNT		WIRE: 4	
VOLTS: 120/208		PHASE: 3		KVA LOAD	
PLC	1	20	2	HP PUMP STAND	
PLC	3	20	3E		
PRESOAK & TWO-STEP	5	20	100	HP PUMP STAND	
PRESOAK & TWO-STEP	7	20	8		
HP UNDERBODY	9	20	100		
HP UNDERBODY	15	20	14	WATER SOFTENER	
HP UNDERBODY	15	20	16	AIR COMPRESSOR	
BLOWERS	21	20	22	ENTRY STAND	
BLOWERS	27	20	24	RECEPT.	
BLOWERS	27	20	28	RECEPT. - OUTSIDE	
BLOWERS	27	20	30	UNIT HEATER	
WATER HEATER	33	20	34	LIGHTING - WASH BAY	
CIRC. PUMP	35	20	36	LIGHTING - INTERIOR	
BOILER	37	20	38	LIGHTING - WASH BAY	
SPACE	39	20	40	LIGHTING - EXTERIOR WALL PACKS	
SPACE	41	20	42	SPACE	
TOTAL CONN. LOAD		TOTAL DEM. LOAD			

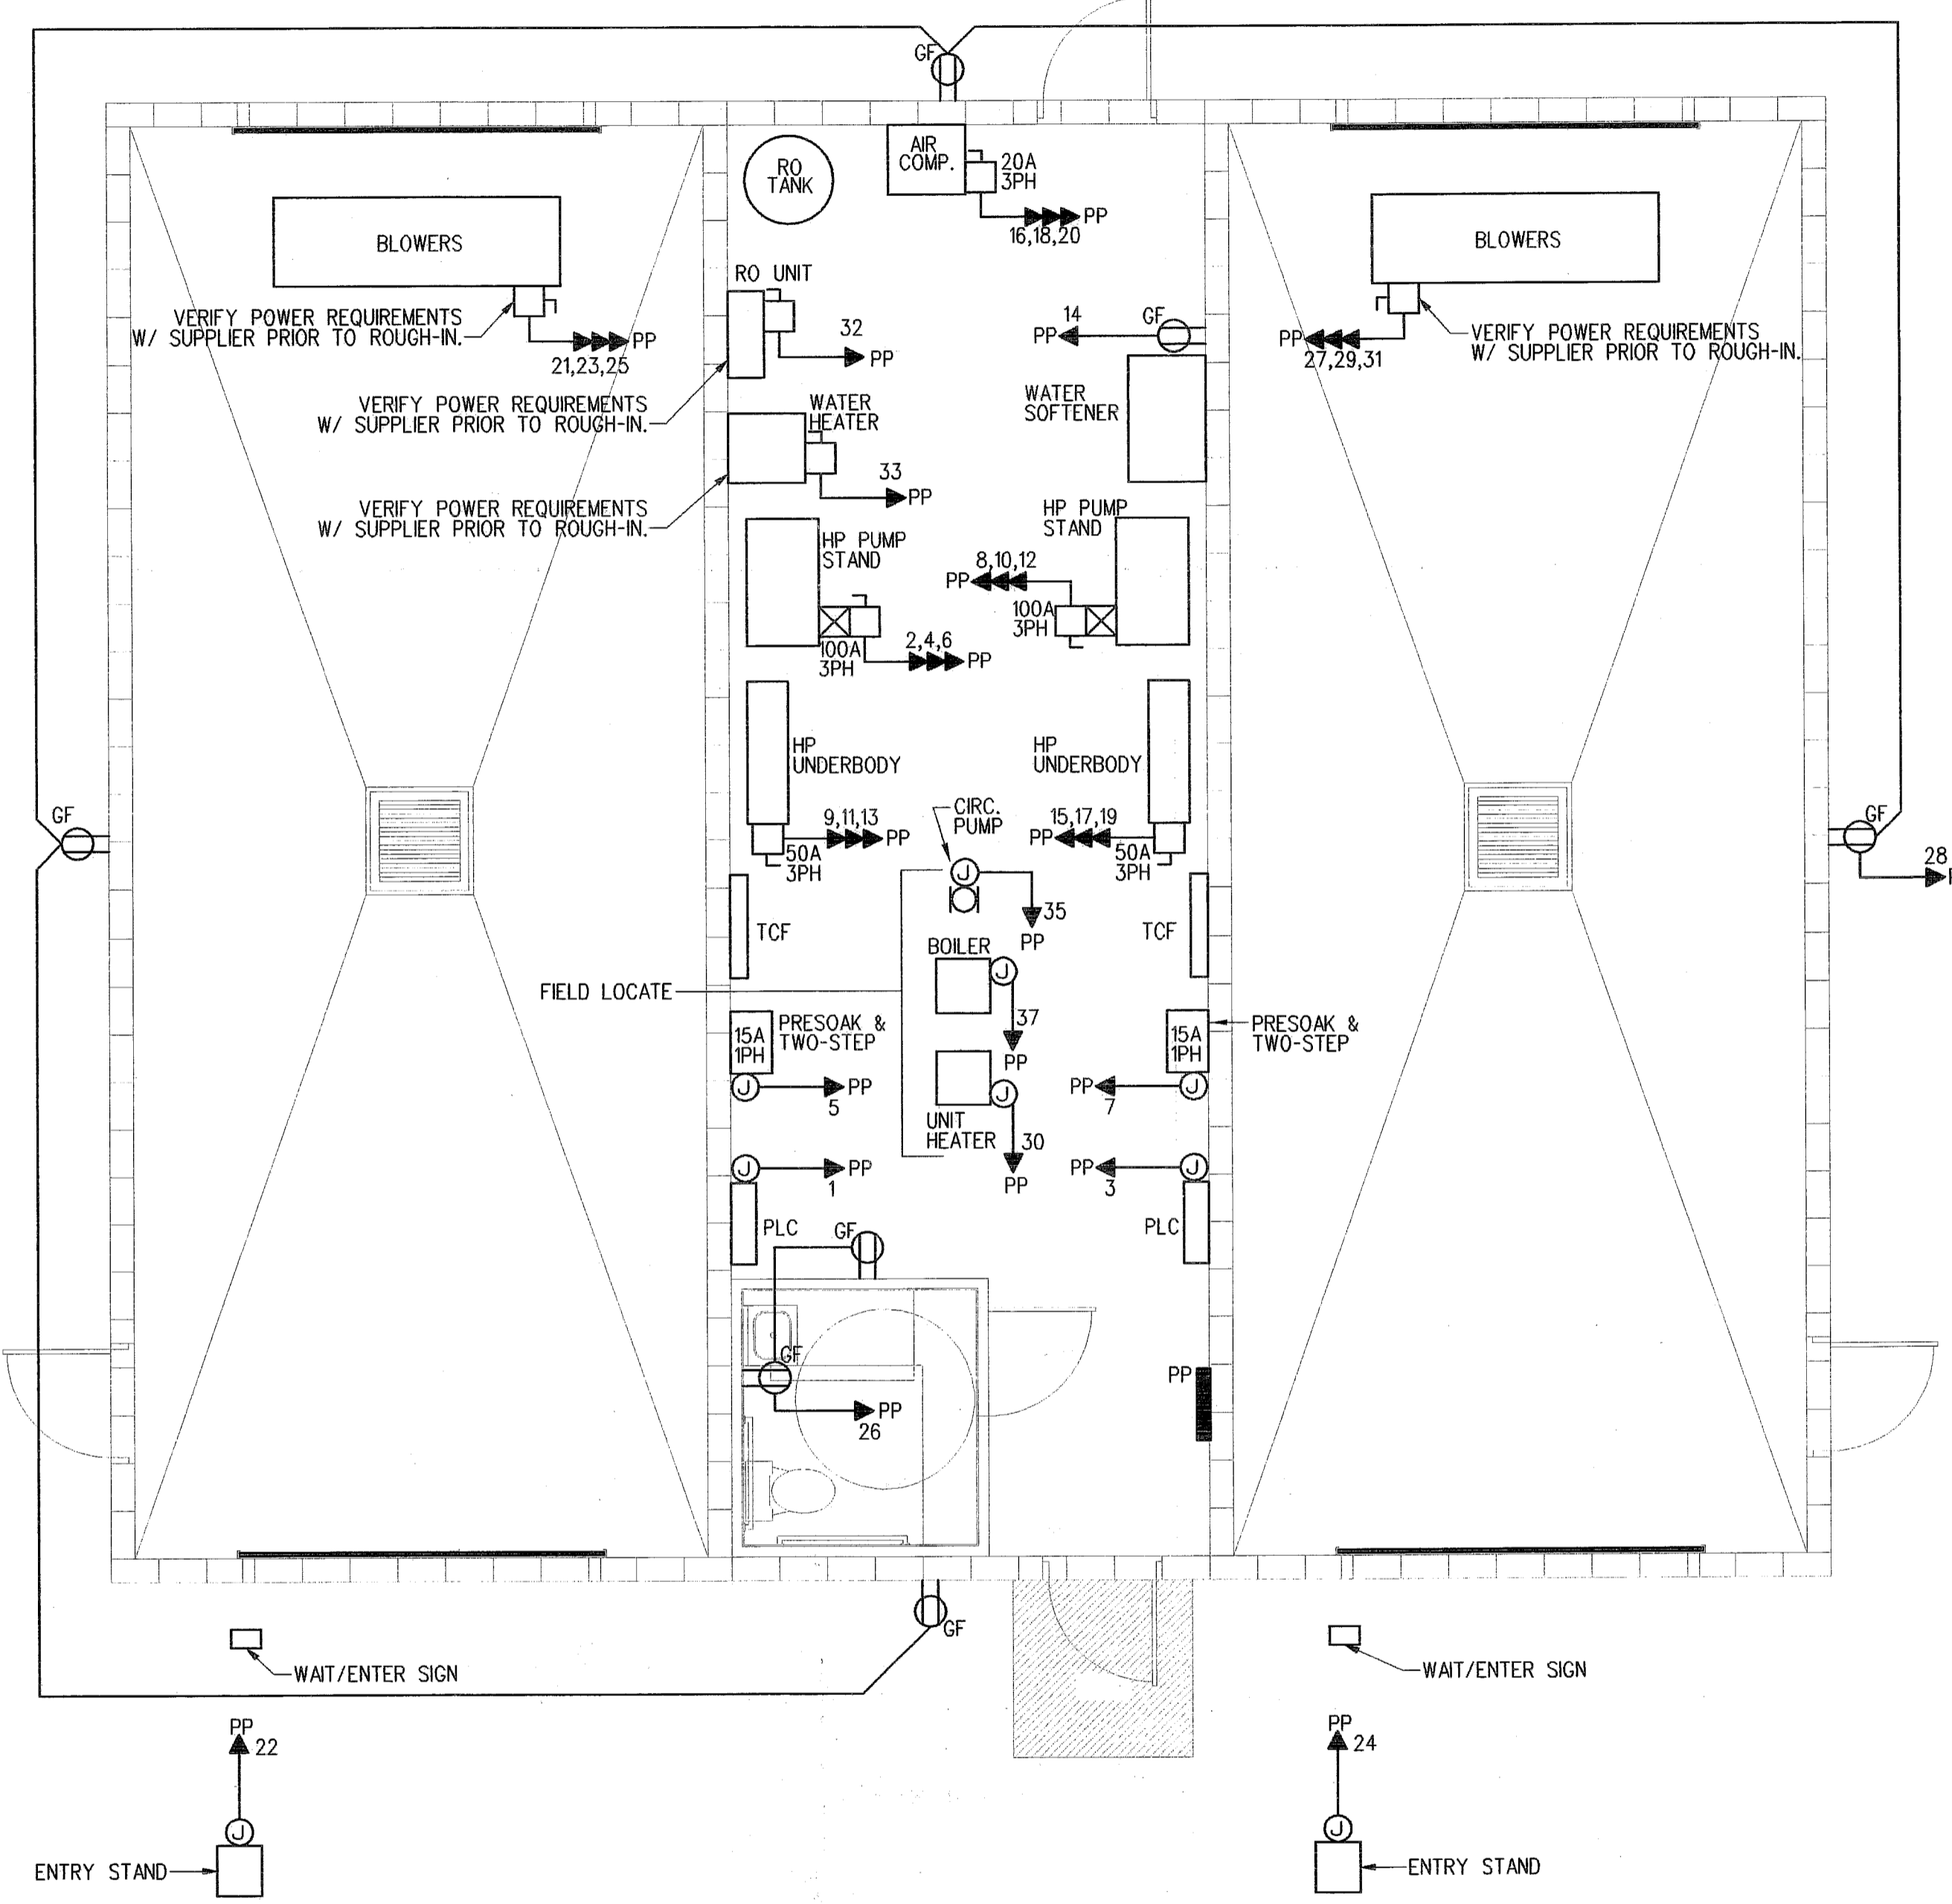


POWER PLAN
 SCALE: 1/4"=1'-0"

POWERPLAN PSI-00075 DATE: 05/20/04 NAME: EQUIPMENT ROOM LAYOUT ALL DIM ±.015" P/N: SCALE: NONE
 REV-04 DESCRIPTION: 2-D VIEW-TYPICAL EQUIPMENT ROOM LAYOUT ALL DIM ±.12" ALL DIM IN INCHES

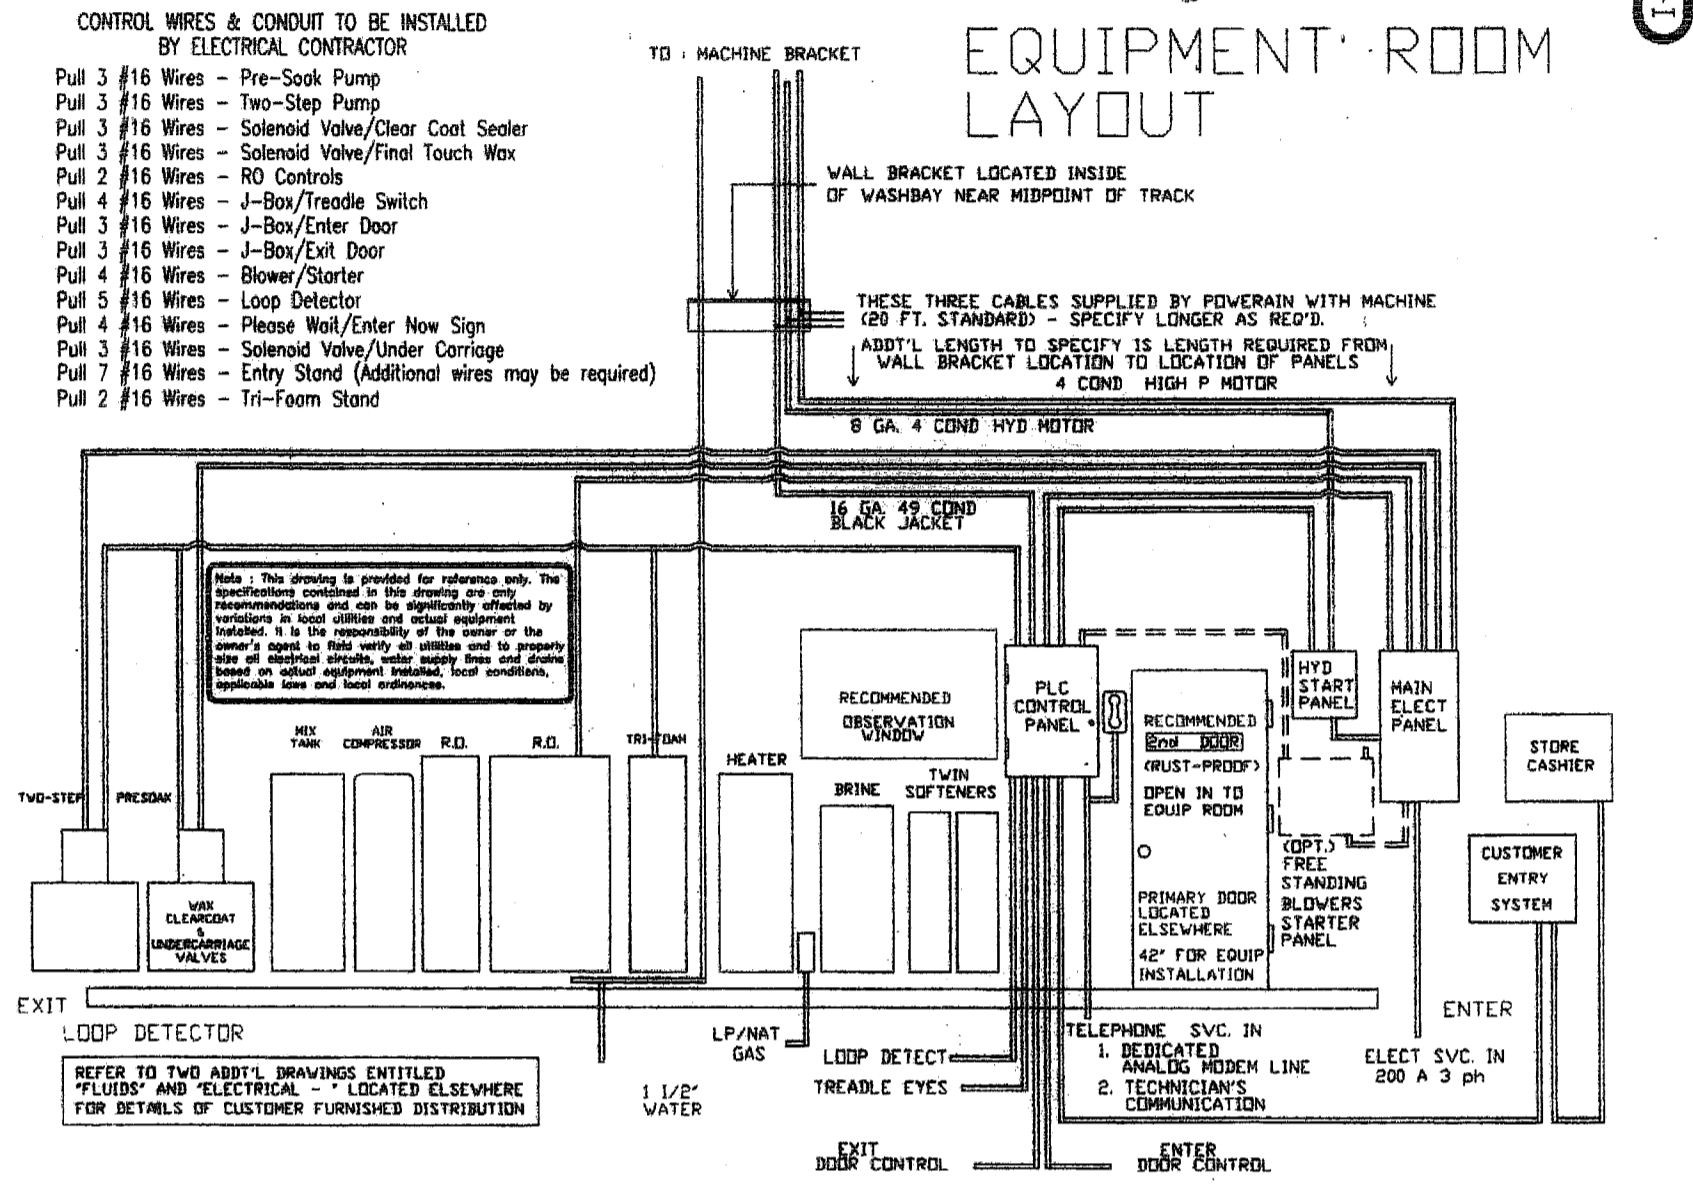

POWERPLAN PSI-00079 DATE: 05/26/04 NAME: ELECTRICAL DISTRIBUTION OVERVIEW ALL DIM ±.015" P/N: SCALE: NONE
 REV-05 DESCRIPTION: REMOTE BLOWERS-OVERVIEW FOR INSTALLATION WITH ON-BOARD WATER PUMPING

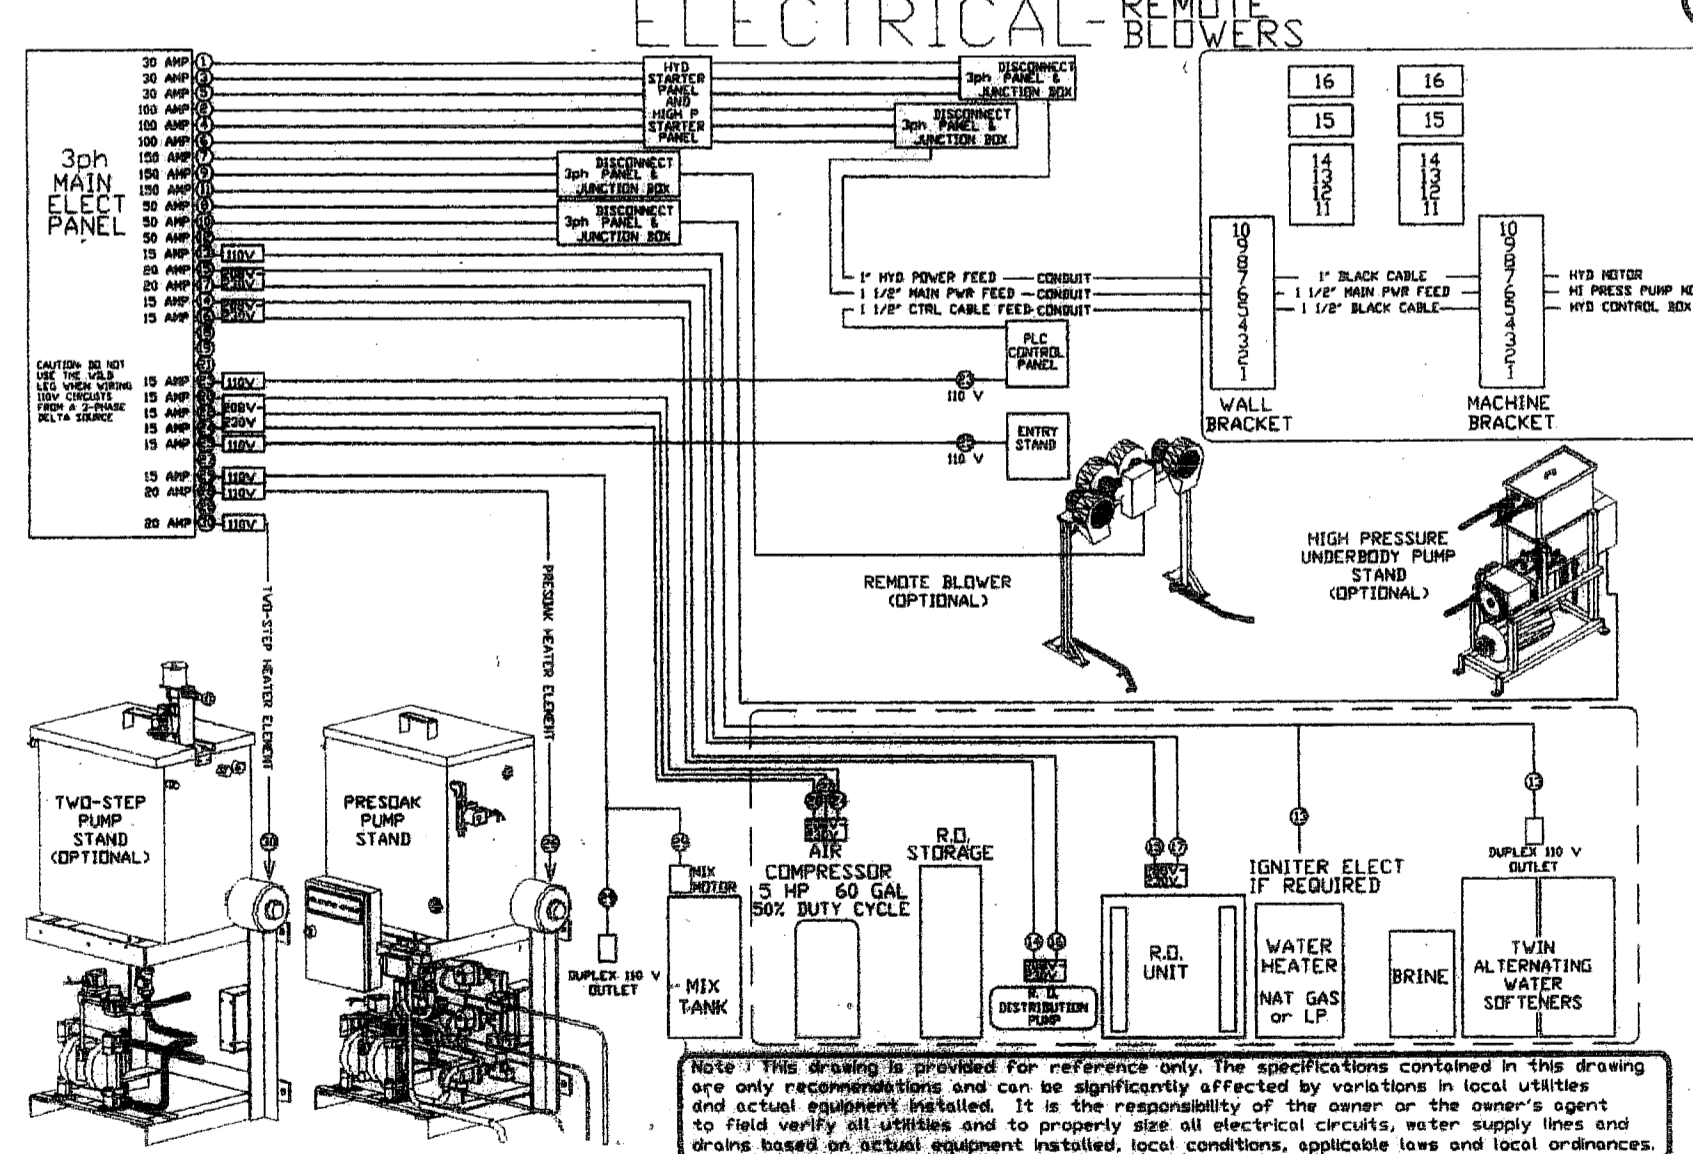

REVISIONS	NO.	DATE	DESCRIPTION

DRAWN BY: CJM
 CHECKED BY: CWA
 PROJECT NO.
 SCALE: AS NOTED
 DATE: 7/20/06