


OUTLET CONTROL STRUCTURE
NOT TO SCALE

LEGEND:

- W — W — WATER LINE
- UE/TV/CATV — UNDERGROUND ELECTRIC, TELEPHONE, CABLE TV
- S — S — GRAVITY SEWER
- S — FM — S — SEWER FORCE MAIN
- D — D — STORM DRAIN
- TRANSFORMER PAD
- SEWER MANHOLE
- SEWER EJECTOR PUMP
- STORM DRAIN MANHOLE
- CATCH BASIN
- FIRE HYDRANT
- WATER VALVE

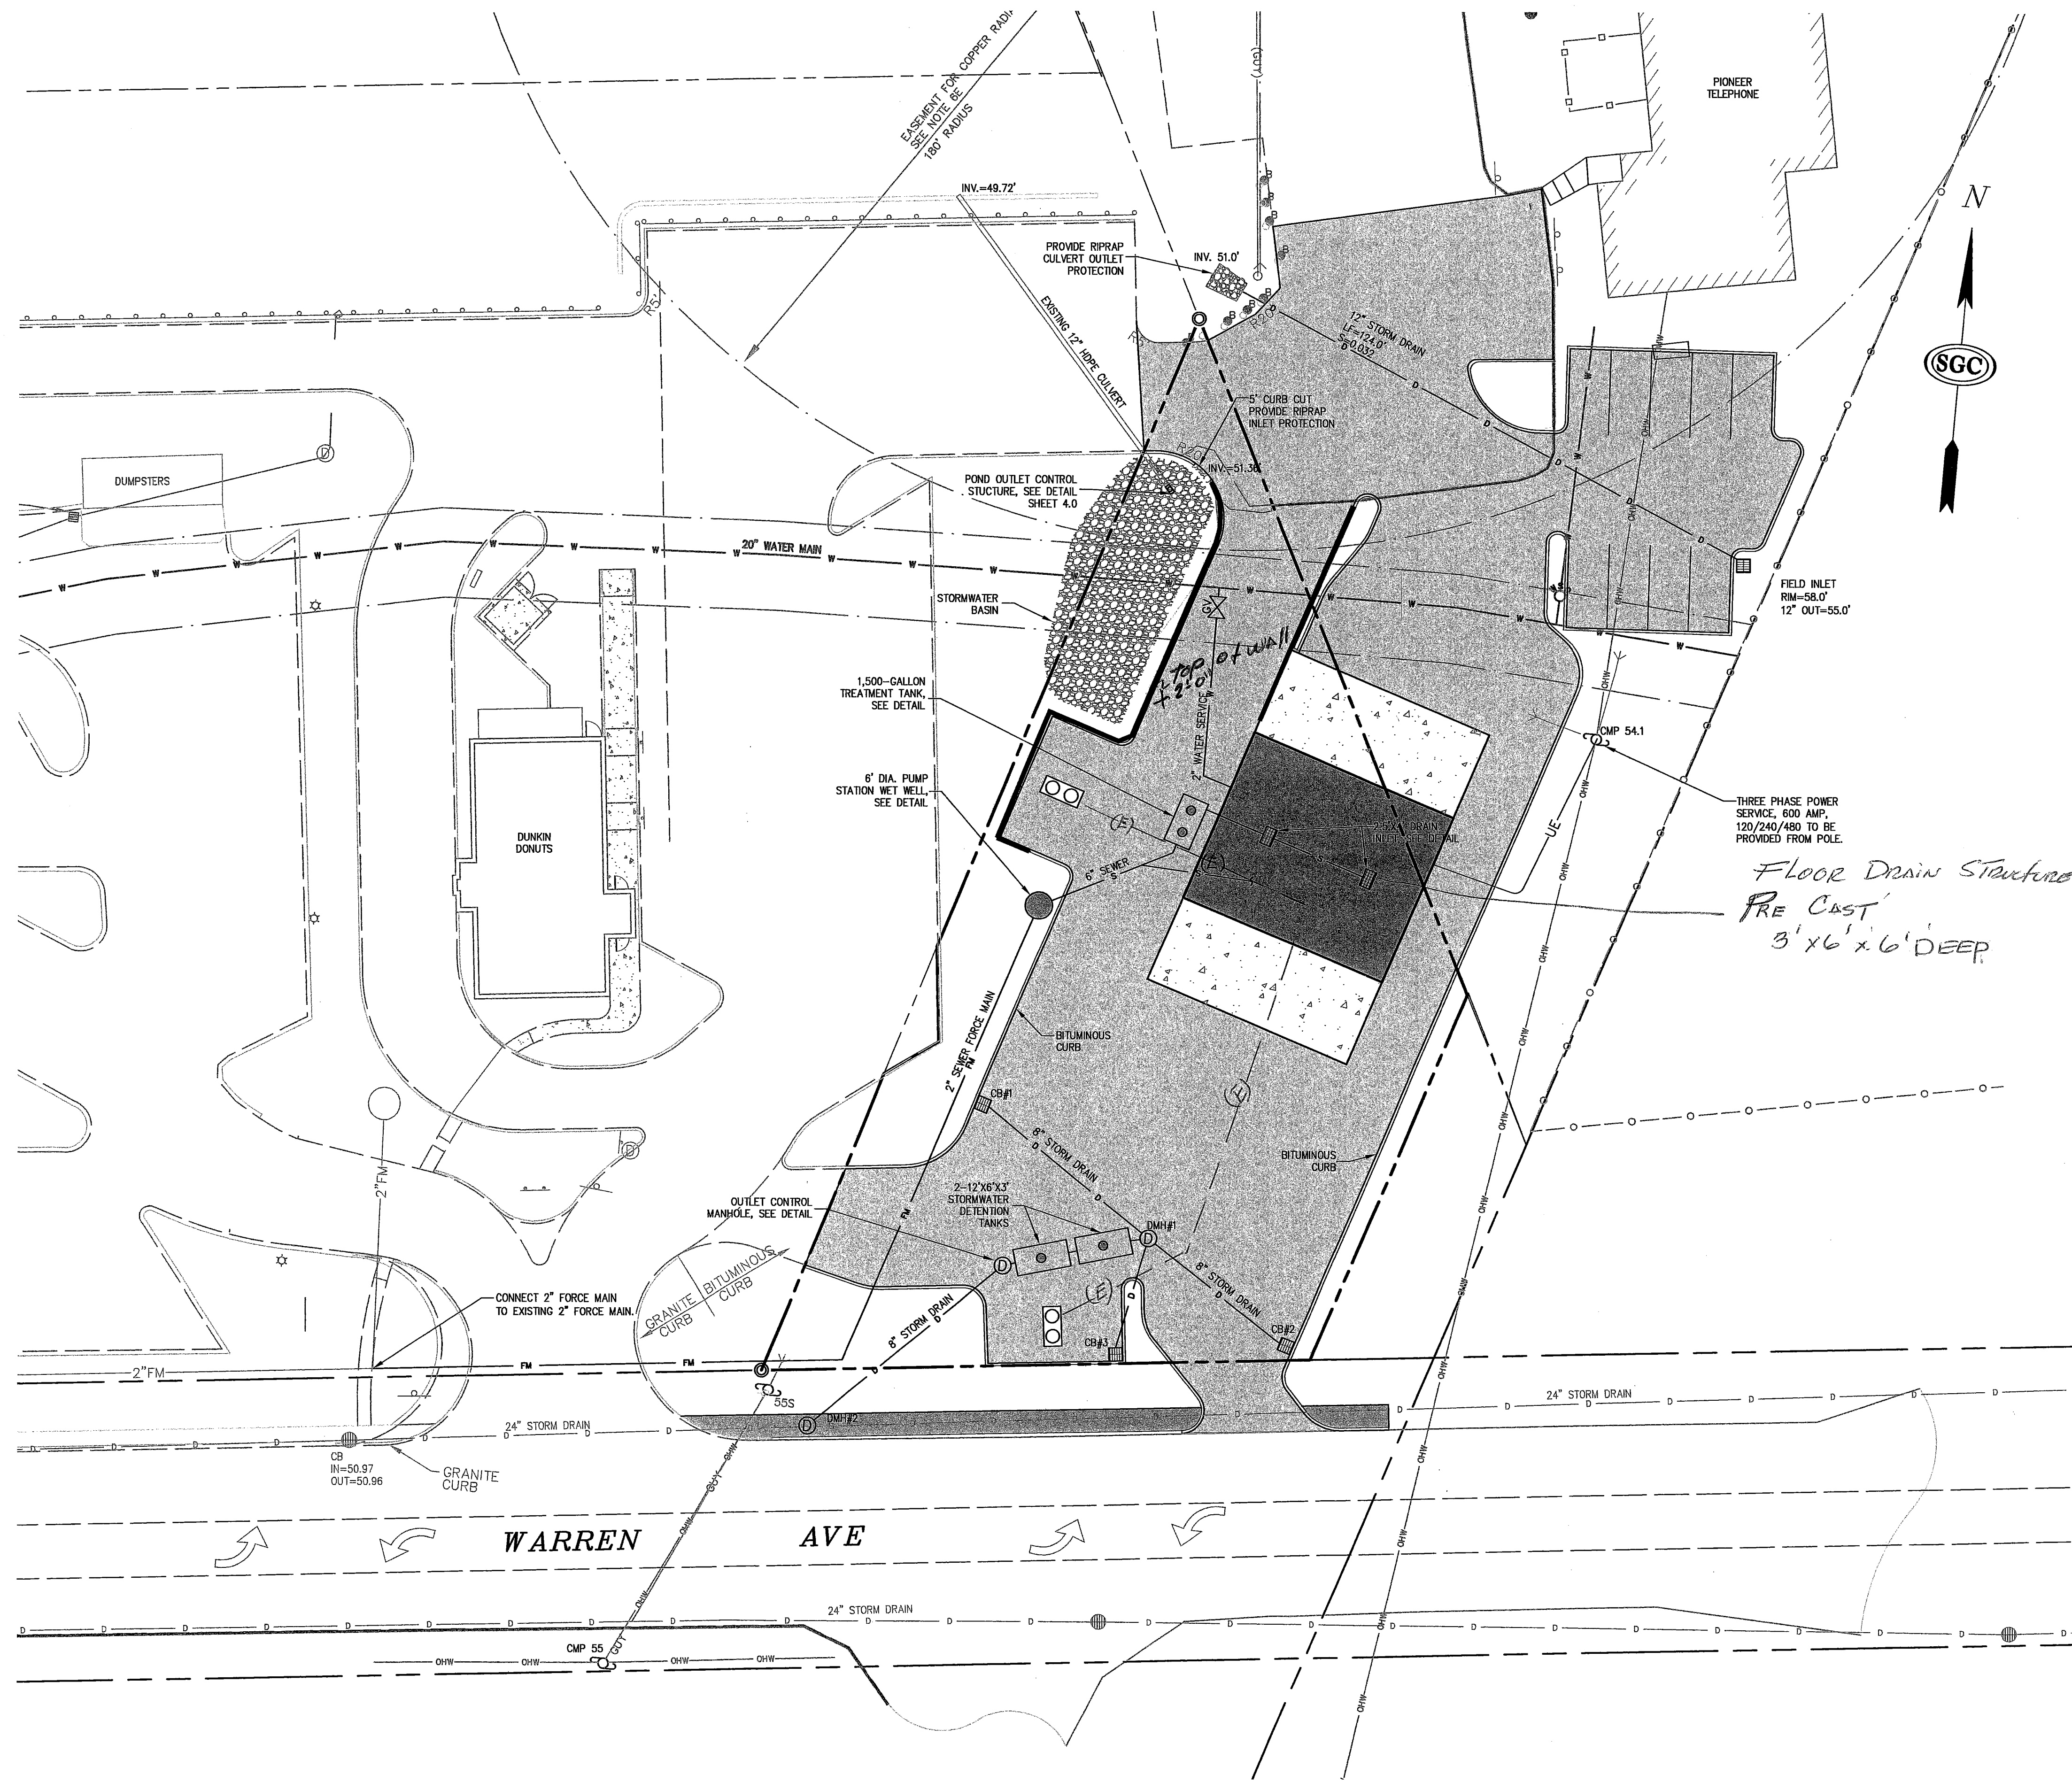

*FLOOR DRAIN Structure
PRE CAST
3'x6'x6' DEEP*

REVISIONS:

NO.	DATE	DESCRIPTION
0	01-24-06	PRELIMINARY PLAN SUBMISSION

SGC ENGINEERING, LLC
 • Civil Design & Survey Engineering
 • Environmental & Regulatory Permitting
 • Electrical, Power Systems Engineering

SGC
 SERVING OUR CLIENTS IN THE U.S.A. & CANADA
 Target Technology Center
 20 Oakley Drive, Suite 920
 Westborough, MA 01581
 Tel: 508-866-6900
 Fax: 508-866-6901

ONLY VALID WITH ORIGINAL STAMP

PREPARED FOR:
CP&S ASSOCIATES, LLC.
 1 BROOKSIDE DRIVE
 FALMOUTH, MAINE 04105

DATE: 08/28/05 | PROJECT: 40300102
 DRAWN: JMR | CHECK: JMR | FILE: SITE_PLAN_403001.DWG

TITLE:
UTILITY PLAN
 CPS ASSOCIATES CARWASH
 WARREN AVENUE
 PORTLAND, MAINE 04103

SHEET:
4.0

SCALE: 1" = 20'