


5" GRANULAR BASE @ DOOR THRESHOLD
NOT TO SCALE


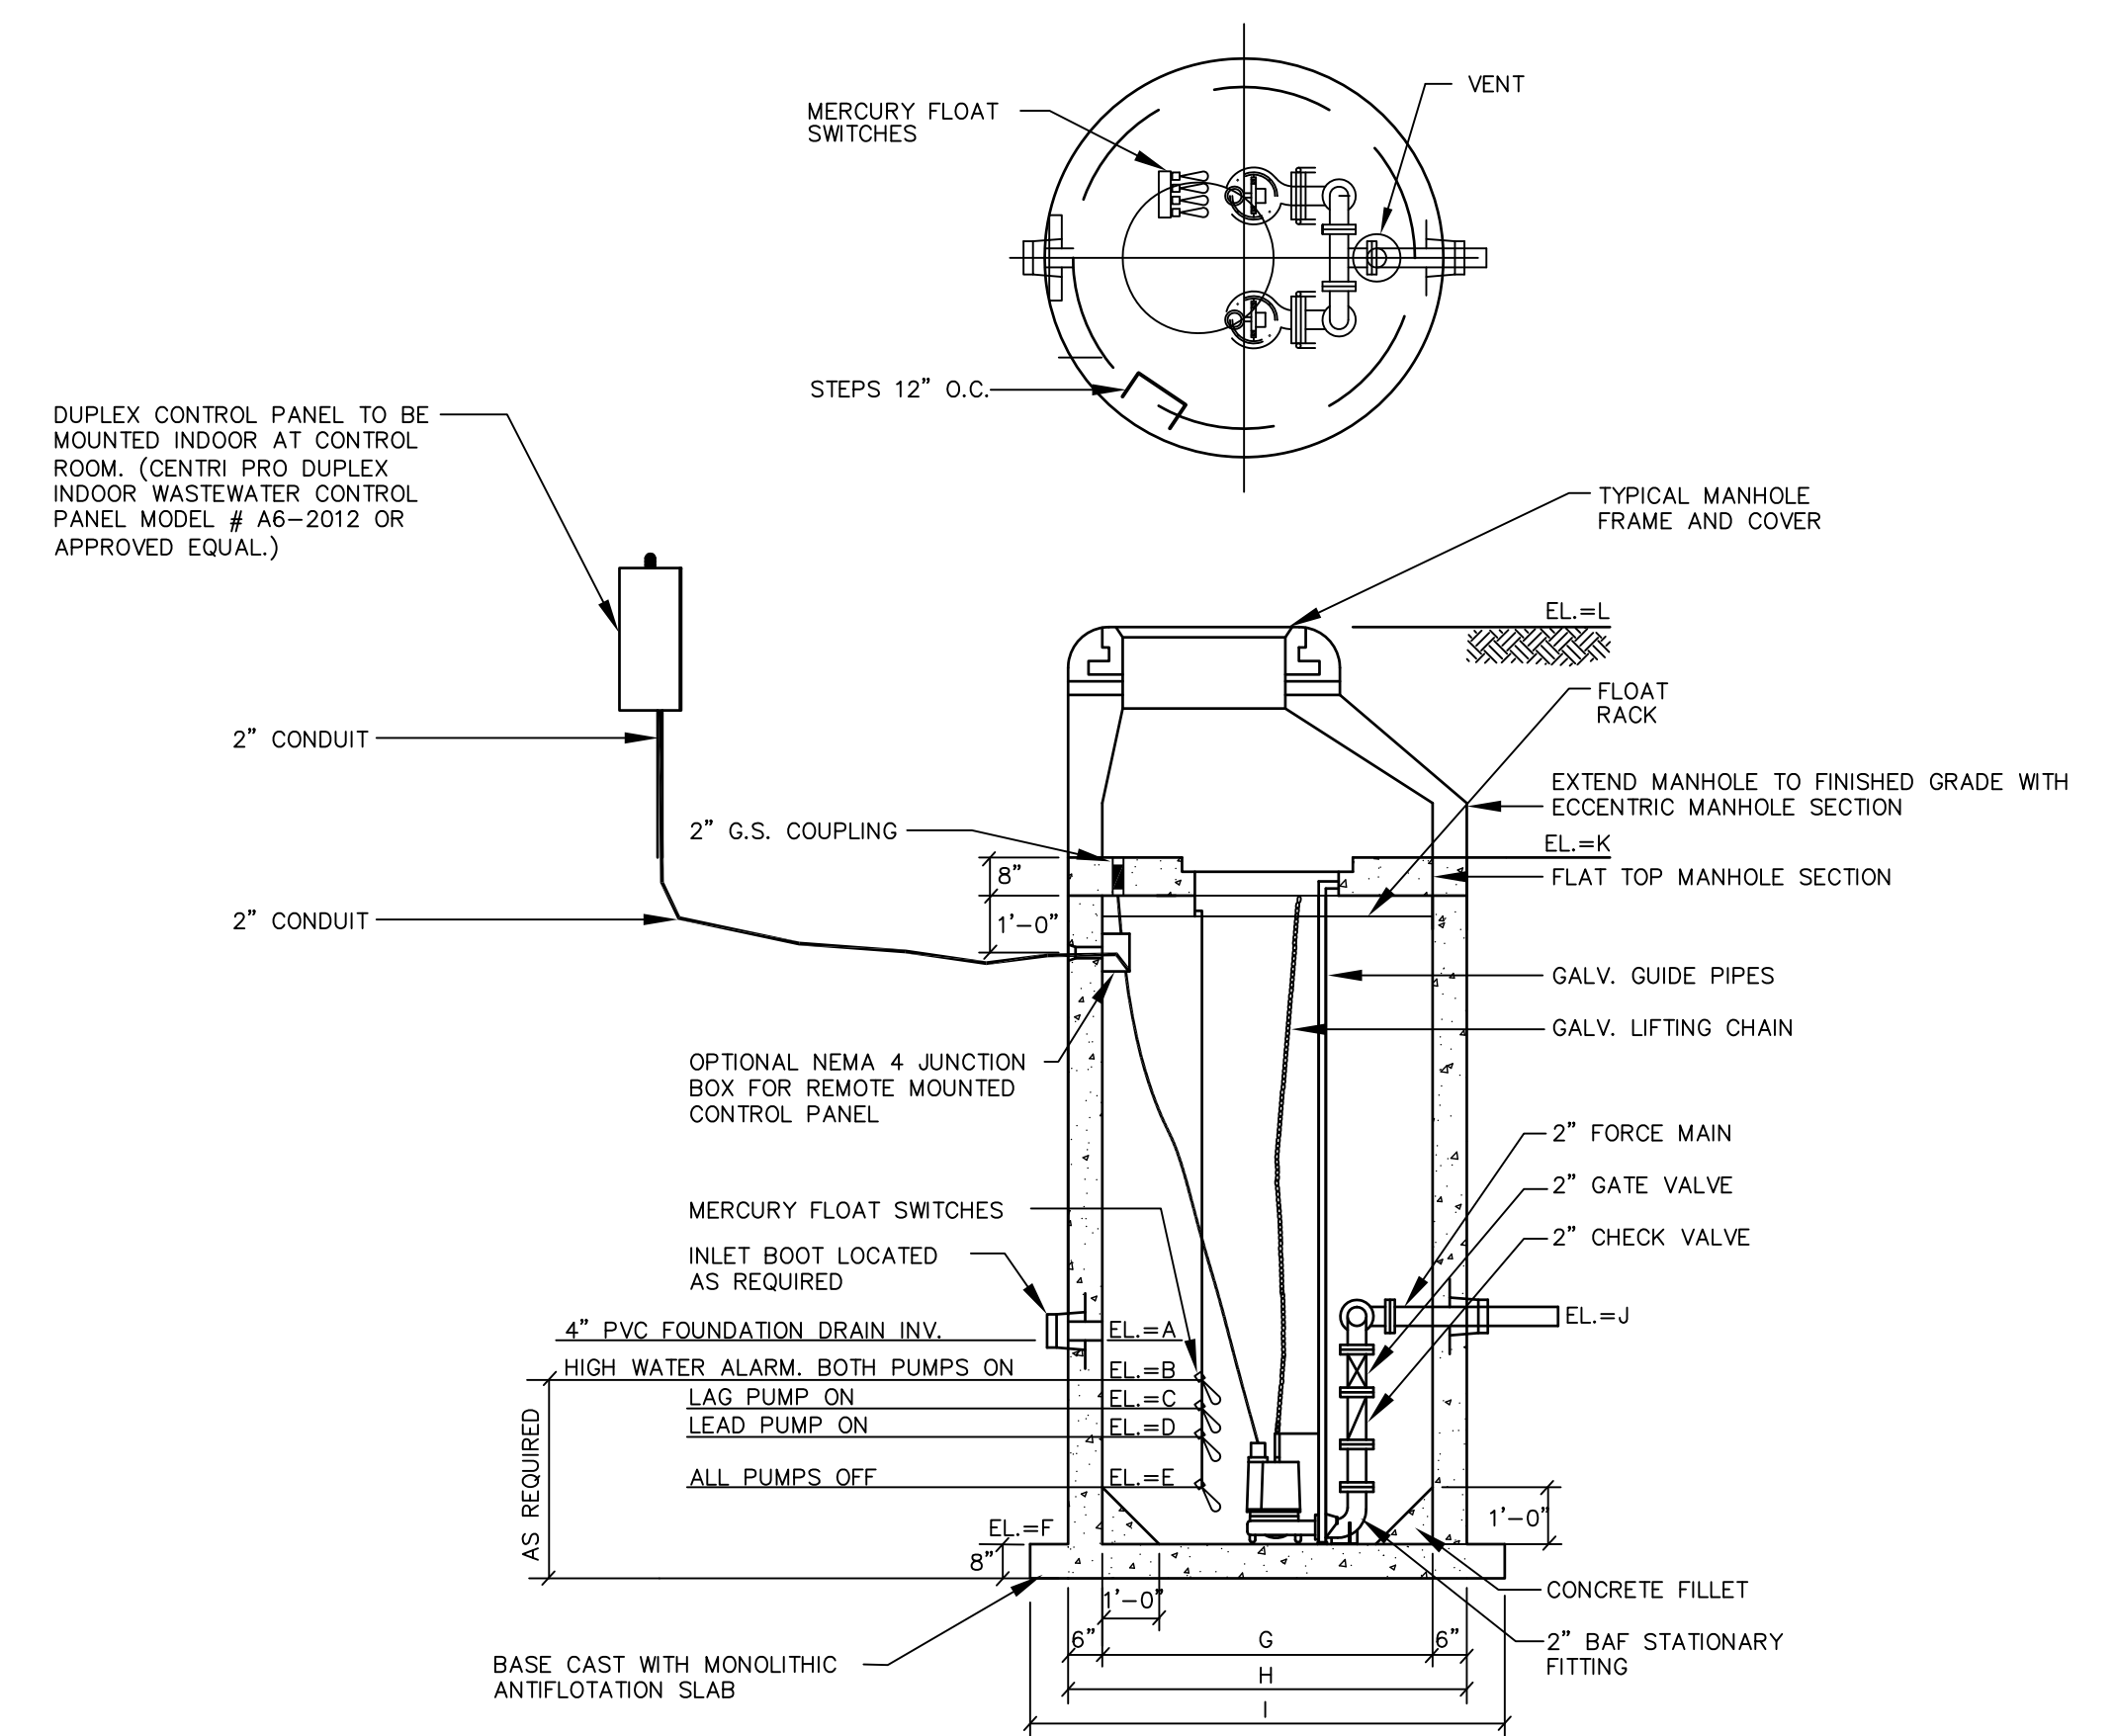


PUMP MODEL	PS-1
BARNES PUMPS	
SERIES 3P33	
1/3 HP	
3450 RPM	
30 GPM	
15 TDH	

PUMP STATION SCHEDULE										
PUMP STATION	A	B	C	D	E	F	G	H	I	
I	63.7	63.6	63.3	63.0	62.5	61.5	4	5	7	69.0 71.5 74.5



PUMP STATION
NOT TO SCALE

FOUNDATION DRAIN PUMP STATION DETAIL
SCALE: N.T.S.

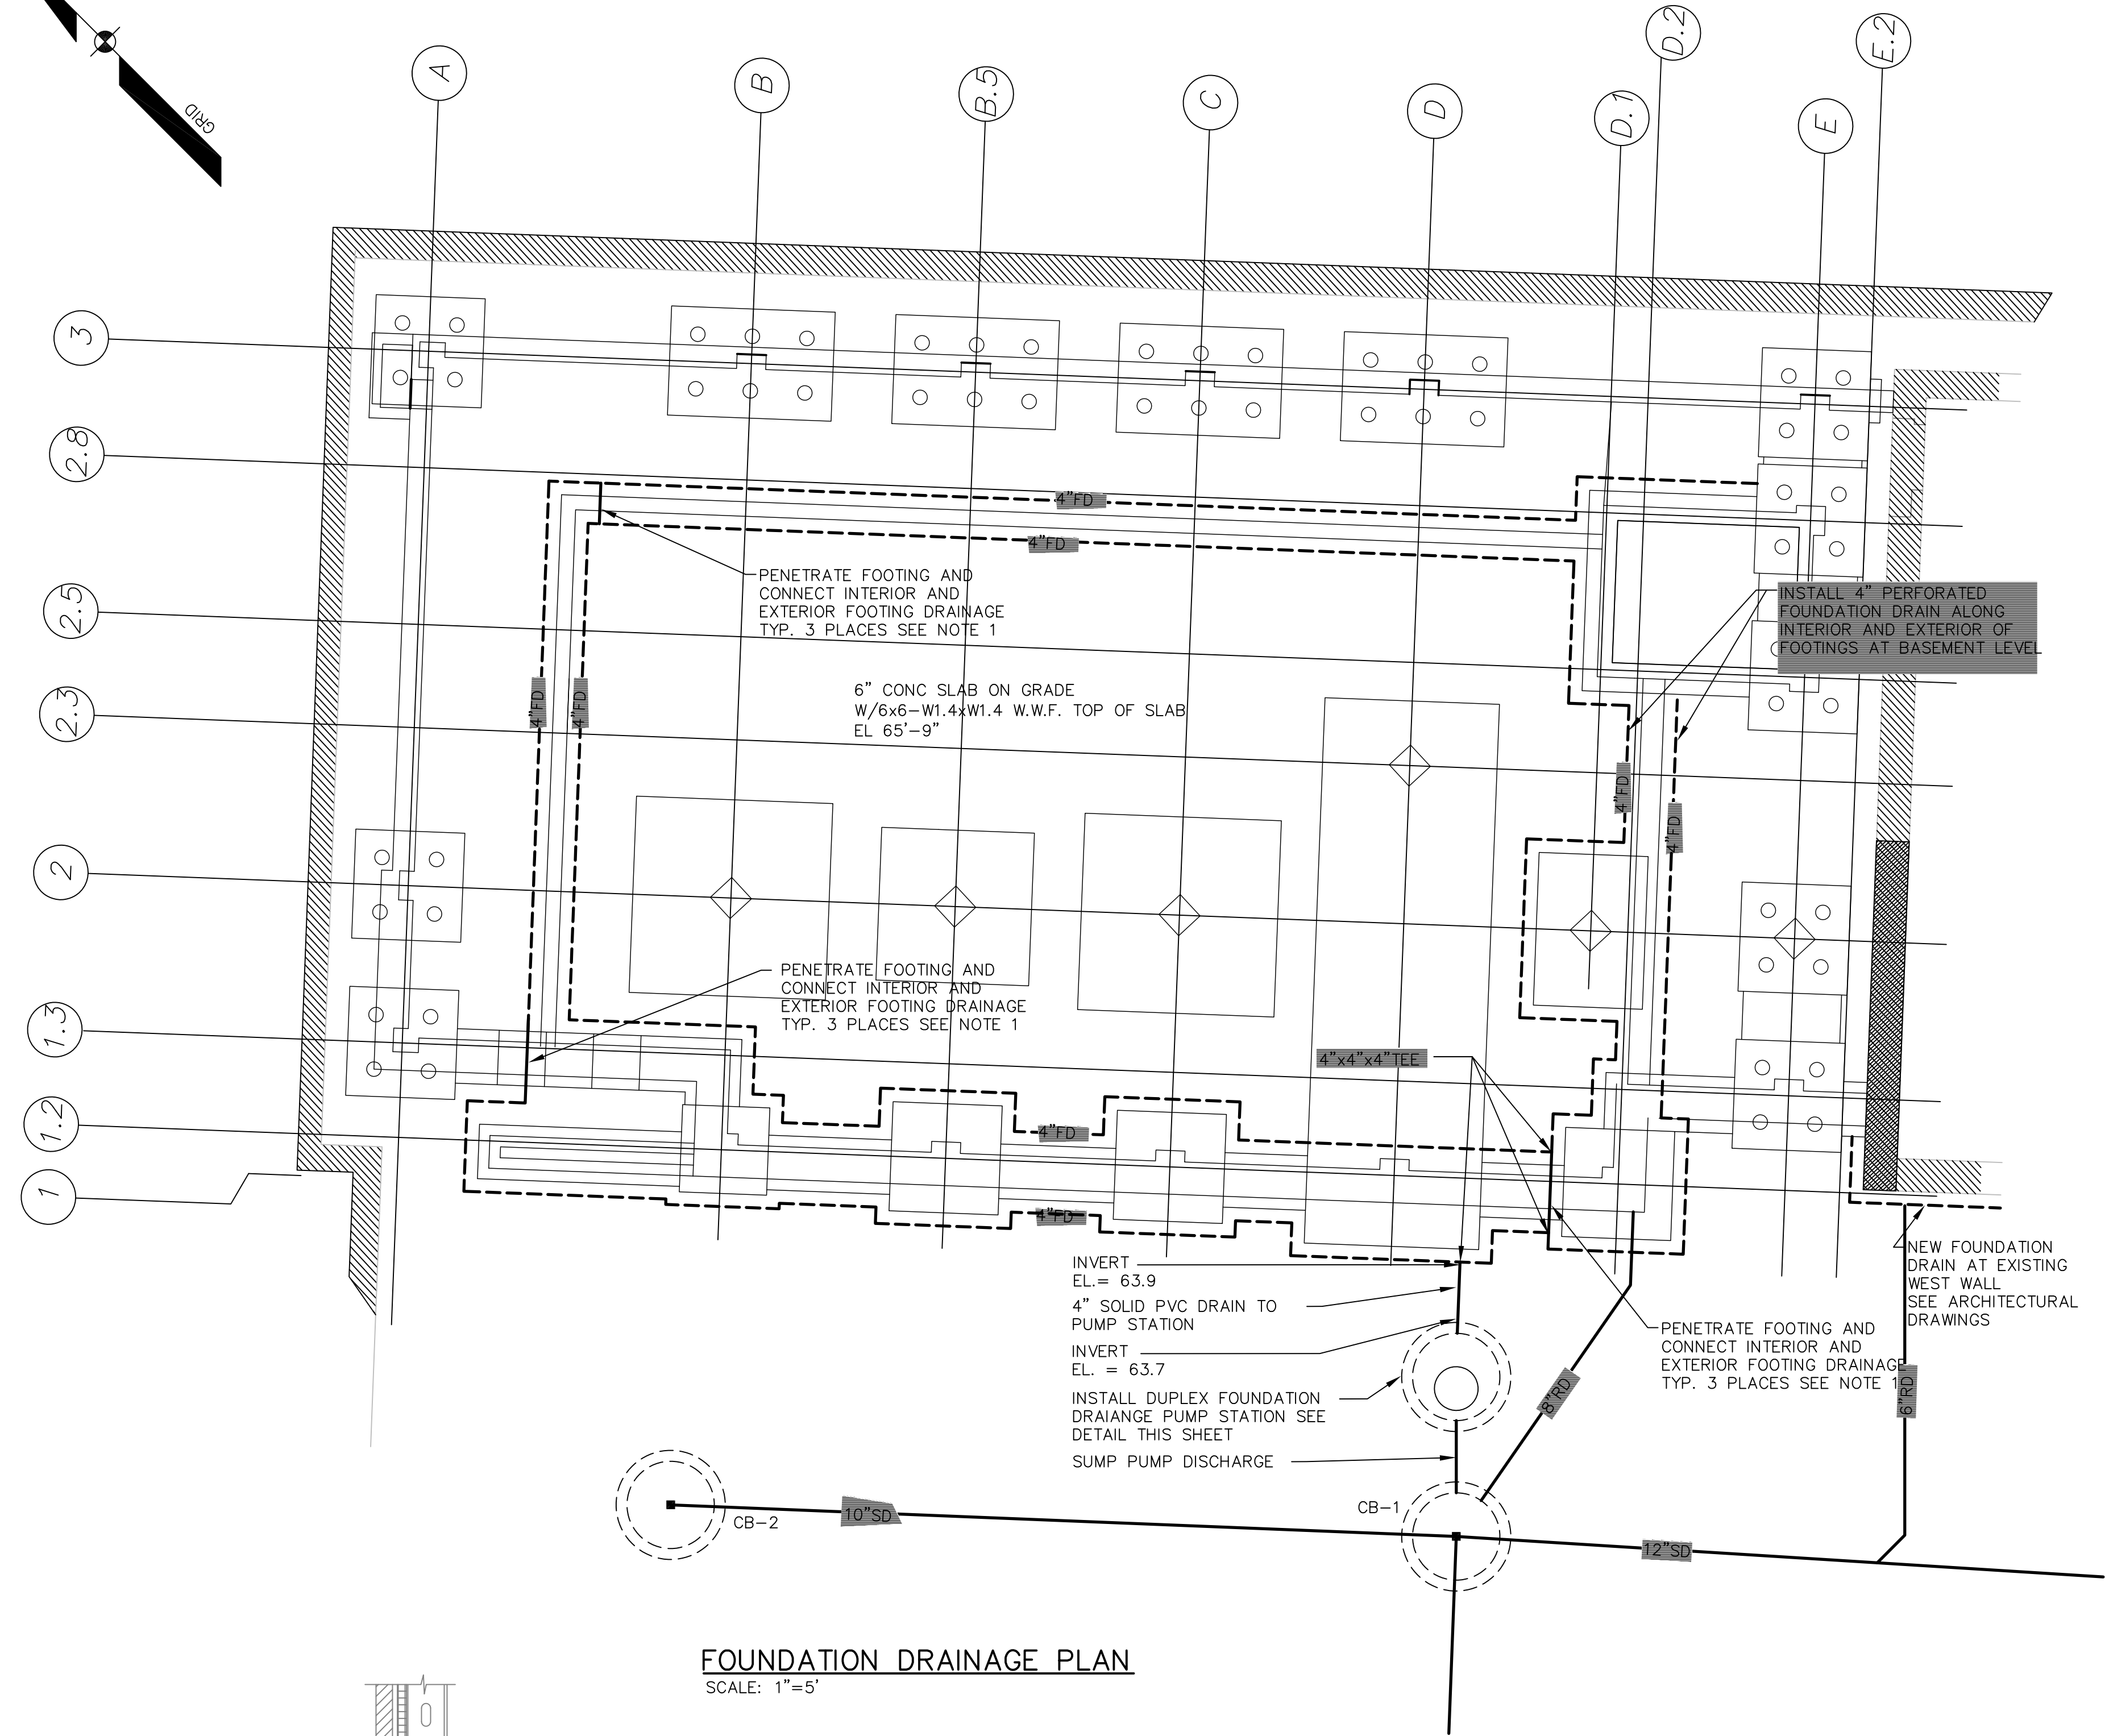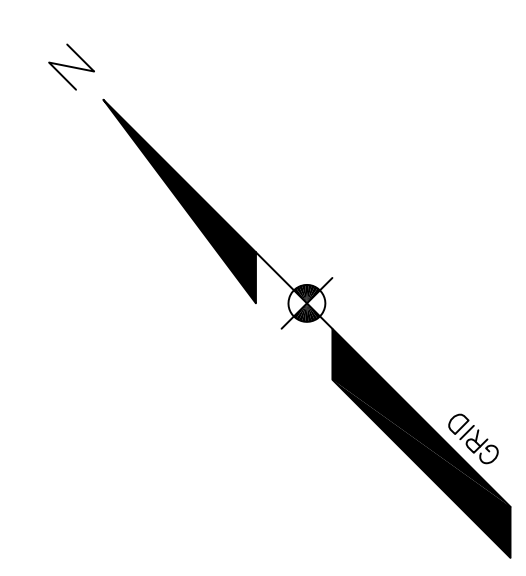

FOUNDATION DRAINAGE PLAN
SCALE: 1"=5'

- FOUNDATION DRAINAGE NOTES:**
1. PENETRATE FOOTING WITH SOLID PVC UNDERDRAIN PIPE. CONNECT INTERIOR AND EXTERIOR FOOTING DRAINS. SEE STRUCTURAL PLANS FOR THICKENED FOOTING SECTION.
 2. FOUNDATION PLAN IS SHOWN FOR REFERENCE ONLY. SEE STRUCTURAL PLANS FOR FOUNDATION DIMENSIONS, ELEVATIONS AND DETAILS.

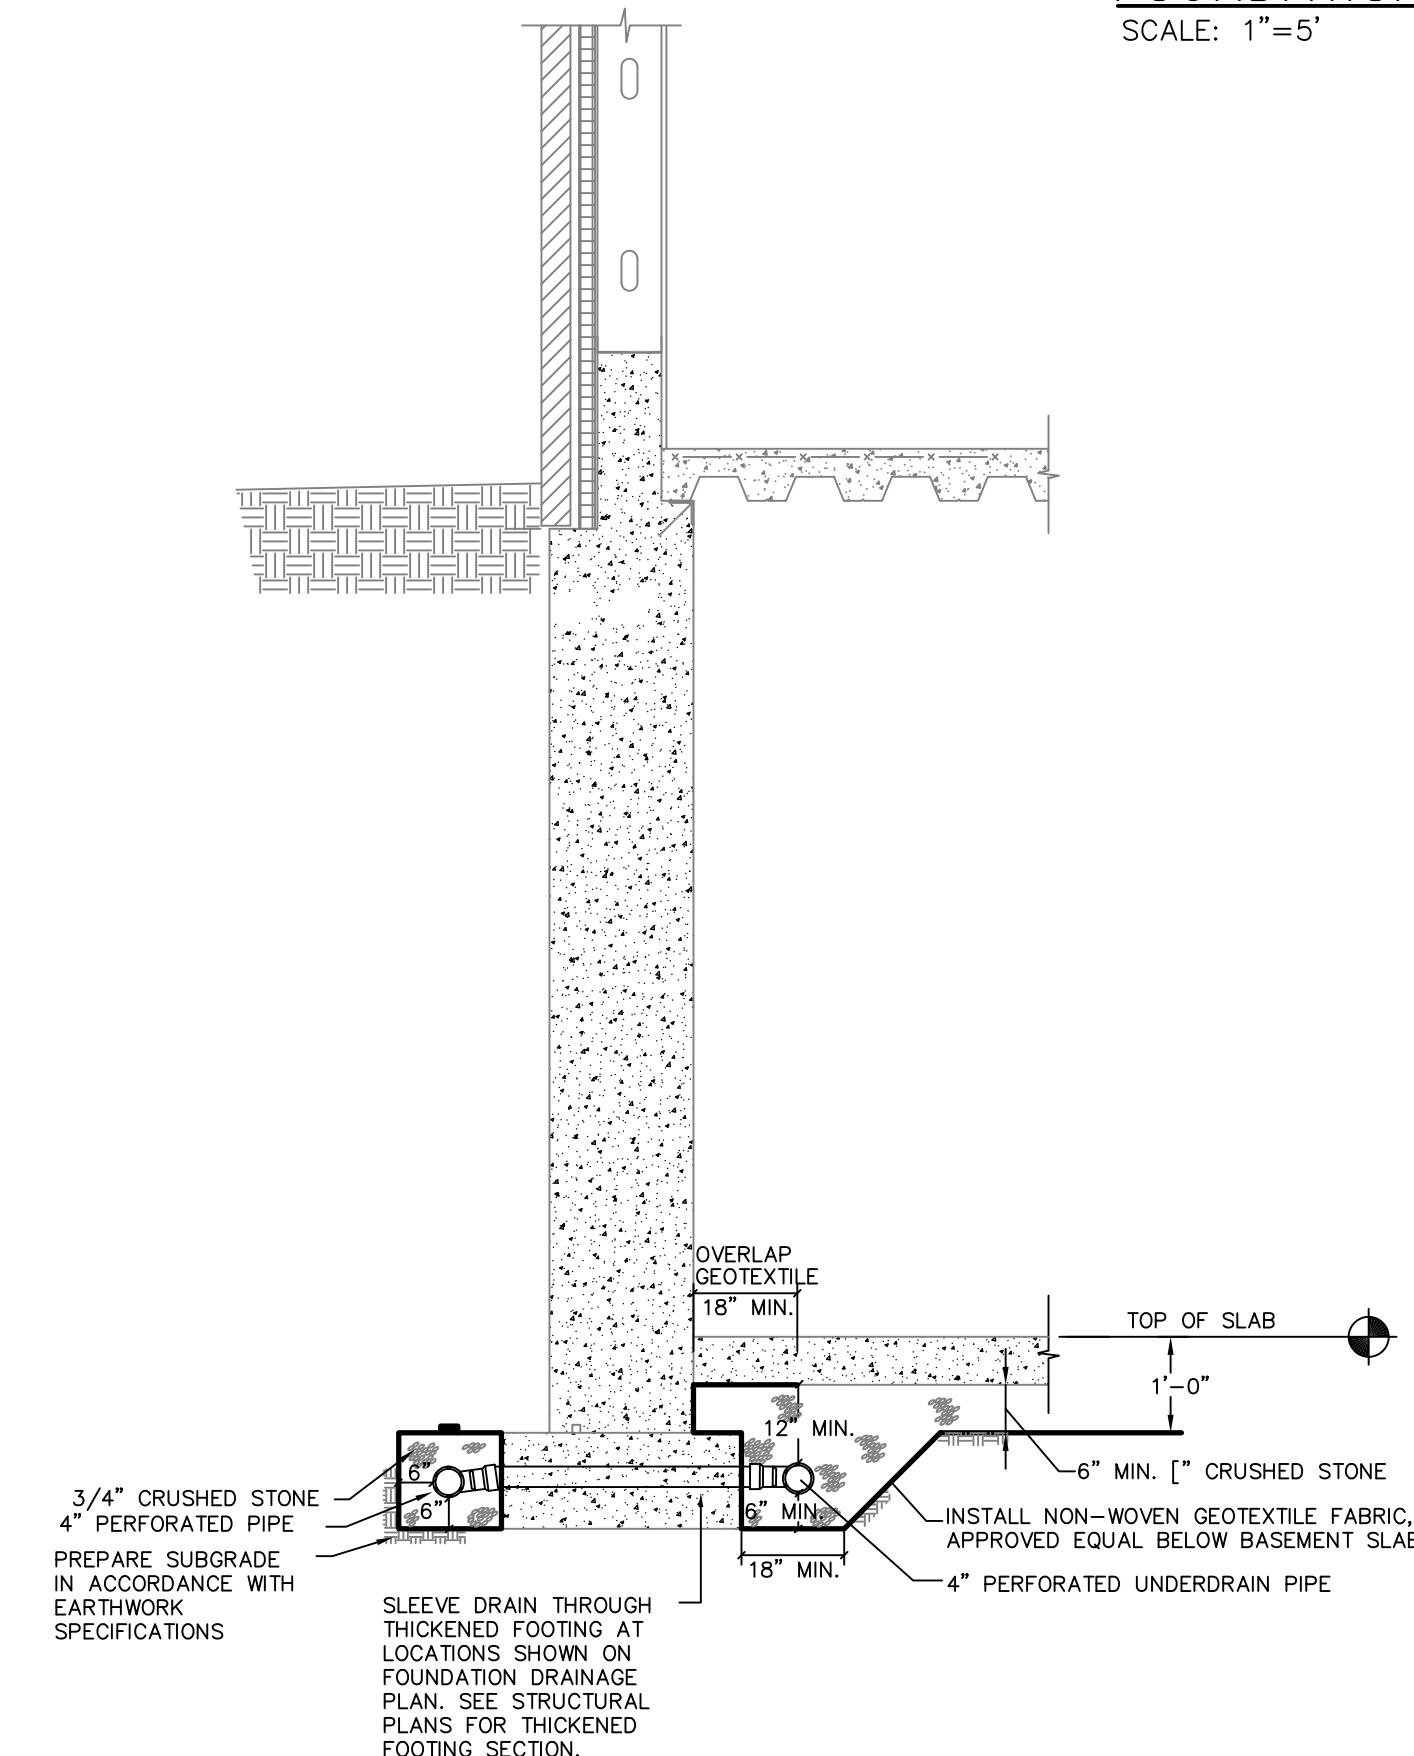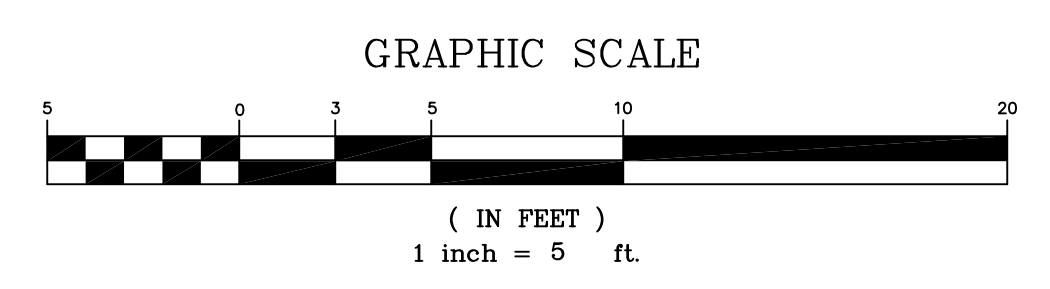

TYPICAL PERIMETER DRAIN INSTALLATION
SCALE: 1/2"=1'