


GENERAL NOTES

GN1. HVAC WORK IS INDICATED DIAGRAMMATICALLY. EXACT LOCATIONS OF ALL COMPONENTS ARE TO BE DETERMINED IN THE FIELD AND BY THE ACTUAL BUILDING CONDITIONS...


ABBREVIATIONS

- AFB ABOVE FINISHED FLOOR
ACD AUTOMATIC CONTROL DAMPER
AD ACCESS DOOR
AP ACCESS PANEL
ARCH. ARCHITECT


PIPING LEGEND

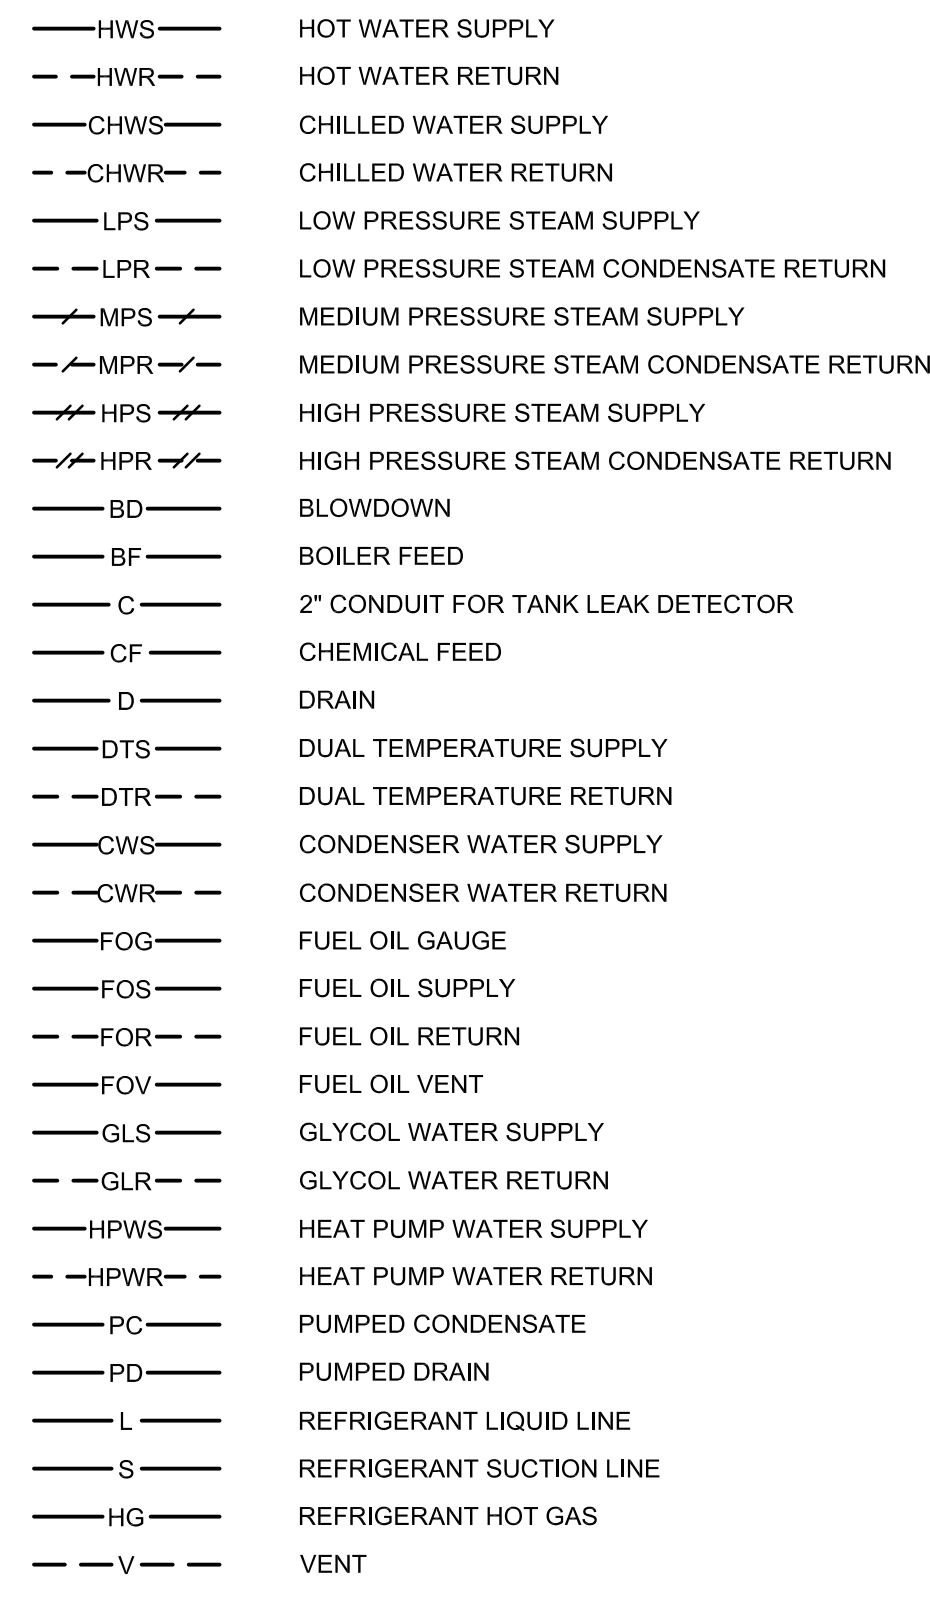


MISC. LEGEND / TAGS

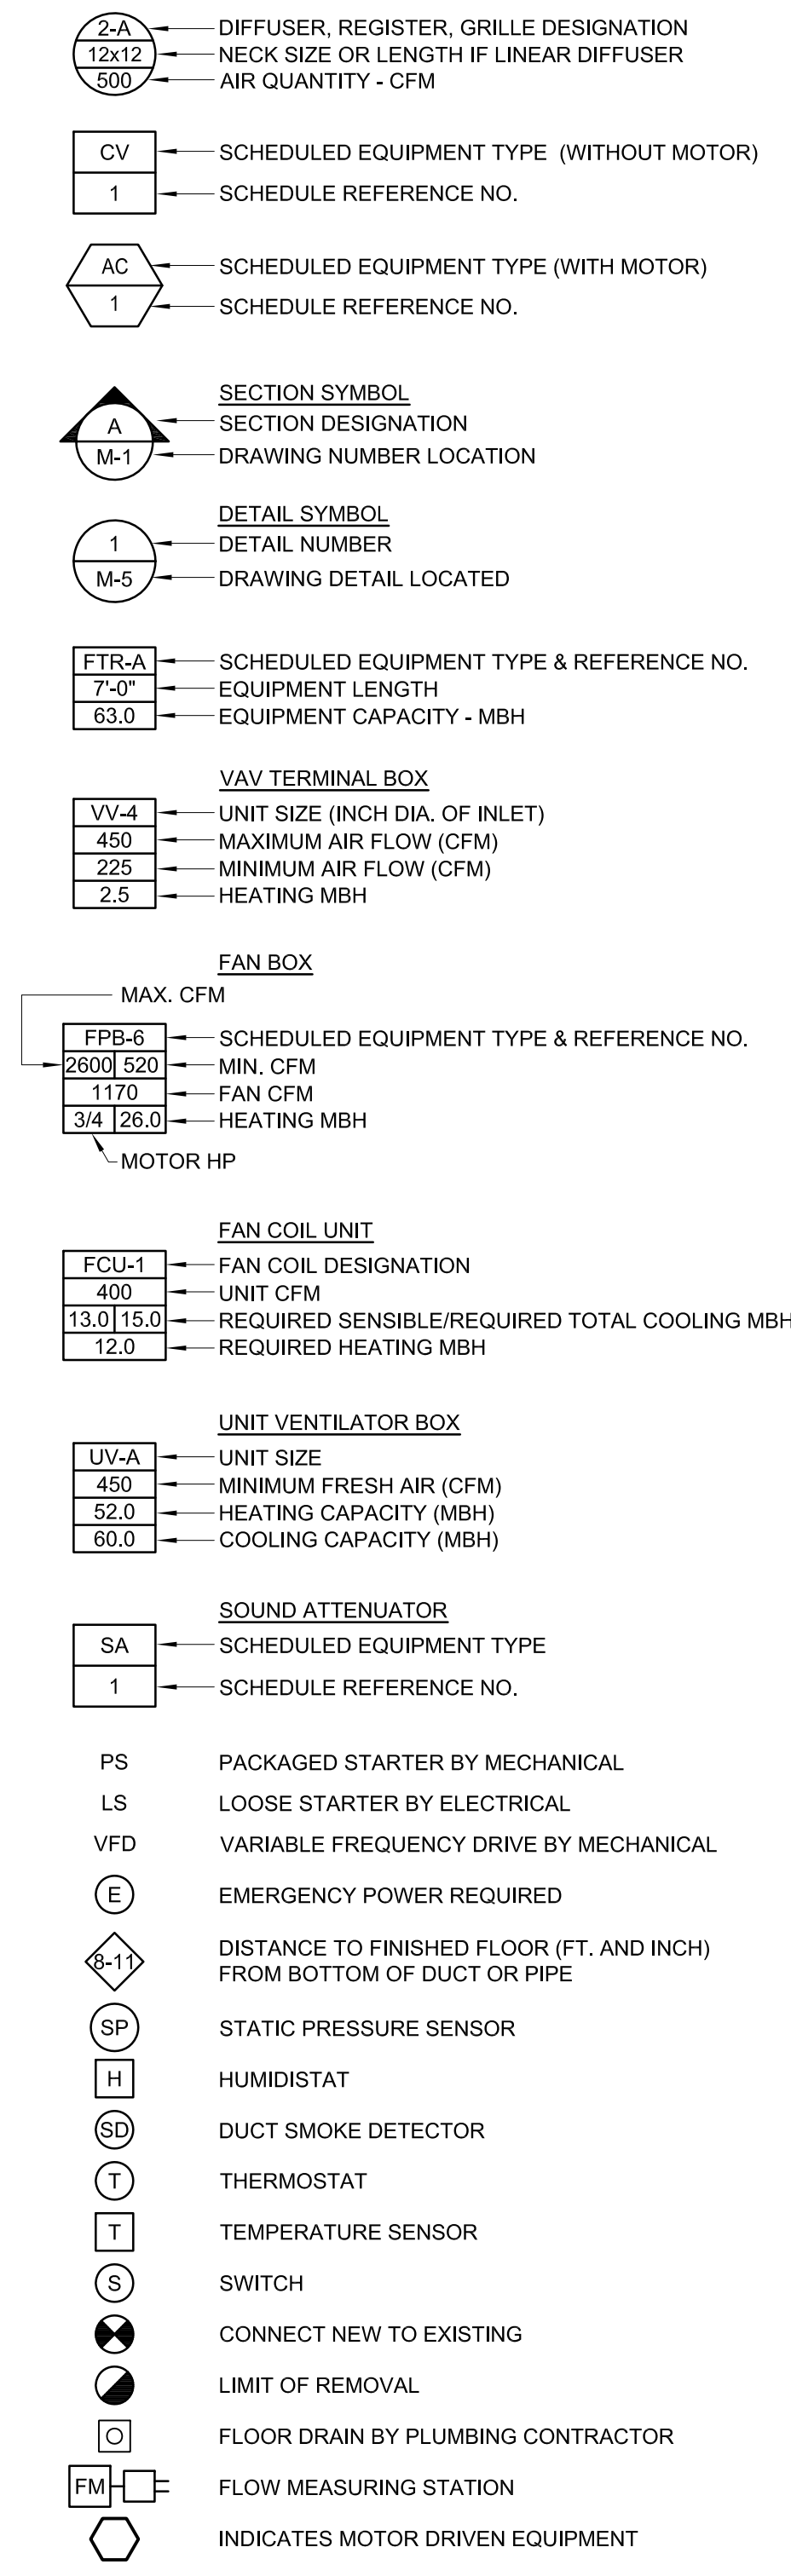

DUCTWORK LEGEND

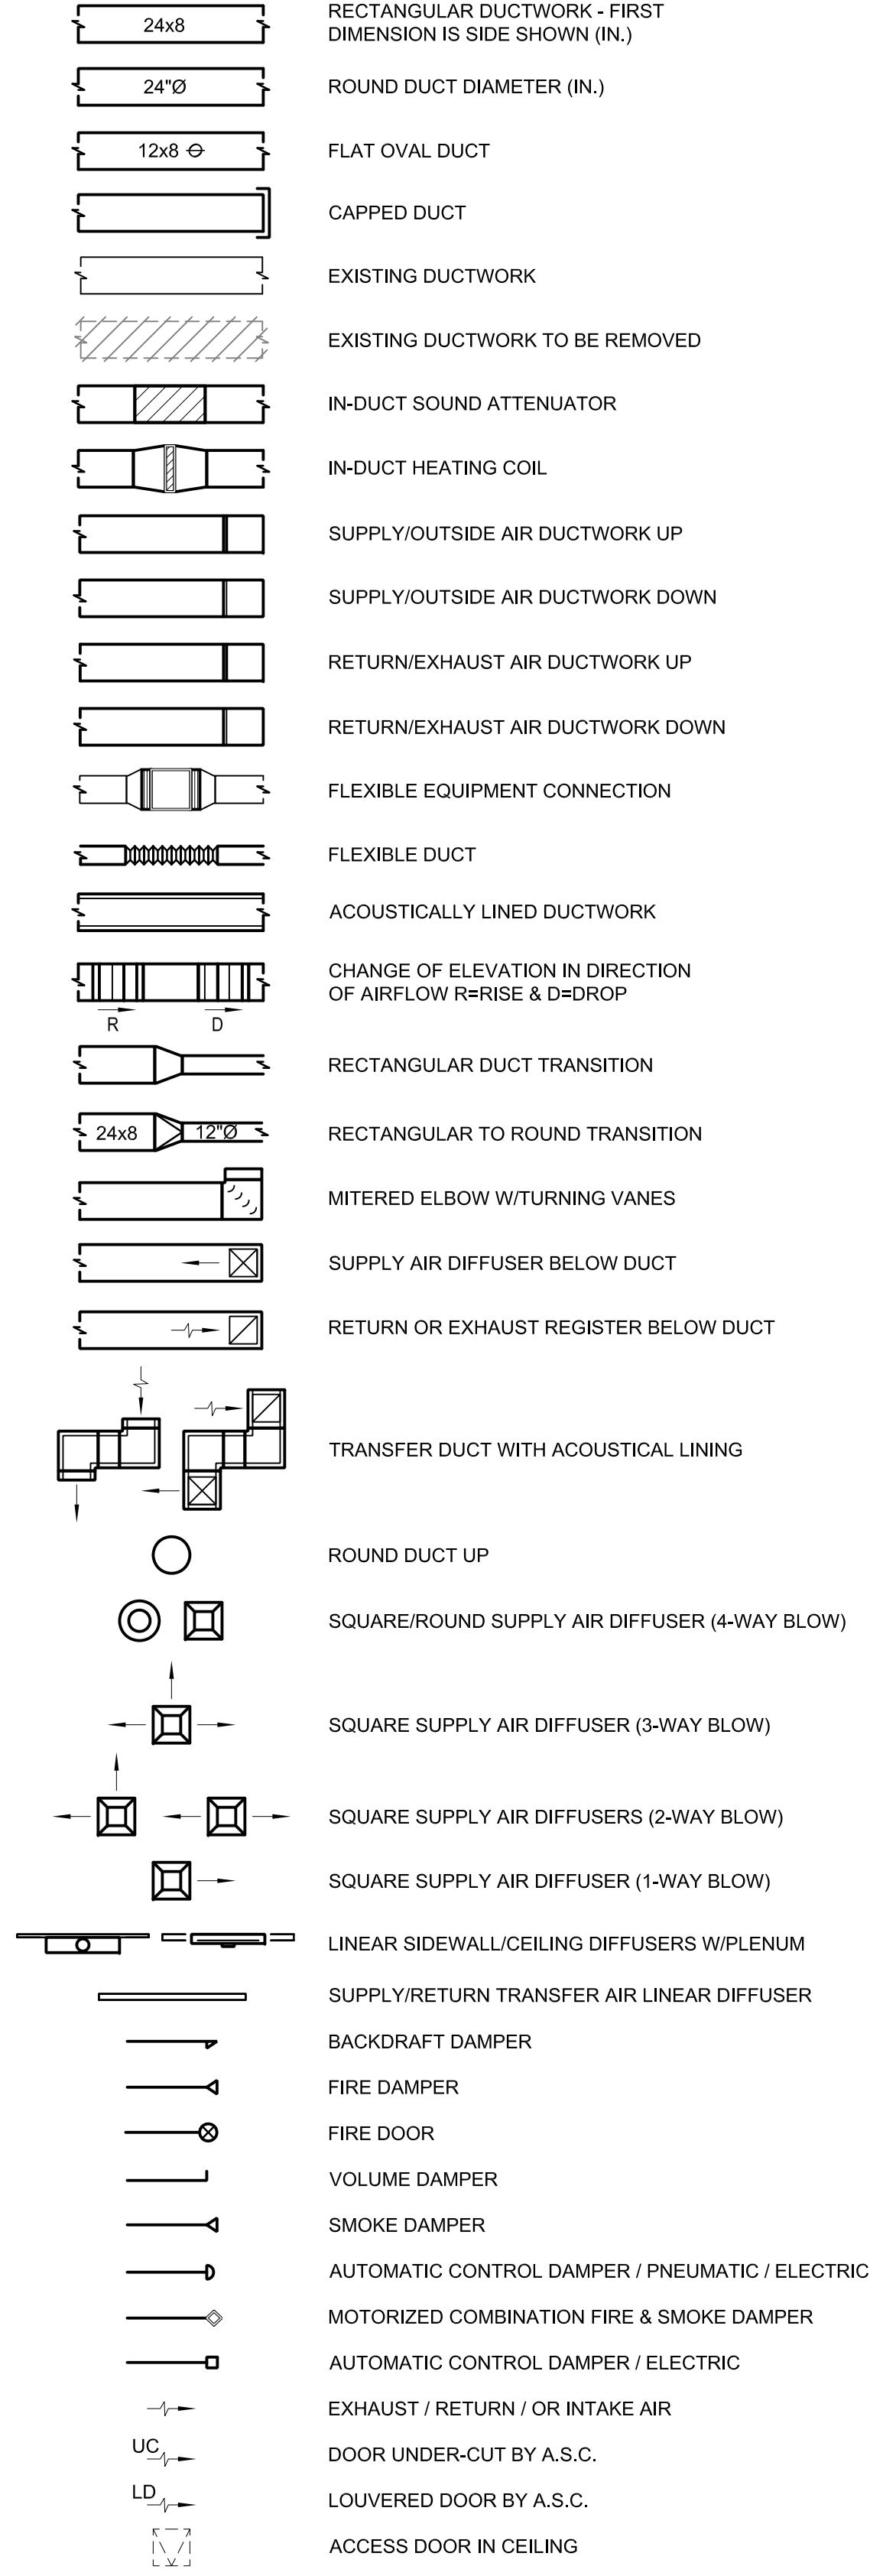


VALVES AND ACCESSORIES

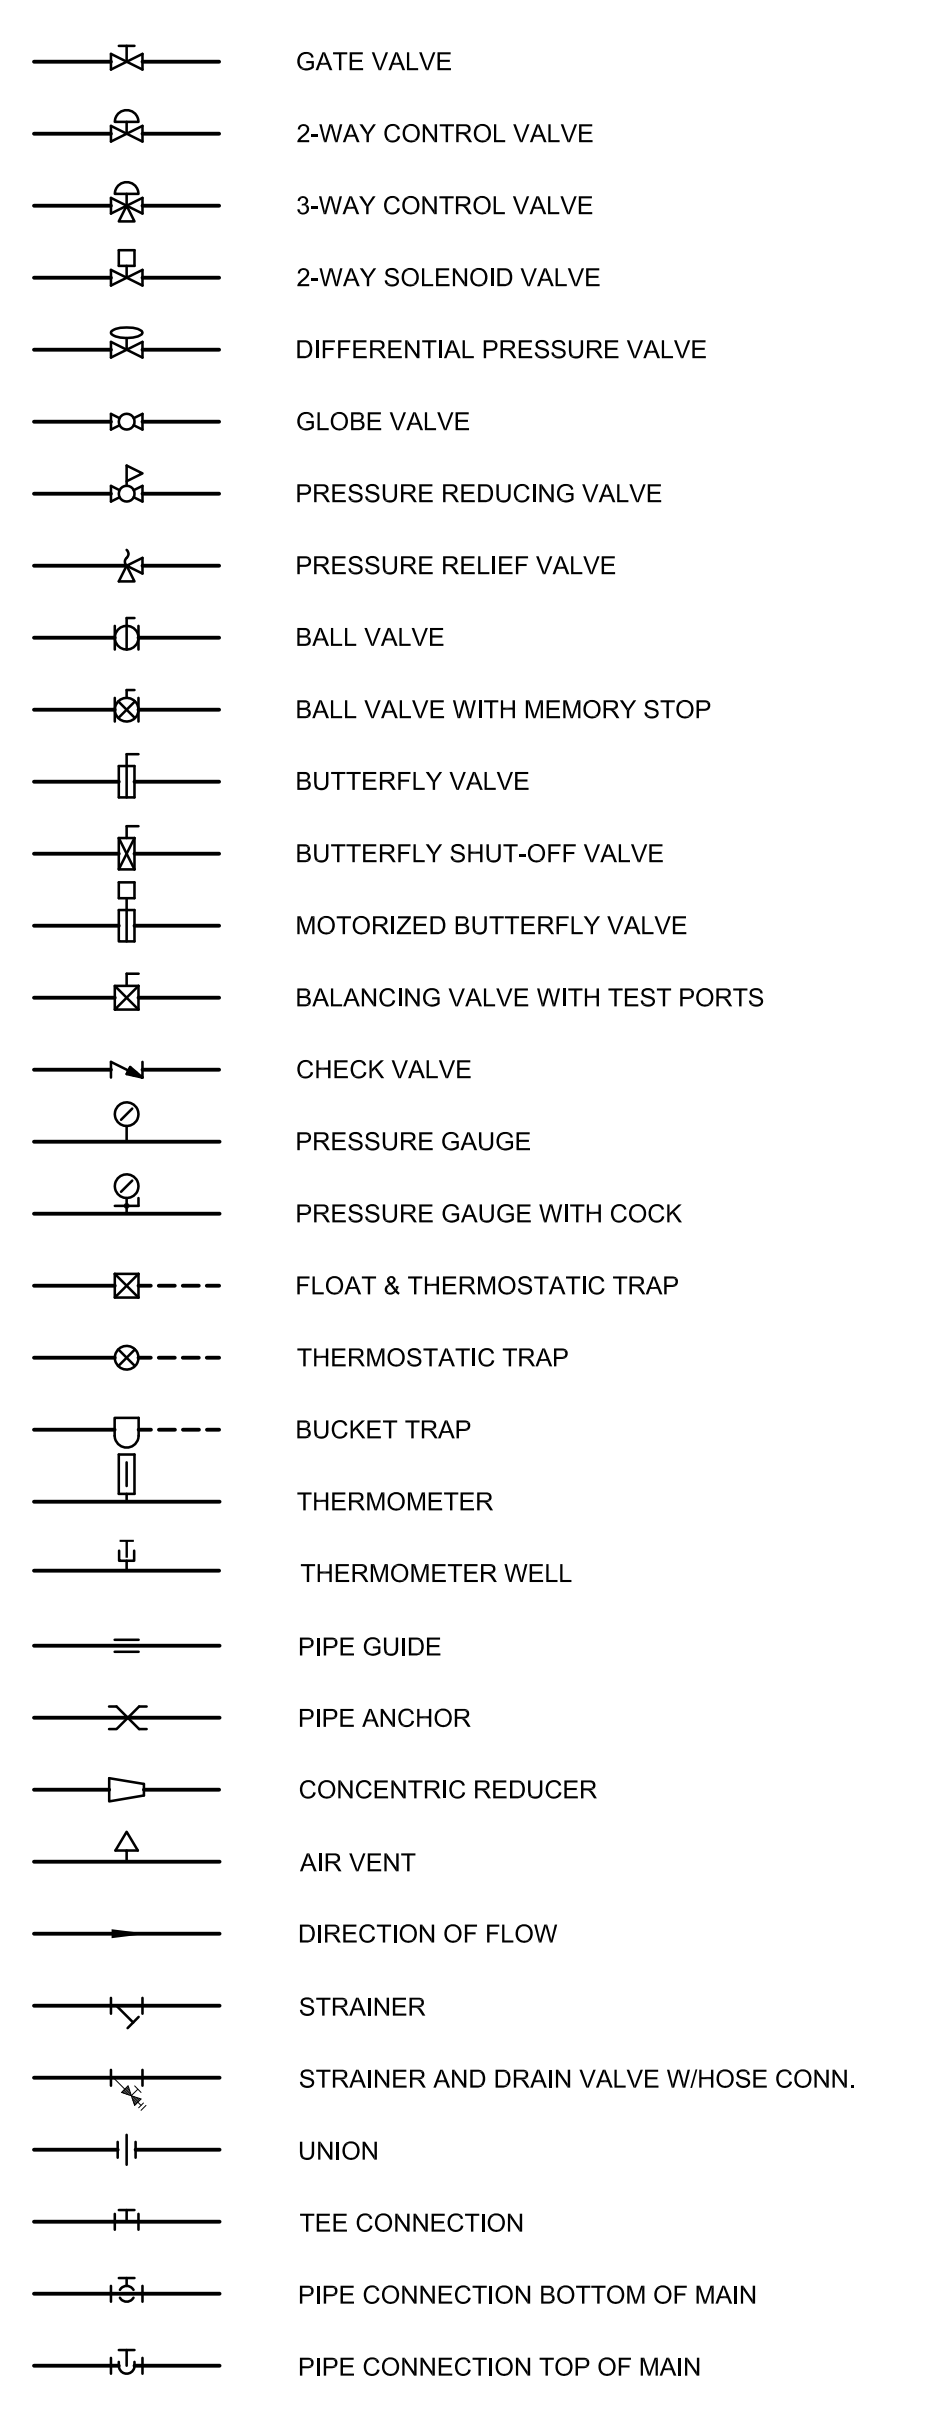

EQUIPMENT TYPES

- AC AIR CONDITIONING UNIT
ACC AIR COOLED CONDENSER
ACCU AIR COOLED CONDENSING UNIT
ACLIC AIR COOLED LIQUID CHILLER

SINGLE LINE DUCTWORK LEGEND

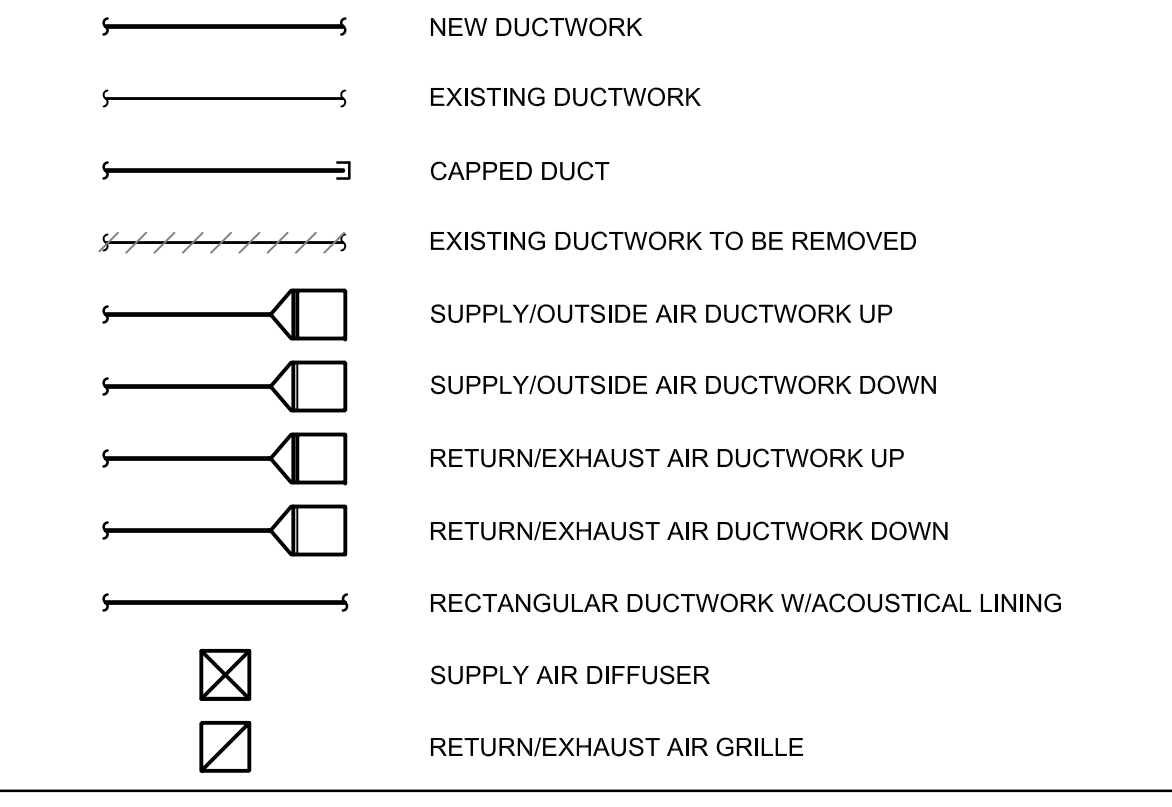

DESIGN CONDITIONS

Table with columns for TEMPERATURES AND HUMIDITIES and WEATHER DATA BASIS. Includes data for winter and summer conditions.

ENVELOPE COMPLIANCE

Table showing envelope compliance details including orientation (North, East, South, West), component name/description, and associated values for gross area, cavity R-value, etc.

HVAC DRAWING LIST

Table listing drawing numbers, titles, and sheet numbers for various HVAC drawings including legend, abbreviations, and schematic symbols.

Vertical text on the left margin containing drawing metadata, revision dates, and project information.

Project information sidebar including project title, client name (Schwartz/Silver Architects Inc.), project location (Portland, Maine), and drawing number (M0.01).