
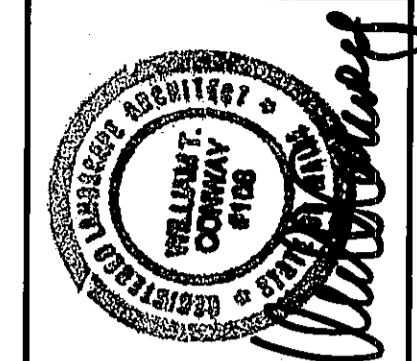
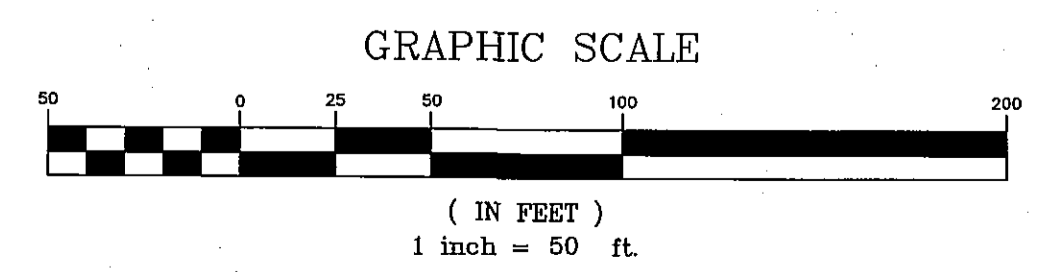
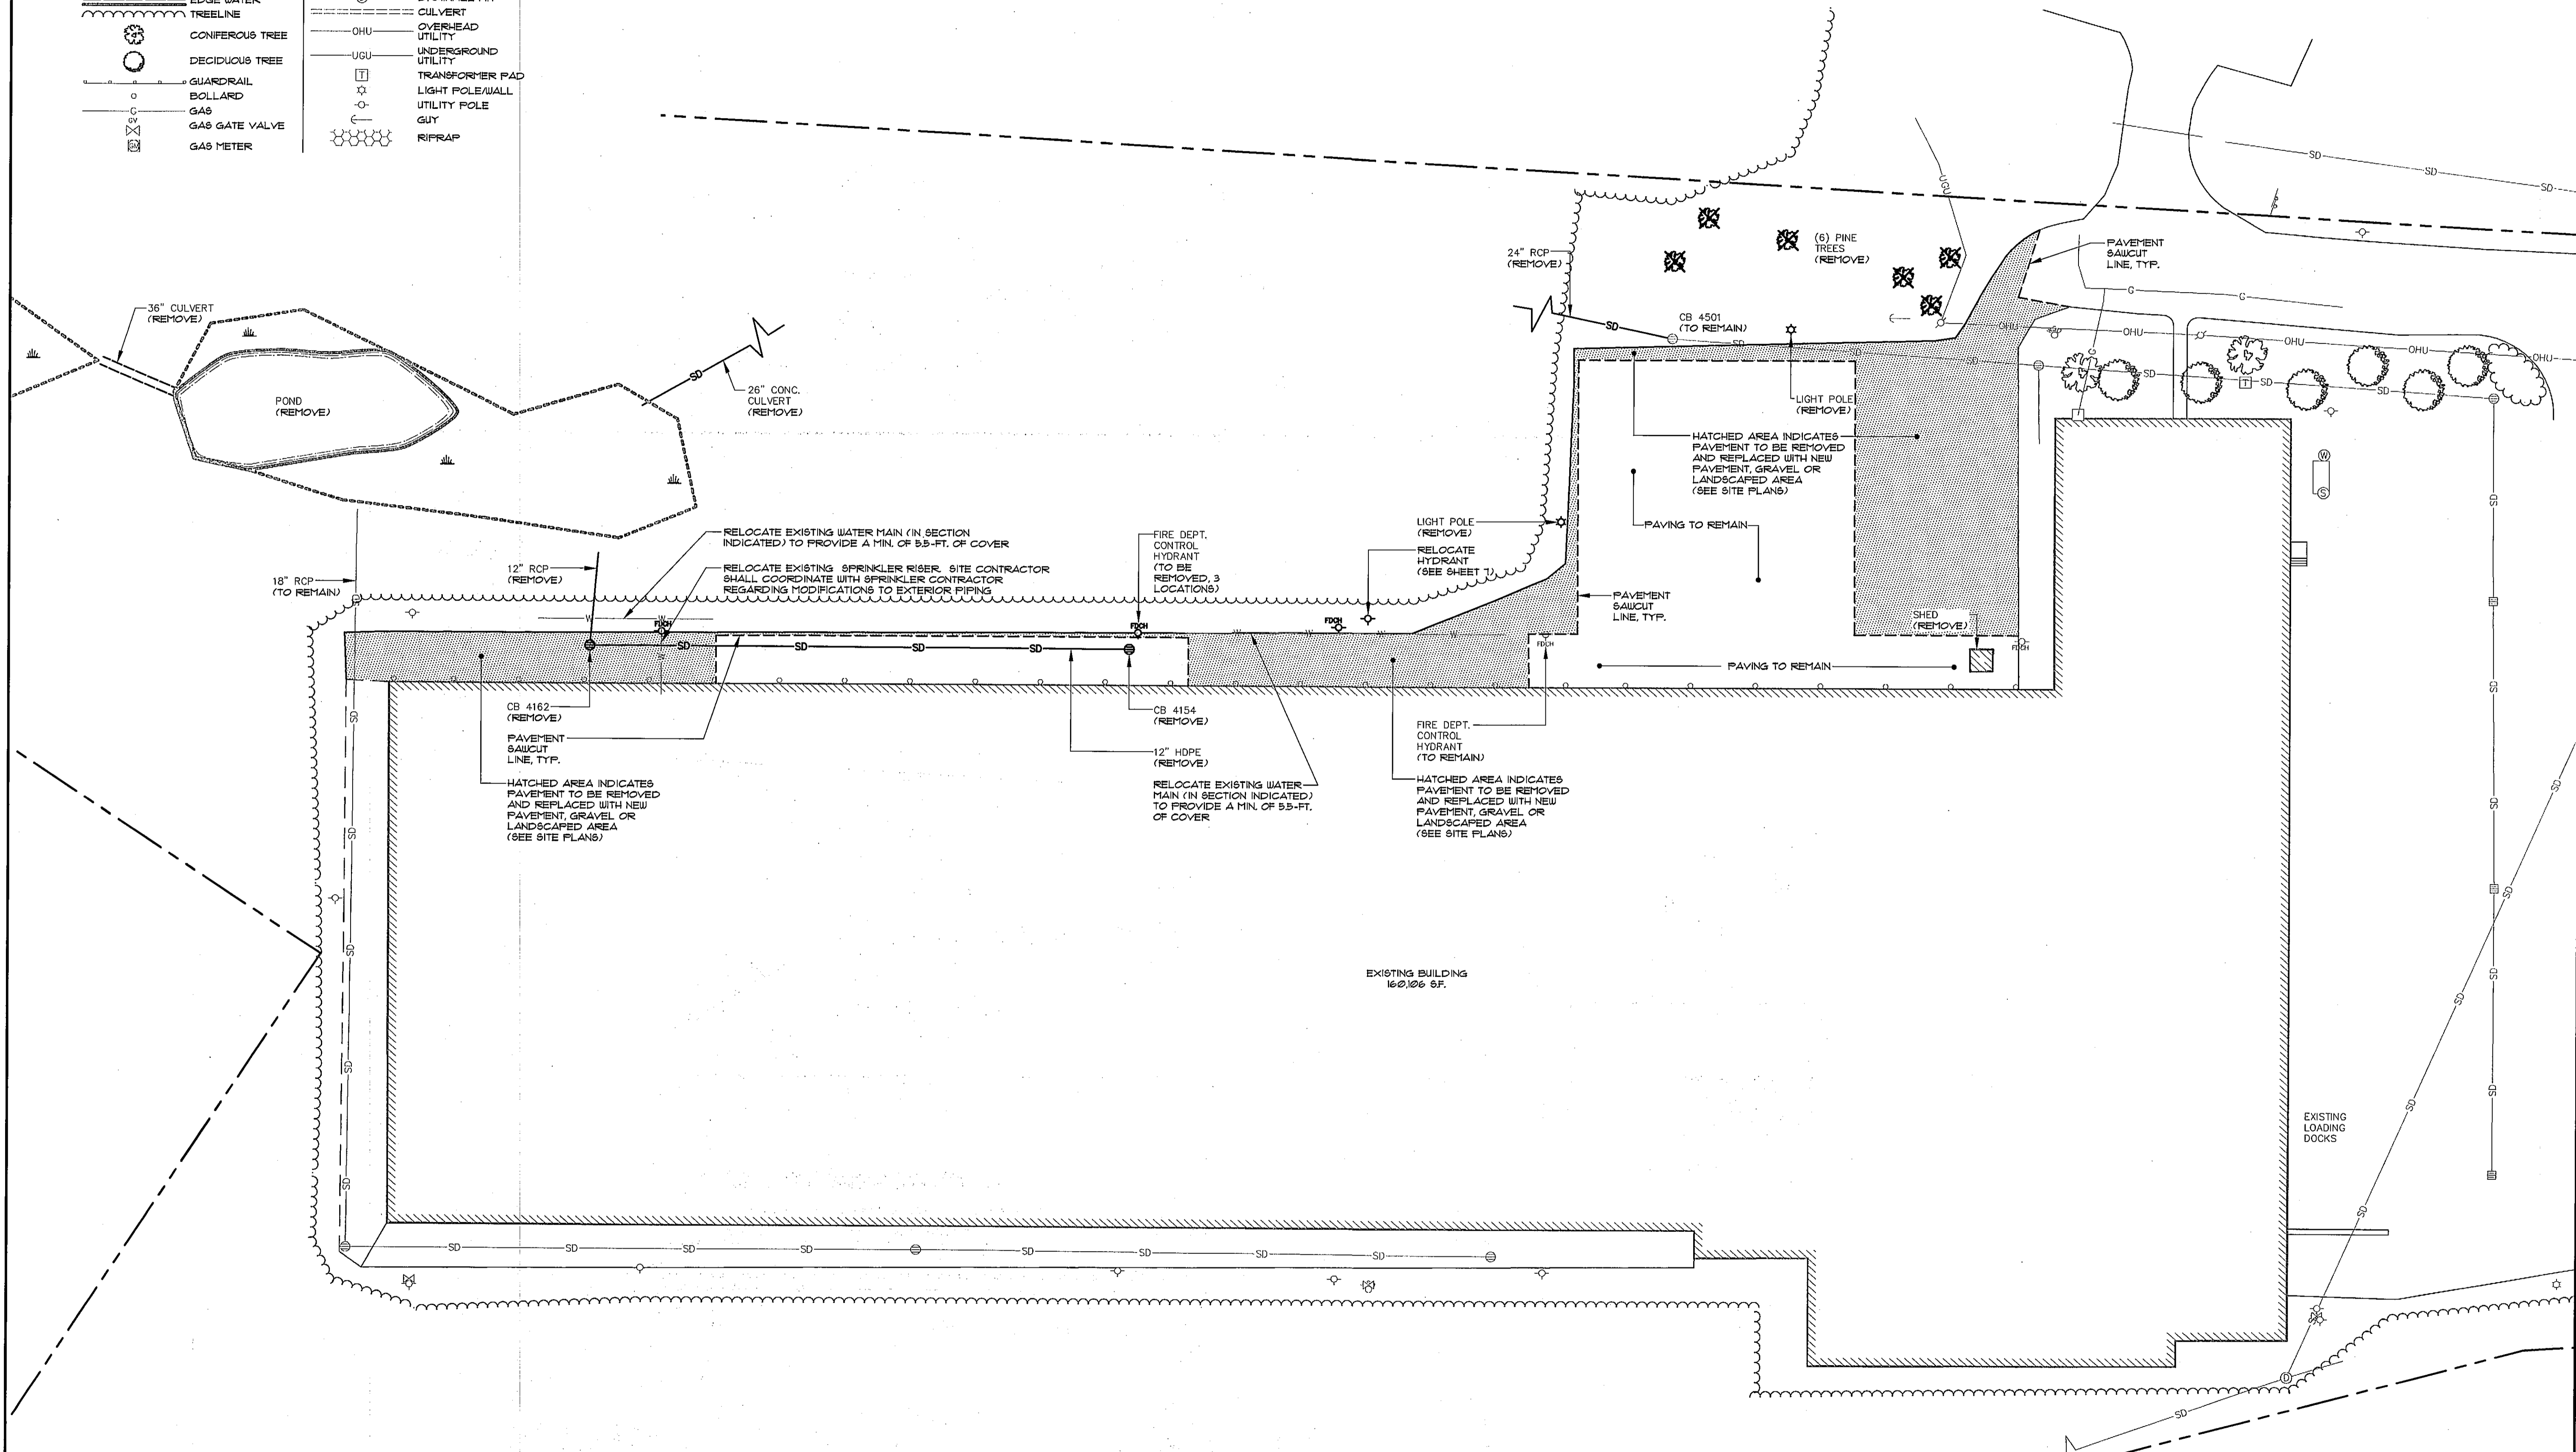


LEGEND

EXISTING	DESCRIPTION	EXISTING	DESCRIPTION
---	BOUNDARY LINE/ROW	W	WATER
---	ADJUTER LINE/ROW	WV	WATER GATE VALVE
---	BUILDING	WV	WATER SHUT OFF
---	WETLANDS	WV	HYDRANT
---	EDGE WETLAND	WV	POTABLE WELL
---	SIGN	SD	STORM DRAIN
---	EDGE PAVEMENT	UD	UNDERDRAIN
---	EDGE GRAVEL	CB	CATCH BASIN
---	EDGE WATER	DM	DRAINAGE MH
---	TREELINE	C	CULVERT
○	CONIFEROUS TREE	OHU	OVERHEAD UTILITY
○	DECIDUOUS TREE	UGU	UNDERGROUND UTILITY
---	GUARDRAIL	TP	TRANSFORMER PAD
---	BOLLARD	LP	LIGHT POLE/WALL
---	GAS	UP	UTILITY POLE
---	GAS GATE VALVE	G	GUY
---	GAS METER	R	RIFRAP

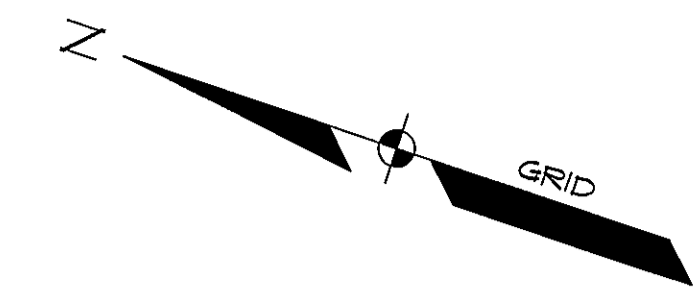

REV.	BY:	DATE:	STATUS:
C	WTC	10-23-12	RESUBMIT TO CITY
B	WTC	10-09-12	RESUBMIT TO CITY
A	WTC	08-27-12	SITE PLAN SUBMISSION TO CITY

THIS PLAN SHALL NOT BE MODIFIED WITHOUT WRITTEN PERMISSION FROM SEBAGO TECHNICS, INC. ANY ALTERATIONS, AUTHORIZED OR OTHERWISE, SHALL BE AT THE USER'S SOLE RISK AND WITHOUT LIABILITY TO SEBAGO TECHNICS, INC.

SEBAGO TECHNICS
 76 Jean Roberts Rd., Suite 104
 South Portland, ME 04106
 Tel: 207-763-8656

PROJECT NO.	11270	DESIGN	CHKD	DRAWN	MAL
		FIELD BOOK	WTC	WTC	WTC

SITE DEMOLITION PLAN
 OF: **765 WARREN AVENUE SITE**
 WARREN AVENUE
 PORTLAND, MAINE

FOR: **BOULOS PROPERTY MANAGEMENT**
 ONE CANAL PLAZA
 PORTLAND, MAINE 04101

DATE	SCALE
08-01-12	1" = 20'