



1 ELECTRICAL PLAN
SCALE: 1"=5'

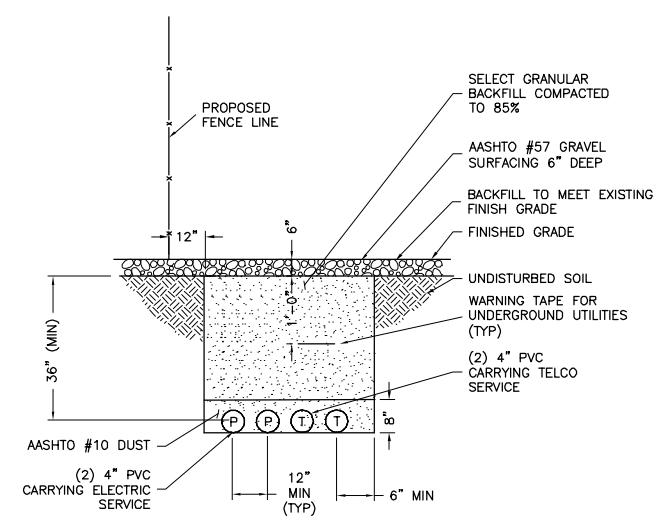

NOTE:
1. EXCAVATE EXISTING SUBGRADE AS REQUIRED TO INSTALL CONDUITS IN ACCORDANCE WITH OSHA AND ALL APPLICABLE CODES.

2 TYPICAL TRENCH DETAIL
E-1 NTS

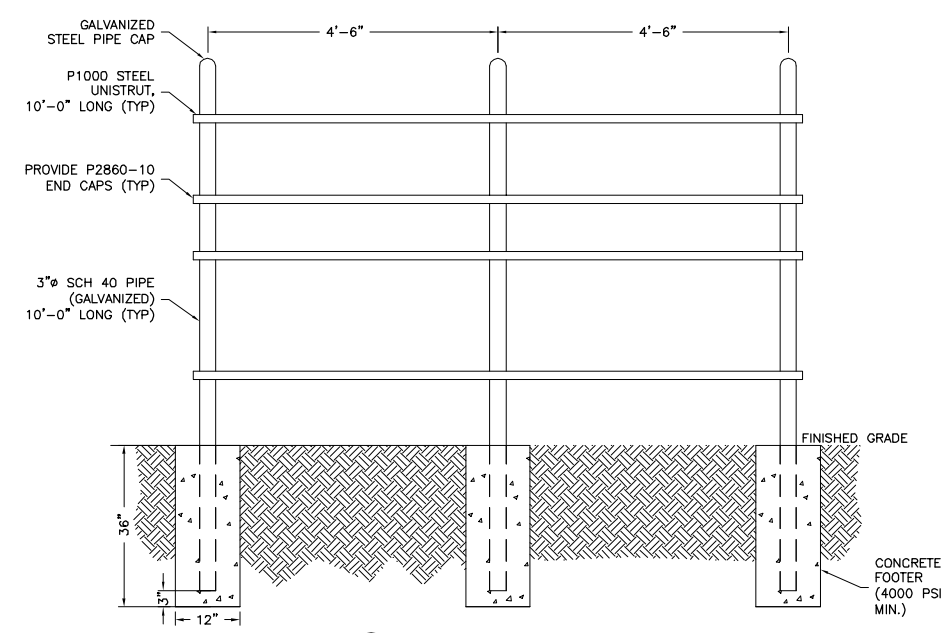

3 UTILITY ELEVATION
E-1 NTS

ENGINEER	<p>NB+C TOTALLY COMMITTED.</p> <p>NB+C ENGINEERING SERVICES, LLC. 1777 SENTRY PARKWAY WEST DUBLIN HILL, SUITE 200 BLUE BELL, PA 19422 (610) 480-9122</p>																				
APPLICANT	<p>at&t mobility corp.</p> <p>550 COCHITUATE ROAD FRAMMINGHAM, MA 01701</p>																				
SITE INFORMATION	<p>ME5372 LUCAS TREE 636 RIVERSIDE STREET PORTLAND, ME 04103 CITY OF PORTLAND</p>																				
DESIGN RECORD	<table border="1"> <thead> <tr> <th>REV</th> <th>DATE</th> <th>DESCRIPTION</th> <th>BY</th> </tr> </thead> <tbody> <tr> <td>3</td> <td>06/06/14</td> <td>REVISED PER COMMENTS</td> <td>DAK</td> </tr> <tr> <td>2</td> <td>05/22/14</td> <td>PRELIMINARY CDs</td> <td>DAK</td> </tr> <tr> <td>1</td> <td>03/20/14</td> <td>REVISED PER COMMENTS</td> <td>DAK</td> </tr> <tr> <td>0</td> <td>10/10/13</td> <td>PRELIMINARY ZDs</td> <td>DAK</td> </tr> </tbody> </table>	REV	DATE	DESCRIPTION	BY	3	06/06/14	REVISED PER COMMENTS	DAK	2	05/22/14	PRELIMINARY CDs	DAK	1	03/20/14	REVISED PER COMMENTS	DAK	0	10/10/13	PRELIMINARY ZDs	DAK
REV	DATE	DESCRIPTION	BY																		
3	06/06/14	REVISED PER COMMENTS	DAK																		
2	05/22/14	PRELIMINARY CDs	DAK																		
1	03/20/14	REVISED PER COMMENTS	DAK																		
0	10/10/13	PRELIMINARY ZDs	DAK																		
PROFESSIONAL STAMP																					
ENGINEER	<p>KRUPAKARAN KOLANDAVELU P.E. ME PROFESSIONAL ENGINEER LIC. #12979</p> <p><small>THIS SEAL VALID FOR THE YEAR FOR ANY PERSON UNLESS THEY ARE ACTING UNDER THE DIRECTION OF A LICENSED PROFESSIONAL ENGINEER TO ALTER THIS DOCUMENT UNLESS EXPLICITLY AGREED TO BY THE ENGINEER IN WRITING. THE ENGINEER SHALL BE FULLY RESPONSIBLE FOR ANY ALTERATION OR MODIFICATION OF THE CONTENTS HEREIN.</small></p>																				
SHEET TITLE	<p>ELECTRICAL PLAN & DETAILS</p>																				
SHEET NUMBER	<p>E-1</p>																				