

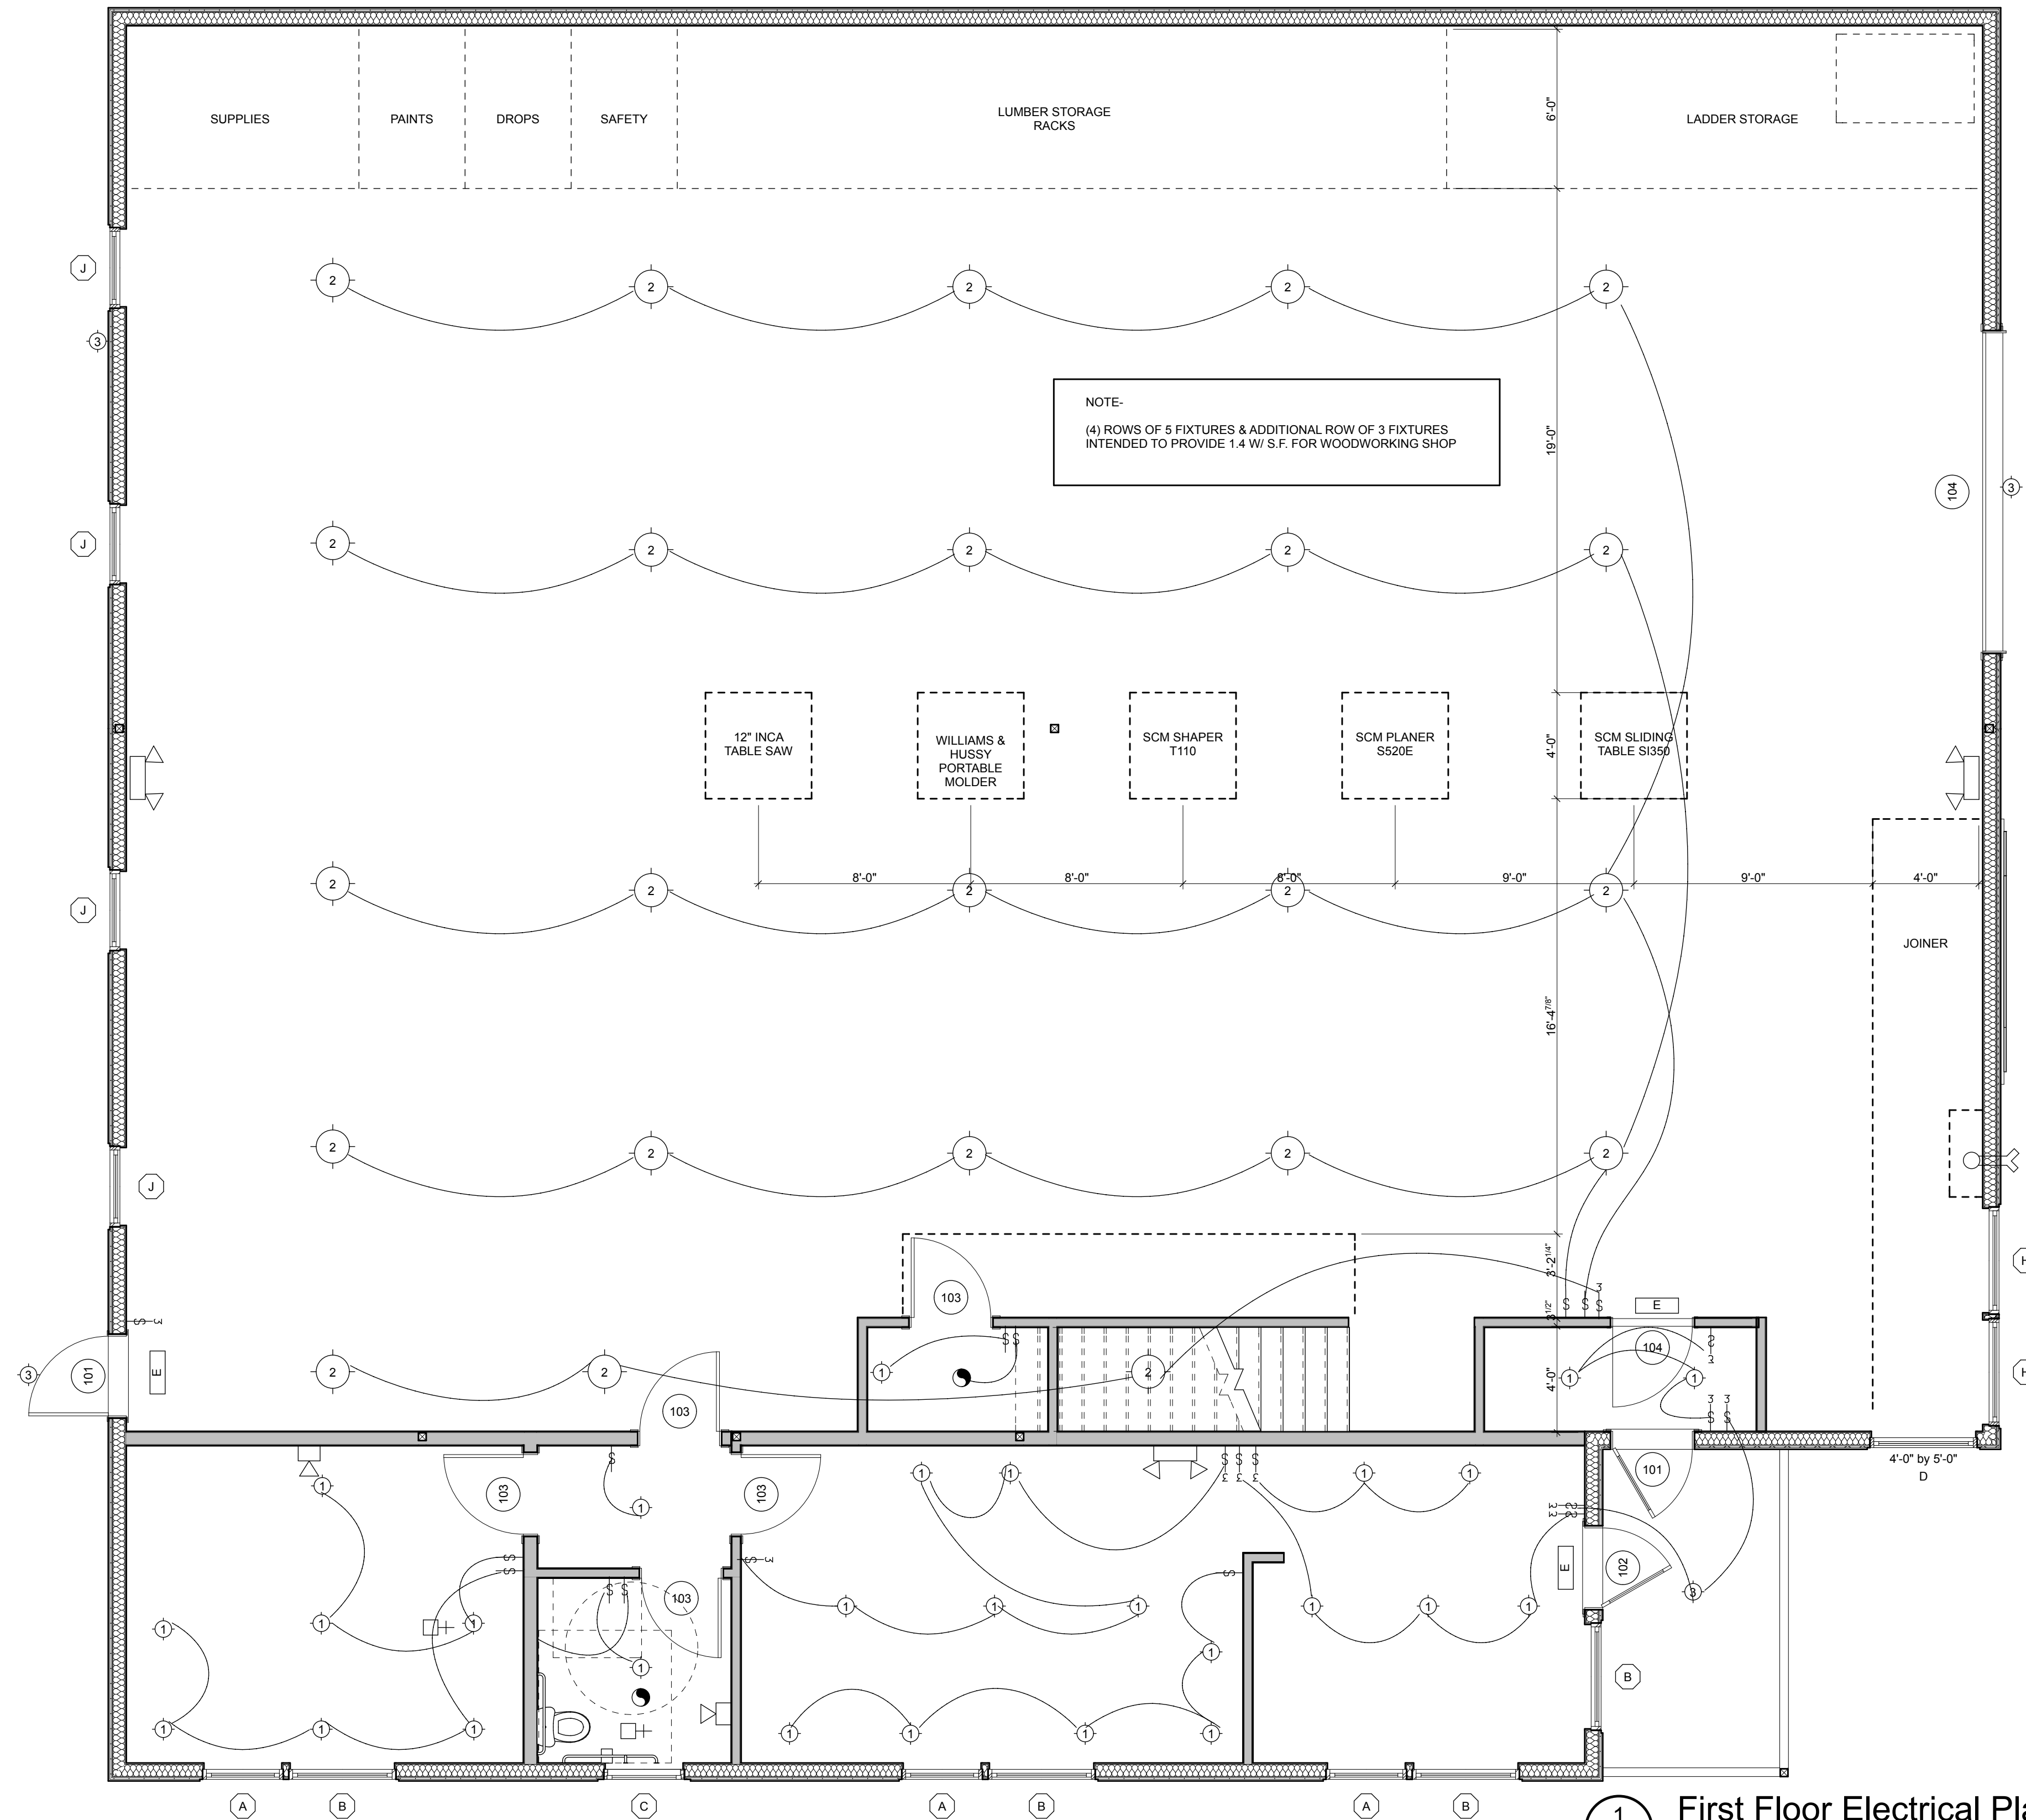


1
E1.1 Second Floor Electrical Plan
SCALE: 1/4" = 1'-0"

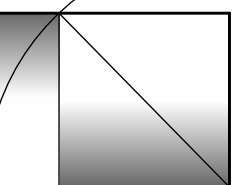

1
E1.1 First Floor Electrical Plan
SCALE: 1/4" = 1'-0"

- ELECTRICAL SYMBOLS**
- DUPLEX OUTLET 18" A.F.F. UNLESS NOTED OTHERWISE
"WP" INDICATES WATERPROOF OUTLET
PROVIDE GFI WHERE NOTED
 - DOUBLE DUPLEX OUTLET 18" A.F.F. UNLESS NOTED OTHERWISE
"WP" INDICATES WATERPROOF OUTLET
PROVIDE GFI WHERE NOTED
 - SPECIAL PURPOSE POWER OUTLET - CONSULT OWNER - RE
STOVE, MICROWAVE, DISPOSAL
 - WALL PHONE JACK 18" A.F.F. UNLESS NOTED OTHERWISE
 - CABLE TV IF REQ'D - ASK OWNER
 - SWITCH
 - THREE-WAY SWITCH
 - COMPUTER - CONSULT OWNER - RE INTERNET CONNECTION
 - DUPLEX FLOOR OUTLET
 - CEILING FAN
 - EXHAUST FAN
- LIGHTING SYMBOLS**
- SURFACE MOUNTED INTERIOR FIXTURE LED "CANS"
 - UTILITY LIGHT
 - SURFACE MOUNTED EXT. FIXTURE - FULL CUTOFF LENS TYPICAL
 - WALL MOUNTED EXT. FIXTURE
- LIFE SAFETY SYMBOLS**
- SMOKE DETECTOR
 - FIRE EXT. WALL MTD.
 - CARBON MONOXIDE DETECTOR
 - EMERG. LT.
 - HORN/ STROBE
 - EXIT SIGNAGE

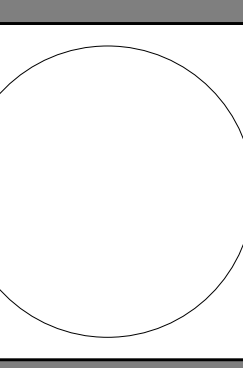

DATE	DESCRIPTION

DATE:	10.22.14
CHECKED BY:	J.A.D.
DRAWN BY:	JAD
JOB:	ROM-14
SHEET TITLE:	

E1.1 First Floor Electrical Plan - Plotted on 9/17/15 at 11:42 AM by Joe Delaney. File Path: /Volumes/LaCie Disk/ WCA Projects/2008 Projects/RRS RICK ROMANO SHOP/RRS ArchiCAD Models/Rick Shop 8-27-10 Model Bldg.pln

THIS DRAWING IS AN INSTRUMENT OF SERVICE AND SHALL REMAIN THE PROPERTY OF WHIPPLE CALLENDER ARCHITECTS. IT SHALL NOT BE USED FOR ANY OTHER PURPOSE THAN FOR WHICH IT IS SPECIFICALLY FURNISHED.