


SITE PLAN

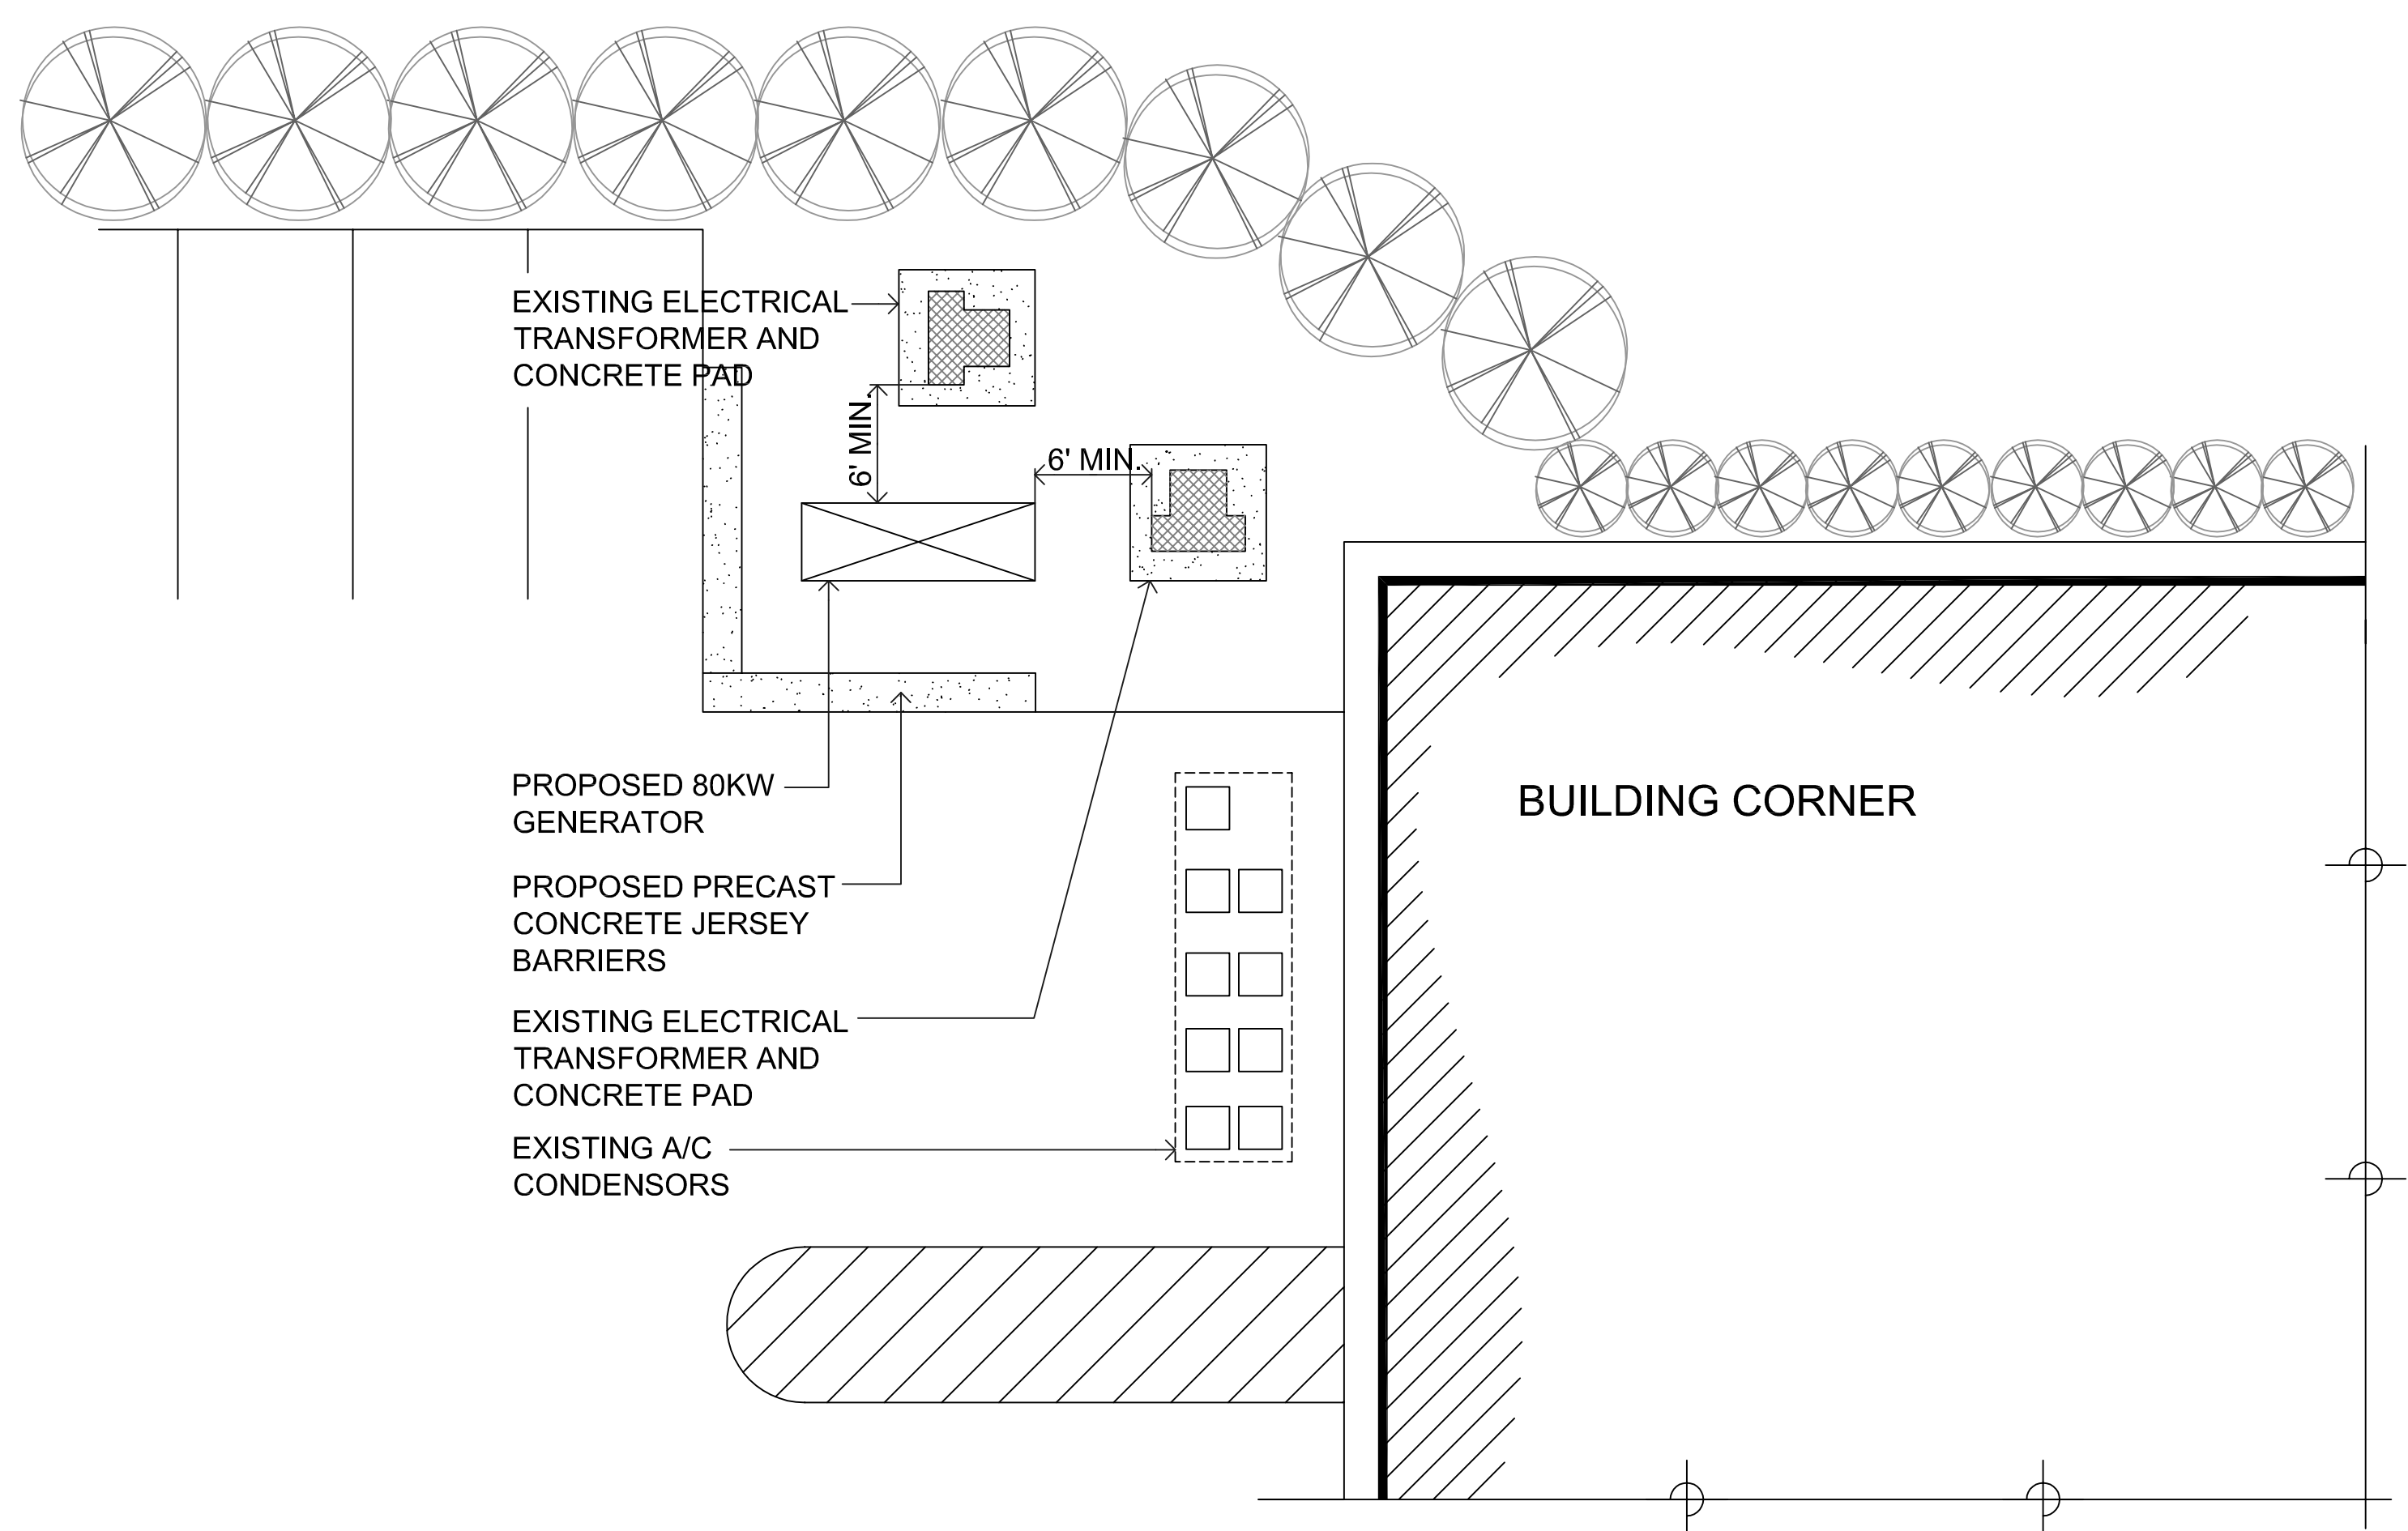

ENLARGED PLAN

NEW ENGLAND LIFE CARE
PROPOSED GENERATOR INSTALLATION

108 INDUSTRIAL WAY
PORTLAND, MAINE 04103

ALLIANCE BUILDERS INC.

800 Turnpike Street, Suite 300
North Andover, MA 01845

MARK	DATE	DESCRIPTION

PROJECT NO:
CAD DWG FILE:
DRAWN BY: SCALE: 1/8"=1'-0"
DATE: AUGUST 27TH, 2012

PROPOSED SITE PLAN

C.1