 

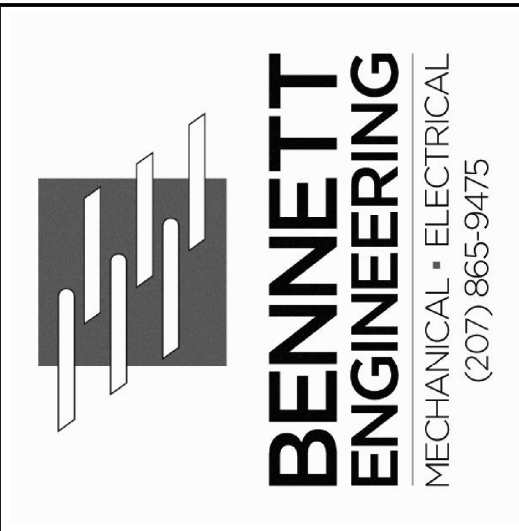


FLOOR PLAN
SCALE: 1/4"=1'-0"

WORK NOTES:
 FDF - FLOOR DRAIN W/FUNNEL 3"S 2"V
 FD - FLOOR DRAIN 3"S 2"V
 FS - FLOOR SINK 3"S 2"V
 HAND SINK 2"S 1-1/2"V

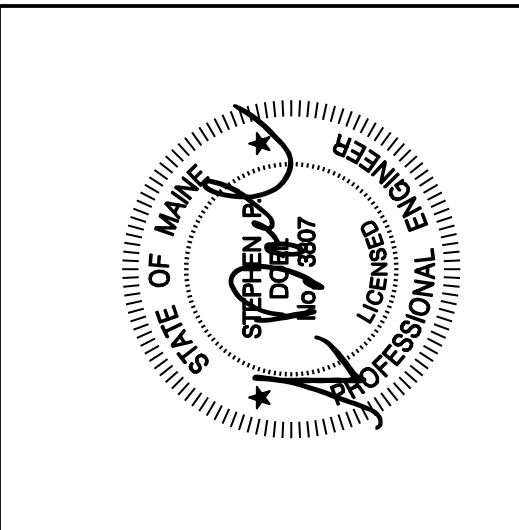

YANKEE LANES RENOVATIONS
 PORTLAND, MAINE
 MECHANICAL PLAN

Date Drawn -	
Drawn By -	
Revised -	03/24/16 - PERMIT
Project •	3871
Scale -	AS NOTED
Sheet Number -	M100