


FILE PATH: W:\Northern New England Design\Team\147\Spare Time Recreation\REV\REV1\Fire Alarm Drawings\FA-101.dwg
 LAST PRINTED: 9/15/2015 10:33:33 AM
 LAST SAVED BY: MDESIGATA
 24 x 36" - Arch D Size

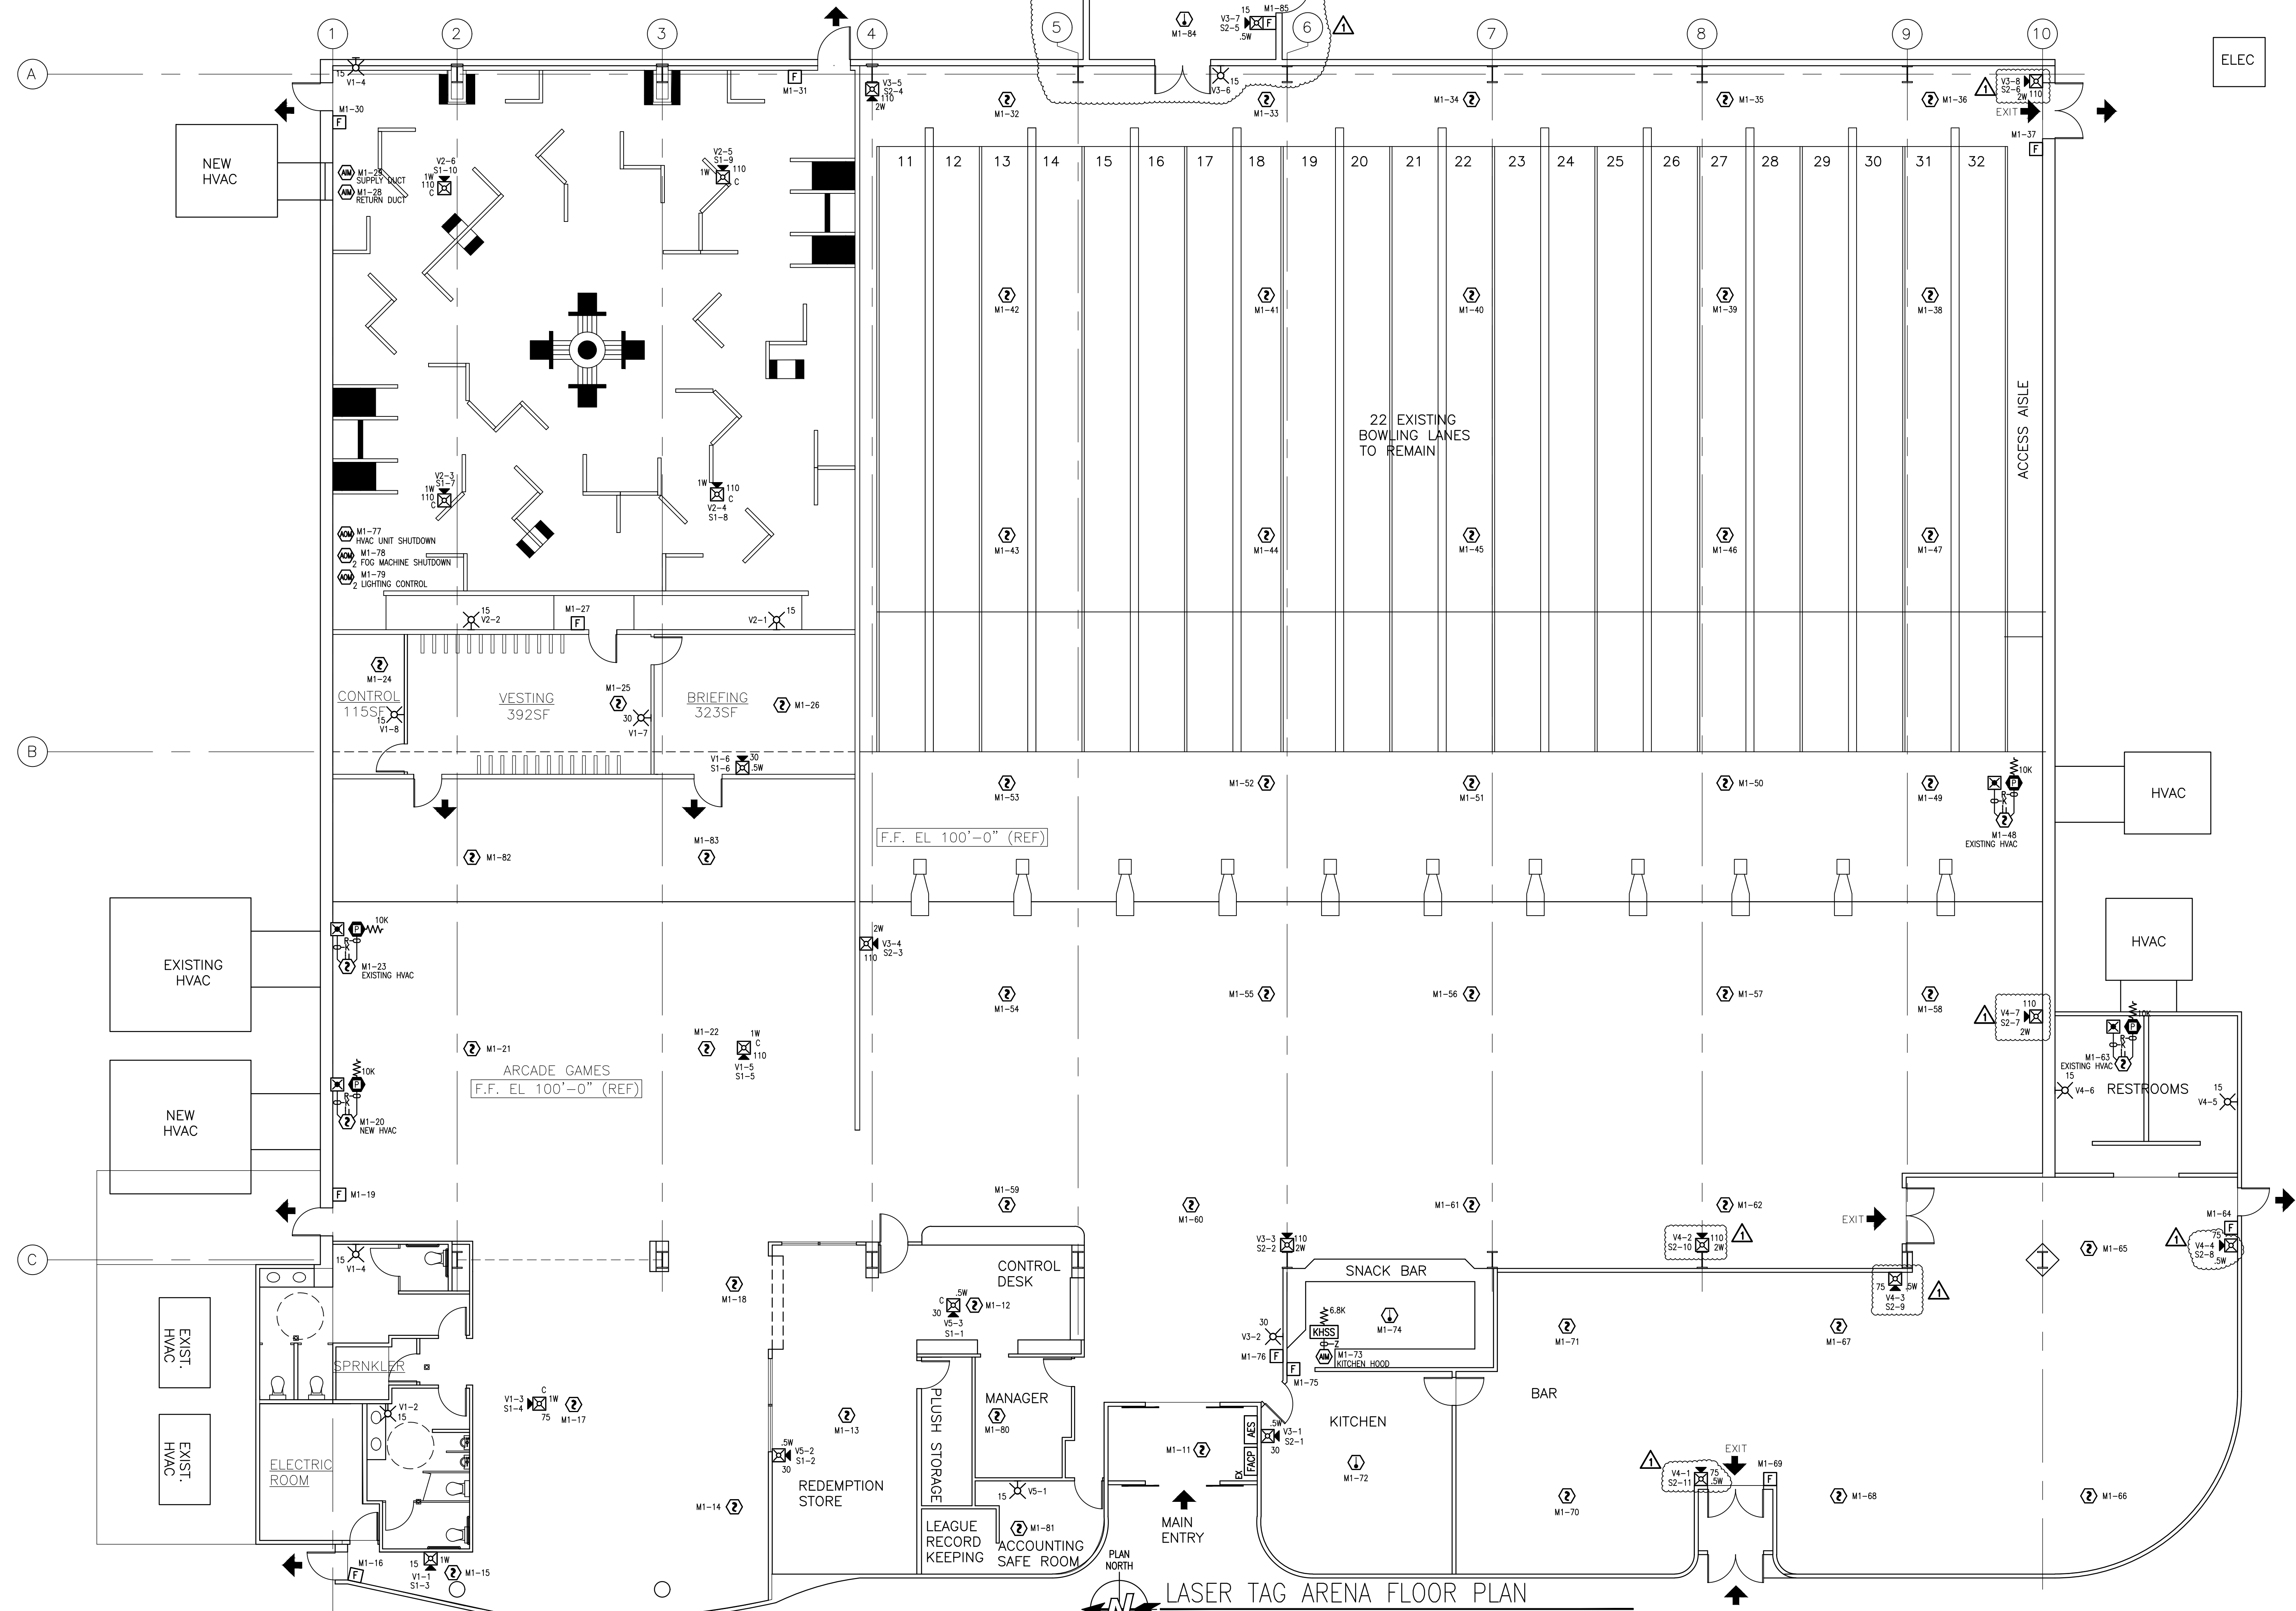

LASER TAG ARENA FLOOR PLAN
 SCALE: 1/8" = 1'-0"
 0 4 8 16 (N FEET)

tyco
 SimplexGrinnell
 Safer. Smarter. Tyco.[®]
 DISTRICT - 147
 1015 RIVERSIDE STREET
 WESTBROOK, ME 04092
 SERVICE: 207-842-8440
 PHONE: 207-842-8440
 FAX: 207-842-6439

SPARE TIME RECREATION-LASER TAG AMUSEMENT

SPARE TIME RECREATION-LASER TAG AMUSEMENT
 867 RIVERSIDE STREET
 PORTLAND, MAINE 04103-1070

ISSUE NO.	DATE	CHK	DESCRIPTION
1	8/12/15	SK	REVISED PER ADDITION OF MAINTENANCE SHEET

DRAWN BY: MD
 CHECKED BY: SK
 ISSUE DATE: 8/12/15
 PROJECT #: 147-985922501
 SIMPLEXGRINNELL © 2015

SYSTEM:
FIRE ALARM SYSTEM

SHEET:
LASER TAG ARENA FLOOR PLAN

FA-101

IMPORTANT NOTICE TO USER: This drawing is the property of Tyco Fire Protection Products, Inc. and is to be used only for the project and address to which it was prepared. No other use, copying, modification or alteration of the information contained herein is to be made without the express written consent of Tyco Fire Protection Products, Inc. The user assumes all liability for the use or reuse of the information contained herein for any other project or address to which it was prepared. This information may not be sold or transferred to any third party, used or otherwise project or address to which it was prepared. SimplexGrinnell assumes no liability for the use or reuse of the information contained herein for any other project or address to which it was prepared.