


ROOF

ROOF

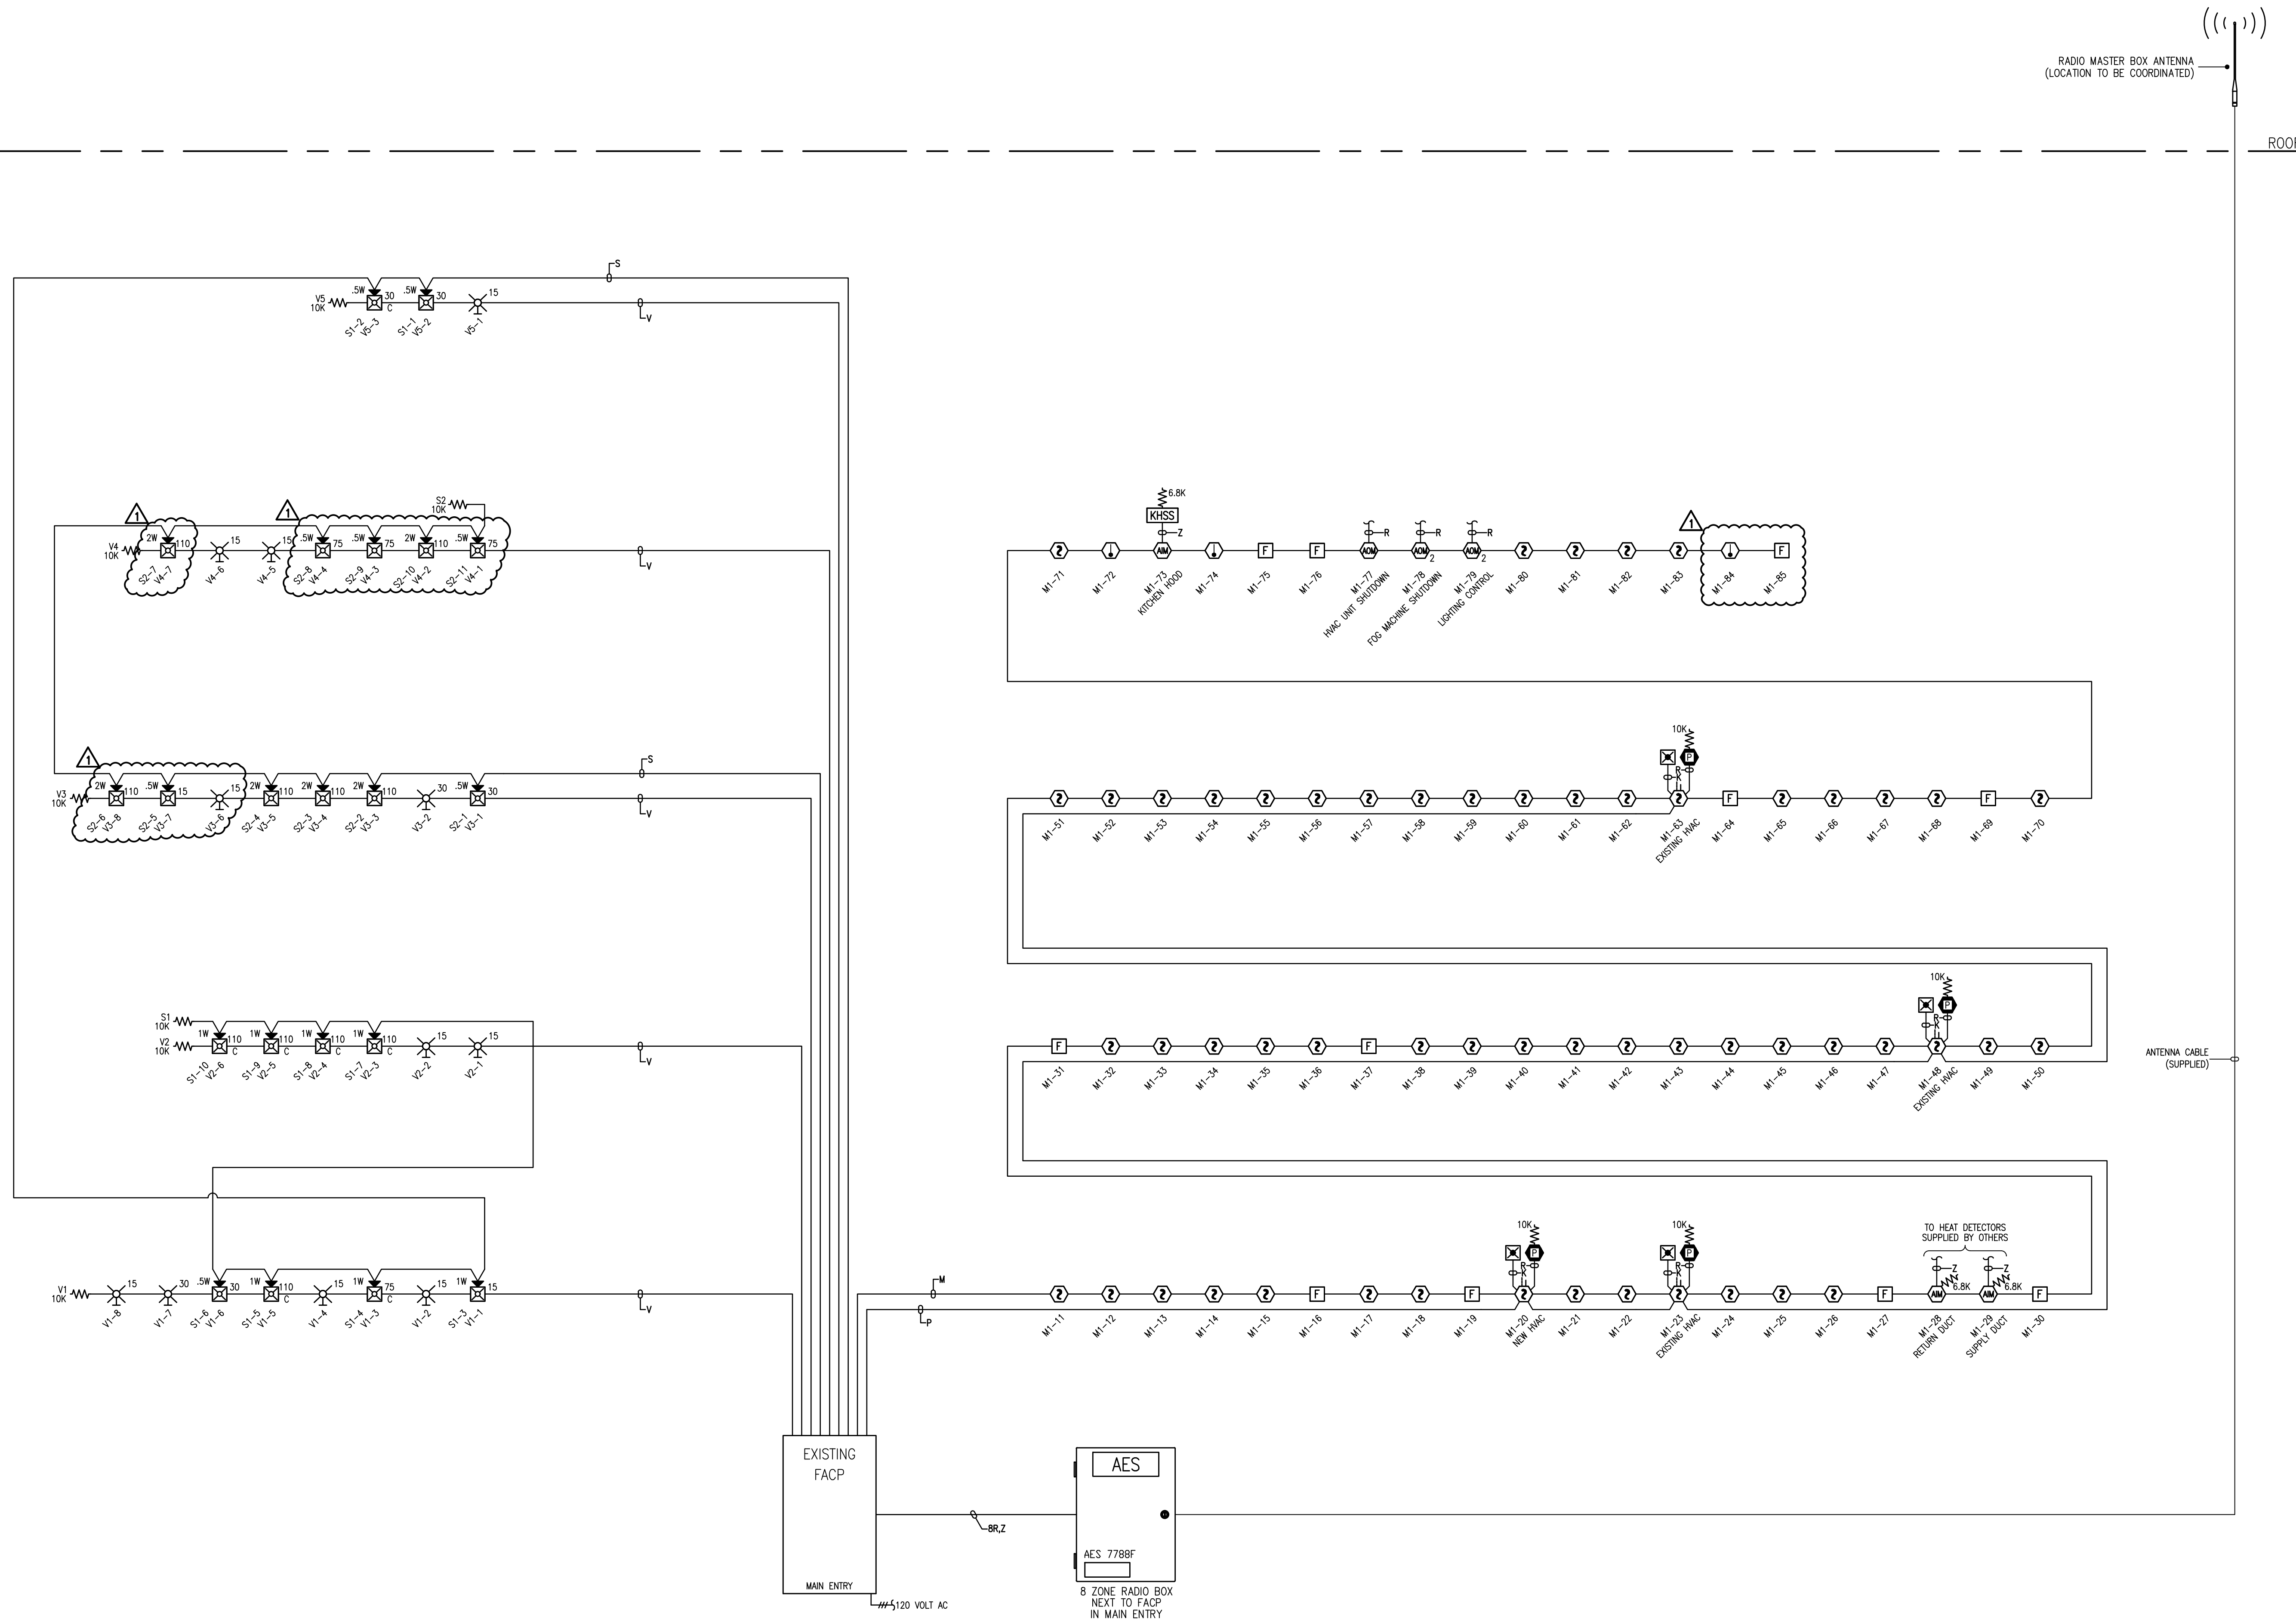

SPARE TIME RECREATION - RISER DIAGRAM

SPARE TIME RECREATION - RISER DIAGRAM

**tyco**  
SimplexGrinnell  
Safer. Smarter. Tyco.™

DISTRICT - 147  
1000 WESTBROOK AVE  
WESTBROOK, ME 04092  
SERVICE: 207-842-8440  
PHONE: 207-842-8440  
FAX: 207-842-8439

**SPARE TIME RECREATION-LASER TAG AMUSEMENT**

SPARE TIME RECREATION-LASER TAG AMUSEMENT  
867 RIVERSIDE STREET  
PORTLAND, MAINE 04103-1070

ISSUE NO.	DATE	BY	CHK	DESCRIPTION
1	8/15/15	MD	SK	REVISED PER ADDITION OF MAINTENANCE SHEET

DRAWN BY:	MD
CHECKED BY:	SK
ISSUE DATE:	8/12/15
JOB #:	
PROJECT #:	147-985922501
SIMPLEXGRINNELL © 2015	
SYSTEM: FIRE ALARM SYSTEM	

SHEET:  
  
RISER DIAGRAM

FA-201

IMPORTANT NOTICE: This drawing is the property of SimplexGrinnell. It is to be used only for the project and location specified. The licensee is responsible for the accuracy of the drawings. The licensee is responsible for the accuracy of the drawings. Any use, reproduction, or distribution of this drawing without the written consent of SimplexGrinnell is prohibited. SimplexGrinnell assumes no liability for the use of these drawings.