

date	revision
08/01/2010	Shifted Pantry, Hall & MP Storage


project name
Spurwink Services

project location
Smith House Renovation
899 Riverside St
Portland, Maine
45°17'58.77N 70°12'03.40W



Demolition Notes


- 1 Remove existing door, frame and blocking. Prep opening for infill wall.
- 2 Remove existing door or window.
- 3 Remove existing wall.
- 4 Remove existing flooring, backing and accessories.
- 5 Remove existing plumbing fixture.
- 6 Remove existing retractable room partition.
- 7 Remove existing lighting fixtures from ceiling.
- 8 Remove existing closet rods and shelving.
- 9 Remove existing lavatory and toilet cap all water lines, waste lines and floor drain at floor level.
- 10 Remove countertops, cupboards and cabinets.
- 11 Remove existing masonry chimney, fireplace, hearth.

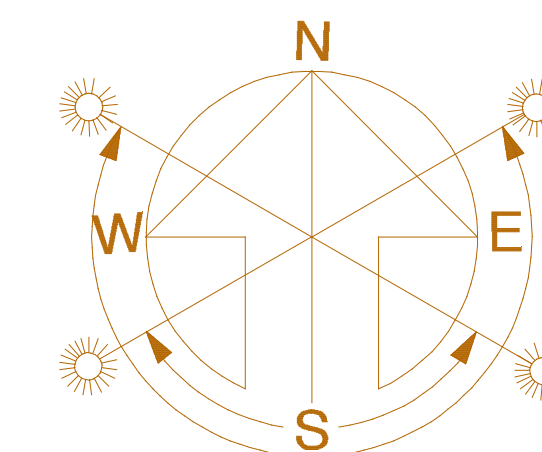

Partition Legend

- Existing Partitions to Remain
- Existing Partitions and components to be demolished

10 Existing Second Floor Plan & Demo Plan

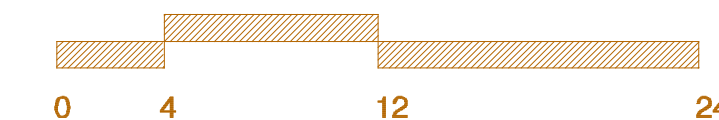

date	July 29, 2016
scale	3/16" = 1'-0"
project #	2016-007
drawing title	Existing Second Floor and Demo Plan
drawing number	D102