


ROOF SPRINKLER PLAN
SCALE: 1/8" = 1'-0"

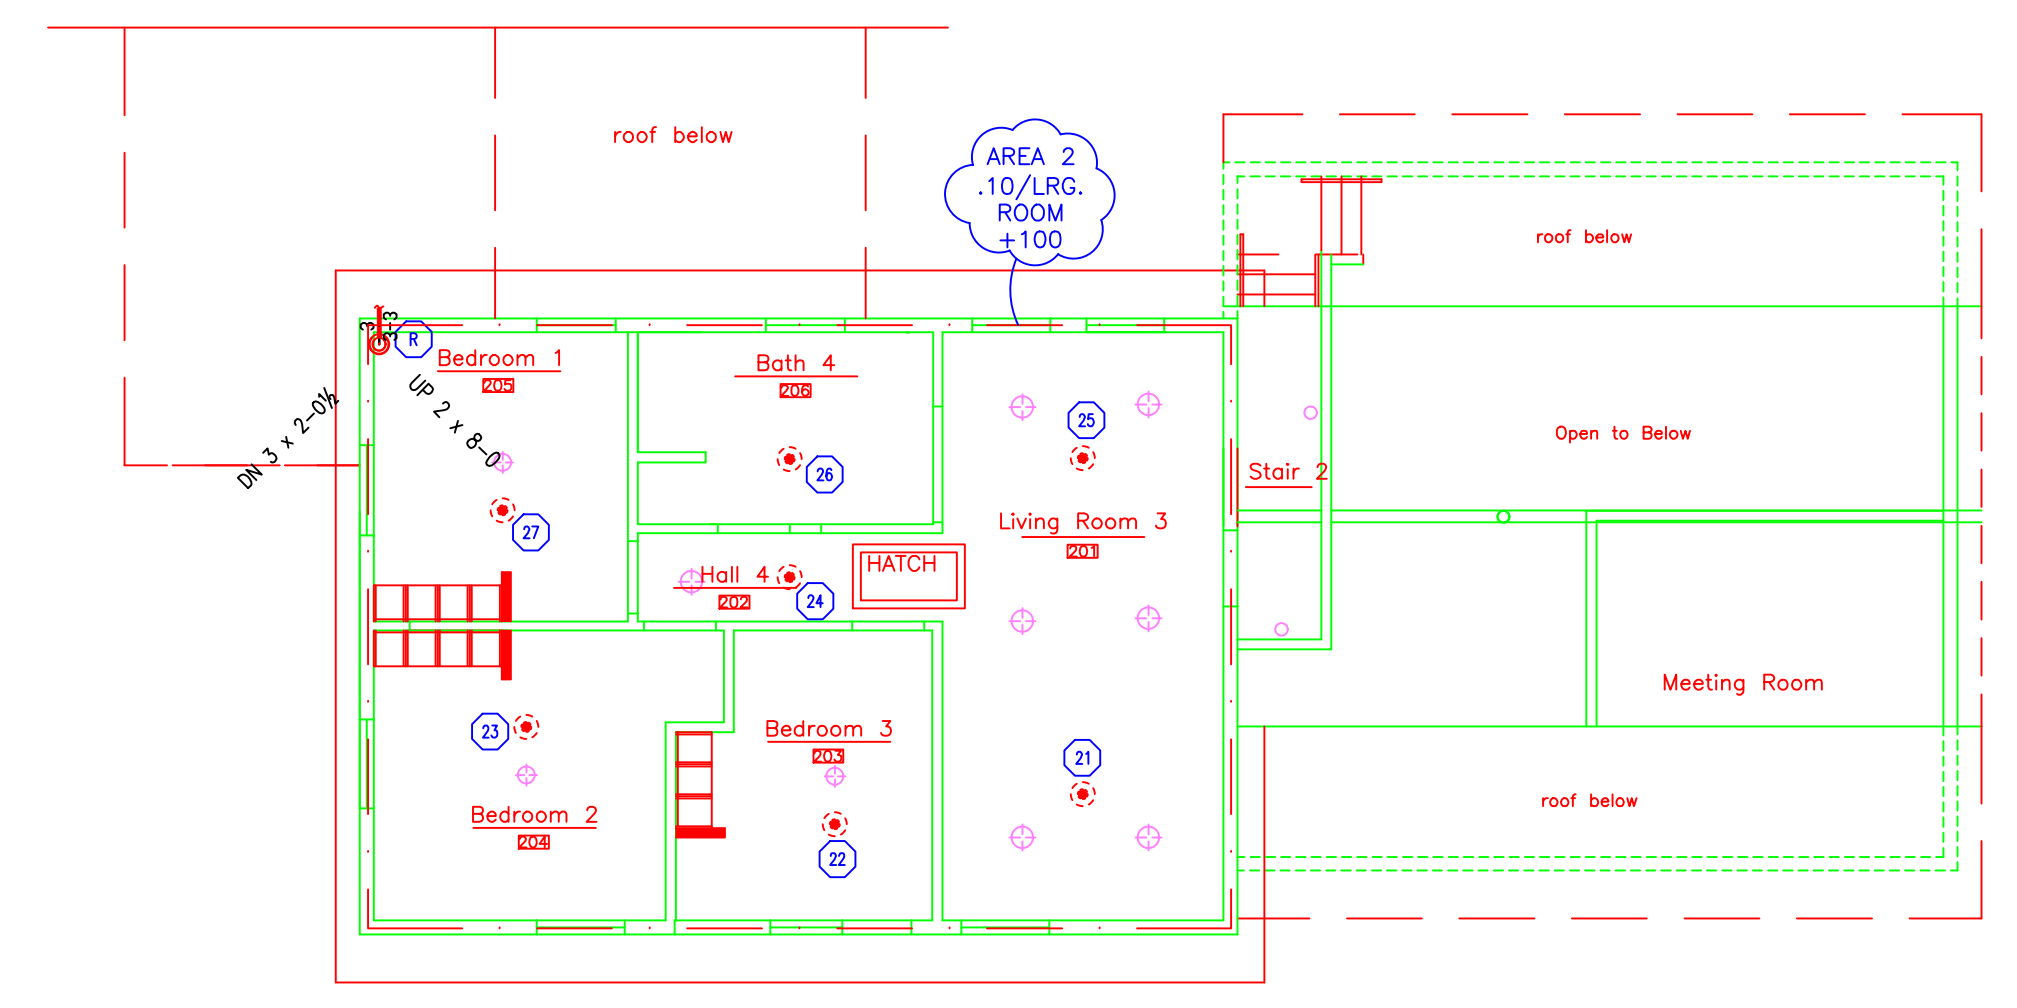

PARTIAL THIRD FLOOR SPRINKLER PLAN
SCALE: 1/8" = 1'-0"
FINISH FLOOR ELEV. 117.67'

SUBMITTAL COPY

SPRINKLER HEAD LEGEND										
SYMBOL	MAKE	MODEL	SIN	FINISH	TYPE	TEMP	NPT	ORIFICE	K-FACTOR	TOTAL
SEE SHEET 1 FOR HEAD DETAIL										

LICENSE# 093
R.M.S.# 442

PERMIT # ????

SPRINKLER SYSTEMS INC.
P.O. BOX 1285
LEWISTON MAINE
04243-1285

CONTRACT WITH		PC	
SYSTEM TYPE		REVISIONS	
WET	<input checked="" type="checkbox"/>	NO.	DATE
DRY	<input type="checkbox"/>		
DELUGE	<input type="checkbox"/>		
PREACTION	<input type="checkbox"/>		
ME. LIFE	<input type="checkbox"/>		
HYDRO-PRO	<input type="checkbox"/>		
DRAWN BY		RDO	
CHECKED BY		SEG	
DATE		12/8/2016	
TOTAL SPKRS ON JOB		135	
SHEET#		2 of 2	
JOB#		16136	

SMITH HOUSE-SPURWINK
899 RIVERSIDE STREET
PORTLAND, ME 04103

