

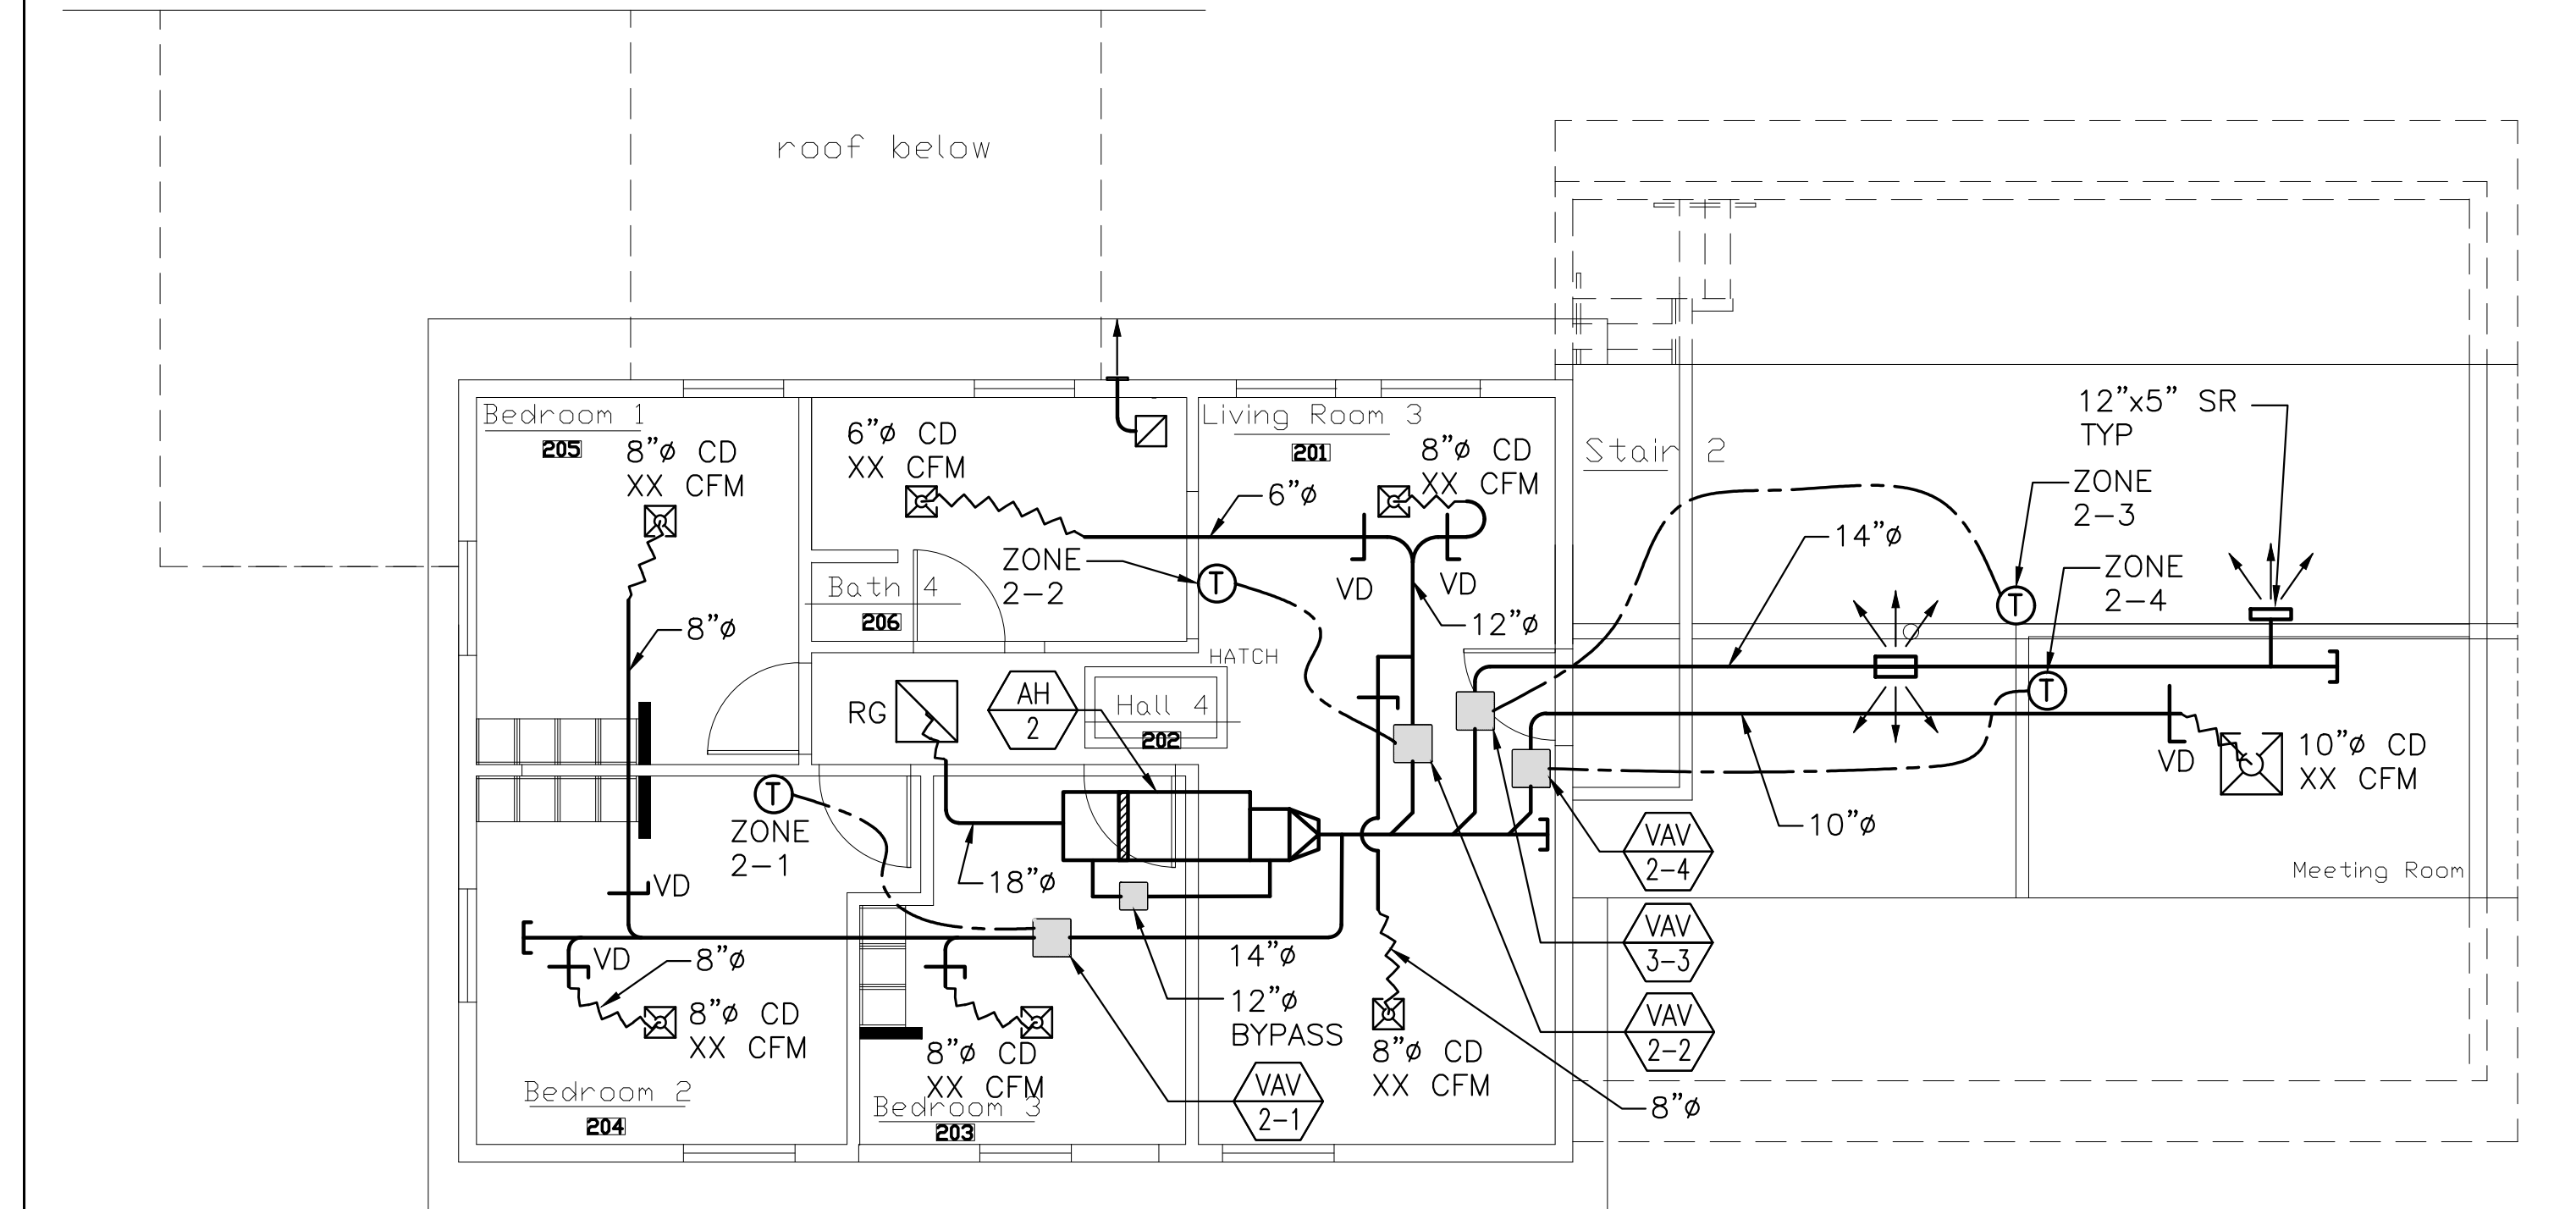
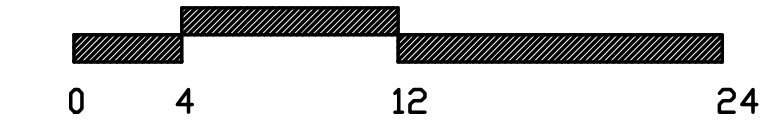
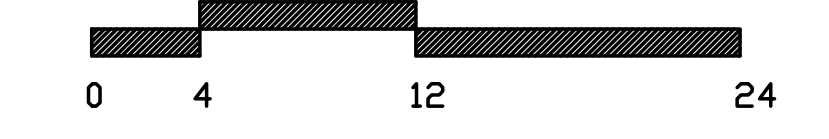
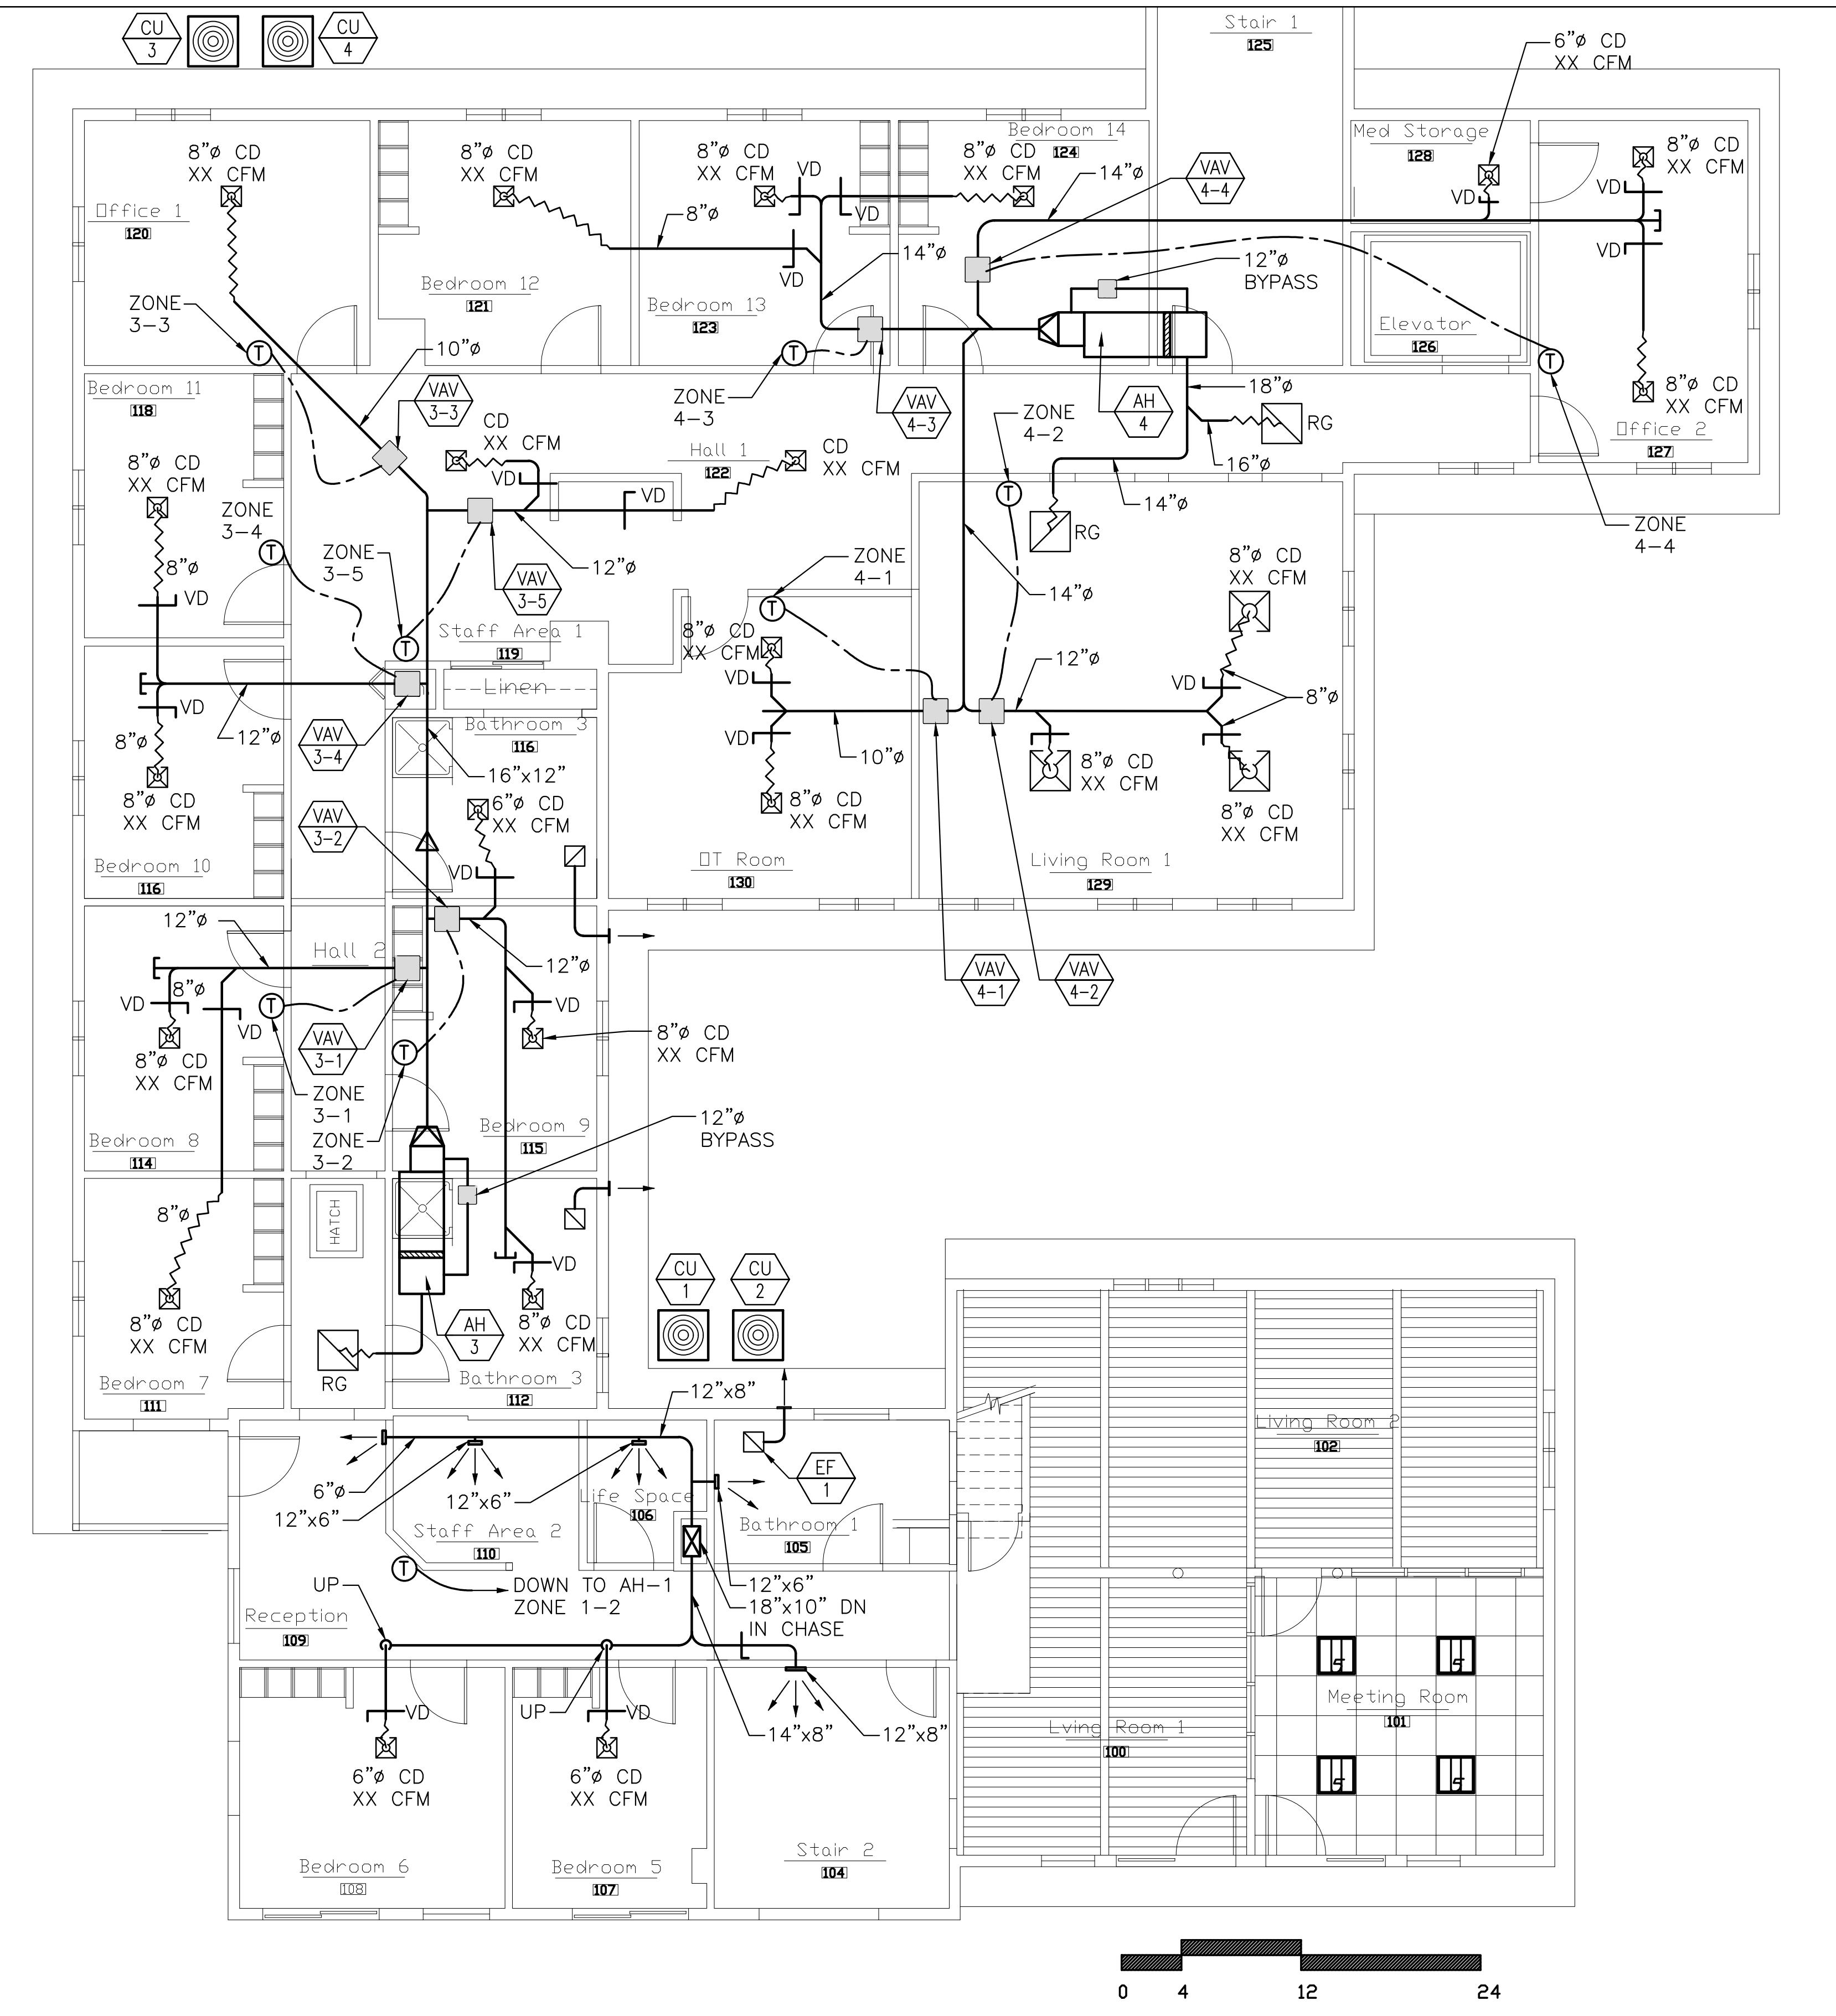



Partial Ground Floor Plan

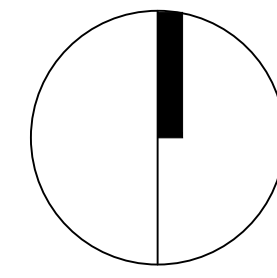

Partial Third Floor Plan

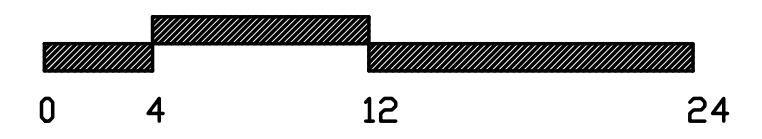

 <p>Design • Build • Install • Service</p> <p>73 BRADLEY DRIVE WESTBROOK, MAINE 04092 (207) 854-HVAC (4822)</p>	<p>SPURWINK SERVICES SMITH HOUSE RENOVATION PORTLAND, MAINE</p>					
	<p>REVISIONS</p> <table border="1"> <thead> <tr> <th>NO.</th> <th>NOTES</th> </tr> </thead> <tbody> <tr> <td> </td> <td> </td> </tr> </tbody> </table>	NO.	NOTES			<p>PROJECT: NEW DUCTWORK FLOOR PLANS</p>
NO.	NOTES					
<p>SHEET TITLE: SCALE: 3/16"=1'-0"</p>		<p>DATE: 12-2-2016</p>				
<p>DRAWN BY: A22 CADD DRAFTING SERVICES, INC.</p>		<p>SHEET No.</p>				
<p>CHECKED BY:</p>		<p>M-1</p>				
<p>"AS-BUILT" DATE:</p>						