


LEGEND


EXISTING	DESCRIPTION	PROPOSED
---	BOUNDARY LINE/ROW	---
---	SETBACK	---
---	EASEMENT	---
---	BUILDING	---
---	WETLANDS	---
---	EDGE WETLAND	---
---	SIGN	---
---	EDGE PAVEMENT	---
---	EDGE CONCRETE	---
---	CURBLINE	---
---	TREELINE	---
○	DECIDUOUS TREE	○
●	CONIFEROUS TREE	●
---	MULCH LINE	---
---	SCREENING FENCE	---
○	BOLLARD	○
○	LIGHT POLE/WALL	○
○	UTILITY POLE	○

PLANT SCHEDULE

ID	BOTANICAL	COMMON	SIZE
MS	MISCANTHUS SINENSIS	SILVER MAIDEN GRASS	2'
LIGHT	CLEPHEATIS X ARABELLA	ARABELLA CLEPHEATIS	5' ON STANDARD, FASTEN TO ARBORS WITH TIES, MINIMUM 2 YEAR POT 24-36" HGT
RR	ROSA RUGOSA	SEA ROSE	24-36" HGT
BO	SCORBARIA SCROFOLIA 'SEPT'	ASHLEAF (FALSE) SPIREA	3' - CAL.
UA	ULMUS AMERICANA 'VALLEY FORESS'	AMERICAN ELM	24-36" HGT
BN	BETULA NIGRA	RIVER BIRCH	24-36" HGT
TC	TILIA CORDATA 'GREENSHIRE'	LINDEN	24-36" HGT
AC	ABIES CONCOLOR	WHITE FIR	3' - CAL.
AG	ACER GINALE FLAME	AMUR MAPLE	24-36" HGT
ACD	APHELANCHIER CANADENSIS	AUTUMN BRILLIANCE SERVICEBERRY	3' - CAL.
RO	ROSA RUGOSA	KNOCK OUT ROSE	6-8' HGT
FP	FICIA FINGENS FAT ALBERT	FAT ALBERT SPRUCE	24-36" HGT
UF	UEGELA FLORIDA GARDEN TONY	GASTY UEGELA	3-4' HGT
HA	HYDRANGEA ARBORESCENS 'ANNABELLE'	ANNABELLE HYDRANGEA	3-4' HGT
PG	PARTHENOCISSUS QUINQUEFOLIA	VIRGINIA CREEPER	5' ON STANDARD, FASTEN TO ARBORS WITH TIES, MINIMUM 2 YEAR POT 4-5' HGT
VP	VIBURNUM PFLICATUM 'TOMMYHAT'	DOUBLEFILE VIBURNUM	3' - CAL.

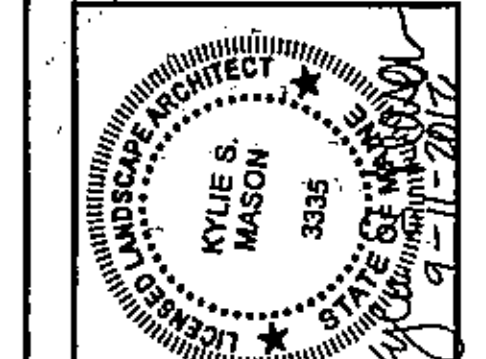

REV.	DATE	BY	DESCRIPTION
0	09/19/12	RLM	REVISED PER CONDITIONS OF APPROVAL
1	09/10/12	RLM	REVISED PER CITY REVIEW COMMENTS
2	07/06/12	RLM	PRELIMINARY SITE PLAN SUBMISSION TO CITY

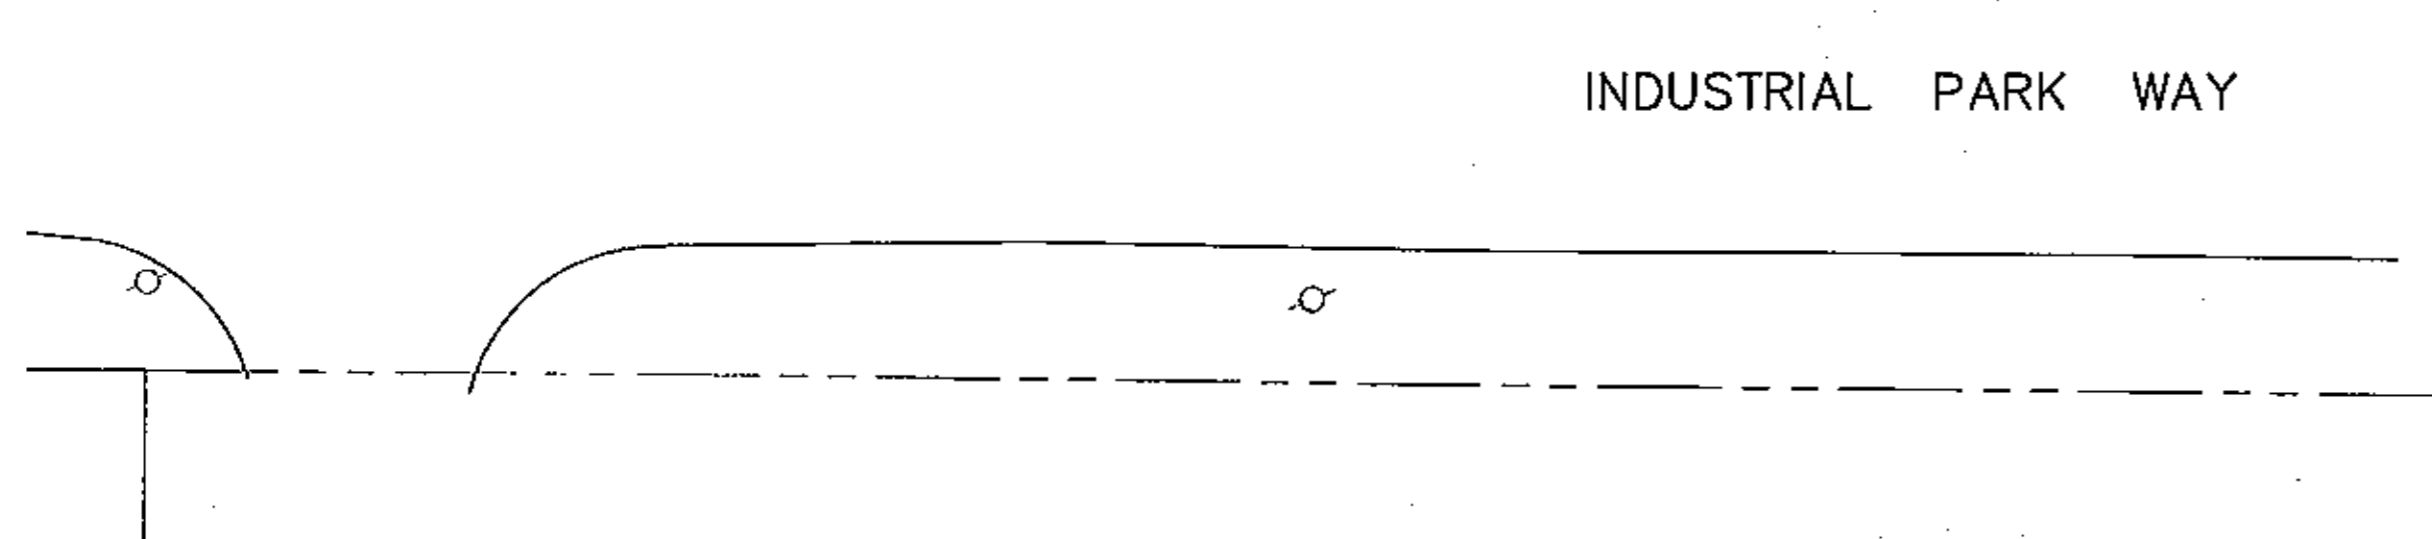

NOTES:





- ALL TREE SAVE AREAS MUST BE IDENTIFIED IN THE FIELD PRIOR TO SITE WORK.
- PROTECTIVE MEASURES WILL BE REQUIRED IN TREE SAVE AREAS IN ORDER TO PREVENT THE STORAGE OF MATERIALS AND EQUIPMENT.
- IN THE CASE THAT TREE SAVE AREAS ARE AFFECTED DURING CONSTRUCTION, ADDITIONAL TREES/SHRUBS MAY BE NEEDED.

LIGHTING LEGEND

LS-1
★ UNIQUE LIGHTING SYSTEMS:
COMET - B75-30-18-58-16-100-20

LS-2
★ UNIQUE LIGHTING SYSTEMS:
GALAXY - F75-C25-35-DR-APOLLOCOPT

● KIM LIGHTING:
S-3 - EKG401-3/20CHFS-E18/18 (20' MOUNTING HEIGHT)
S-35 - EKG401-3/20CHFS-E18/18 (20' MOUNTING HEIGHT)
S-45 - EKG401-4/25CHFS-E18/18 (20' MOUNTING HEIGHT)

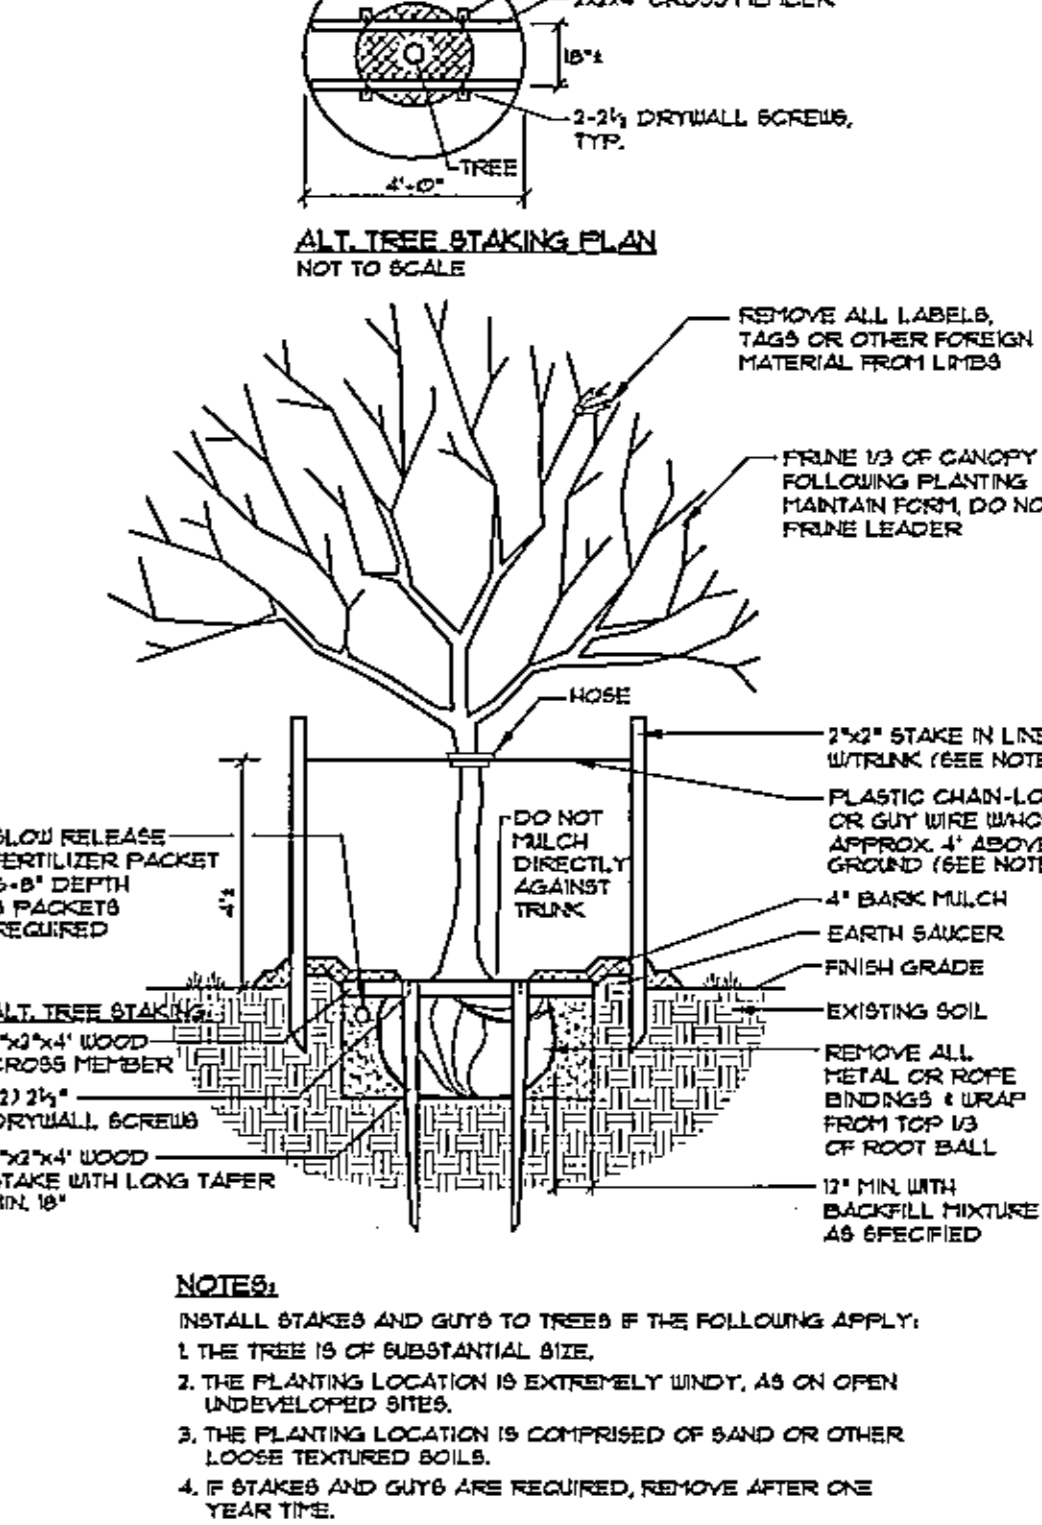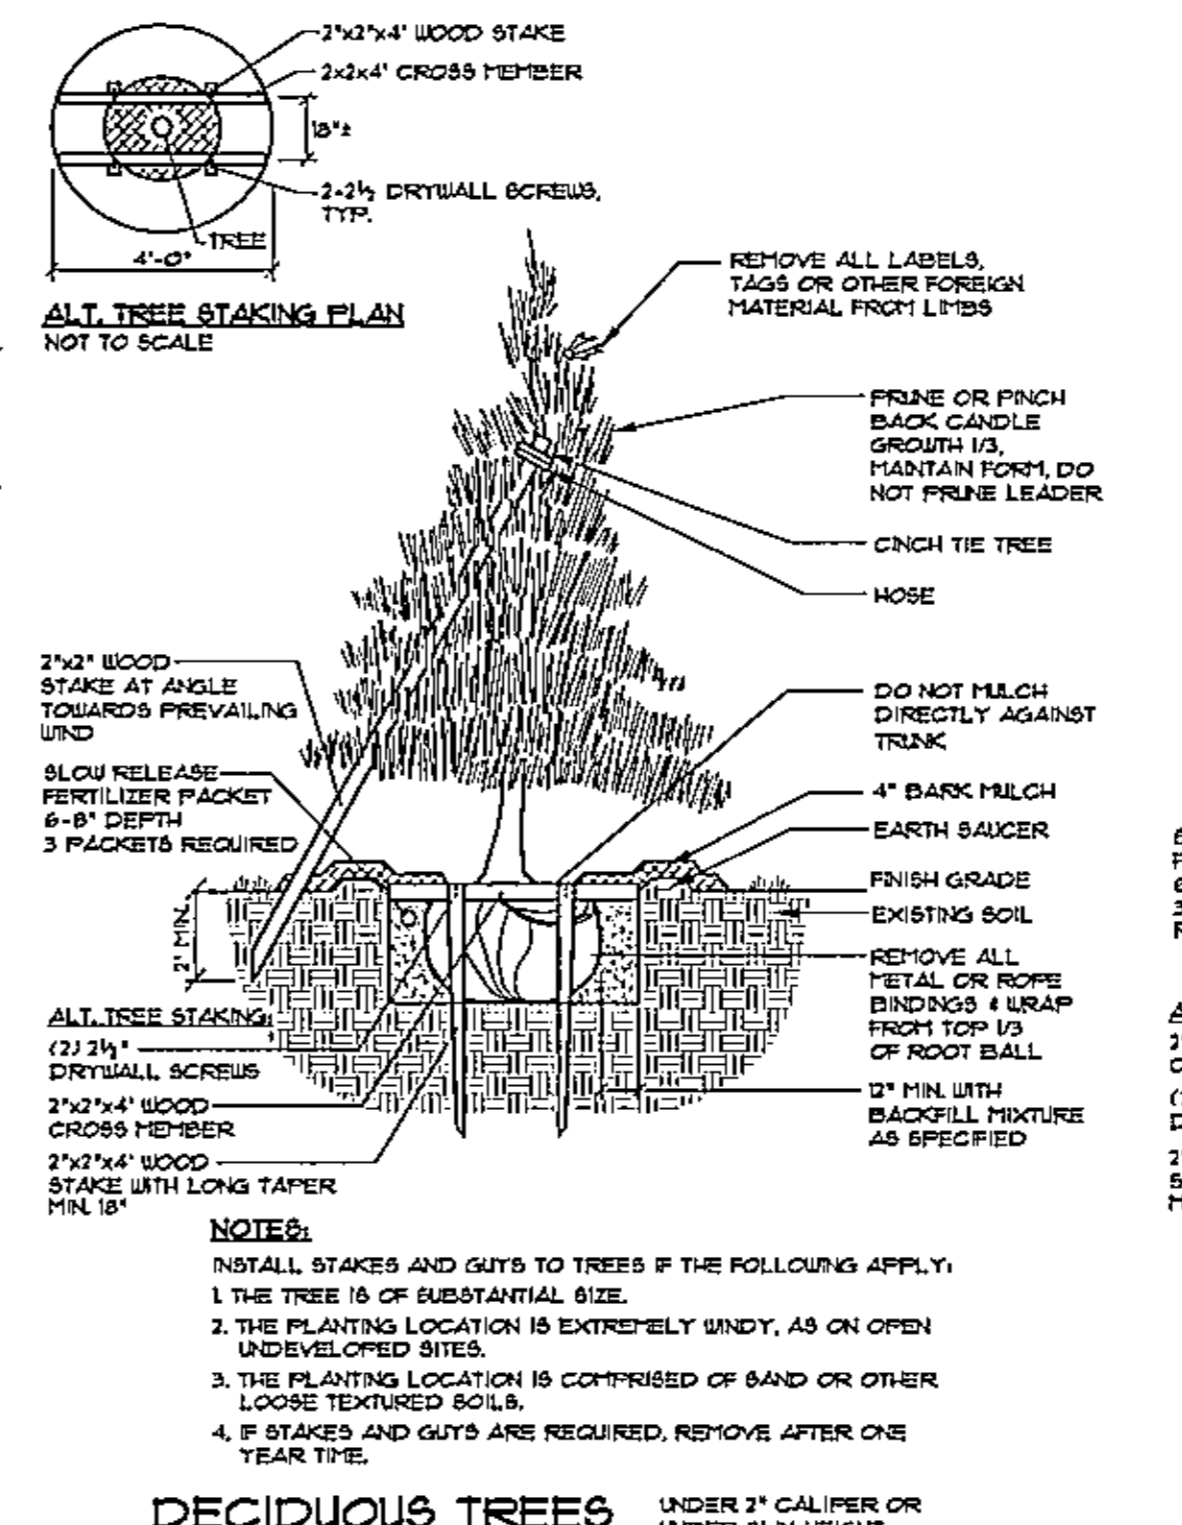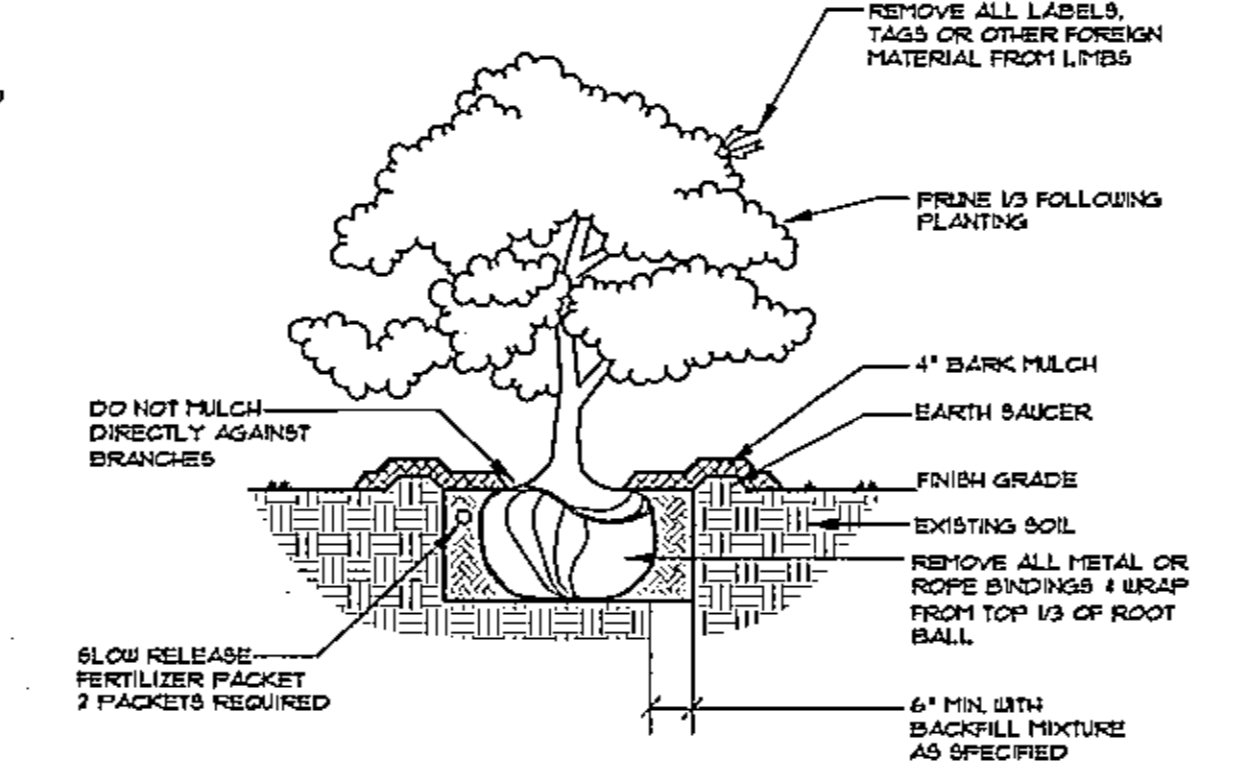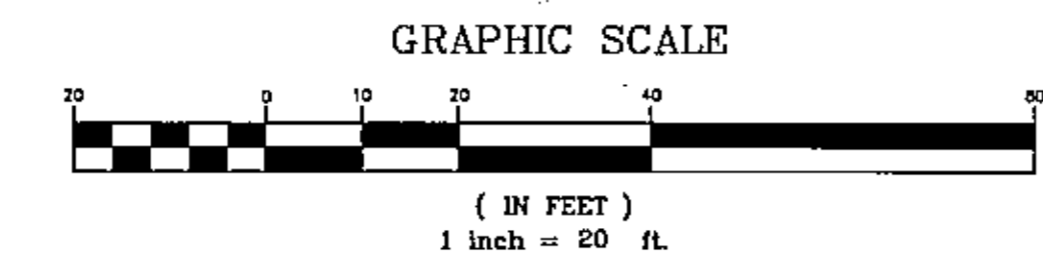

SEBAGO TECHNICALS

75 John Roberts Rd. - Suite 1A
South Portland, ME 04106
(207) 255-2525
www.sebagotechnicals.com

PROJECT NO.: FIELD BOOK DESIGN CHKD DRAWN
02249 847 KSM KSM JAR

LANDSCAPE AND LIGHTING PLAN
OF:
ALLAGASH BREWING COMPANY
INDUSTRIAL WAY
PORTLAND, MAINE
FOR:
50 INDUSTRIAL WAY
PORTLAND, MAINE 04103

DATE: 06/19/12
SCALE: 1" = 20'

SHEET 6 OF 8