
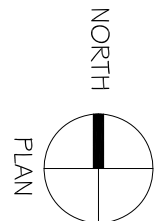


- FIRE SUPPRESSION & LIFE SAFETY SYSTEM NOTES:**
1. THE ENTIRE BUILDING HAS AN EXISTING NFPA 1.3 FIRE SUPPRESSION SPRINKLER SYSTEM. THE EXISTING SPRINKLER SYSTEM SHALL BE MODIFIED BY A CERTIFIED SPRINKLER CONTRACTOR FOR THE PROPOSED PLANS AND SHALL BE REVIEWED BY THE LOCAL FIRE DEPARTMENT. THE CONTRACTOR SHALL BEAR SOLE RESPONSIBILITY FOR THE DESIGN AND INSTALLATION OF THE MODIFIED SYSTEM FOR OCCUPANCY.
 2. UPGRADE THE EXISTING FIRE ALARM SYSTEM AS REQUIRED FOR COMPLIANCE WITH NFPA 101 LIFE SAFETY CODE. COORDINATE WITH SPRINKLER SYSTEM MODIFICATION. THE CONTRACTOR SHALL BEAR SOLE RESPONSIBILITY FOR THE DESIGN AND INSTALLATION OF THE MODIFIED SYSTEM FOR OCCUPANCY.

LIFE SAFETY SYMBOLS

	EXIT LIGHT
	FIRE EXTINGUISHER
	FIRE ALARM PULL MANUAL PULL STATION
	FIRE ALARM PANEL
	EMERGENCY LIGHT
	FIRE ALARM NON-STROBE UNIT
	FIRE ALARM STROBE LIGHT
	SMOKE DETECTOR
	SPACE DETECTOR W/ AUDIBLE ALARM
	NOT AN EXIT SIGN
	KNOCK BOX
	1 HR. RATED PARTITION
	2 HR. RATED PARTITION

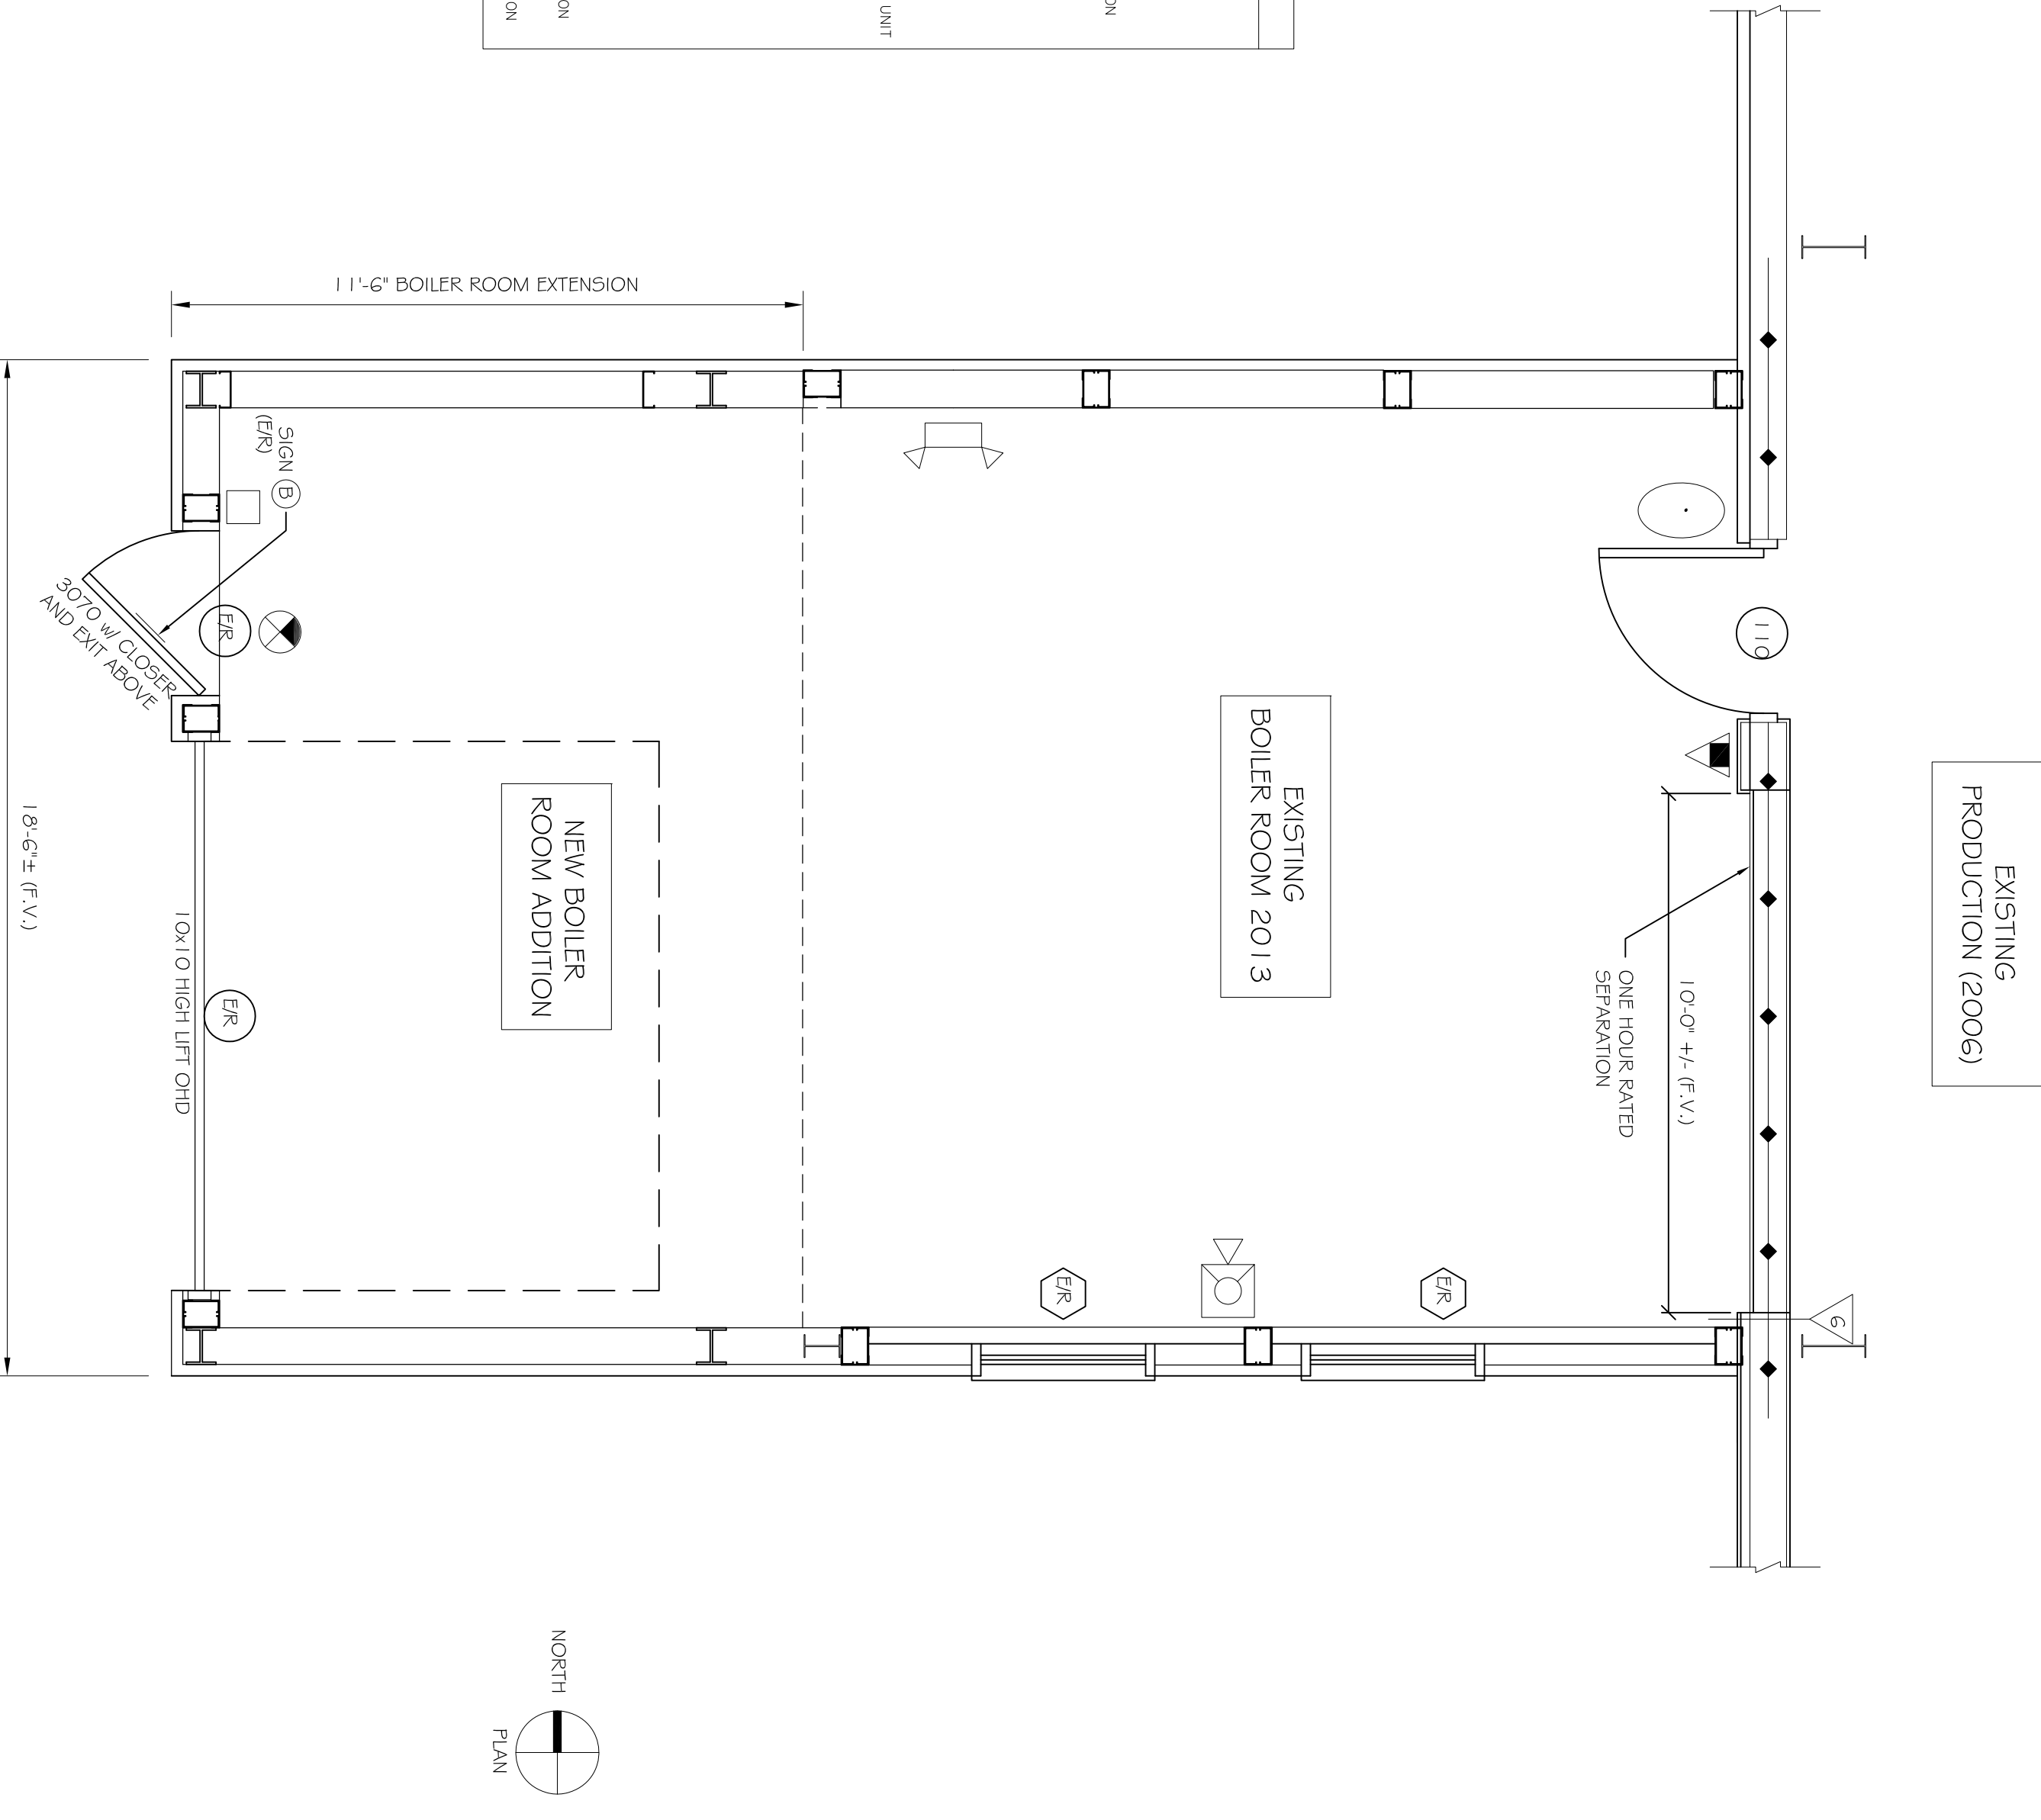


A4

CODE COMPLIANCE PLAN
SCALE: 3/8" = 1'-0"

A2

FLOOR PLAN
SCALE: 3/8" = 1'-0"

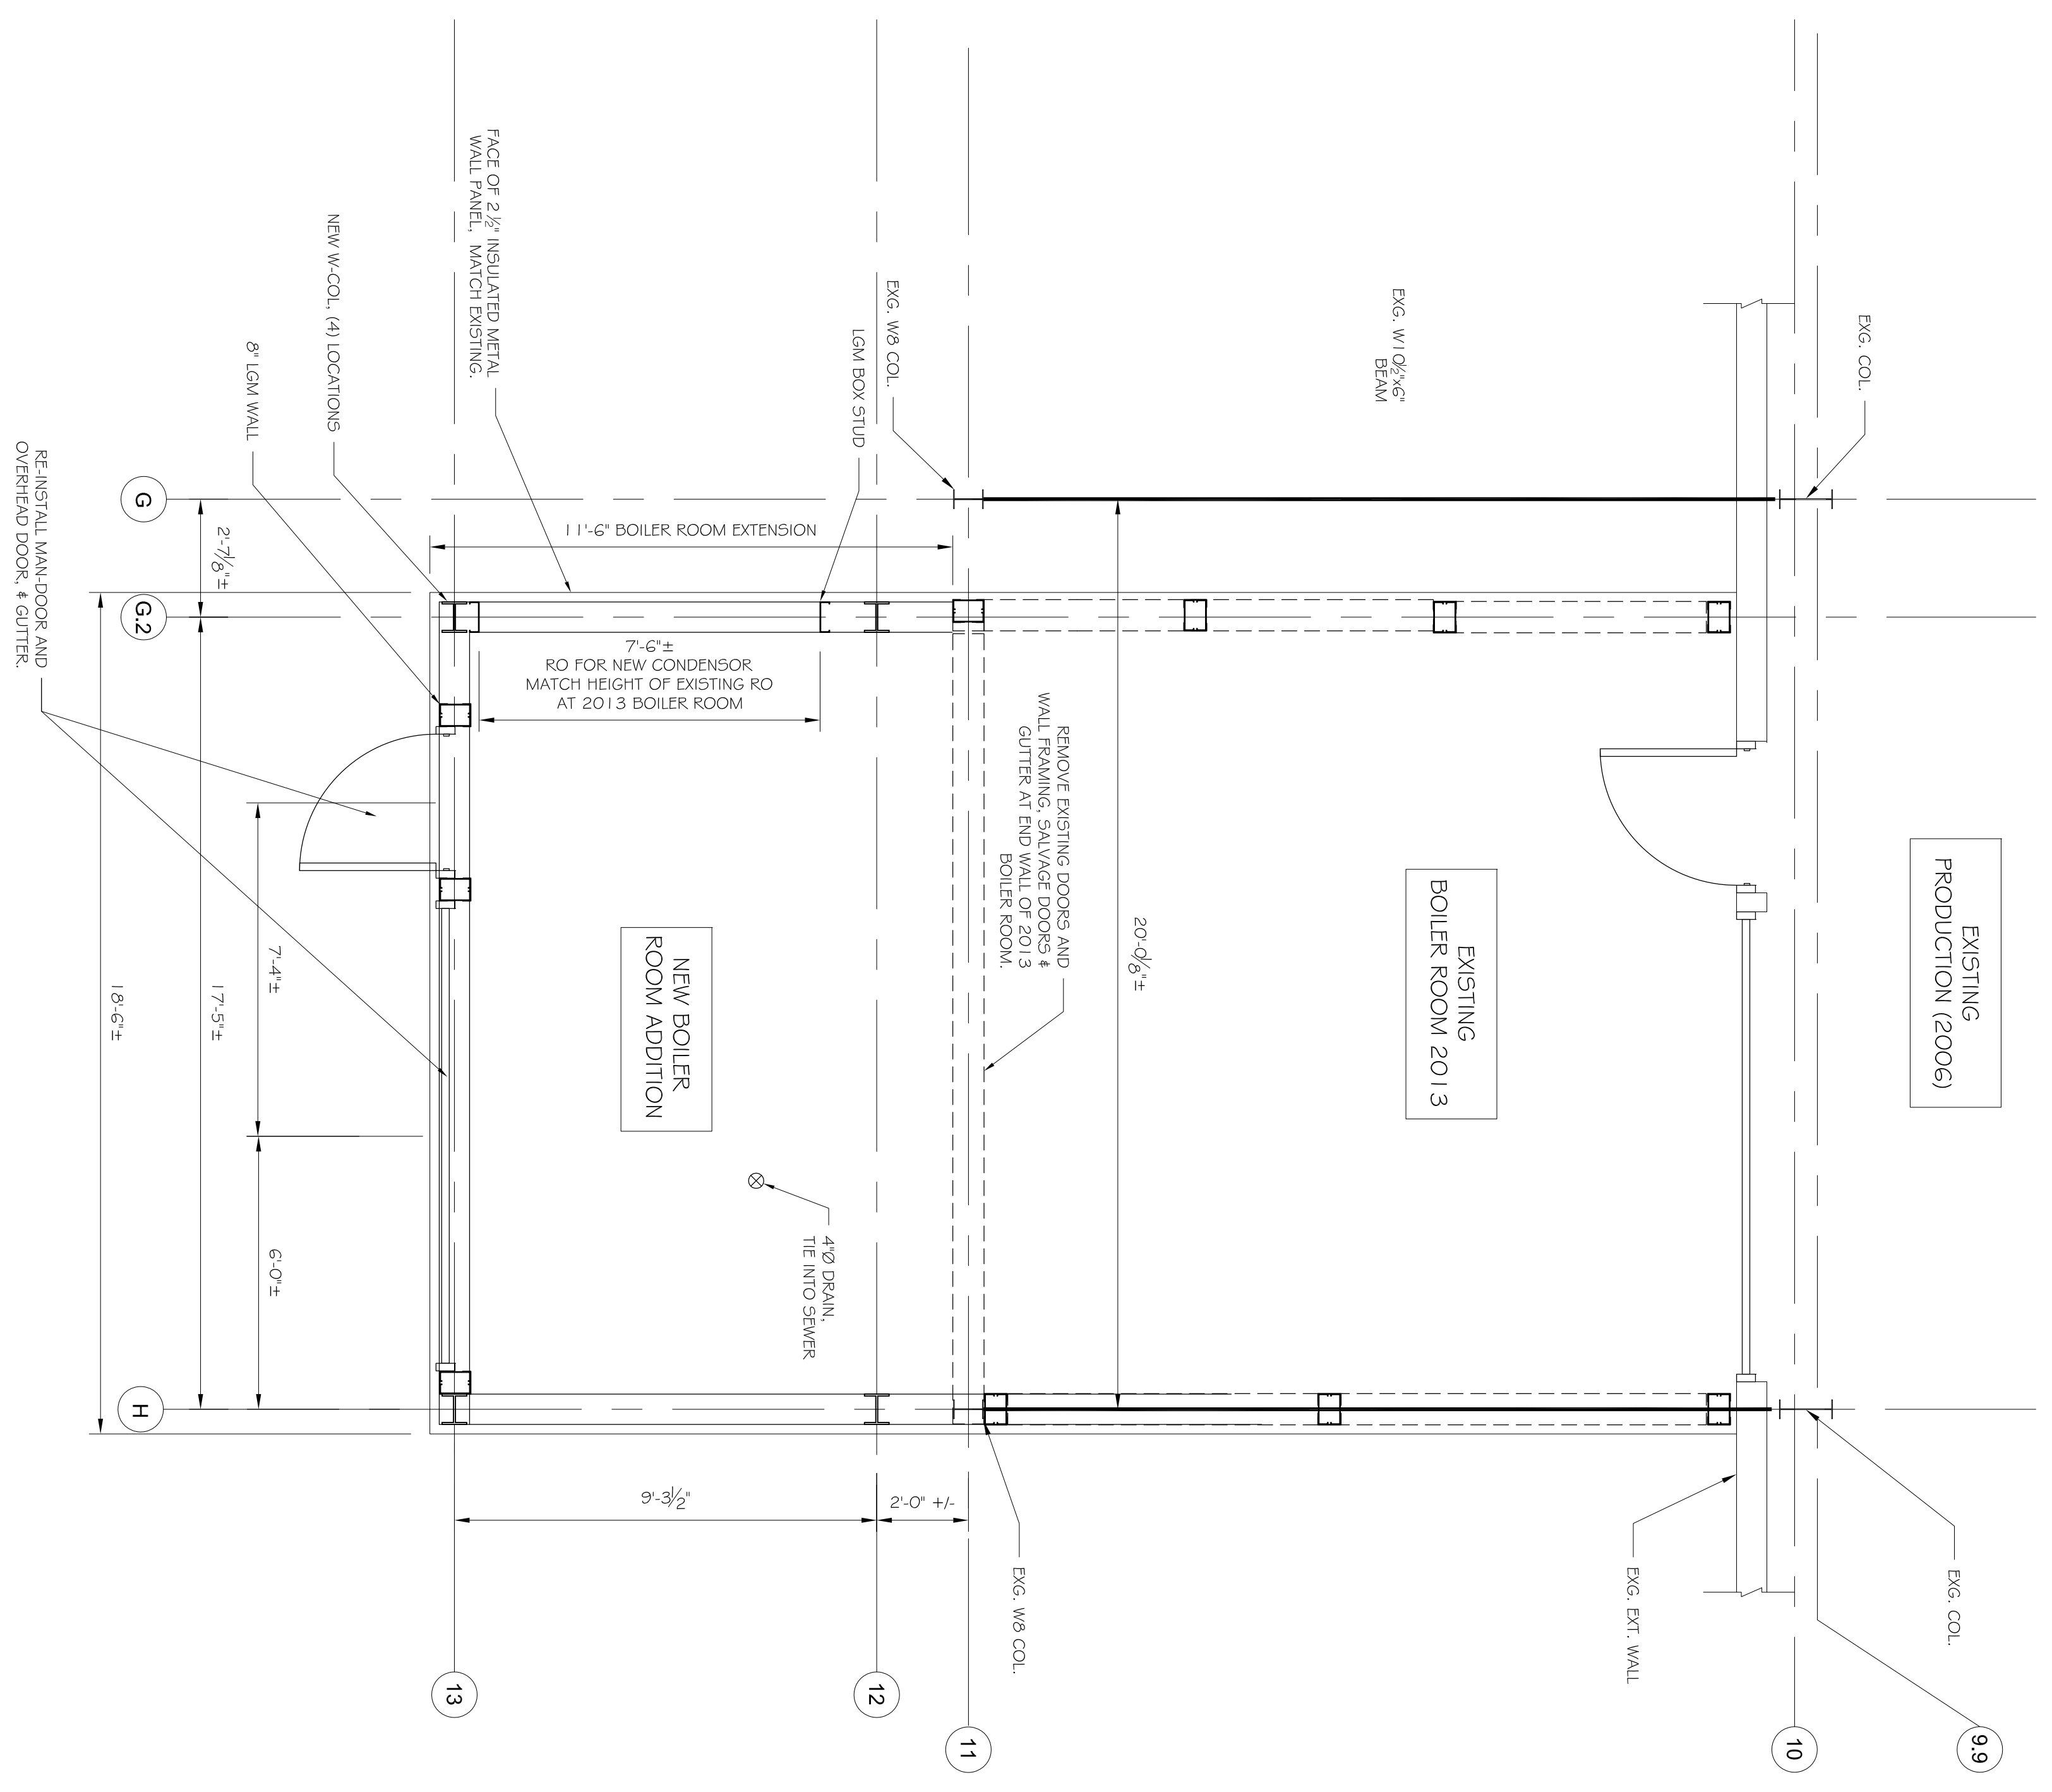

REVISIONS	DATE
No.	DESCRIPTION
BY	

PROJECT: **ALLAGASH BOILER ROOM EXTENSION**
INDUSTRIAL WAY, PORTLAND, MAINE
 FOR: ALLAGASH BREWING CO.


SHEET TITLE:
FLOOR PLAN AND DETAILS
ISSUED FOR PERMITTING

THIS DRAWING, DESIGN AND ELECTRONIC FILE ARE THE PROPERTY OF ASSOCIATED DESIGN PARTNERS, INC. NO PART OF THIS DOCUMENT WITHOUT WRITTEN CONSENT IS PROHIBITED.

ASSOCIATED DESIGN PARTNERS INC.

80 Leighton Road
 Falmouth, Maine 04105

Office: (207) 878-1751
 Fax: (207) 878-1788
 E-Mail: adp@adpengineering.com

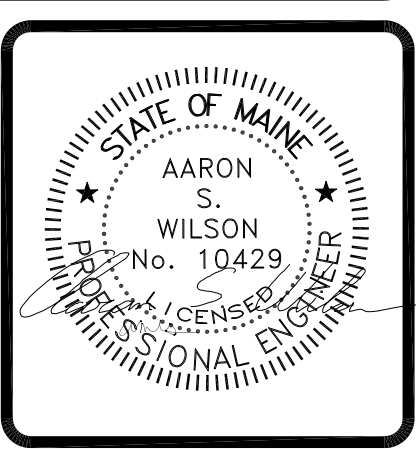

DATE: 6-15-15
 SCALE: AS NOTED
 DESIGN BY: ASW
 DRAWN BY: RSC
 FILE #: 14307
 PROJECT NUMBER:
14307
 SHEET NO:
A101