



C4 TANK ANCHORS
SCALE: 1 1/2" = 1'-0"

C3 SLAB SECTION
SCALE: 1/2" = 1'-0"

- FRAMING NOTES:
- SEE S102 FOR GENERAL DESIGN NOTES.
 -
 - "UNO" INDICATES "UNLESS NOTED OTHERWISE"
 - CONTRACTOR VERIFY ALL DIMENSIONS NOTED (+/-).

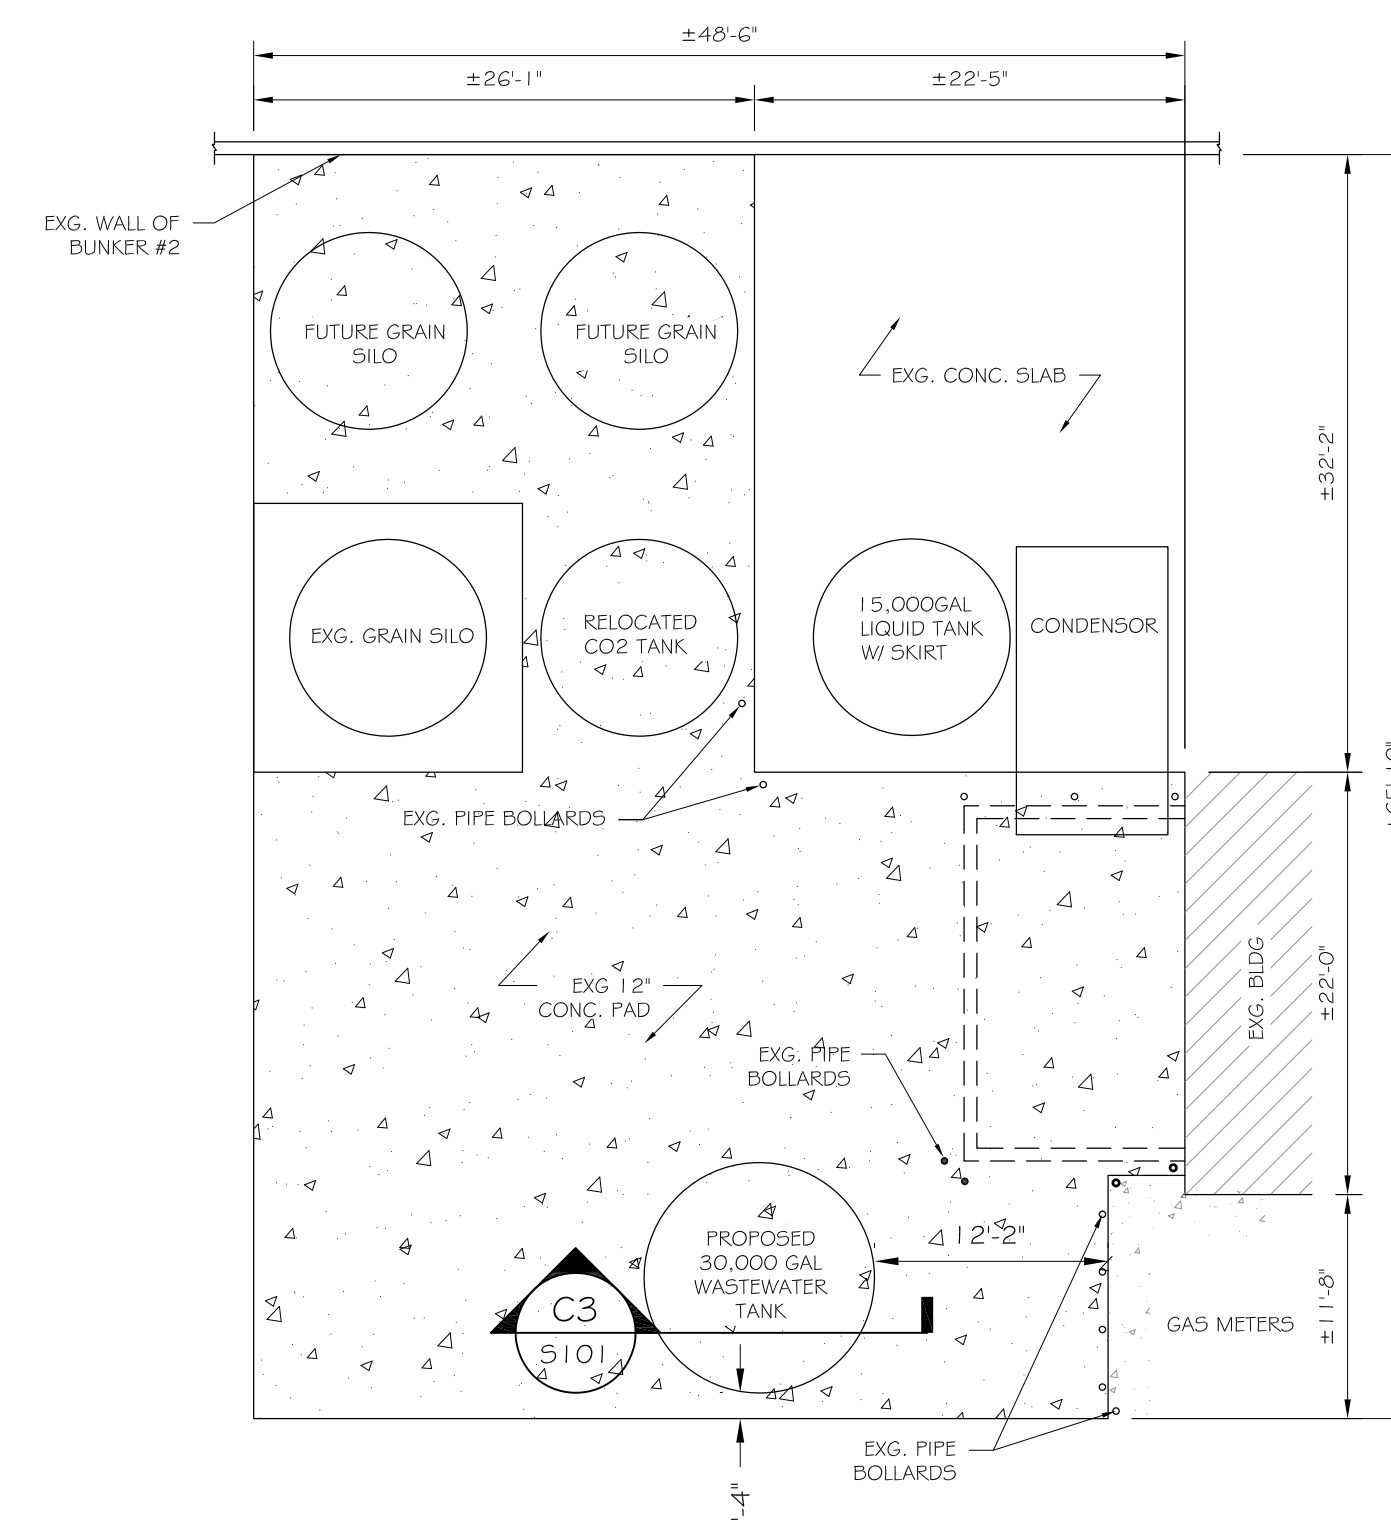

A4
A2 PARTIAL SITE PLAN
SCALE: 1"=10'-0"

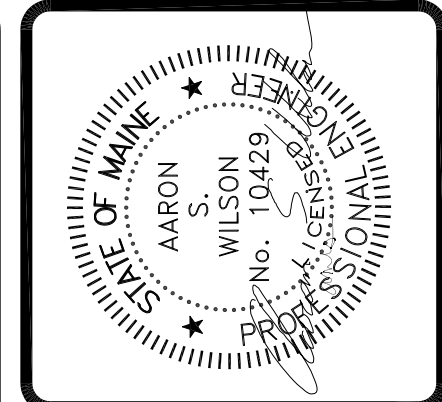

ASSOCIATED DESIGN PARTNERS INC.
Office: (207) 878-1751
Falmouth, Maine 04105
Fax: (207) 878-1788
E-Mail: adp@adpengineering.com

THIS DRAWING, DESIGN AND ELECTRONIC FILE ARE THE PROPERTY OF ASSOCIATED DESIGN PARTNERS, INC. THE REPRODUCTION, COPYING OR ANY OTHER USE OF THIS DOCUMENT WITHOUT WRITTEN CONSENT IS PROHIBITED.

PROJECT: **ALLAGASH WASTEWATER TANK**
50 INDUSTRIAL WAY, PORTLAND, MAINE
FOR: ALLAGASH BREWING CO.
SHEET TITLE: **STRUCTURAL PLANS AND DETAILS**
ISSUED FOR PERMITTING

REVISIONS	DATE

DATE : 5/17/16
SCALE : AS NOTED
DESIGN BY: ASW
DRAWN BY: RSC
FILE #: 14307
PROJECT NUMBER:
14307
SHEET NO:
S101