


REVISION  
PRICING SET  
NOT FOR  
CONSTRUCTION

DRAWING NAME  
2018 PACKAGING ADDITION  
ALLAGASH  
BREWING COMPANY  
50 INDUSTRIAL WAY  
PORTLAND, MAINE 04103  
PROJECT # 18-005

SHEET  
ADDITION  
LIGHTING PLAN

DATE  
4 APRIL 2018  
SCALE  
1/8" = 1'-0"  
DRAWN BY  
PMC/SAJ  
JOB NO.  
180112  
SHEET  
E-1

COPYRIGHT  
REPRODUCTION OR REVUE OF THIS  
DOCUMENT WITHOUT WRITTEN  
PERMISSION FROM GRANT HAYS  
ASSOCIATES IS PROHIBITED.

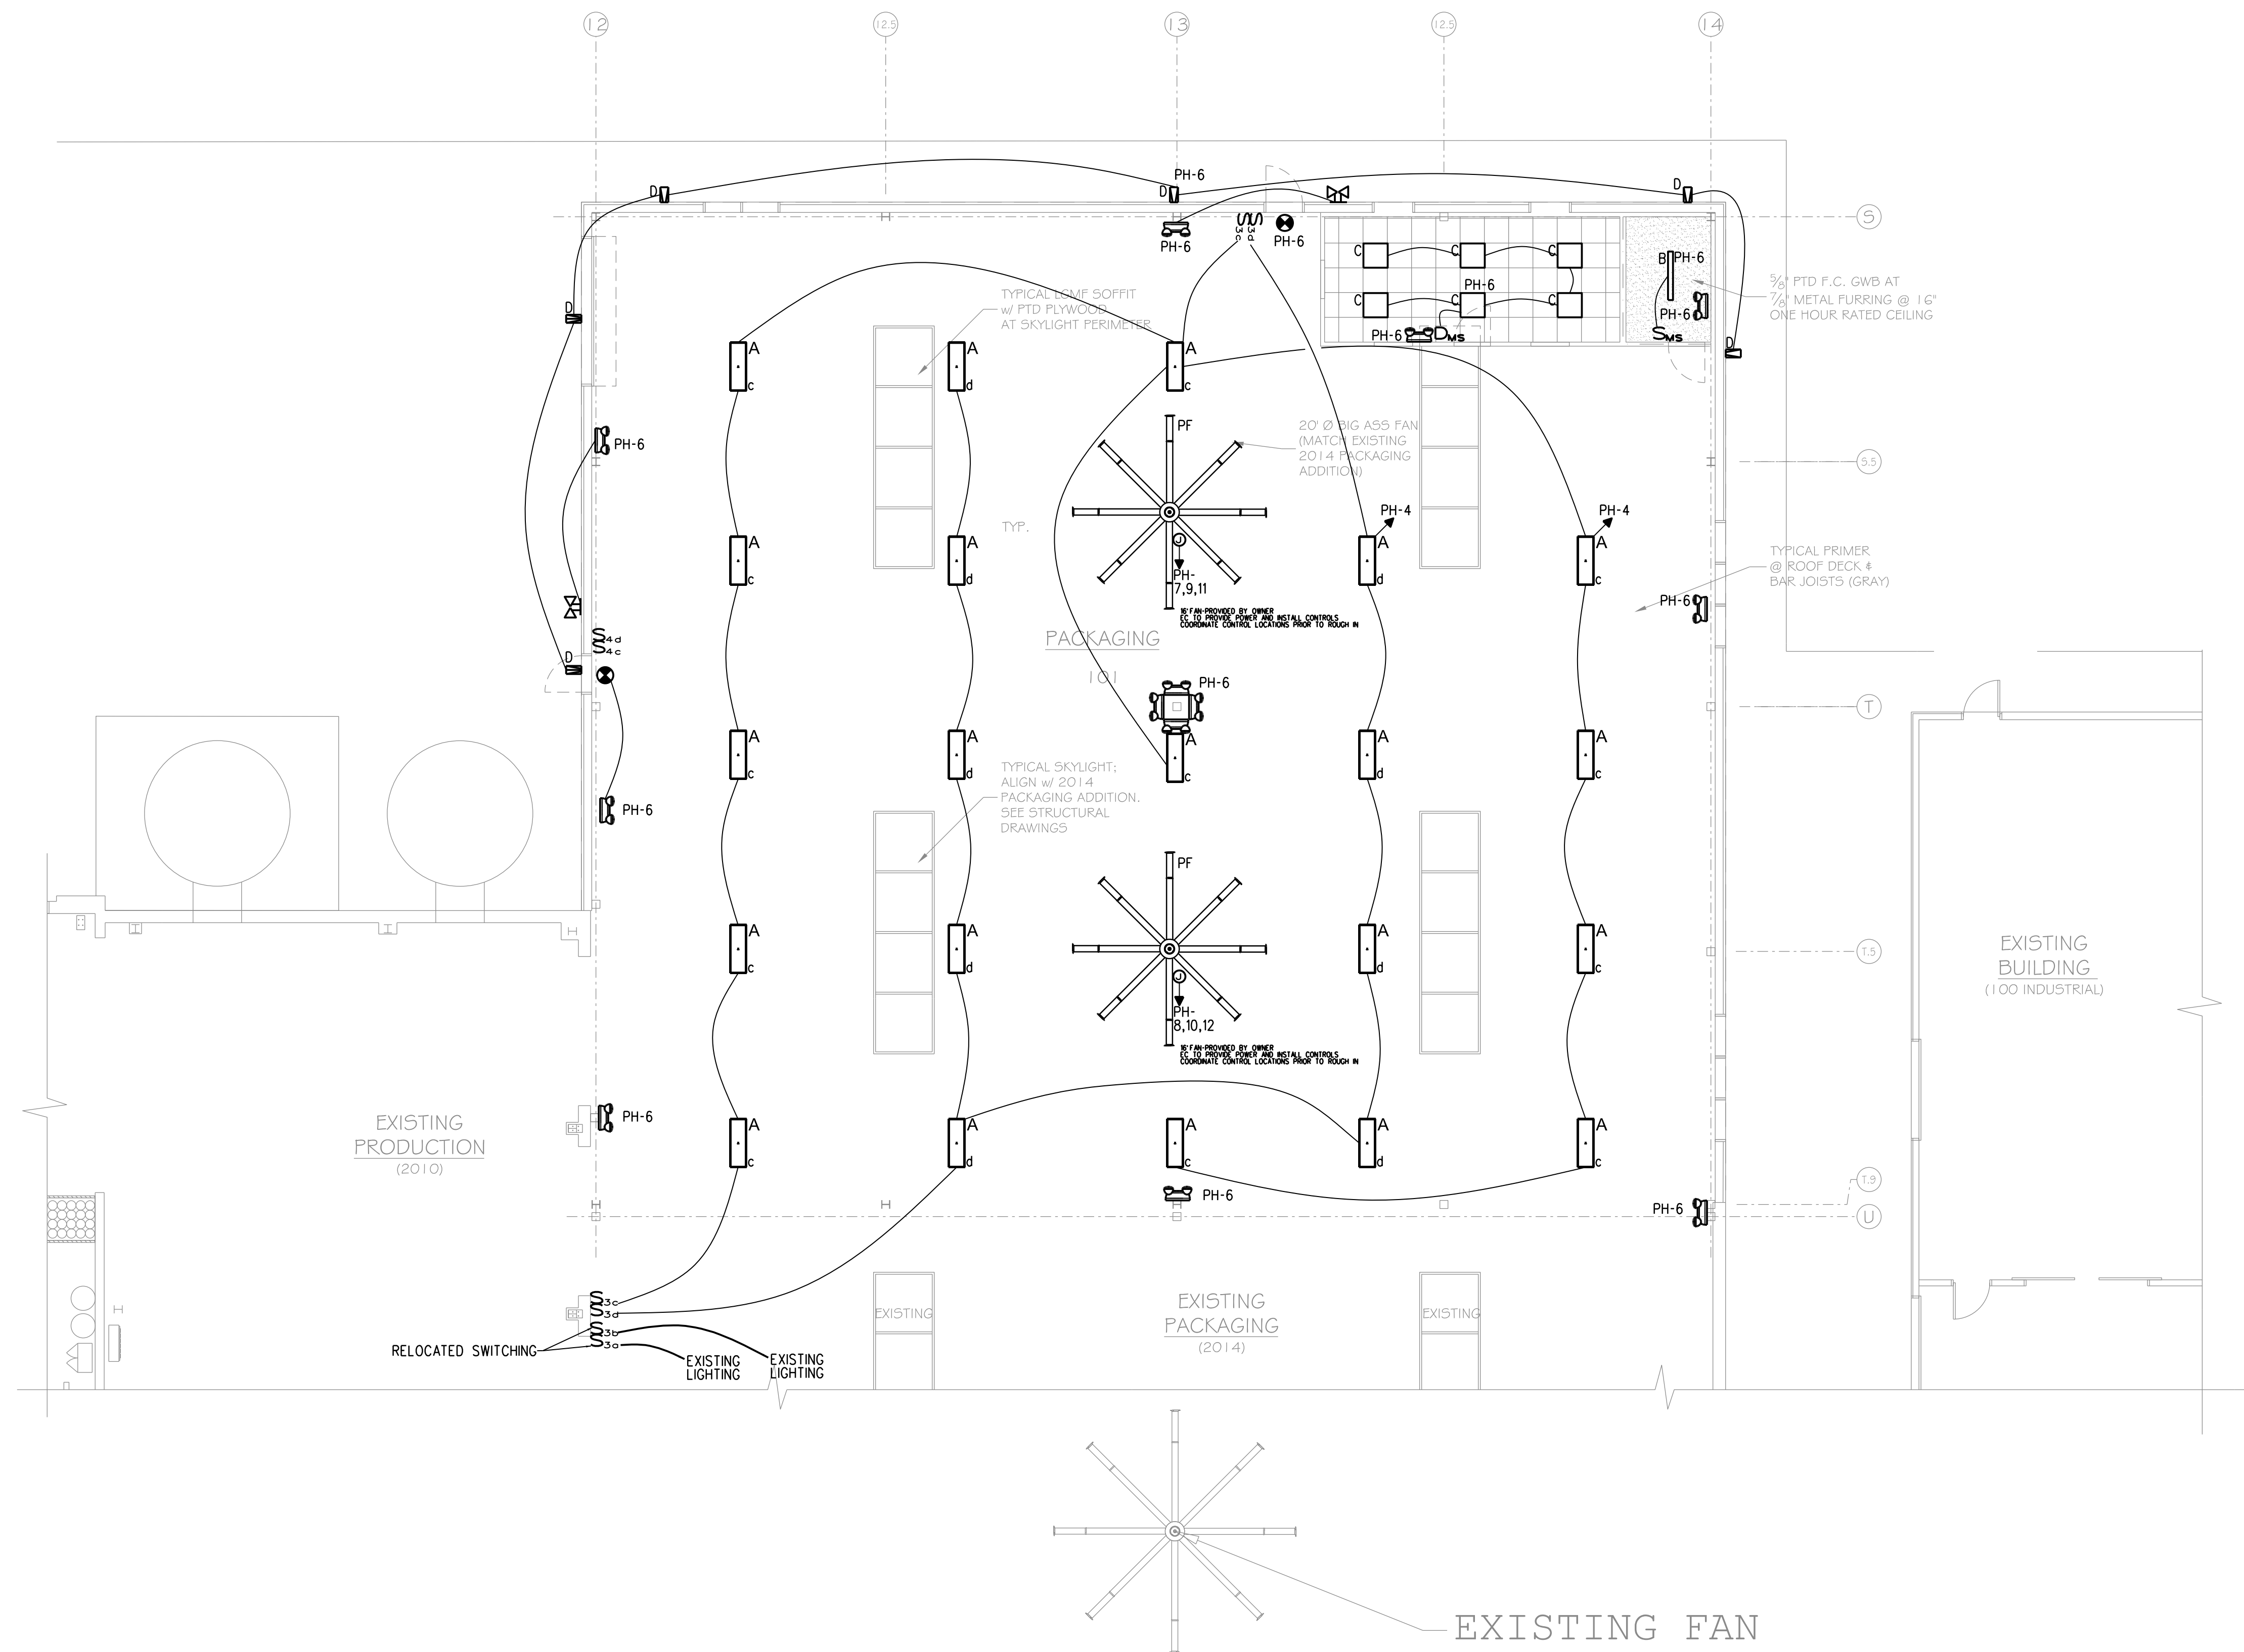

**ADDITION LIGHTING PLAN**  
SCALE: 1/8" = 1'-0"

