

GENERAL NOTES

- NOT ALL SYMBOLS INDICATED IN THE LEGEND APPEAR ON THE DRAWINGS. COORDINATE WORK ACCORDINGLY. COMPLY WITH SPECIFICATIONS AND NOTES BELOW AS APPLICABLE.
- ALL RECEPTACLES SHALL BE INSTALLED 18" AFF TO CENTERLINE OF BOX UNLESS NOTED OTHERWISE.
- MOUNT PANELS IN RESIDENTIAL SPACES SO NO CIRCUIT BREAKER HANDLE IS HIGHER THAN 44" AFF.
- ALL WIRING SHALL BE COPPER UNLESS DESIGNATED AS "AL". UNLESS OTHERWISE NOTED ALL WIRING SHALL BE 2*12 AWG AND 1*12 EQUIPMENT GROUNDING CONDUCTOR. HOMERUNS FED FROM A 20A-1P, 120V CIRCUIT IN EXCESS OF 70' SHALL BE *10 AWG.
- CONNECT BATTERY BACKED EMERGENCY AND EXIT LIGHTING TO NEAREST LIGHTING CIRCUIT AHEAD OF ANY SWITCHING. CONNECT REMOTE HEADS WITH *10 AWG COPPER CONDUCTORS. AC EXIT FIXTURES SHALL BE CONNECTED TO NEAREST EMERGENCY CIRCUIT OR AS INDICATED.
- TEST ALL EMERGENCY LIGHTING UNITS FOR PROPER OPERATION OF LAMPS AND BATTERIES.
- SEE MECHANICAL PLAN FOR HVAC UNITS, PUMPS AND FANS CONTROLLED BY THERMOSTATS (PROVIDED BY ATC CONTRACTOR).
- FUSES AND OVERLOAD UNITS FOR MOTORS SHALL BE SIZED BASED ON ACTUAL MOTOR NAMEPLATE DATA AND IN ACCORDANCE WITH NEC. CIRCUIT BREAKERS FOR MOTORS ARE SUPPLIED AT MAX VALUE PER NEC (2.5 x FLA). SIZE IN THE FIELD IN ACCORDANCE WITH MFCR RECOMMENDATION.
- ALL WORK SHALL COMPLY WITH NFPA70, NFPA72, NFPA101 & ALL FEDERAL, STATE & LOCAL REGULATIONS.
- ALL PENETRATIONS THROUGH FLOORS, RATED WALLS AND PARTITIONS SHALL BE SEALED WITH UL APPROVED FIRE SEALANT MATERIAL TO MAINTAIN FIRE RATING FOR THE SEPARATION.
- ALL ENCLOSURES, CONDUIT BODIES AND THEIR COVERS CONTAINING FIRE ALARM SYSTEM CONDUCTORS SHALL BE PAINTED RED.
- AN EQUIPMENT GROUNDING CONDUCTOR SHALL BE INSTALLED WITH ALL FEEDERS AND BRANCH CIRCUITS. SIZE IN ACCORDANCE WITH NFPA 70 ARTICLE 250.
- PROVIDE TWO BALLASTS FOR EACH FIXTURE INDICATED AS REQUIRING DUAL LEVEL SWITCHING. ONE BALLAST TO CONTROL OUTER LAMPS AND THE SECOND BALLAST TO CONTROL INNER LAMPS).
- COORDINATE INSTALLATION OF VOICE/DATA OUTLETS WITH OWNER, MS OR COMMUNICATIONS CONTRACTOR.
- LOCATE DISCONNECTS AT EQUIPMENT AS REQUIRED BY MANUFACTURER. LOCATIONS ON DRAWINGS ARE APPROXIMATE.
- OPERATE ALL FLUORESCENT AND METAL HALIDE LAMPS FROM INITIAL INSTALLATION FOR 100 HOURS AT FULL OUTPUT (NO DIMMING) TO SEASON LAMPS AND STABILIZE LAMP COLOR.
- PROVIDE RISER OR PLENUM RATED CABLES ABOVE SUSPENDED CEILINGS.
- THE CONTRACTOR SHALL SET ALL ELECTRONIC BREAKERS TO SPECIFIED TRIP SETTINGS BEFORE ENERGIZING EQUIPMENT.
- PROVIDE EXPANSION FITTINGS FOR ALL UNDERGROUND RACEWAYS ENTERING ENCLOSURES ATTACHED TO FIXED STRUCTURES.
- OUTDOOR RECEPTACLE COVERS SHALL COMPLY WITH NFPA 70 - ARTICLE 406.9.
- ALL CONDUCTOR INSULATION FOR BUILDING WIRE SHALL BE THWN/THHN UNLESS NOTED OTHERWISE.
- PROVIDE LABEL ON SERVICE EQUIPMENT INDICATING AVAILABLE SHORT CIRCUIT CURRENT OBTAIN VALUES FROM ENGINEER.
- PROVIDE ARC FAULT LABELS PER NFPA 70-ARTICLE 110.24
- IF BUILDING REQUIRES TWO SERVICE ENTRANCES, PROVIDE SIGNS PER NFPA 70-230.
- OUTLETS INSTALLED IN FIRE RATED WALLS BACK TO BACK SHALL BE SEPARATED BY 24" MINIMUM OR BE PROTECTED WITH "PUTTY PADS" PER 2009 INTERNATIONAL BUILDING CODE SECTION 713.3.2
- PROVIDE AIR VAPOR BARRIER BOXES FOR WIRING DEVICES IN EXTERIOR WALLS AND INTERIOR SOUND CONTROL WALLS BETWEEN RESIDENT ROOMS. INSTALL PER MANUFACTURER'S INSTRUCTIONS. PROVIDE LESSCO MODEL NUMBER: VAPORBOX
- MINIMUM WIRE SIZE ON ALL BRANCH CIRCUITS SHALL BE *12.
- PROVIDE SIGN AT SERVICE ENTRANCE EQUIPMENT INDICATING TYPE AND LOCATION OF EMERGENCY GENERATOR PER NEC 700.7.

ABBREVIATIONS


- | | | | |
|-------|---|--------|--|
| A | AMP | LTG | LIGHTING |
| AC | ALTERNATING CURRENT, ABOVE COUNTER | LSIG | LONG TIME, SHORT TIME, INSTANTANEOUS, GROUND FAULT CIRCUIT BREAKER TRIP FUNCTIONS AS INDICATED |
| ADA | AMERICANS WITH DISABILITIES ACT | MCC | MOTOR CONTROL CENTER |
| AF | AMP FRAME | MCCB | MOLDED CASE CIRCUIT BREAKER |
| AFCI | ARC FAULT CIRCUIT INTERRUPTER | MCB | MAIN CIRCUIT BREAKER |
| AFB | ABOVE FINISHED FLOOR | MCP | MAIN DISTRIBUTION PANEL |
| AFG | ABOVE FINISHED GRADE | MH | MANHOLE |
| AL | ALUMINUM | MIS | MANAGEMENT INFORMATION SYSTEM |
| AT | AMP TRIP | MLO | MAIN LUGS ONLY |
| ATC | AUTOMATIC TEMPERATURE CONTROL | MTS | MANUAL TRANSFER SWITCH |
| ATS | AUTOMATIC TRANSFER SWITCH | NC | NORMALLY CLOSED OF NURSE CALL |
| AWG | AMERICAN WIRE GAUGE | NEC | NATIONAL ELECTRICAL CODE |
| BLDG | BUILDING | NFPA | NATIONAL FIRE PROTECTION ASSOCIATION |
| C | CONDUIT | NL | NIGHT LIGHT |
| CB | CIRCUIT BREAKER | NO | NORMALLY OPEN |
| CI | CAST IRON | NO. | NUMBER |
| CKT | CIRCUIT | OL | OVERLOAD |
| CL | CENTERLINE | P | POLE |
| CMP | CENTRAL MAINE POWER (ELECTRIC UTILITY) | PA | PUBLIC ADDRESS |
| CMU | CONCRETE MASONRY UNIT | PB | PUSH BUTTON |
| CT | CURRENT TRANSFORMER | PF | POWER FACTOR |
| CONC | CONCRETE | PH | PHASE |
| CS | CARBON STEEL | PNL | PANEL |
| CU | COPPER | TPI-2 | TELE-POWER POLE - POLE AND CIRCUIT NUMBER AS INDICATED |
| CUH | CABINET UNIT HEATER | DLP | DAMP LOCATION |
| DL | DAMP LOCATION | PSNH | PUBLIC SERVICE OF NEW HAMPSHIRE (ELECTRIC UTILITY) |
| EC | ELECTRICAL CONTRACTOR | PT | POTENTIAL TRANSFORMER |
| EF | EXHAUST FAN | PVC | POLYVINYL CHLORIDE |
| ERL | EXISTING RELOCATE | RL | ELECTRICAL EQUIPMENT TO BE RELOCATED |
| ERV | EXISTING REMOVE | RM | ELECTRICAL EQUIPMENT TO REMAIN |
| ETR | EXISTING TO REMAIN | RSC | RIGID STEEL CONDUIT |
| EUH | ELECTRIC UNIT HEATER | RTU | ROOF TOP UNIT |
| EWC | ELECTRICAL WATER COOLER | RV | ELECTRICAL EQUIPMENT TO REMOVE |
| FACP | FIRE ALARM CONTROL PANEL | RVNR | REDUCED VOLTAGE, NON-REVERSING |
| FAPS | FIRE ALARM PULL STATION | SB | SMART BOARD |
| FRP | FIBER REINFORCED PLASTIC | SF | SUPPLY FAN |
| FVNR | FULL VOLTAGE, NON-REVERSING FURNISHED WITH UNIT | SLO | SINGLE LINE DIAGRAM |
| FWU | FURNISHED WITH UNIT | SM | MANUAL MOTOR STARTER SWITCH WITH THERMAL OVERLOAD DEVICE, MOUNTED AT UNIT |
| DC | DIRECT CURRENT | SS | SOLID STATE |
| GF1 | GROUND FAULT INTERRUPTER | SWBD-1 | SWITCHBOARD NUMBER AS DESIGNATED |
| GND | GROUND | TC | TIME CLOCK |
| HD | HIGH INTENSITY DISCHARGE | TS | TRANSFER SWITCH |
| HOA | HAND-OFF-AUTOMATIC | T&B | TOP AND BOTTOM |
| HP | HORSEPOWER | TYP | TYPICAL |
| HPS | HIGH PRESSURE SODIUM | UG | UNDERGROUND |
| HZ | HERTZ | V | VOLT |
| ICB | INSULATED CASE CIRCUIT BREAKER | VA | VOLT-AMPERE |
| JB | JUNCTION BOX | VFD | VARIABLE FREQUENCY DRIVE |
| KAIC | THOUSAND AMP INTERRUPTING CAPACITY | W | WATT |
| KCMIL | THOUSAND CIRCULAR MIL | W/ | WITH |
| KV | THOUSAND VOLTS | WP | WEATHERPROOF |
| KVA | THOUSAND VOLT-AMPS | XFMR | TRANSFORMER |
| KW | THOUSAND WATTS (KILOWATT) | XP | EXPLOSION PROOF |
| LC | LIGHTING CONTACTORS | 3PH | THREE PHASE |
| LCP | LIGHTING CONTROL PANEL | 4W | FOUR WIRE |
| LED | LIGHT EMITTING DIODE | 3W | THREE WIRE |
| LP | LIGHTING PANELBOARD | | |

SYMBOL LEGEND

- SURFACE MOUNTED POWER PANEL, SEE PANEL SCHEDULES FOR RATING
- RECESSED MOUNTED POWER PANEL, SEE PANEL SCHEDULES FOR RATING
- ELECTRIC MOTOR DRIVEN EQUIPMENT, HP SHOWN
- H, DS, DW @ JUNCTION BOX, "H" DENOTES RANGE HOOD, "DS" DENOTES DISPOSAL UNIT, "DW" DENOTES DISHWASHER
- SM MANUAL MOTOR STARTER SWITCH WITH THERMAL OVERLOAD DEVICE MOUNTED AT UNIT
- DISCONNECT SWITCH, SIZE AND NUMBER OF POLES AS INDICATED ON DRAWING. PROVIDED BY EC UNLESS NOTED OTHERWISE. PROVIDE FUSES WHERE RECOMMENDED BY MANUFACTURER.
- COMBINATION MOTOR STARTER/ DISCONNECT SWITCH WITH AUXILIARY CONTACTS AND HAND-OFF-AUTO SWITCH AND RED RUN LIGHT. PROVIDED AND INSTALLED BY EC UNLESS NOTED OTHERWISE.
- VARIABLE FREQUENCY DRIVE, PROVIDED BY MC, INSTALLED AND WIRED BY EC
- DUPLEX RECEPTACLE, 20A, 125V SPEC GRADE GROUNDING TYPE, TAMPER PROOF AND MATCHING PLATE, MOUNT 18" AFF UNLESS NOTED OTHERWISE.
- QUAD RECEPTACLE, 20A, 125V SPEC GRADE GROUNDING TYPE, TAMPER PROOF AND MATCHING PLATE, MOUNT 18" AFF UNLESS NOTED OTHERWISE.
- DUPLEX RECEPTACLE, 20A, 125V SPEC GRADE GROUNDING TYPE, TAMPER PROOF AND MATCHING PLATE, MOUNT 18" AFF, BOTTOM RECEPTACLE SWITCHED.
- GROUND FAULT DUPLEX RECEPTACLE, 20A, 125V, TAMPER PROOF WITH MATCHING PLATE FURNISHED W/ OUTLET. FLUSH MOUNTED 45" AFF UNLESS OTHERWISE NOTED.
- REFRIGERATOR DUPLEX RECEPTACLE, 20A, 125V SPEC GRADE GROUNDING TYPE, TAMPER PROOF AND MATCHING PLATE, MOUNT RECEPTACLE AT 48" AFF.
- DUPLEX RECEPTACLE, 20A, 125V SPEC GRADE GROUNDING TYPE, TAMPER PROOF WITH (2) USB CHARGING PORTS, COLOR BY ARCH. MOUNT 18" AFF UNLESS NOTED OTHERWISE.
- FLUSH FLOOR MOUNTED DUPLEX RECEPTACLE - 20A, 125V SPEC GRADE GROUNDING TYPE. "CL" DENOTES CEILING MOUNTED
- RANGE OUTLET 50 AMP, 250 VOLT, GROUNDING TYPE FLUSH MOUNTED 18" AFF
- DRYER OUTLET 30 AMP, 250 VOLT, GROUNDING TYPE FLUSH MOUNTED 18" AFF
- RACEWAY & WIRING OR MC CABLE RUN CONCEALED IN WALLS/CEILING
- RACEWAY & WIRING RUN EXPOSED
- RACEWAY & WIRING RUN CONCEALED UNDER FLOOR OR BURIED 30" BELOW FINISH GRADE HOME RUN TO PANEL, WITH HOME RUN TO PANEL, WITH PANEL AND CIRCUIT NUMBER
- BRANCH CIRCUIT WIRING SHALL CONSIST OF (1)1/2"C-2*12AWG-1*12GND UNLESS OTHERWISE NOTED. (+)ASTERISK DENOTES *10AWG FOR ALL CIRCUITS CONTAINED IN HOME RUN. (+)DOUBLE ASTERISK DENOTES (1)3/4"C-2*8AWG-1*10GND.
- PROVIDE EQUIPMENT GROUNDS IN ACCORDANCE WITH NFPA 70, ARTICLE 250.
- CABLE TV JUNCTION BOX "CTV", SIZE AS REQUIRED BY CABLE UTILITY
- TV OUTLET LOCATION, CABLE AND JACKS BY EC
- TEMPERATURE CONTROL PANEL, PROVIDED BY MC WIRED BY EC
- PUSHBUTTON FOR ELECTRICALLY OPERATED DOOR, FURN W/ DOOR OPERATOR, WIRED BY EC
- DOOR PUSHBUTTON-DOORBELL
- DOOR ELECTRIC STRIKE
- DOOR CHIME WITH STROBE-ADA COMMUNICATIONS REQUIREMENT
- LIGHTING FIXTURES, CAPITAL LETTERS DENOTE TYPE PER LIGHTING FIXTURE SCHEDULE. LOWER CASE LETTERS INDICATE SWITCH CONTROL. "ob" INDICATES INBOARD LAMPS CONTROLLED BY OUTBOARD SWITCHED "o" AND "b". DIAGONAL OR "NL" INDICATES NIGHT LIGHT (UNSWITCHED)
- SELF CONTAINED EMERGENCY LIGHT W/2 HEADS DUAL-LITE (LED) MODEL LZ25NI-03L, 25 WATTS FOR 90 MINUTES, COLOR BY ARCHITECT
- EMERGENCY LIGHTING BATTERY PACK DUAL-LITE No LM130-12V1-0 SELF-DIAGNOSTIC
- INTERIOR REMOTE HEAD DUAL-LITE (LED) MODEL No CPDR 1203L, COLOR BY ARCHITECT
- EXTERIOR REMOTE HEAD DUAL-LITE (LED) MODEL No OCRD 1203L COLOR BY ARCHITECT
- EXIT LIGHT FIXTURE, UNSWITCHED, DUAL-LITE LX-U-R-W-E OR APPROVED EQUAL
- EXIT/ EMERGENCY LIGHT COMBO, DUAL-LITE No EVCU-R-D4-10R APPROVED EQUAL COLOR BY ARCHITECT
- SECURITY CAMERA LOCATION, COORDINATE AND PROVIDE DUPLEX RECEPTACLE, DATA AND CONDUIT PER MANUFACTURERS RECOMMENDATIONS
- CEILING MOUNTED MOTION SENSOR (WATTSTOPPER OR EQUAL) CORRIDORS: WT-2255 SENSOR & B120E-P POWER PACK. OTHER COMMON SPACES: WT-605 SENSOR & B120E-P POWER PACK. SENSORS AND RELAYS TO CONTROL CIRCUITS IN SPACES INDICATED. DEVICES SHALL PROVIDE FULL COVERAGE IN AREAS INSTALLED. DT INDICATES DUAL TECHNOLOGY PIR INDICATES PASSIVE INFRARED TECHNOLOGY
- WALL MOUNTED SWITCH MOTION SENSOR. MOUNT AT 48" AFF UNLESS OTHERWISE NOTED
- SINGLE POLE SWITCH, 120V, 20A, SPEC GRADE, GROUNDING TYPE, MOUNT 48" AFF, 3-3-WAY, 4-4-WAY, LOWER CASE LETTER INDICATES FIXTURE OR CONTROLLED LOAD.
- SWITCH WITH PILOT LIGHT, SWITCH SHALL BE PROVIDED W/ ENGRAVED NAMEPLATE IDENTIFYING USE
- REMOTE RANGE HOOD FAN SWITCH, CONNECT TO HOOD FAN THRU HOOD JUNCTION BOX.
- REMOTE RANGE HOOD LIGHT SWITCH, CONNECT TO HOOD LIGHT THRU JUNCTION BOX.
- BURNER SAFETY SWITCH, PROVIDE WITH RED PLATE, MOUNTED 72" AFF
- SINGLE POLE DIMMER SWITCH, 120V, 20A, SPEC GRADE, GROUNDING TYPE, MOUNT 48" AFF, 3-3-WAY, 4-4-WAY, LOWER CASE LETTER INDICATES FIXTURE OR CONTROLLED LOAD.
- PHOTOCELL
- LIGHTING CONTACTOR
- TIMECLOCK
- TELEPHONE/DATA DUAL JACK, MOUNT 18" AFF, RUN TWO CABLES BACK TO TBB. SEE SPECIFICATIONS FOR FURTHER INFORMATION
- DATA JACK, RUN TWO CABLES BACK TO TBB. SEE SPECIFICATIONS FOR FURTHER INFO
- FLUSH FLOOR MOUNTED TELEPHONE/DATA DUAL JACK, RUN TWO CABLES BACK TO TBB. "CL" DENOTES CEILING MOUNTED
- TELEPHONE JACK, MOUNT 18" AFF UNLESS NOTED OTHERWISE, RUN ONE CABLE BACK TO TBB.
- TELEPHONE BACK BOARD
- WiFiROUTER, RUN CABLE BACK TO TBB OR IT ROOM. MOUNT ABOVE CEILING, "W" DENOTES WALL MOUNTED AT 72" AFF
- INTERCOM PANEL IN UNIT
- INTERCOM PANEL AT RECEPTION
- CARD READER LOCATION: PROVIDE BOX AND 3/4" CONDUIT TO NEAREST LOCATION ABOVE SUSPENDED CEILING. PROVIDE 120V DOOR STRIKE POWER FROM NEAREST RECEPTACLE CIRCUIT.
- FIRE ALARM CONTROL PANEL WITH DEDICATED TELEPHONE JACK
- FIRE ALARM ANNUNCIATOR PANEL
- FIRE ALARM BOOSTER PANEL
- FIRE EXTINGUISHER ELECTRONIC MONITOR-SHALL BE ACCOMPLISHED THROUGH USE OF AN ADDRESSABLE INTERFACE DEVICE AND SHALL PROVIDE INPUT TO THE FACP
- FIRE ALARM AUDIO/VISUAL, MOUNT 6'-8" AFF, NUMBER DENOTES CANDELA RATING. "MH" DENOTES MINIHORN, "CL" DENOTES CEILING MOUNTED. NO DESIGNATION EQUALS 15cd
- FIRE ALARM PULL STATION, MOUNT 48" AFF
- FIRE ALARM VISUAL STROBE ONLY, FLUSH MOUNT 6'-8" AFF, NUMBER DENOTES CANDELA RATINGS. "CL" DENOTES CEILING MOUNTED
- SYSTEM CONNECTED SMOKE / CARBON MONOXIDE DETECTOR, PHOTOELECTRIC TYPE
- SYSTEM CONNECTED FIXED TEMPERATURE HEAT DETECTOR
- SMOKE DETECTOR, PHOTOELECTRIC TYPE, SYSTEM CONNECTED.
- SMOKE DETECTOR, PHOTOELECTRIC TYPE, SYSTEM CONNECTED. "ER" DENOTES ELEVATOR RECALL
- SYSTEM CONNECTED SMOKE DETECTOR, PHOTOELECTRIC TYPE, WITH SOUNDER BASE
- CARBON MONOXIDE DETECTOR
- DUCT SMOKE DETECTOR & TEST STATION
- FIRE/SMOKE DAMPER, SUPPLIED AND INSTALLED BY MECHANICAL CONTRACTOR. ELECTRICAL CONTRACTOR TO PROVIDE ALL WIRING CONNECTIONS AND FIRE ALARM DUCT SMOKE DETECTORS, ADDRESSABLE MODULES AND PROGRAMMING.
- SPRINKLER SYSTEM FLOW SWITCH } SUPPLIED BY SPRINKLER CONTRACTOR
- SPRINKLER SYSTEM TAMPER SWITCH } SPRINKLER CONTRACTOR.
- MAGNETIC DOOR HOLD
- NURSE CALL BASE STATION
- NURSE CALL PULL STATION
- NURSE CALL ANNUNCIATOR LIGHT
- WP DENOTES WEATHERPROOF CONSTRUCTION
- RP DENOTES EXISTING ELECTRICAL EQUIPMENT TO BE REPLACED
- RM OR ETR DENOTES EXISTING ELECTRICAL EQUIPMENT TO REMAIN
- RL DENOTES EXISTING ELECTRICAL EQUIPMENT TO BE RELOCATED
- RV DENOTES EXISTING ELECTRICAL EQUIPMENT TO BE REMOVED

LIGHT FIXTURE SCHEDULE


TYPE	MANUFACTURER AND MODEL NUMBER	LAMP INFO	REMARKS
A	BIG ASS LIGHTING BAS-HBL3-20050103 5K, WL	137W, LED, 18,530 LUMENS	USED IN PRODUCTION AREA SUPPLIED BY OWNER-277V
B	COLUMBIA LIGHTING No LRO4-35-ML-EU-GLR	53W LED, 5000 LUMENS	GENERAL USE 4' LENSED STRIP LED, SURFACE MOUNT-277V
C	COLUMBIA LIGHTING No LEPC22-35MLG-LL-EDU-GLR	30W LED, 3407 LUMENS	GRID MOUNTED 2x2 OFFICE AREAS-277V
D	HUBBELL BEACON VIPER VPS/36NB-80/5K/T2/UNV/PCR-TL/WB/xx	80W LED, 8505 LUMENS	WALL MOUNTED EXTERIOR BUILDING LIGHTING. SEE ARCH PLANS FOR MOUNTING HEIGHT. VERIFY WITH OWNER THE FINISH PRIOR TO ORDERING.
PF	BIG ASS POWERFOIL X3.0 PLUS-PFX3-16	480VAC, 60HZ, 3PH, 10A	16' CEILING FANS AND CONTROLS PROVIDED BY THE OWNER, INSTALLED AND WIRED BY THE ELECTRICAL CONTRACTOR.

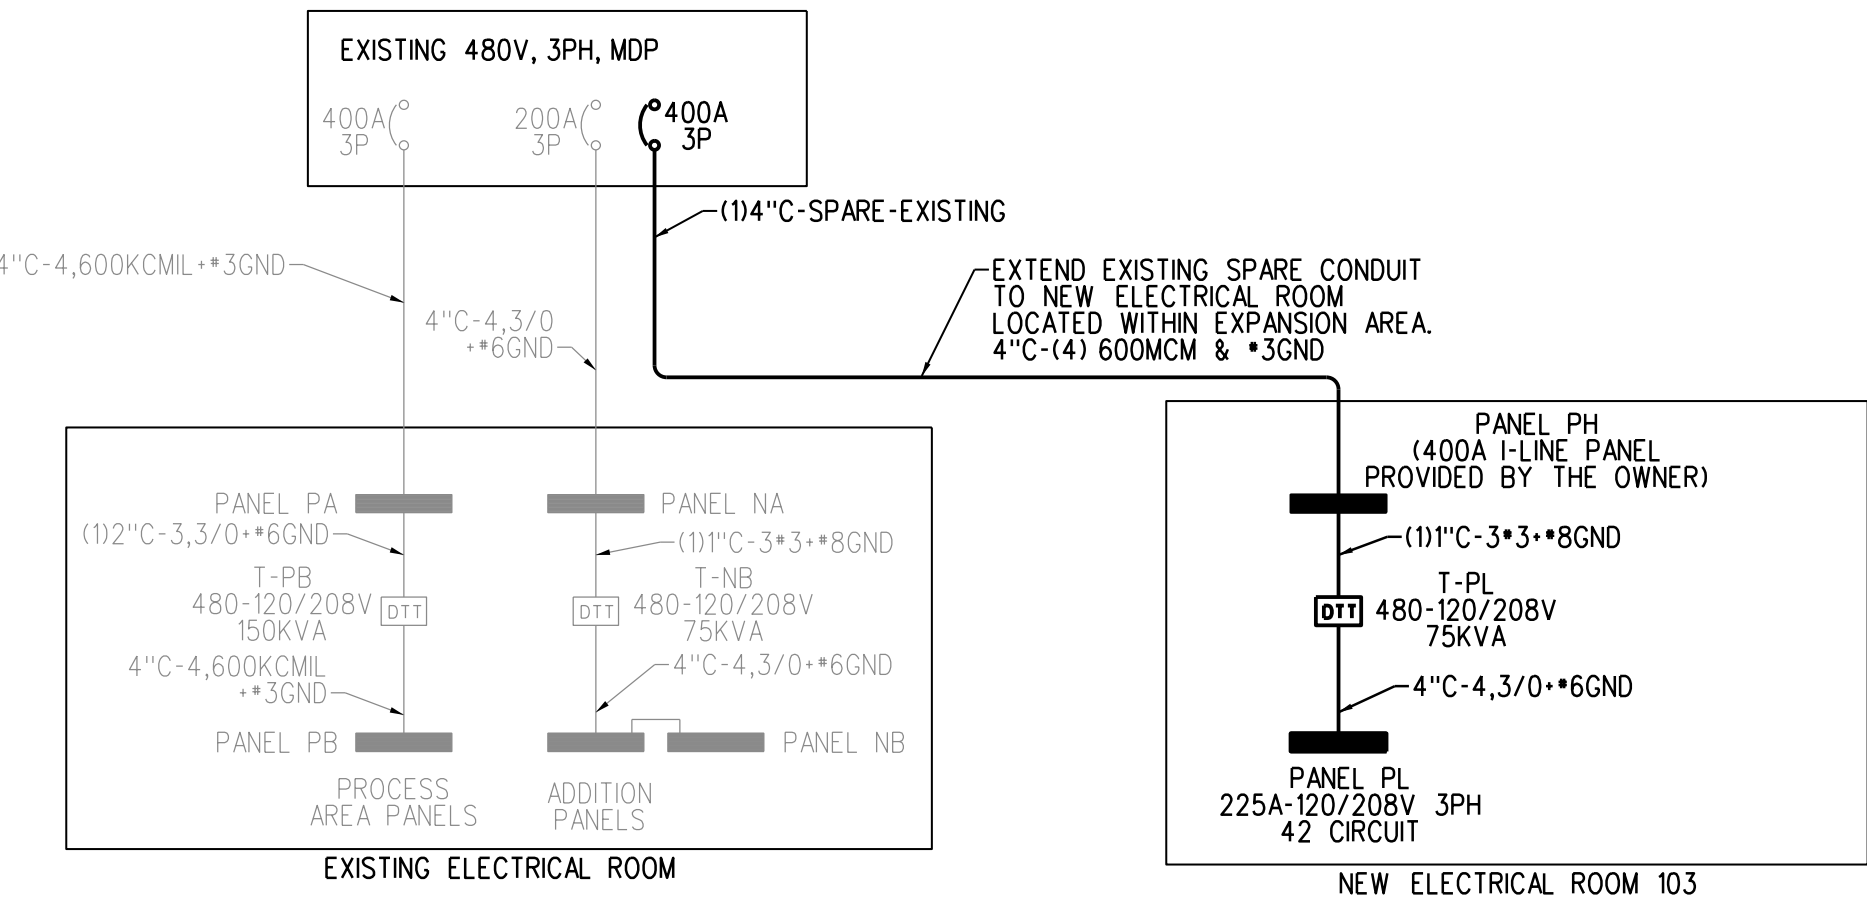

ONE-LINE
NOT TO SCALE



ARCHITECTURE & INTERIOR DESIGN
P.O. BOX 6179 FALMOUTH MAINE 04103
207.871.5900 www.granthays.com

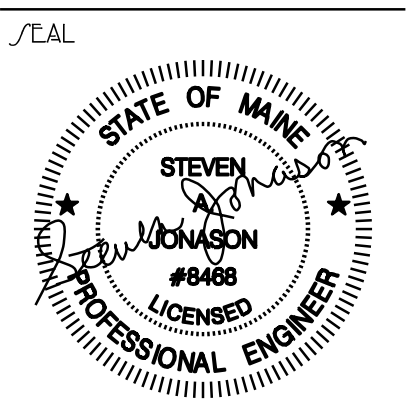

REVISION
PRICING SET
NOT FOR
CONSTRUCTION

DRAWING NAME
2018 PACKAGING ADDITION
ALLAGASH
BREWING COMPANY
50 INDUSTRIAL WAY
PORTLAND, MAINE 04103
PROJECT# 18-005

ELECTRICAL NOTES,
LEGEND AND
LIGHTING FIXTURE
SCHEDULE

DATE: 4 APRIL 2018
SCALE: 1/8"=1'-0"
DRAWN: PMC/SAJ
JOB NO.: 180112
SHEET: E-3

COPYRIGHT
REPRODUCTION OR REVUE OF THIS
DOCUMENT WITHOUT WRITTEN
PERMISSION FROM GRANT HAYS/
ASSOCIATES IS PROHIBITED.