


ELECTRICAL DEMOLITION NOTES

- ① RELOCATE EXISTING LIGHT SWITCHES. SEE LIGHTING PLAN E-1 FOR NEW LOCATIONS.
- ② REMOVE AND RELOCATE EXISTING EMERGENCY EXIT SIGNS. SEE LIGHTING PLAN E-1 FOR NEW LOCATIONS.
- ③ REMOVE AND RELOCATE EXISTING EMERGENCY EGRESS LIGHTING. SEE LIGHTING PLAN E-1 FOR NEW LOCATIONS.
- ④ REMOVE AND RELOCATE EXISTING FIRE ALARM DEVICES. SEE POWER PLAN E-2 FOR NEW LOCATIONS.

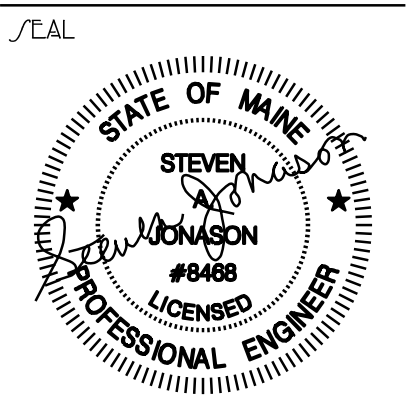

REVISION

PRICING SET
NOT FOR
CONSTRUCTION

DRAWING NAME

2018 PACKAGING ADDITION
ALLAGASH
BREWING COMPANY
50 INDUSTRIAL WAY
PORTLAND, MAINE 04103
PROJECT # 18-005


SHEET

ELECTRICAL
DEMO PLAN

DATE
4 APRIL 2018
SCALE
1/8" = 1'-0"
DRAWN BY
PMC/SAJ
JOB NO.
180112

SHEET
ED-2

COPYRIGHT
REPRODUCTION OR REVUE OF THIS
DOCUMENT WITHOUT WRITTEN
PERMISSION FROM GRANT HAYS
ASSOCIATES IS PROHIBITED.

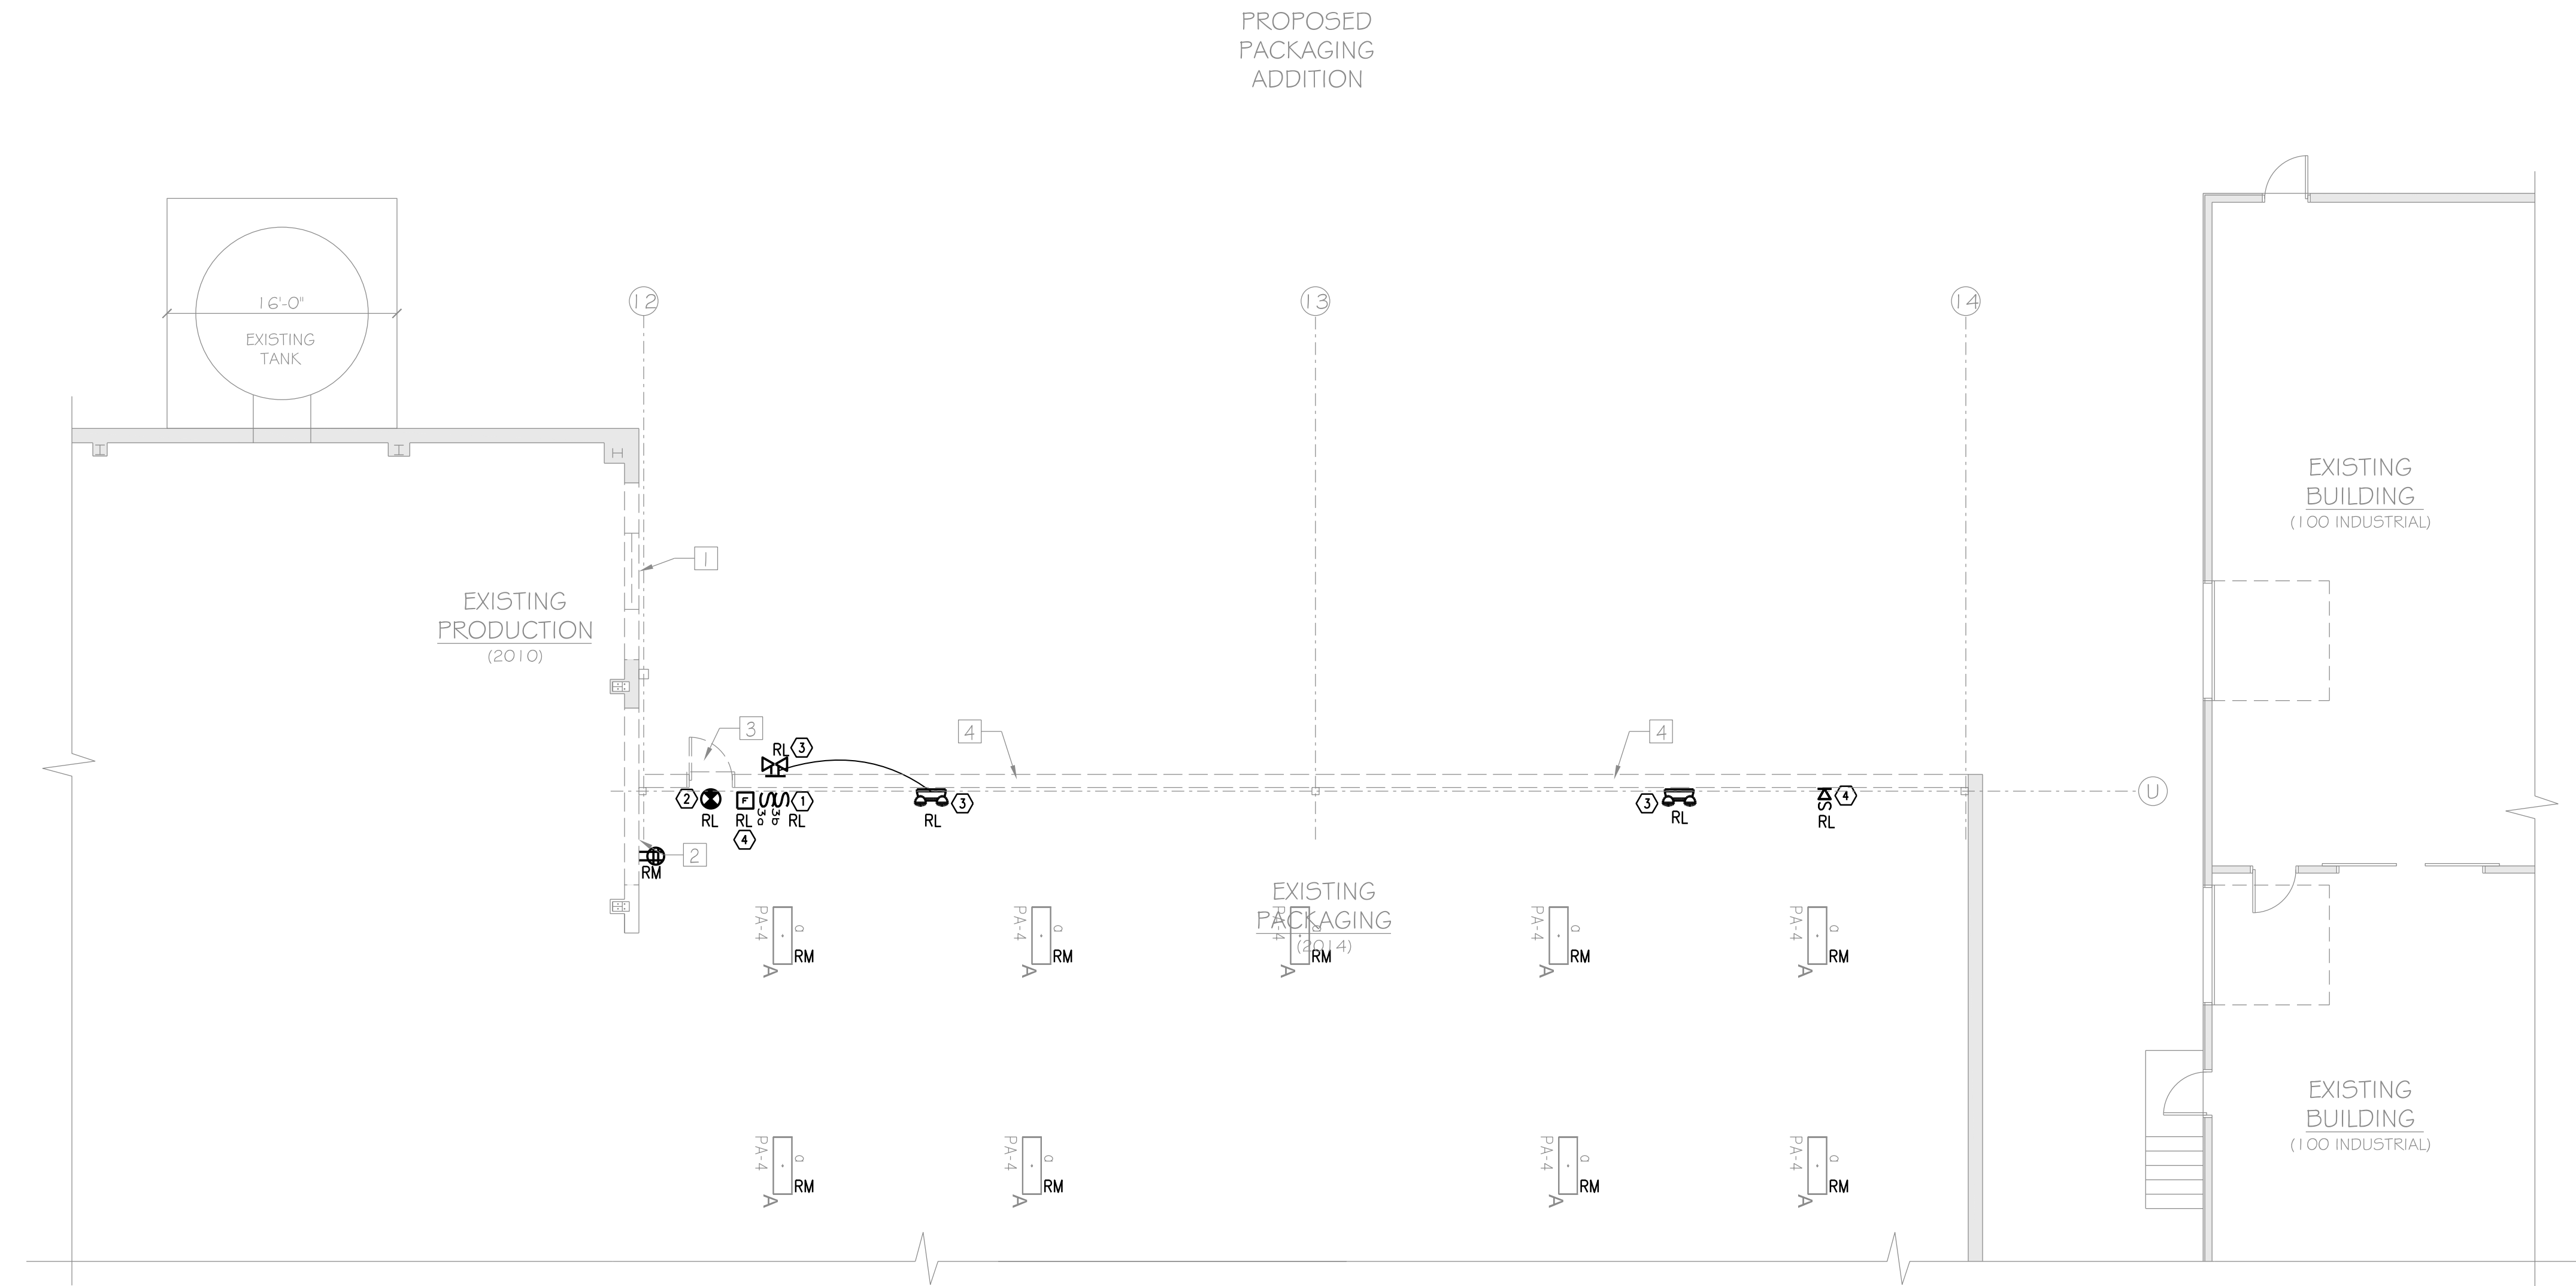

ELECTRICAL DEMO PLAN

SCALE: 1/8" = 1'-0"



DEMOLITION NOTES

- 1 REMOVE EXISTING INTERIOR METAL WALL PANELS & WINDOW. SALVAGE WINDOW FOR REUSE AT NEW ADDITION. SEE STRUCTURAL DRAWINGS FOR ADDITIONAL DEMOLITION AT STEEL FRAMING & CONCRETE FOUNDATION.
- 2 REMOVE EXISTING METAL WALL PANELS. SEE STRUCTURAL DRAWINGS FOR ADDITIONAL DEMOLITION AT STEEL FRAMING & CONCRETE FOUNDATION.
- 3 REMOVE EXISTING DOOR & FRAME. SALVAGE FOR REUSE AT NEW ADDITION.
- 4 REMOVE EXISTING WALL PANELS AND ASSOCIATED CORNER / FASCIA TRIM. SALVAGE WALL PANELS FOR MODIFICATION & REUSE AT NEW ADDITION. SEE STRUCTURAL DRAWINGS FOR ADDITIONAL DEMOLITION AT STEEL FRAMING.