

DOOR SCHEDULE

ABBREVIATIONS

A	ALUMINUM	FR	FIRE RATED
GL	GLASS	HW	HEAVY WOOD
IN	INSULATED	HW	HEAVY WOOD
SP	SPRINKLER	HW	HEAVY WOOD



DOORS										FRAMES				THRESHOLDS			
NO.	TYPE	SIZE (W X H)	THK	INSUL	HW	FR	GLASS TYPE	GLASS SIZE	REMARKS	TYPE	FR	PROFILE	DETAILS HEAD	DETAILS JAMB	MATERIAL	DETAILS SILL	DETAILS FIN
101	A	6070 FR	1 3/4"	YES	HW1	NO	T/TH	FULL		A	NO	T-BREAK	4-A4.1	5-A5.1	ALUM	6-A4.1	-
102	A	6070 FR	1 3/4"	YES	HW1	NO	T/TH	FULL		A	NO	T-BREAK	4-A4.1	5-A5.1	ALUM	6-A4.1	-
103	A	3070	1 3/4"	YES	HW2	NO	T/TH	FULL		D	NO	T-BREAK	4-A4.1	5-A5.1	ALUM	6-A4.1	-
104	D	3070	1 3/4"	NO	HW3	1 HR	24X30			C	1 HR	DW	4-A4.1	4-A4.1	ALUM	2-A4.1	-
105	G	3070	1 3/4"	NO	HW4	NO	NONE	NONE	NOT USED	C	NO	DW	4-A4.1	4-A4.1	NONE	6-6NG	-
106	C	3070	1 3/4"	NO	HW5	NO	NONE	NONE		C	NO	DW	4-A4.1	4-A4.1	NONE	-	CGIC
107	C	3070	1 3/4"	NO	HW5	NO	NONE	NONE		C	NO	DW	4-A4.1	4-A4.1	NONE	-	CGIC
108	C	3070	1 3/4"	NO	HW5	1 HR	NONE	NONE	RELOCATED DOOR	C	1 HR	DW	4-A4.1	4-A4.1	NONE	-	CGIC
109	C	3070	1 3/4"	NO	HW5	NO	NONE	NONE		C	NO	DW	4-A4.1	4-A4.1	NONE	-	-
110	C	3070	1 3/4"	NO	HW5	1 HR	NONE	NONE		C	1 HR	DW	4-A4.1	4-A4.1	NONE	-	-
201	C	3070	1 3/4"	NO	HW6	1 HR	NONE	NONE		C	1 HR	DW	4-A4.1	4-A4.1	ALUM	2-A4.1	-
202	C	3070	1 3/4"	NO	HW7	NO	NONE	NONE		C	NO	DW	4-A4.1	4-A4.1	NONE	-	-
E/R	E	E	E	E	E	E	E	E	* SEE PLAN	E	E	E	E	E	E	E	E

HW-1 EXTERIOR PAIR DOORS		HW-5 INTERIOR SINGLE DOOR	
6	BUTTS	3	BUTTS
2	CLOSERS	1	CLOSER
2	EXIT DEVICES WITH EXTERIOR PULLS & CONCEALED ROPS	1	PUSH PLATE WITH FULL
2	THRESHOLD	2	FRAME SILENCERS
1	DOOR BOTTOMS		
1	WEATHERSTRIPPING JAMB/HEAD SET		

HW-2 EXTERIOR SINGLE DOOR		HW-6 INTERIOR SINGLE RATED DOOR	
3	BUTTS	3	BUTTS
1	CLOSERS	1	CLOSER
1	EXIT DEVICES WITH EXTERIOR PULL	1	LEVER LOCKSET - OFFICE FUNCTION
1	THRESHOLD	2	FRAME SILENCERS
1	DOOR BOTTOMS		
1	WEATHERSTRIPPING JAMB/HEAD SET		

HW-3 INTERIOR SINGLE RATED DOOR		HW-7 INTERIOR SINGLE DOOR	
3	BUTTS	3	BUTTS
1	CLOSERS	1	CLOSER
1	EXIT DEVICES WITH FULL	1	LEVER LOCKSET - OFFICE FUNCTION
1	THRESHOLD	2	FRAME SILENCERS
1	DOOR BOTTOMS	1	DOOR STOP
1	WEATHERSTRIPPING JAMB/HEAD SET		

HW-4 INTERIOR SINGLE DOOR		HW-8 INTERIOR SINGLE RATED DOOR	
3	BUTTS	3	BUTTS
1	LEVER LOCKSET - STORE ROOM FUNCTION	1	CLOSER
2	FRAME SILENCERS	1	LEVER LATCHSET - PASSAGE FUNCTION
		2	FRAME SILENCERS
		1	DOOR STOP

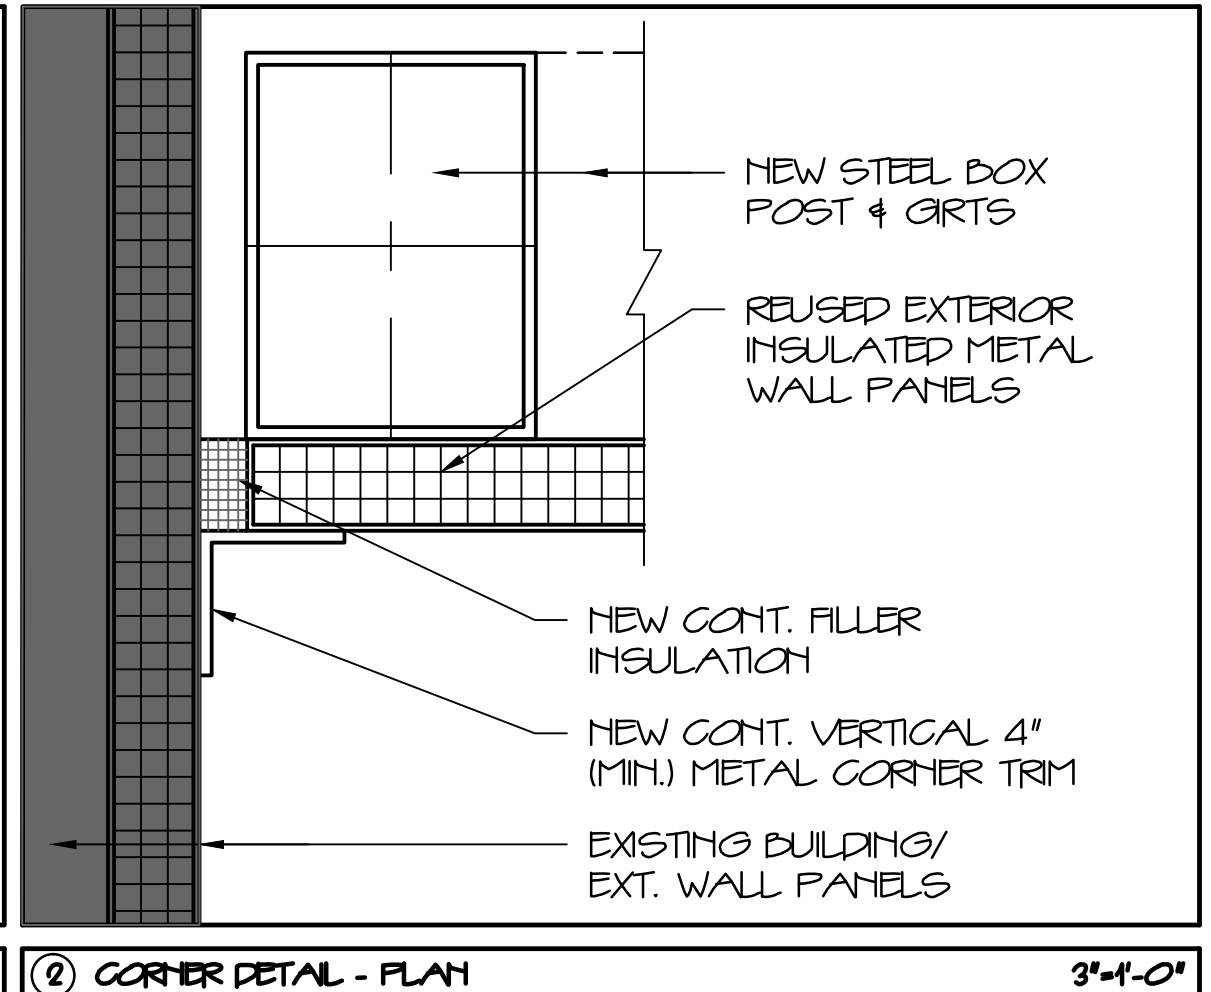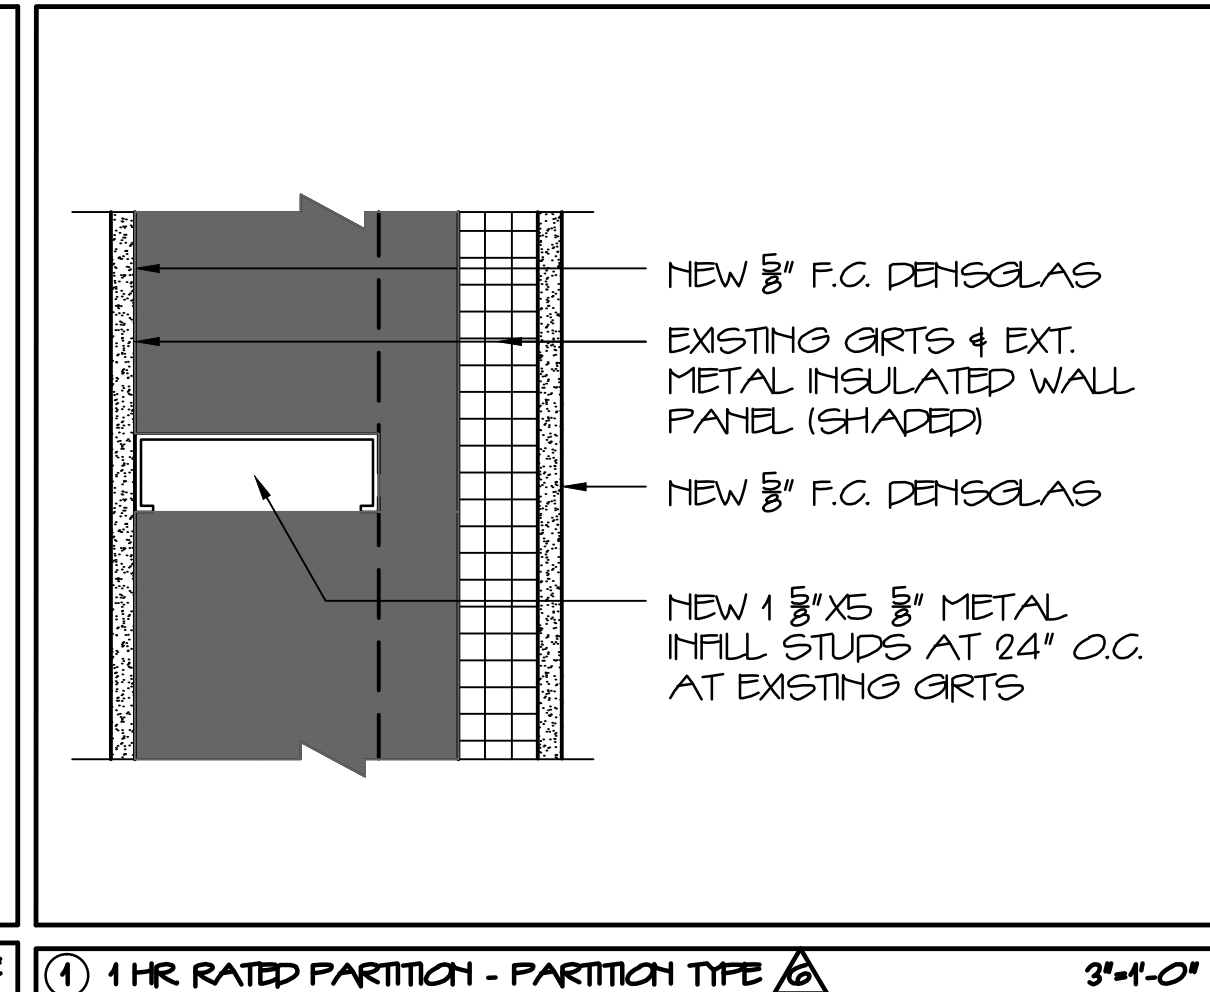

FIRE SUPPRESSION & LIFE SAFETY SYSTEM NOTES:


- THE ENTIRE BUILDING HAS AN EXISTING NFPA 13 FIRE SUPPRESSION SPRINKLER SYSTEM. THE EXISTING SPRINKLER SYSTEM SHALL BE MODIFIED BY A CERTIFIED SPRINKLER CONTRACTOR FOR THE PROPOSED PLANS AND SHALL BE REVIEWED AND APPROVED BY THE STATE AND LOCAL AUTHORITY HAVING JURADITION. THE CONTRACTOR SHALL BEAR SOLE RESPONSIBILITY FOR THE DESIGN AND INSTALLATION OF THE MODIFIED SYSTEM FOR OCCUPANCY.
- UPGRADE THE EXISTING FIRE ALARM SYSTEM AS REQUIRED FOR COMPLIANCE WITH NFPA 101 LIFE SAFETY CODE. COORDINATE WITH SPRINKLER SYSTEM MODIFICATION. VERIFY LOCATION OF ALARM & NOTIFICATION PANELS WITH THE AUTHORITY HAVING JURSDICTION.

PARTITION TYPES

TAB	DETAIL
1	AB.1
2	AB.2
3	AB.3
4	AB.4
5	AB.5
6	AB.6
7	AB.7


SIGNAGE TYPES

TAB	DETAIL
1	AS.1
2	AS.2
3	AS.3
4	AS.4
5	AS.5
6	AS.6
7	AS.7

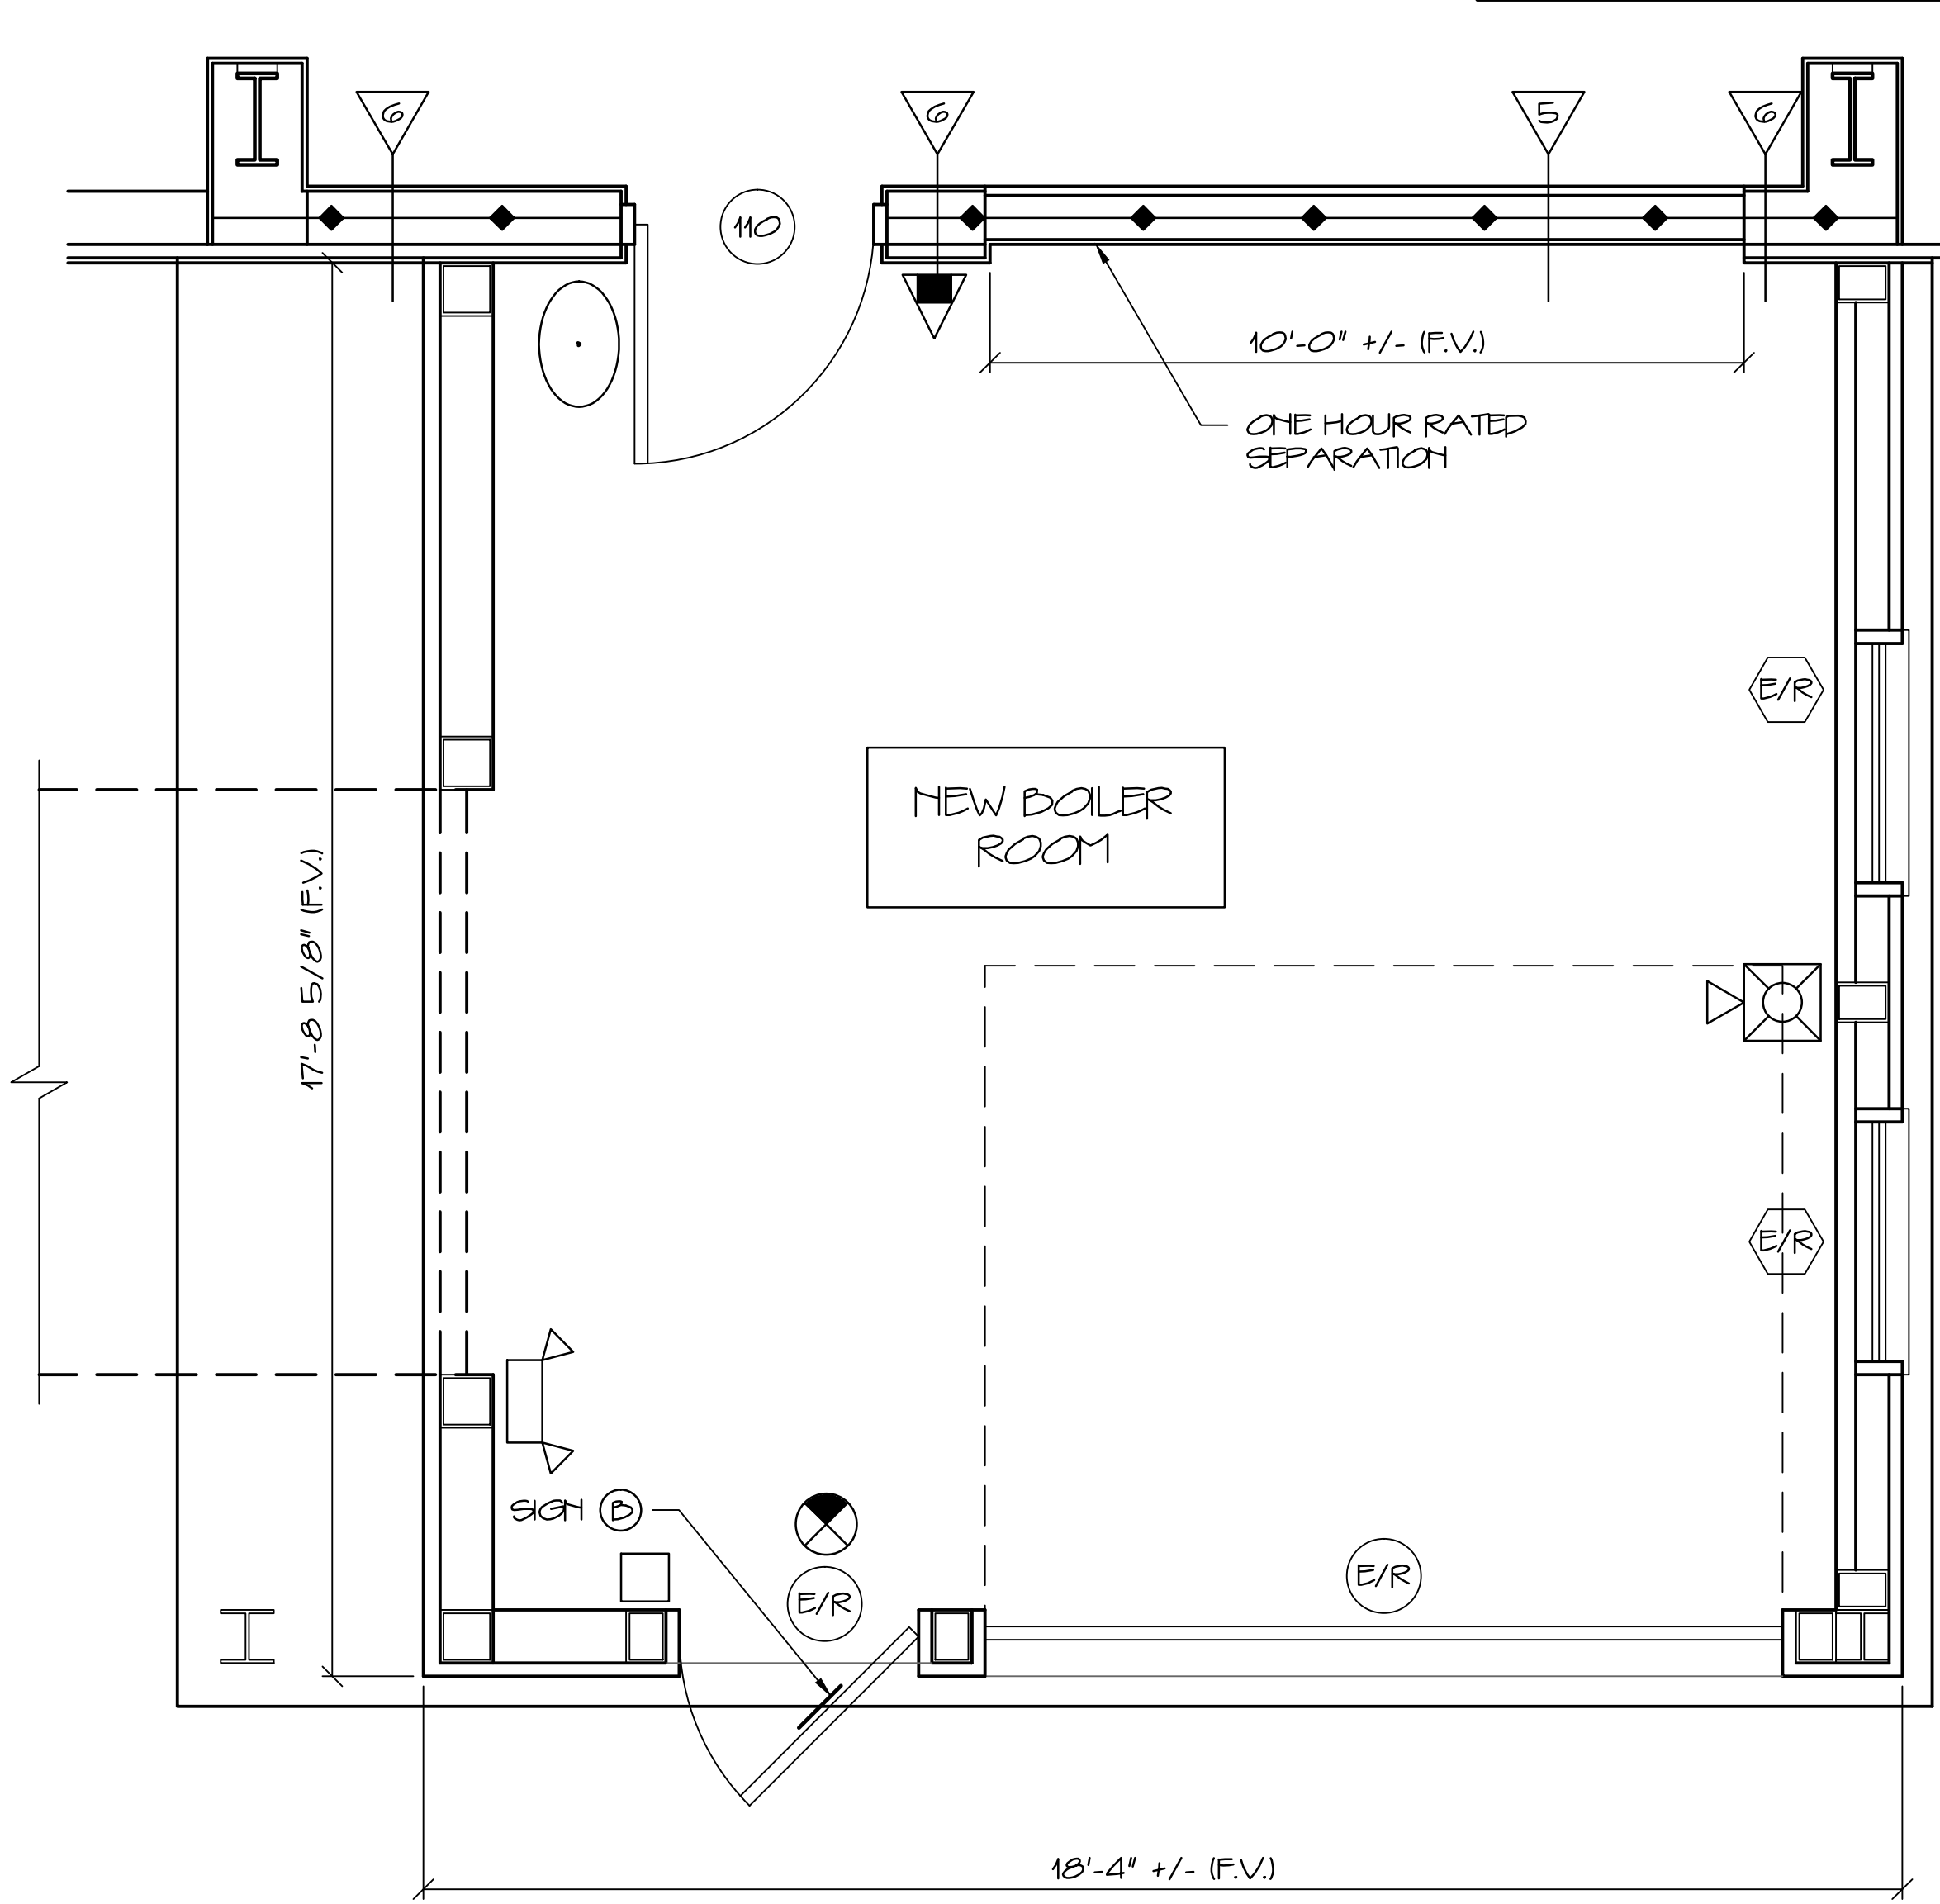


LIFE SAFETY SYMBOLS

(Symbol)	EXT LIGHT
(Symbol)	FIRE EXTINGUISHER
(Symbol)	FIRE ALARM FULL MANUAL PULL STATION
(Symbol)	FIRE ALARM PANEL
(Symbol)	EMERGENCY LIGHT
(Symbol)	FIRE ALARM HORV/STROBE UNIT
(Symbol)	FIRE ALARM STROBE UNIT
(Symbol)	SMOKE DETECTOR
(Symbol)	SMOKE DETECTOR W/ AUDIBLE ALARM
(Symbol)	*NOT AN EXIT SIGN
(Symbol)	KNOX BOX
(Symbol)	1 HR RATED PARTITION
(Symbol)	2 HR RATED PARTITION

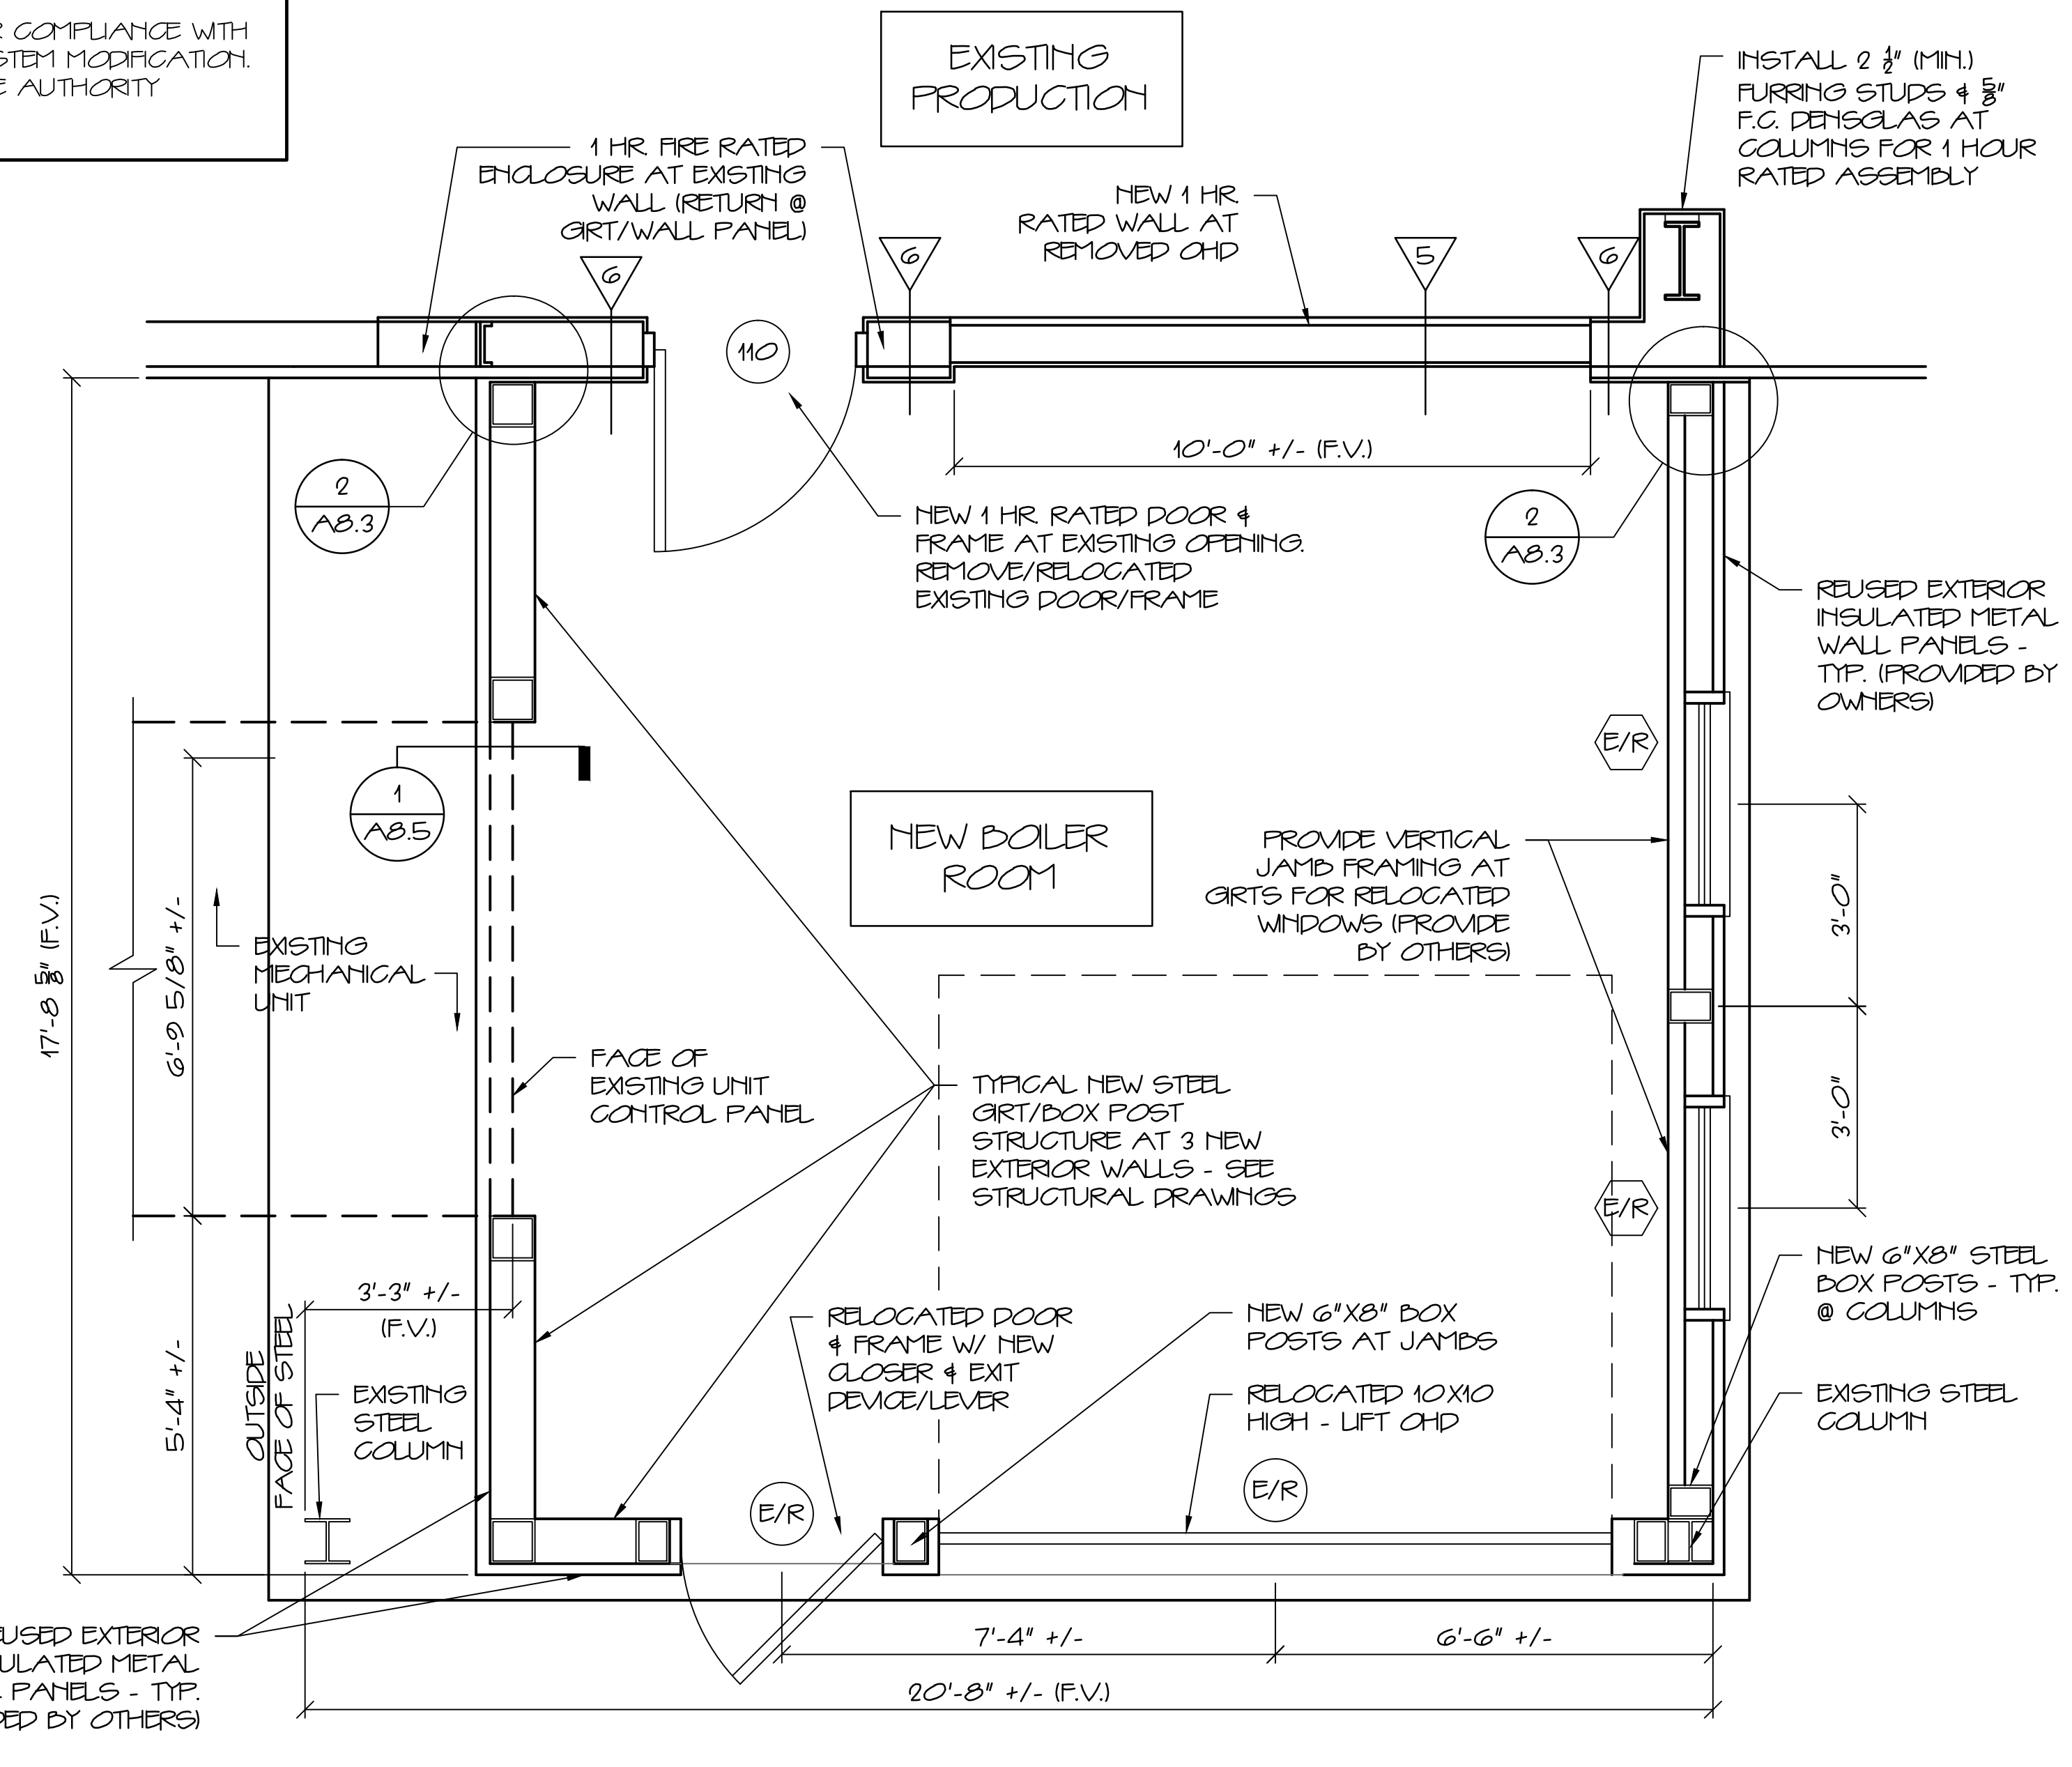

CODE COMPLIANCE FLOOR PLAN
1/2" = 1'-0"

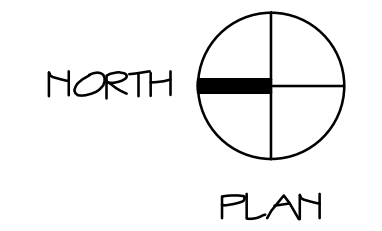

FLOOR PLAN
1/2" = 1'-0"

ARCHITECTURE INTERIOR DESIGN
 P.O. BOX 6179 FALMOUTH, MAINE 04105
 (207) 871-5900
 (207) 871-9306

NEW ADDITION FOR
 ALLAGASH BREWING CO.
 50 INDUSTRIAL WAY PORTLAND, MAINE

HAY S O C I A S S O C I A T I O N

REVISIONS

DRAWING NO. A8.3

SCALE AS NOTED
 DATE 29 MAR 13
 DRAWN BY SAM/MPH
 JOB NO. 120701