

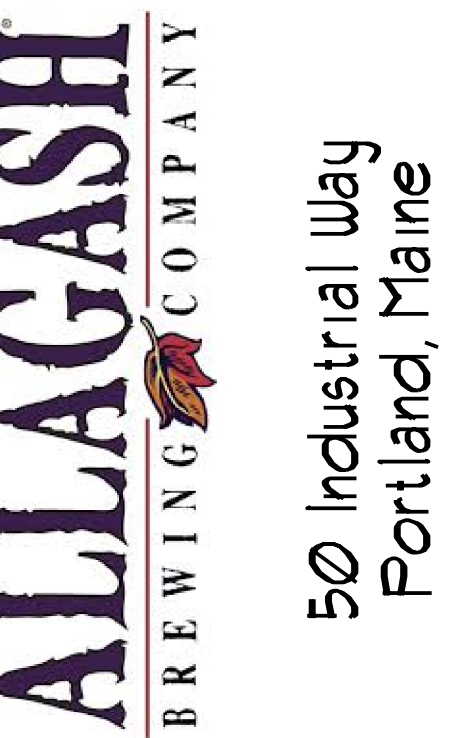


PARTIAL PLAN
SCALE: 1/4"=1'-0"

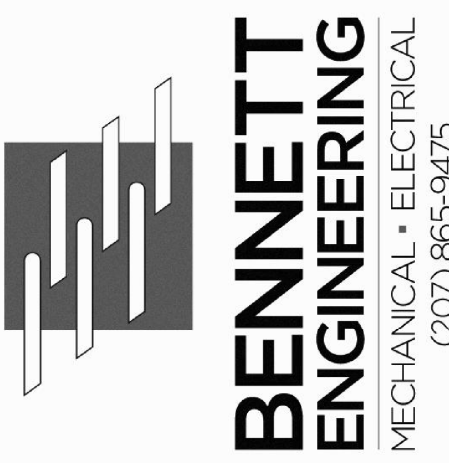

FIRST FLOOR LIGHTING PLAN
SCALE: 1/8"=1'-0"

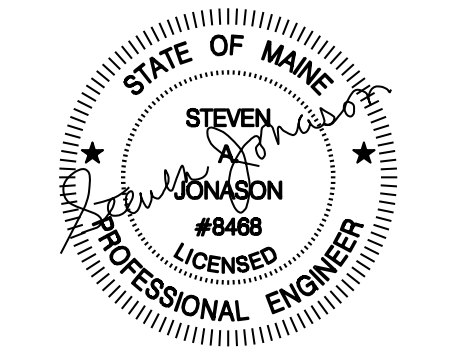

ALLAGASH BREWING CO.
BOTTLING AREA ADDITION

Portland, Maine

FIRST FLOOR LIGHTING PLAN

Date Drawn - 7/7/14

Drawn By -

Revised -
PERMIT 07/25/14

Project # 3588

Scale - AS NOTED

Sheet Number - E1.0