
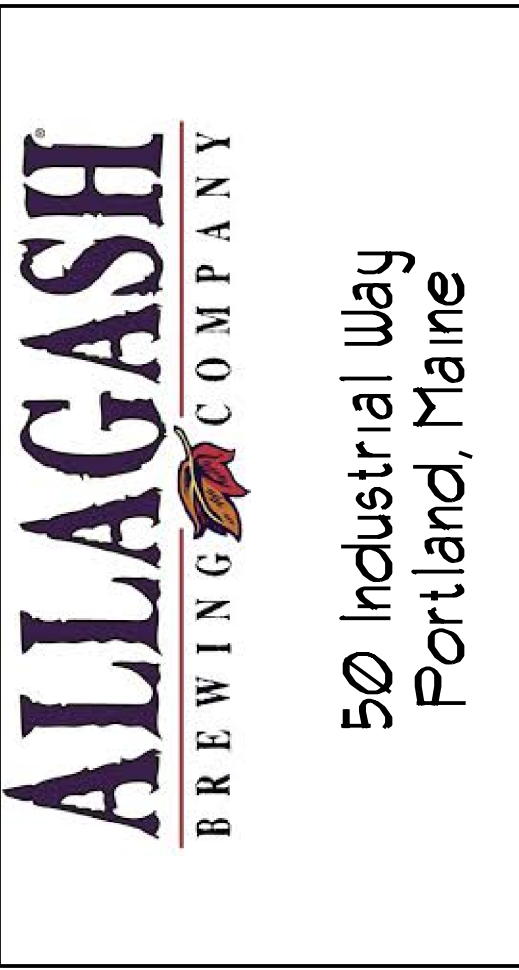
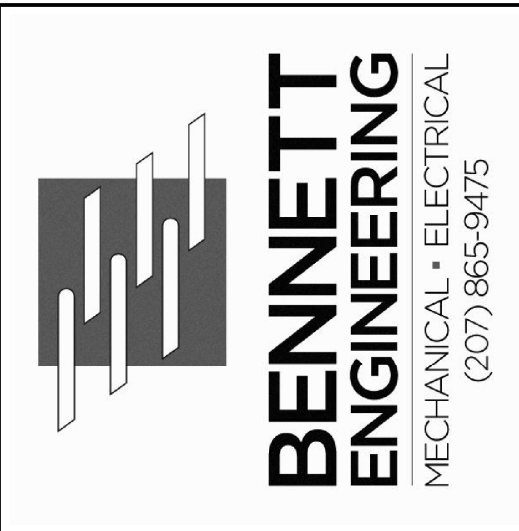


FIRST FLOOR PLAN
SCALE 1/8" = 1'-0"

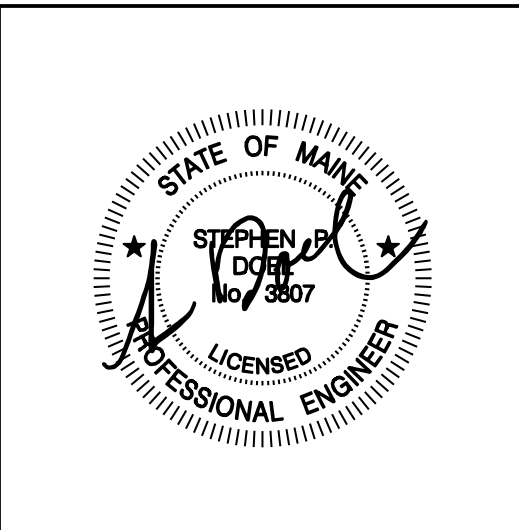

ALLAGASH BREWING CO.
BOTTLING AREA ADDITION
Portland, Maine
FIRST FLOOR MECHANICAL PLAN

Date Drawn - 7/7/14

Drawn By - SPD

Revised - PERMIT 07/25/14

Project # 3588

Scale - AS NOTED

Sheet Number - M1