

TA-1

water and replace with the new water heater. Connect to existing piping:




93'-6"

8'-0" HIGH

EXISTING 100 INDUSTRIAL ROOF



SECOND FLOOR PLAN
SCALE 1/8" = 1'-0"

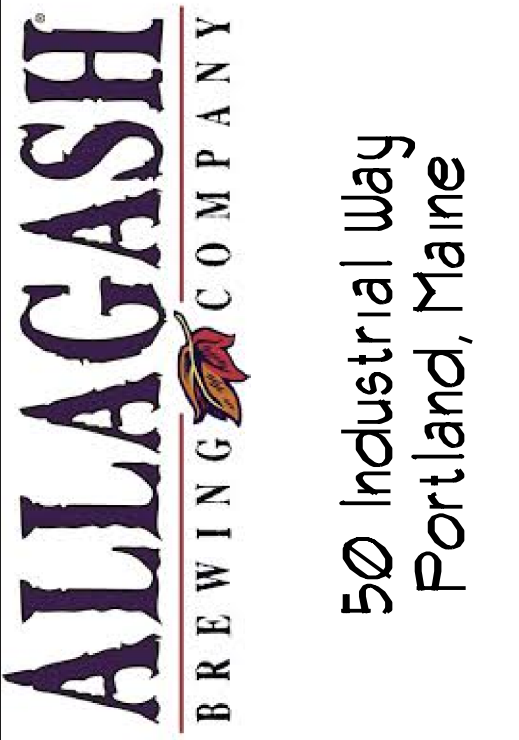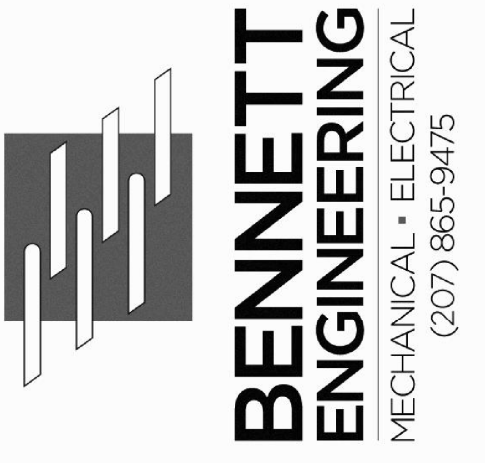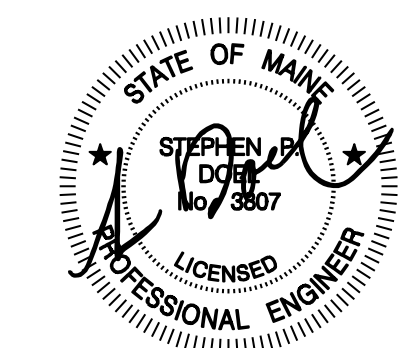

ALLAGASH BREWING CO.
BOTTLING AREA ADDITION

Portland, Maine

SECOND FLOOR PLUMBING PLAN

Date Drawn - 7/7/14

Drawn By - ---

Revised -
PERMIT 07/25/14

Project # 3588

Scale - AS NOTED

Sheet Number - P2