







Reviewed for Code Compliance  
Inspection Division  
Approved with Conditions  
Date: 09/15/14

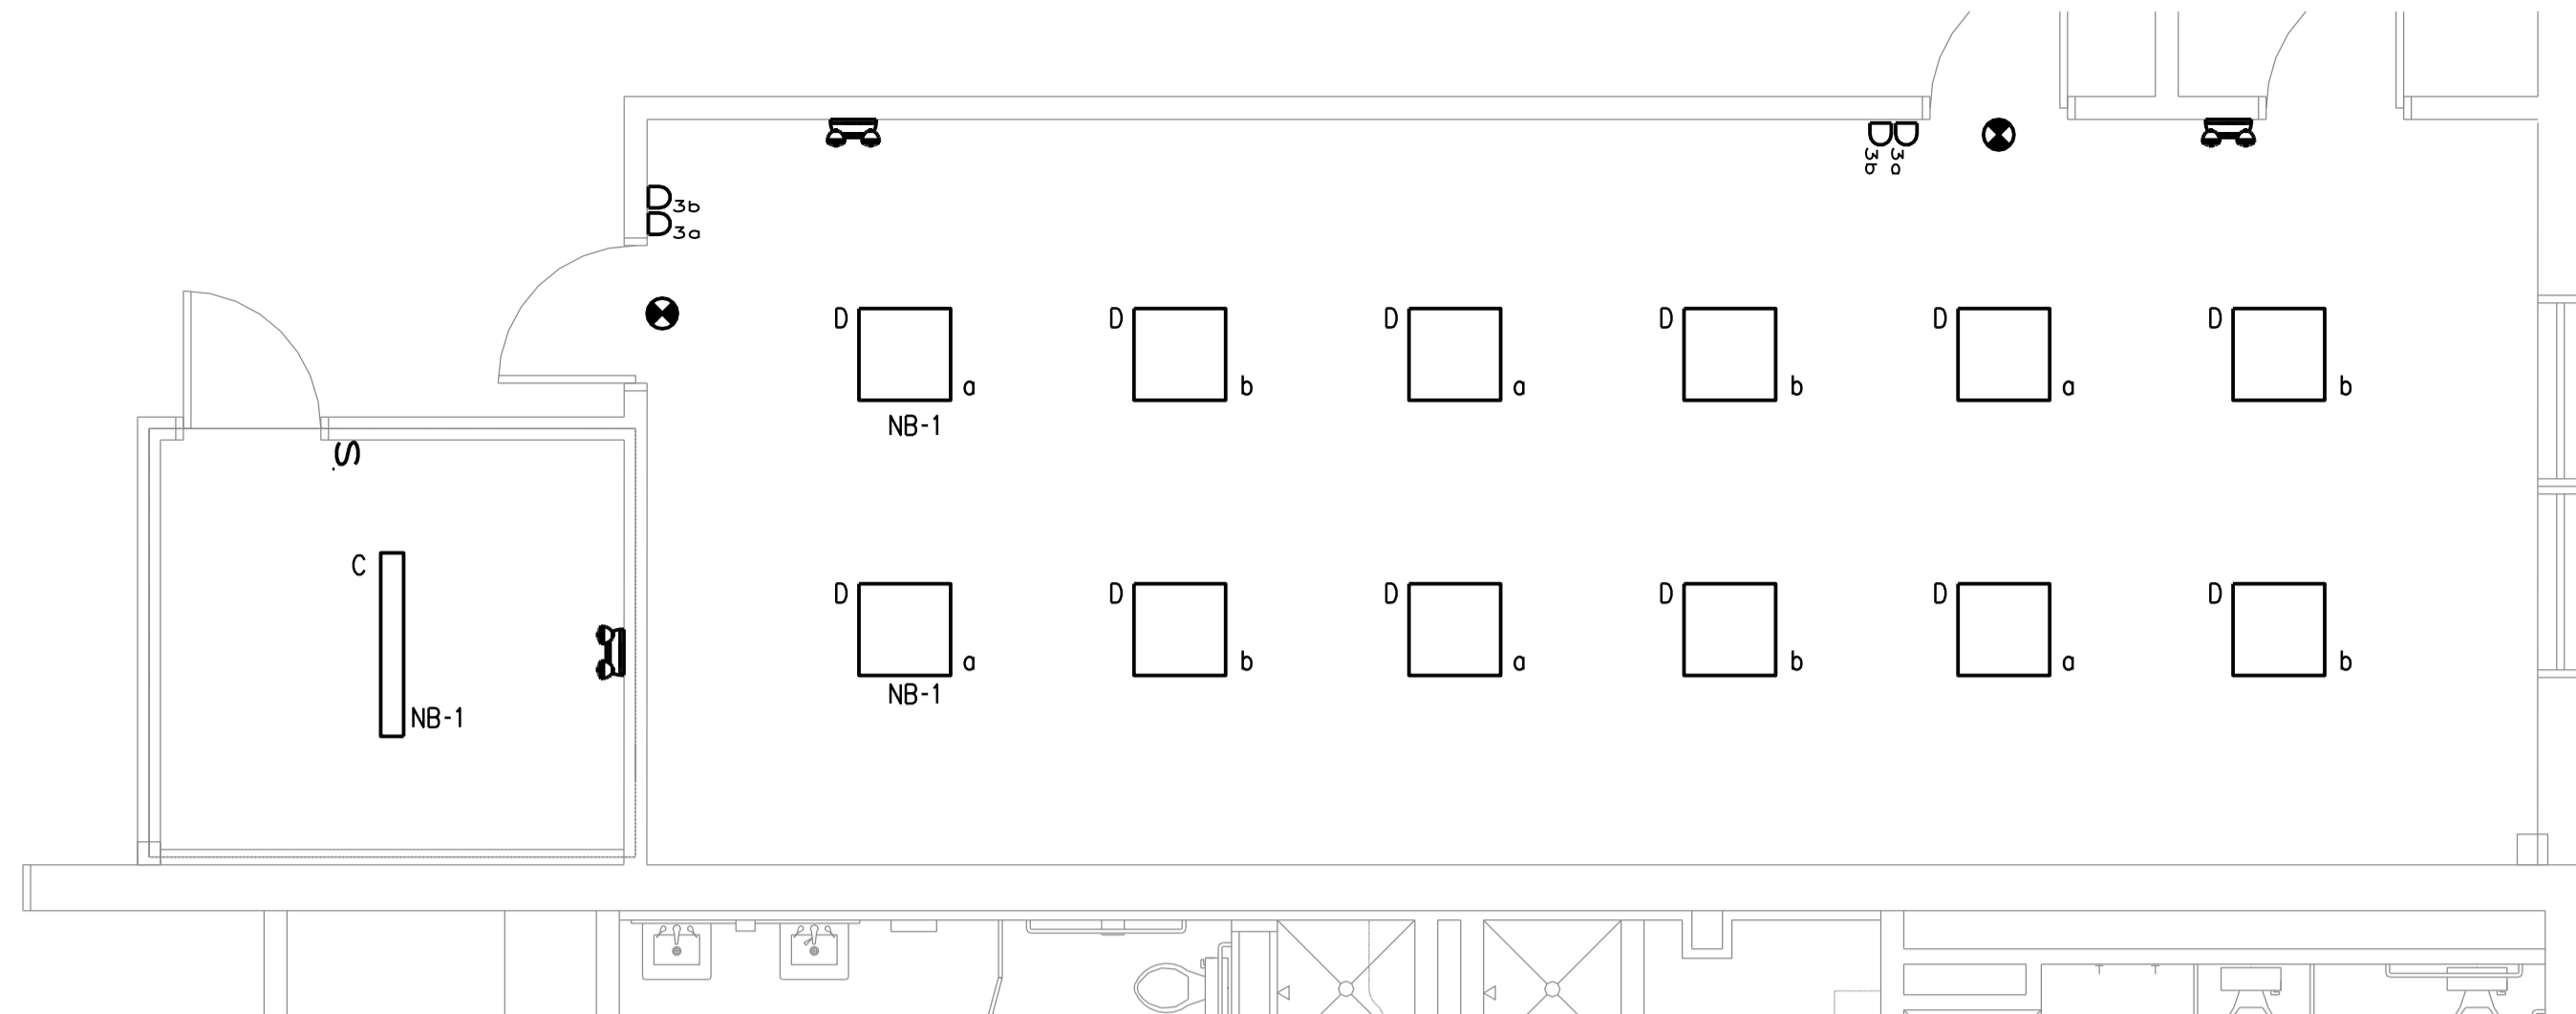

**PARTIAL PLAN**  
SCALE: 1/4"=1'-0"

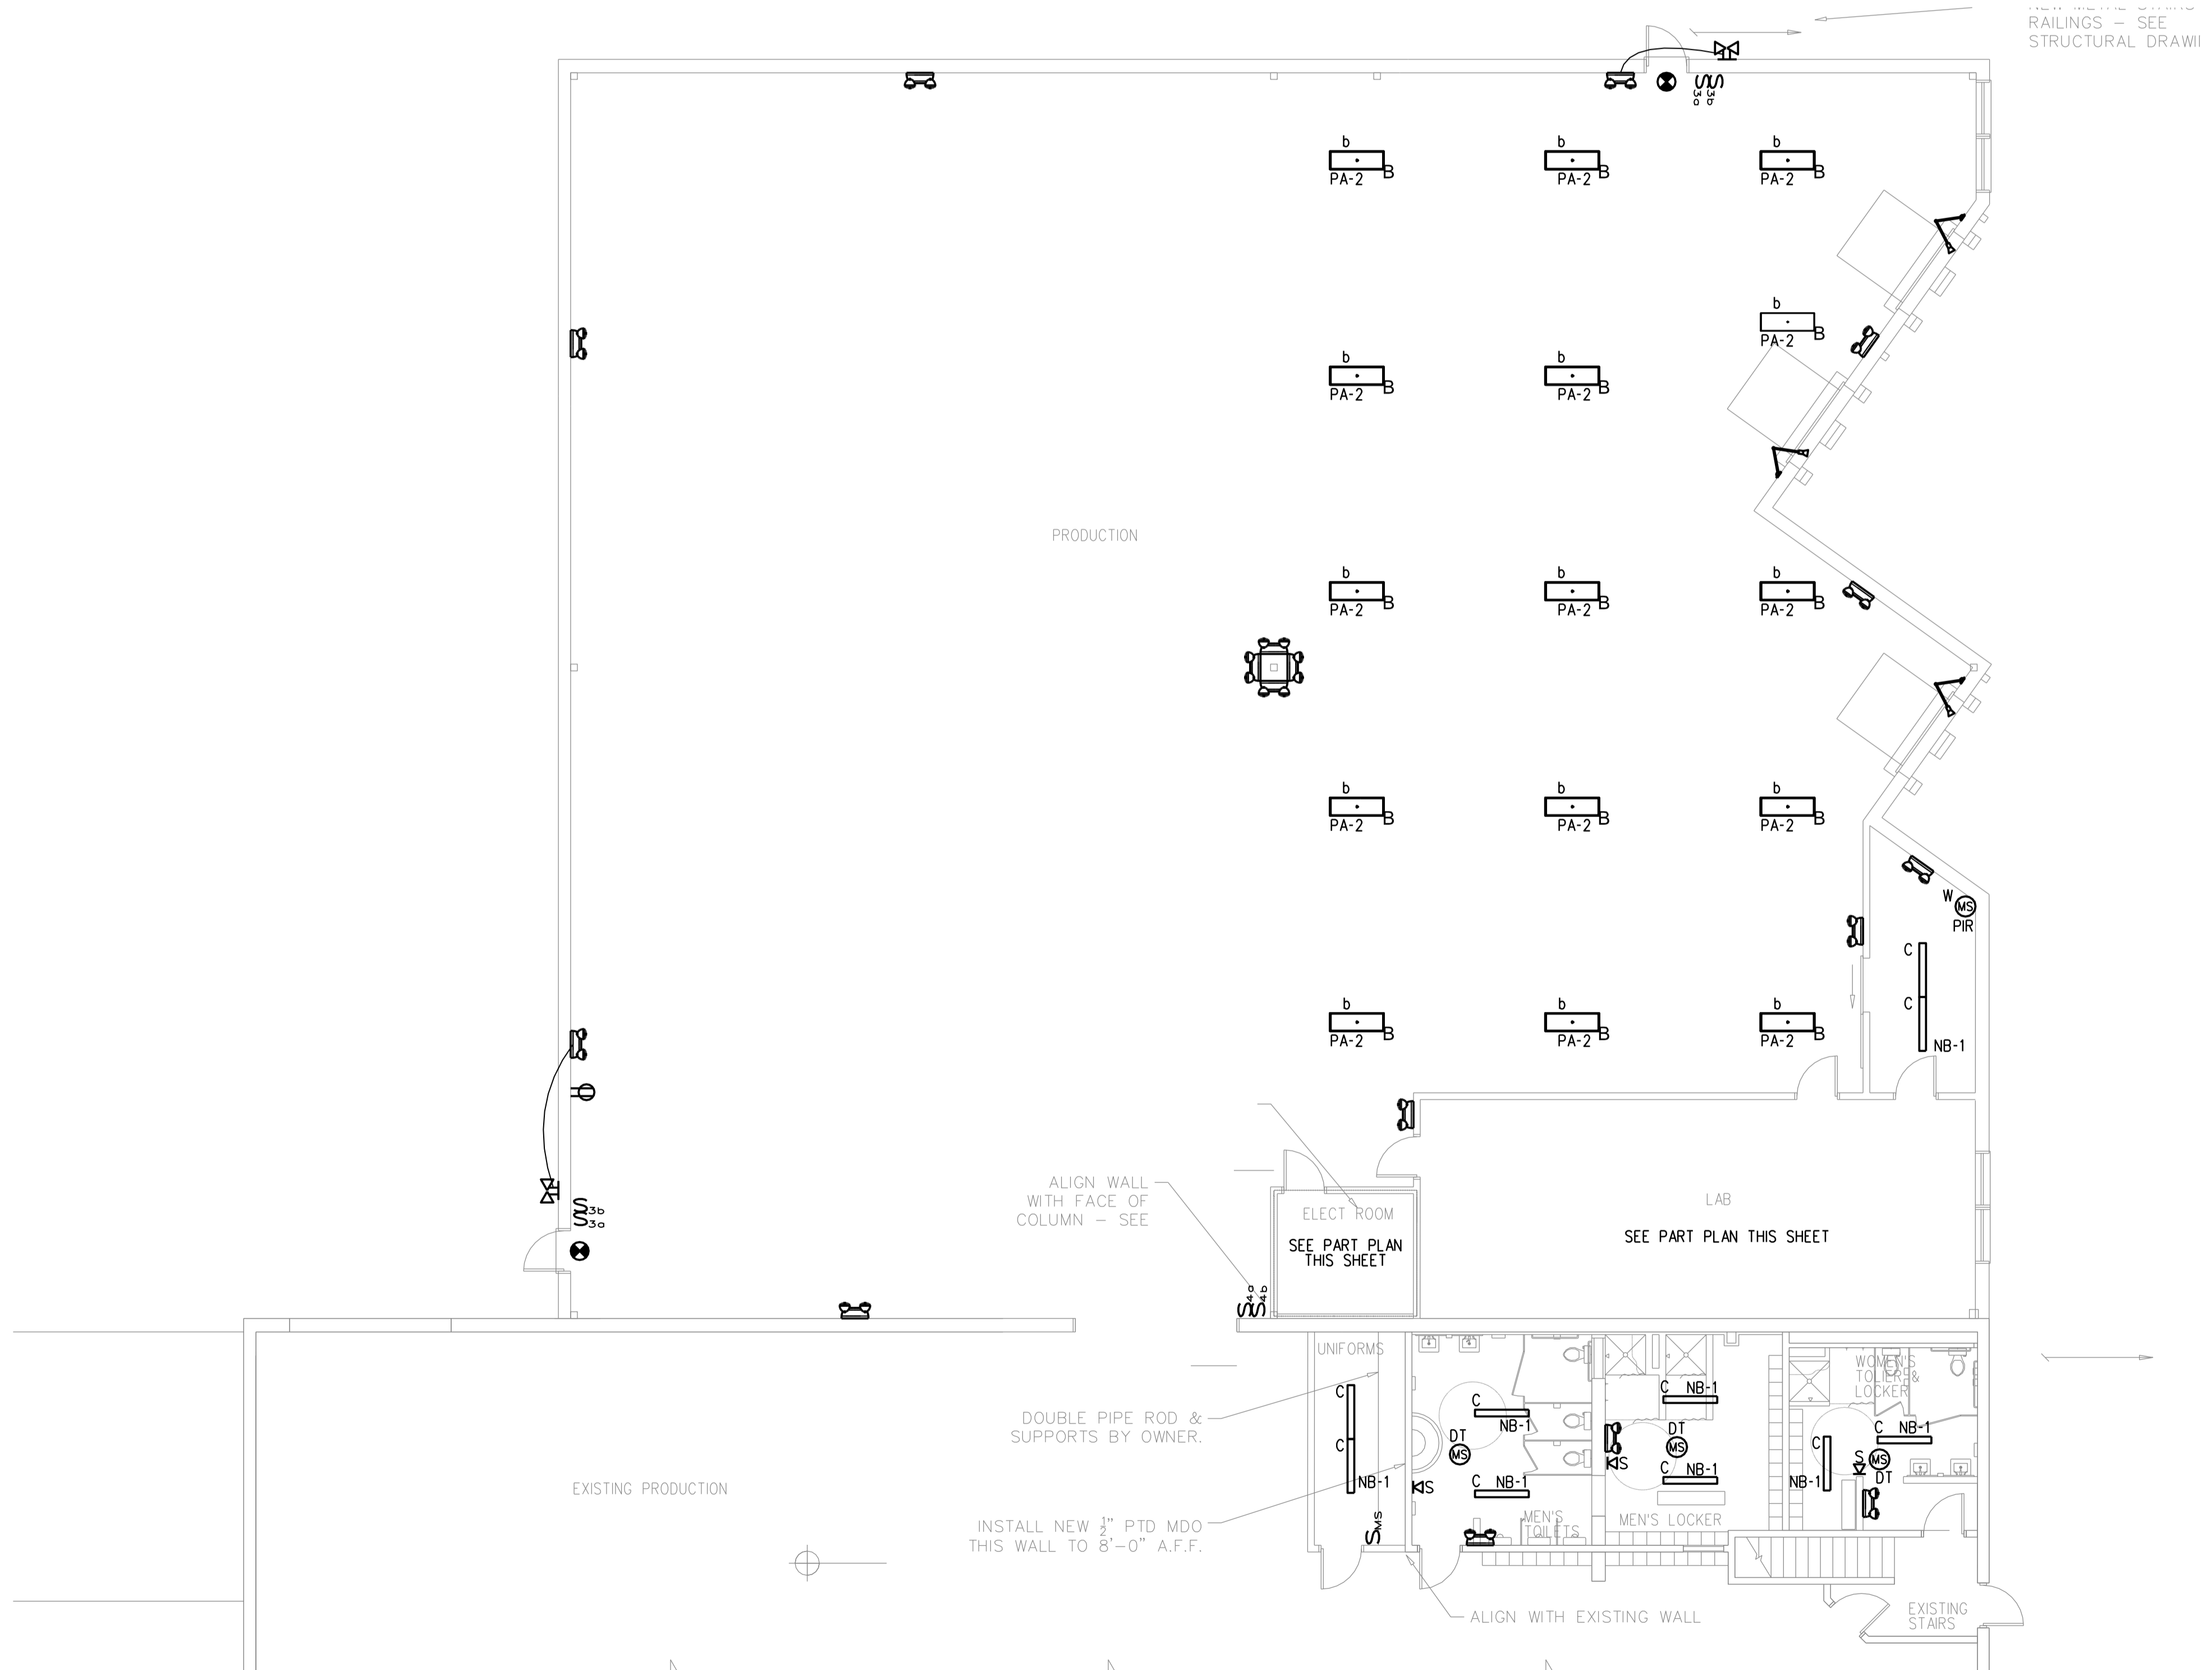

**FIRST FLOOR LIGHTING PLAN**  
SCALE: 1/8"=1'-0"

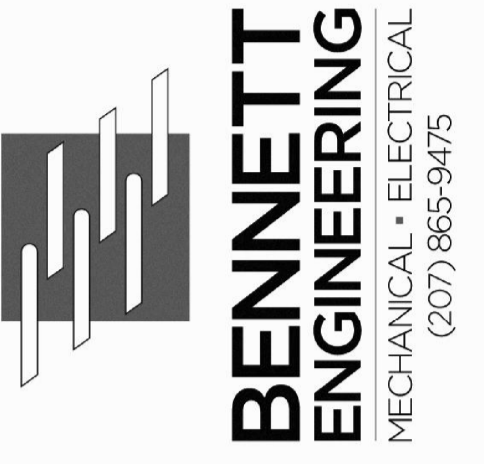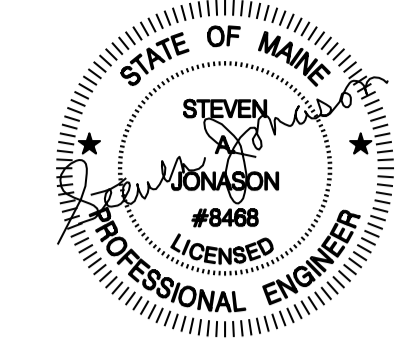

**ALLAGASH**  
BREWING COMPANY  
50 Industrial Way  
Portland, Maine

**ALLAGASH BREWING CO.**  
**BOTTLING AREA ADDITION**  
Portland, Maine  
FIRST FLOOR LIGHTING PLAN

Date Drawn - 7/7/14

Drawn By -

Revised -  
PERMIT 07/25/14

Project # 3588

Scale - AS NOTED

Sheet Number - E1.0